



1/9/2024 10:24:02 AM
Autodesk Docs/725633.XM Huffman-Allen MOB R22/25619.DB Huffman-Allen MOB Tenant A.rvt
THIS LINE IS INDICATED WHEN PRINTED TO FULL SCALE

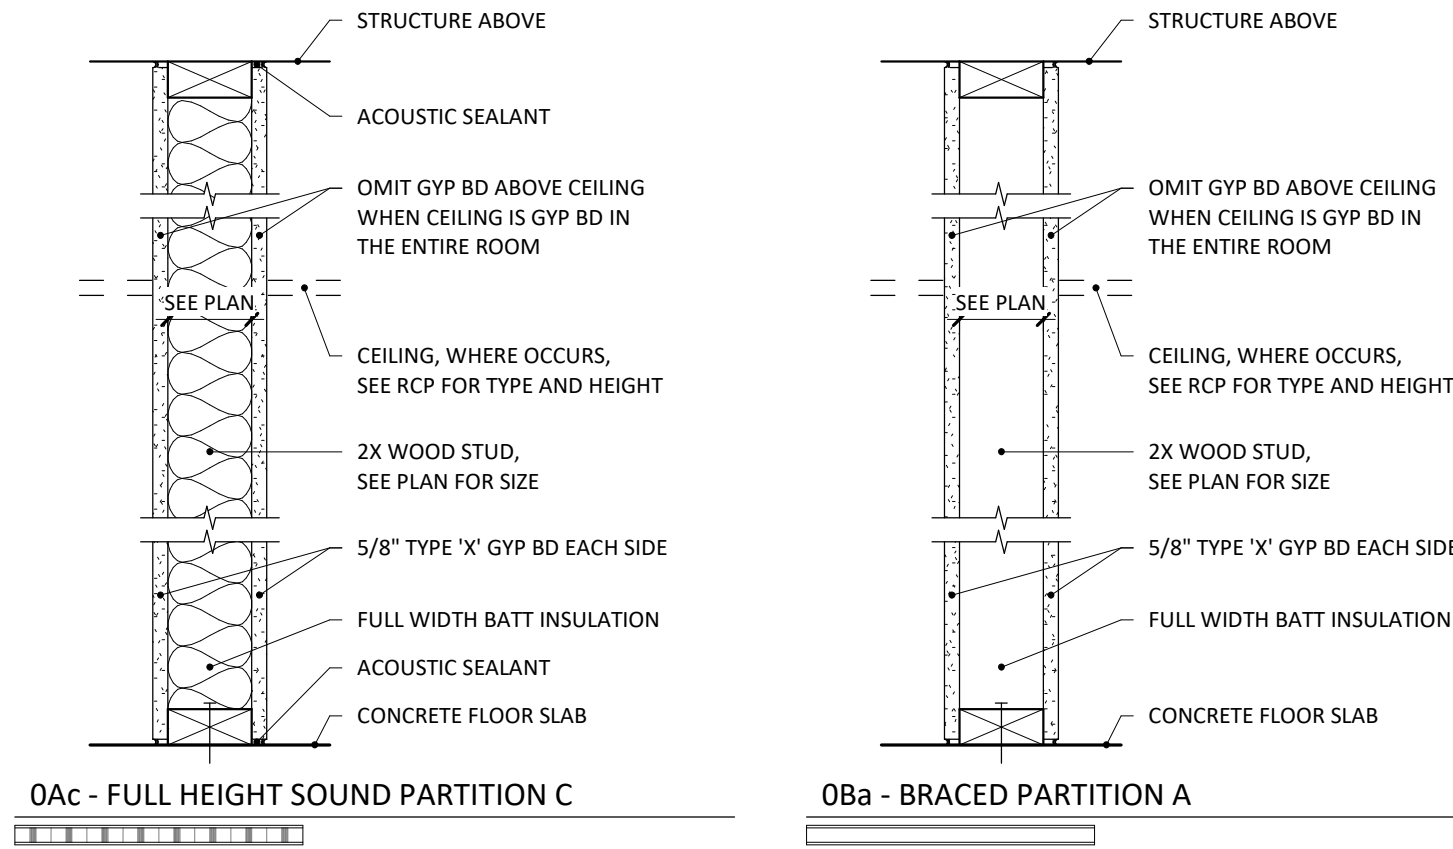

1 FLOOR 1 OVERALL

A2.10 3/16" = 1'-0"

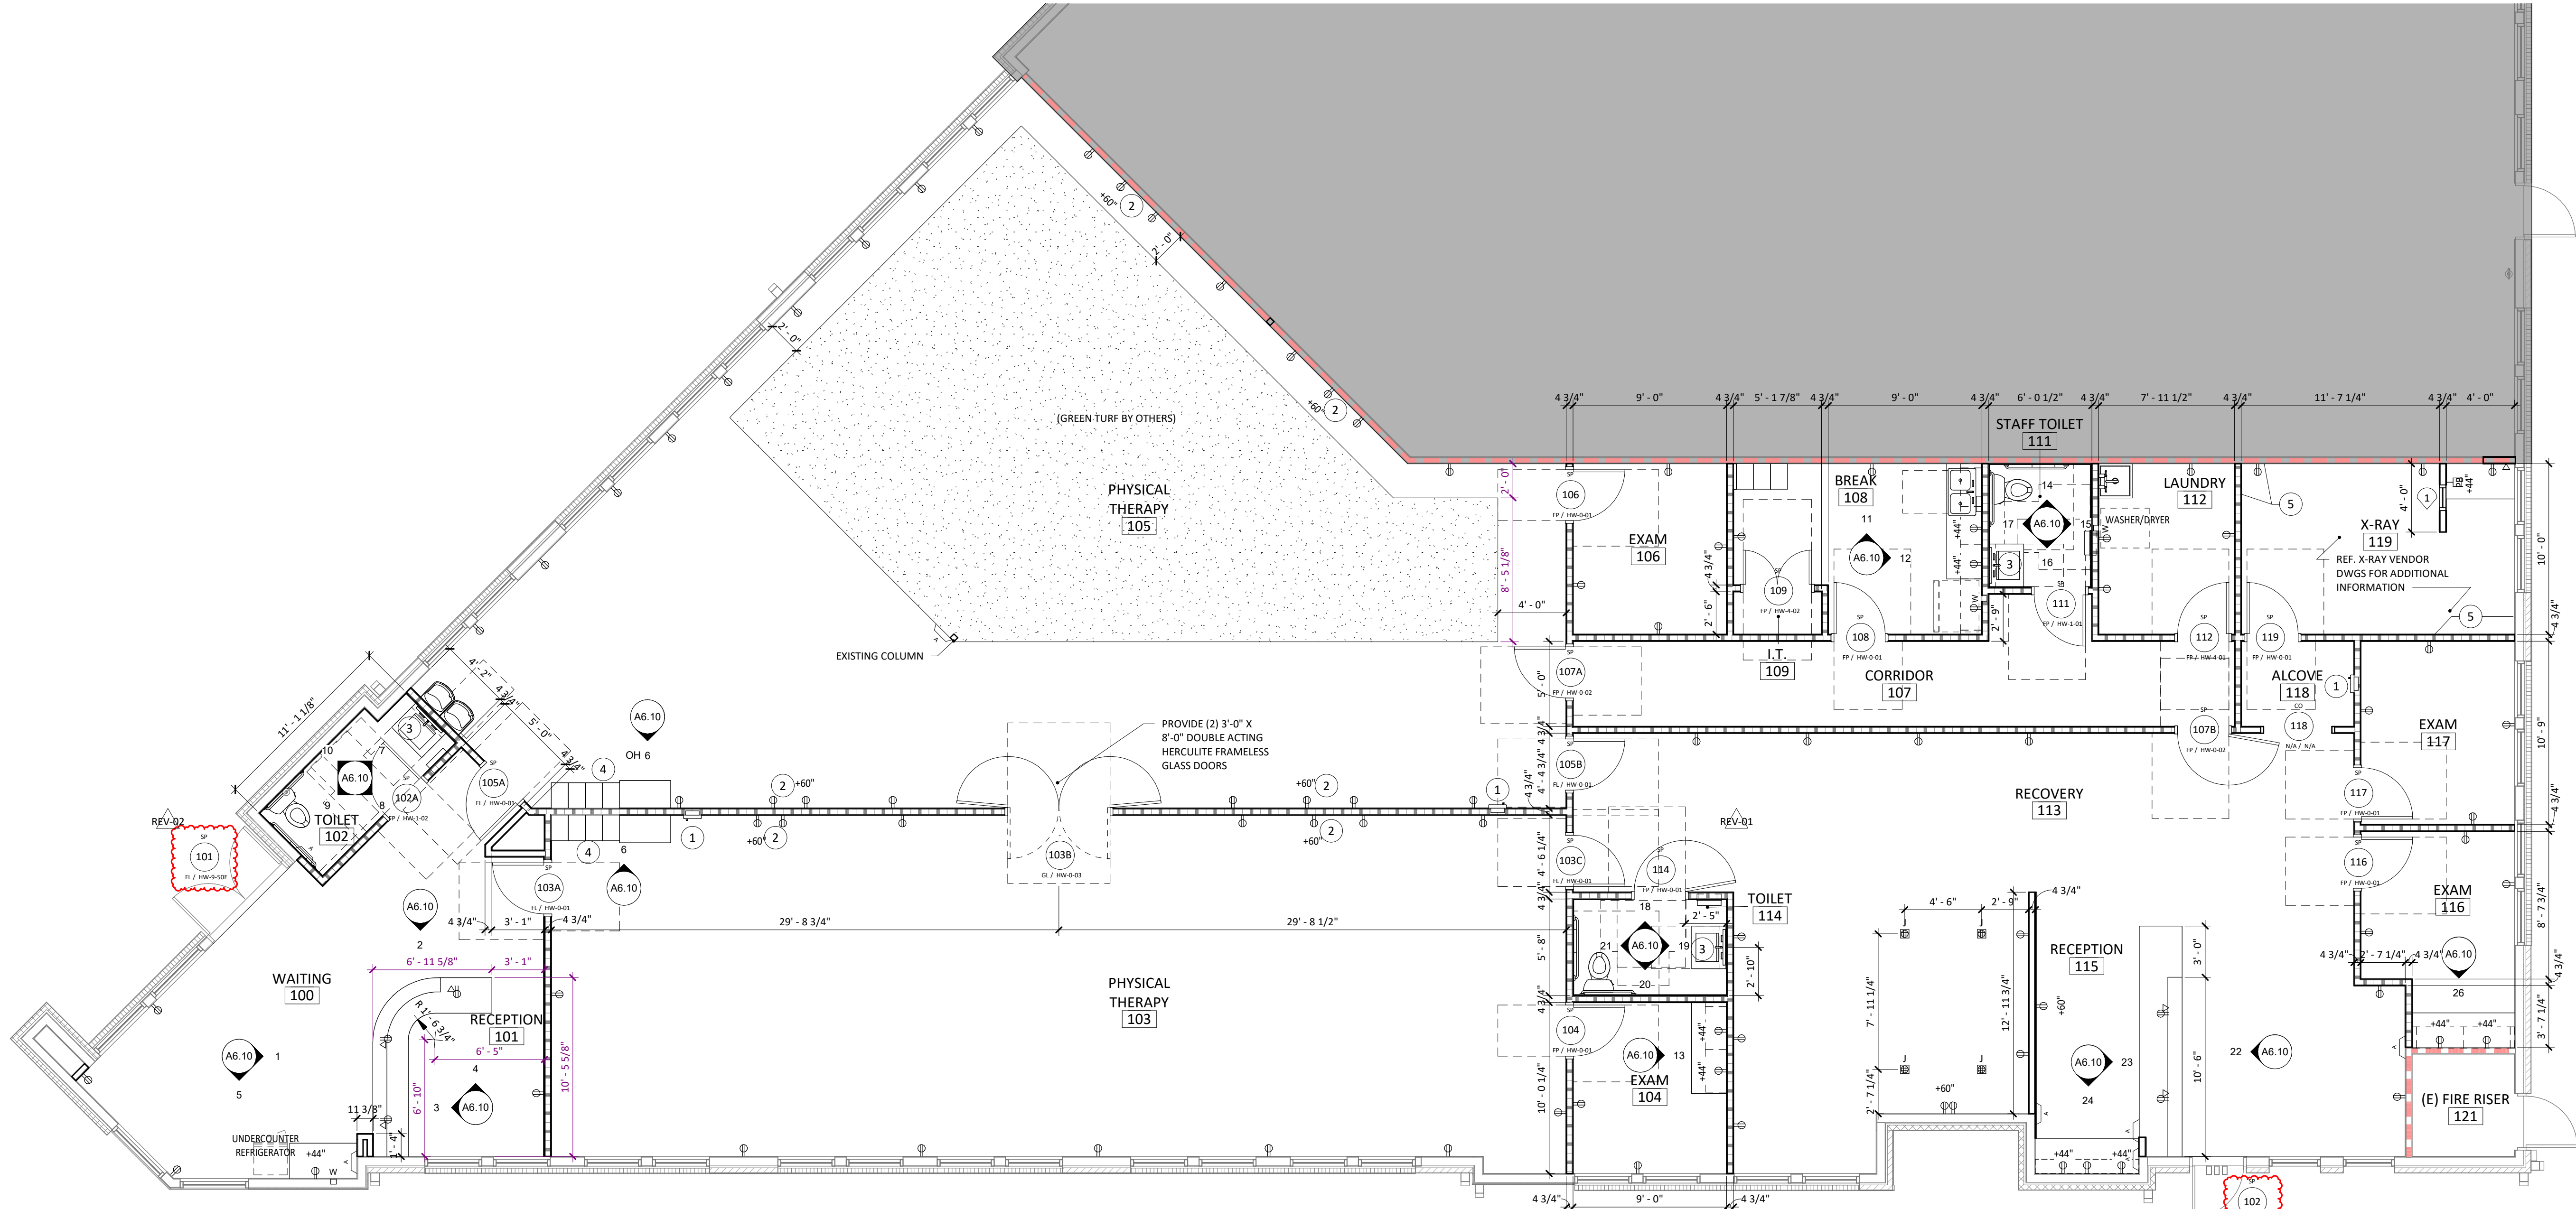

2 PARTITION TYPES

A2.10 1 1/2" = 1'-0"

NOTE: PROVIDE JOINT FIRESTOPPING AND/OR PENETRATION FIRESTOPPING IN EXISTING RATED WALLS TO COMPLY WITH IBC-21 SECTION 714. SUBMIT ALL DETAILS UL 753 & UL 1479 FOR APPROVAL.

REV-02

POWER OUTLET LEGEND

SYMBOLS	
	DUPLEX OUTLET
	QUAD OUTLET
DESIGNATIONS	
+##"	INDICATES HEIGHT IN INCHES AFF TO OUTLET CENTERLINE. DEFAULT HEIGHT = 18" AFF UNLESS TAGGED OTHERWISE. TYPICAL FOR ALL OUTLETS
R	RECESSED OUTLET (TYPE PER SYMBOL OR OTHER DESIGNATION)
D	DEDICATED OUTLET
220V	220 VOLT OUTLET
GFI	OUTLET W/ GROUND FAULT CIRCUIT INTERRUPT PROTECTION
EM	EMERGENCY OUTLET

DATA OUTLET LEGEND

SYMBOLS	
	DATA OUTLET
	PHONE OUTLET
	DATA/PHONE OUTLET
DESIGNATIONS	
R	RECESSED OUTLET (TYPE PER SYMBOL)

SPECIAL PURPOSE OUTLET LEGEND

SYMBOLS	
	SPECIAL PURPOSE OUTLET
DESIGNATIONS	
R	RECESSED OUTLET (TYPE PER OTHER DESIGNATION)
TV	TV OUTLET
CR	CARD READER
DO	DOOR OPENER BUTTON
DR	DOOR RELEASE BUTTON
KP	KEYPAD
I	INTERCOM
SC	SECURITY CAMERA

JUNCTION OUTLET LEGEND

SYMBOLS	
	JUNCTION BOX OUTLET
	JUNCTION FLOOR OUTLET
DESIGNATIONS	
J ^P	JUNCTION BOX OUTLET FOR POWER
J ^W	JUNCTION BOX OUTLET FOR FURNITURE WHIPS
J ^C	JUNCTION BOX OUTLET FOR COMMUNICATION/DATA

MISCELLANEOUS ELECTRICAL LEGEND

MHO	MAGNETIC HOLD OPEN
	LIGHT SWITCH
	FIRE ALARM STROBE
EP	ELECTRICAL PANEL
GP	GENERATOR ALARM PANEL
FACP	FIRE ALARM CONTROL PANEL
FAAP	FIRE ALARM ANNUNCIATOR PANEL

FLOOR PLAN GENERAL NOTES

- DIMENSIONS ARE TO FACE OF STUDS, FACE OF EXTERIOR STUDS, STRUCTURAL GRIDS AND CENTERLINES WHERE INDICATED.
 - ADD GYPSUM WALLBOARD TO INSIDE FACE OF ALL EXTERIOR WALLS. EXTERIOR WALLS TO HAVE MINIMUM CAVITY R VALUE OF 19.
- #### FLOOR PLAN KEYNOTES
- PROVIDE RECESS MOUNTED FIRE EXTINGUISHER CABINET (LARSEND 2409-R1).
 - PROVIDE WOOD BLOCKING AT ALL TV LOCATIONS. COORDINATE FINAL LOCATION WITH OWNER.
 - PROVIDE POWER AT LIGHTED MIRROR LOCATIONS.
 - COORDINATE LOCKING AND KEYING W/ OWNER
 - PROVIDE 1/32 INCH LEAD SHEET TO 7 FEET IN HEIGHT, REF. PHYSICIST REPORT

NEW PARTITION GRAPHICS LEGEND

GRAPHIC	DESCRIPTION	TYPE	DETAIL	PRIORITY
	1 HOUR FIRE BARRIER	1Aa	1/A7.11	HIGH
	SOUND PARTITION	OAc	1/A7.11	
	BRACED PARTITION	OBa	1/A7.11	
	FURRING PARTITION	OFa	1/A7.11	LOW

EXISTING PARTITION GRAPHICS LEGEND

GRAPHIC	DESCRIPTION	TYPE	DETAIL	PRIORITY
	1 HOUR FIRE BARRIER			HIGH
	SOUND PARTITION			
	BRACED PARTITION			
	FURRING PARTITION			LOW

REV-02

- PER 2021 IBC SEC. 1607.16, INTERIOR WALLS AND PARTITIONS THAT EXCEED 6 FT IN HEIGHT, INCLUDING THEIR FINISH MATERIALS, SHALL HAVE ADEQUATE STRENGTH AND STIFFNESS TO RESIST THE LOADS TO WHICH THEY ARE SUBJECTED BUT NOT LESS THAN A HORIZONTAL LOAD OF 100 LBS.
- HIGHEST PRIORITY PARTITIONS ARE LISTED FIRST IN THE LEGEND. SUBSEQUENT PARTITIONS DECREASE IN PRIORITY. HIGHER PRIORITY WALLS TAKES PRECEDENCE, SEE WALL PRIORITY DETAILS.



BOULDER ASSOCIATES

5646 MILTON STREET, SUITE 240
DALLAS, TEXAS 75206
214.420.5700

PROJECT 235819.00

ALLEN MOB - TENANT A

504 NORTH WATTERS
SUITE 100
ALLEN, TEXAS 75013

CONSTRUCTION DOCUMENTS

DATE 2024.01.09

REVISIONS

#	DESCRIPTION	DATE
REV-01	Revision 1 - TAS and Lighting Updates	2023.12.20
REV-02	Revision 2 - City Comments	2024.01.09



2024.01.09

SHEET TITLE

FLOOR PLAN

SHEET NUMBER

A2.10