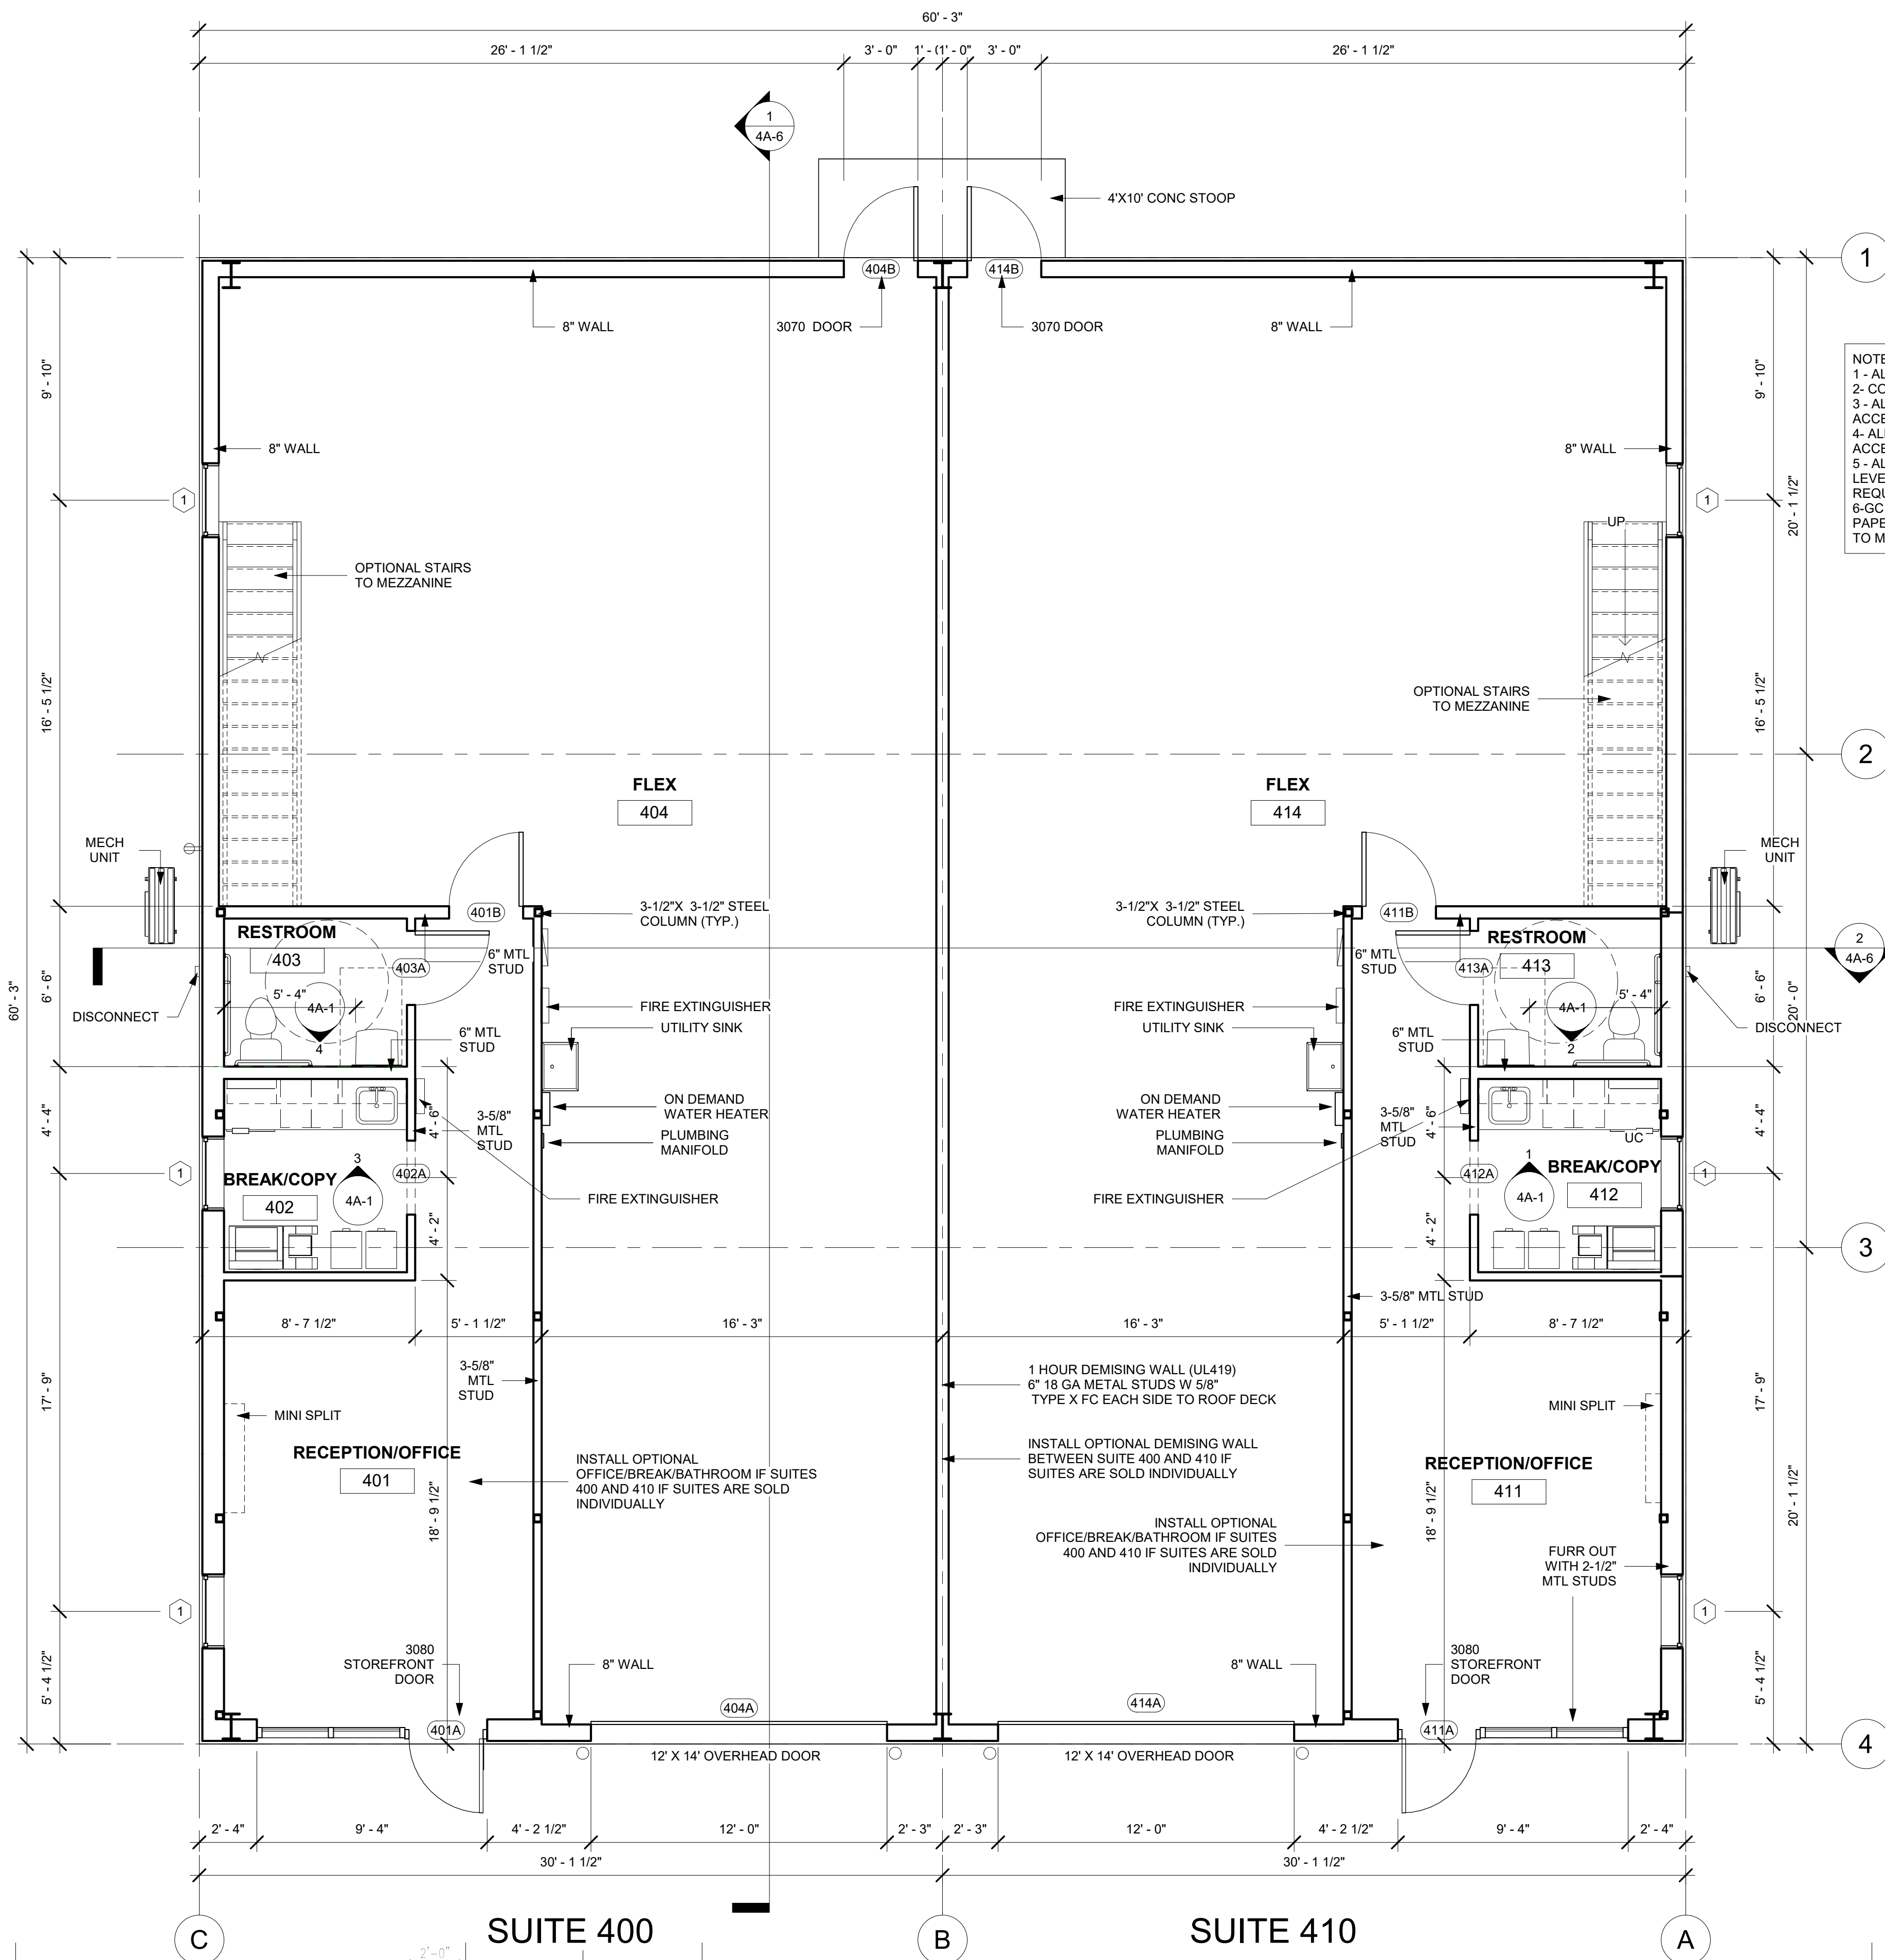
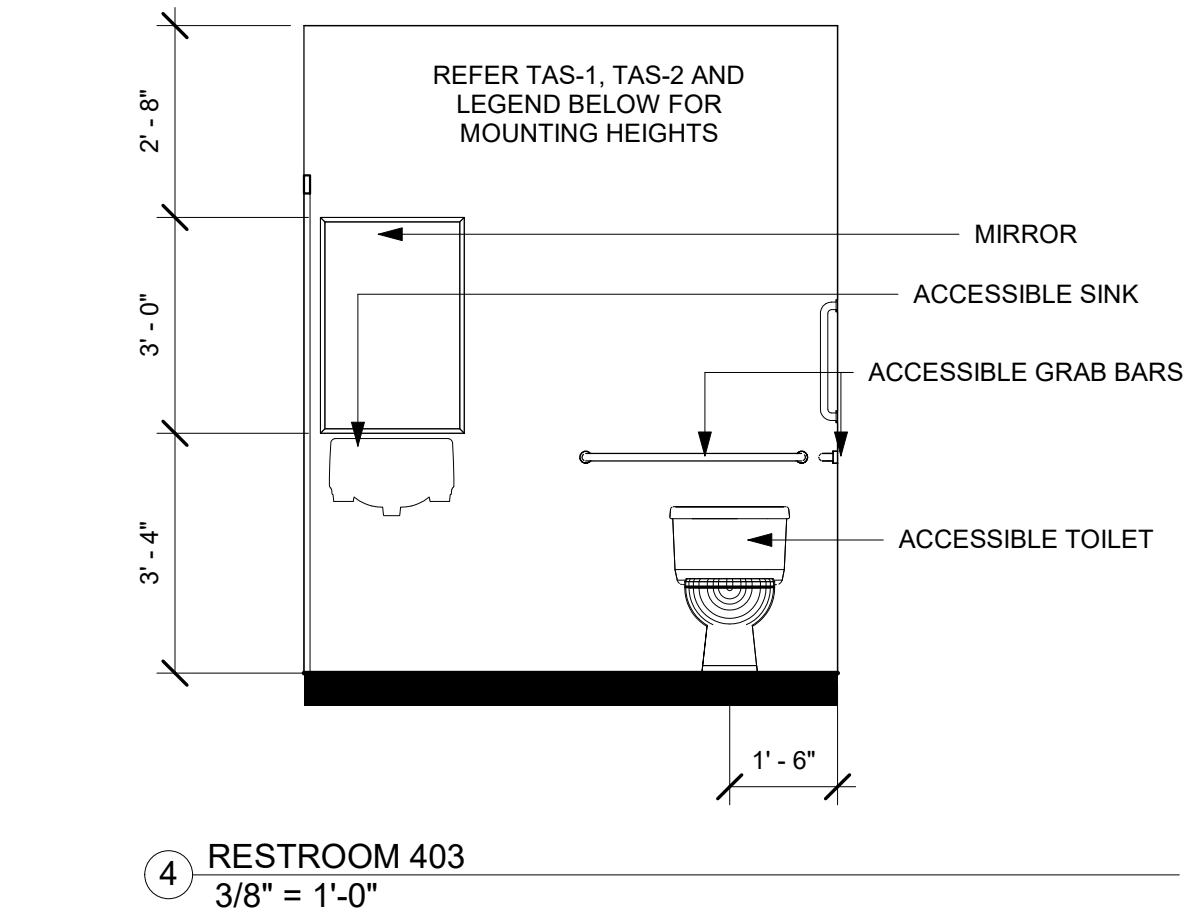


FIXTURE MOUNTING HEIGHTS FOR THE DISABLED (ADA)

NOTE:
1- ALL INTERIOR DOORS TO BE 36"x84"
2- CONSTRUCTION TYPE IIB (2015 IBC)
3- ALL DOOR HARDWARE TO BE ACCESSIBLE COMPLIANT.
4- ALL PLUMBING FIXTURES TO BE ACCESSIBLE COMPLIANT
5- ALL DOOR DOORS TO FITTED WITH LEVER HANDLES THAT MEET ACCESSIBILITY REQUIREMENTS.
6-GC TO INSTALL SOAP DISPENSER AND PAPER TOWEL DISPENSER IN RESTROOM TO MEET ADA REQUIREMENTS

[illegible]

WORKSPACE USA

PHASE 2

BUILDING 4

FLOOR PLAN

Project number	2023-04
Date	08-08-2023
Drawn by	EB
Checked by	JS

4A-1

Scale	As indicated
-------	--------------