


Kitchen exhaust to be omitted under this application and to be filed under separated application.

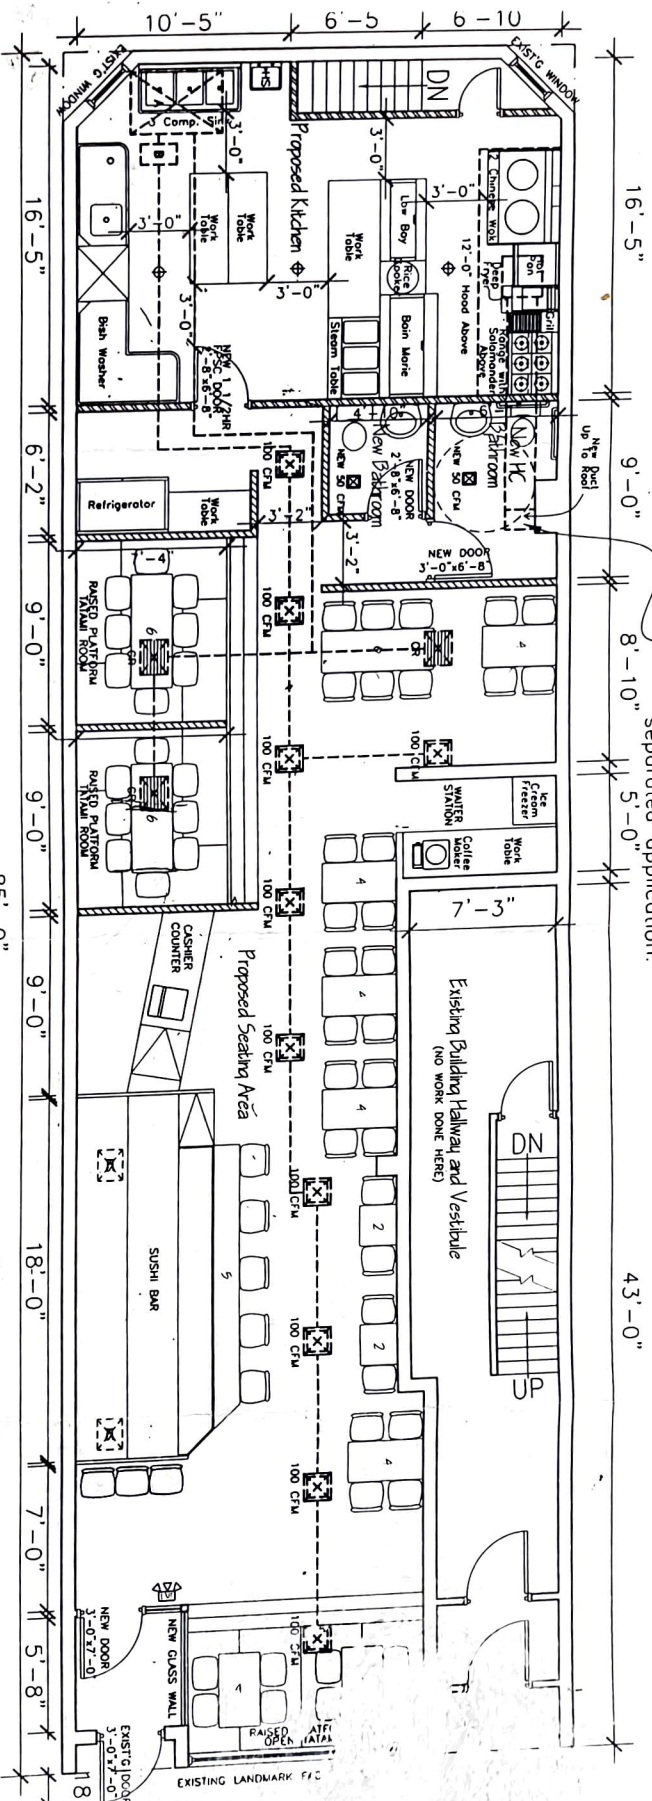

85'-0"

First Floor Plan 3/16" = 1'-0" (PROPOSED)

Proposed Seating for
55 Occupants

- A: 10 Ton A/C Package Unit
Manu.: Carrier
Model#: 40RM012
- MCA:
Capacity: 120,000 BTU
- B: Electrical Heater
Manu.: Ammon
Capacity: 1000,000 BTU

NO.	EQUIPMENT	MANUFACTURER	MODEL	NSF	LT	ADA	BTU
1	COMP. SINK	FAIR	CUSTOM				
2	HANDSINK	FAIR	HSA-107				
3	STOP SINK	FAIR	F1916				
4	HW HEATER	A.O. SMITH	BTR 199				190,000
5	2 CHINSE WOK LEADER	BT-07					200,000
6	2 BURN RANGE CARLAND	GT-88					170,000
7	1 HOT WATER	ST-88					170,000
8	1 HOT WATER	ST-88					170,000
9	STRAW LANE	TRIMPH	WB-46-NM-85				30,000
10	SALAMANDER	CARLAND	RS-46-2800				40,000
11	GAIL	CECWARE	BC-1812A				17,000
12	RICE COOKER	PALOMA	PR-10CS				31,900
13	ICE CUBER	MANITOWOC	AR-0101A				
14	BURN MARE	BEVERAGE-AIR	SUR60-24M				
15	WOK TABLE	WIN	CUSTOM				
16	REFRIGERATOR	TRU	T-49				
17	LOW BOY	CECWARE	WR-48				
18	CECWARE	CECWARE	CL-75				
19	CECWARE	CECWARE	CL-75				
20	WALTON REF. W. WINTER	CUSTOM					
21	WALTON REF. W. WINTER	CUSTOM					

C D DESIGN INC.

ARCHITECTS & ENGINEERS

45 Orchard St., NY 10002

TEL: 212-226-1261 FAX: 212-431-0074

THESE PLANS ARE INSTRUMENT OF SERVICE AND ARE THE PROPERTY OF THE ARCHITECT FIRM. CONTRACTOR SHALL VERIFY ALL FIELD CONDITIONS AND BE RESPONSIBLE FOR FIELD FIT AND QUANTITY OF WORK. NO ALLOWANCES SHALL BE MADE IN FAVOR OF THE CONTRACTOR FOR ANY ERROR OR OMISSION ON THIS PART.

PROJECT TITLE:

177 ATLANTIC AVE. BROOKLYN, NY

PROJECT NUMBER:

OS-01-05

DRAWN BY:

W.S.

CHECKED BY:

S.W.

DATE:

FEB 10, 05

SCALE:

3/16" = 1'-0"

DRAWING NUMBER:

A-05