


Office: Ser # CH-0517-AB

SHEARWALLS CEILING DIAPHRAGM						
ZONE I						
96" WALL HEIGHT - SYSTEM A						
WALL	LENGTH	TRIB.	JUST.	LAG	GLU	S-C S-F
1	108"	22-7"	1	1	1	18 18
2	120"	28-1"	1	1	1	19 19
3	96"	17-6"	1	3	1	16 16

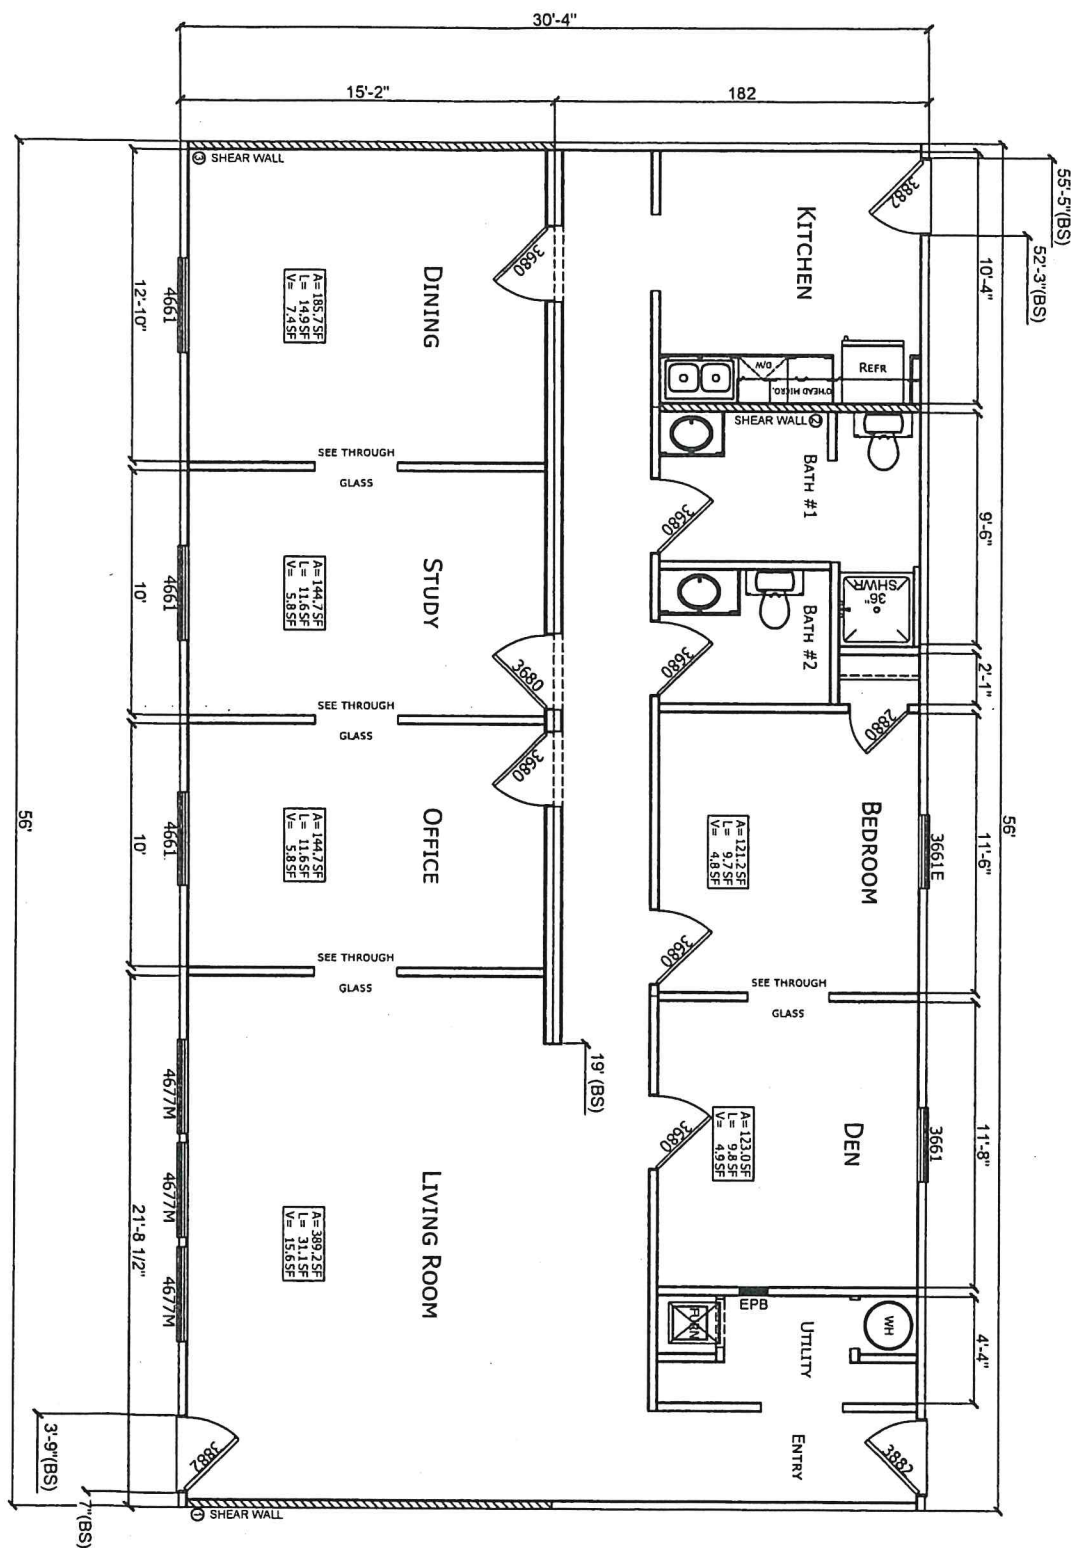

501 S. BURLISON BLVD. BURLISON, TX 76028

PLEASE NOTE: Champion Homes reserves the right to make changes at any time in price, specifications and design without notice and/or obligation. It is also the responsibility of the Retailer, Builder, Developer, and/or Consumer to verify and submit plans to all regulatory agencies including but not limited to Cities, Counties, and States, etc., prior to ordering the home. All changes required by local regulatory agencies will be the responsibility of the salesperson unless properly submitted to the manufacturing facility prior to the order placement and acceptance. All changes will be considered on a case-by-case basis and charged accordingly. Champion Homes will not take responsibility for additional requirements without having full knowledge of such at the time the order is placed. All design details and notes are suggestive only and are subject to the jurisdiction of the state and local codes. See local building department for local code and building requirements.


PROPRIETARY AND CONFIDENTIAL
THESE DRAWINGS AND SPECIFICATIONS ARE ORIGINAL
PROPERTY AND CONFIDENTIAL MATERIALS OF CHAMPION
COPYRIGHT - 4/18/2007 BY CHAMPION

PFS #23
Conforms to HUD MHCS 216021
Limited Approval 188 Days

FLOOR PLAN

MODEL: 125-0FC3256A-10517
32'-4" x 56'-0" 2 BEDROOM / 2 BATH
DATE: 02-19-21
SCALE: 1/8"=1'-0"
DRAWN BY: MMR
REVISIONS:

SHEET NO: AP-101
PAGE:

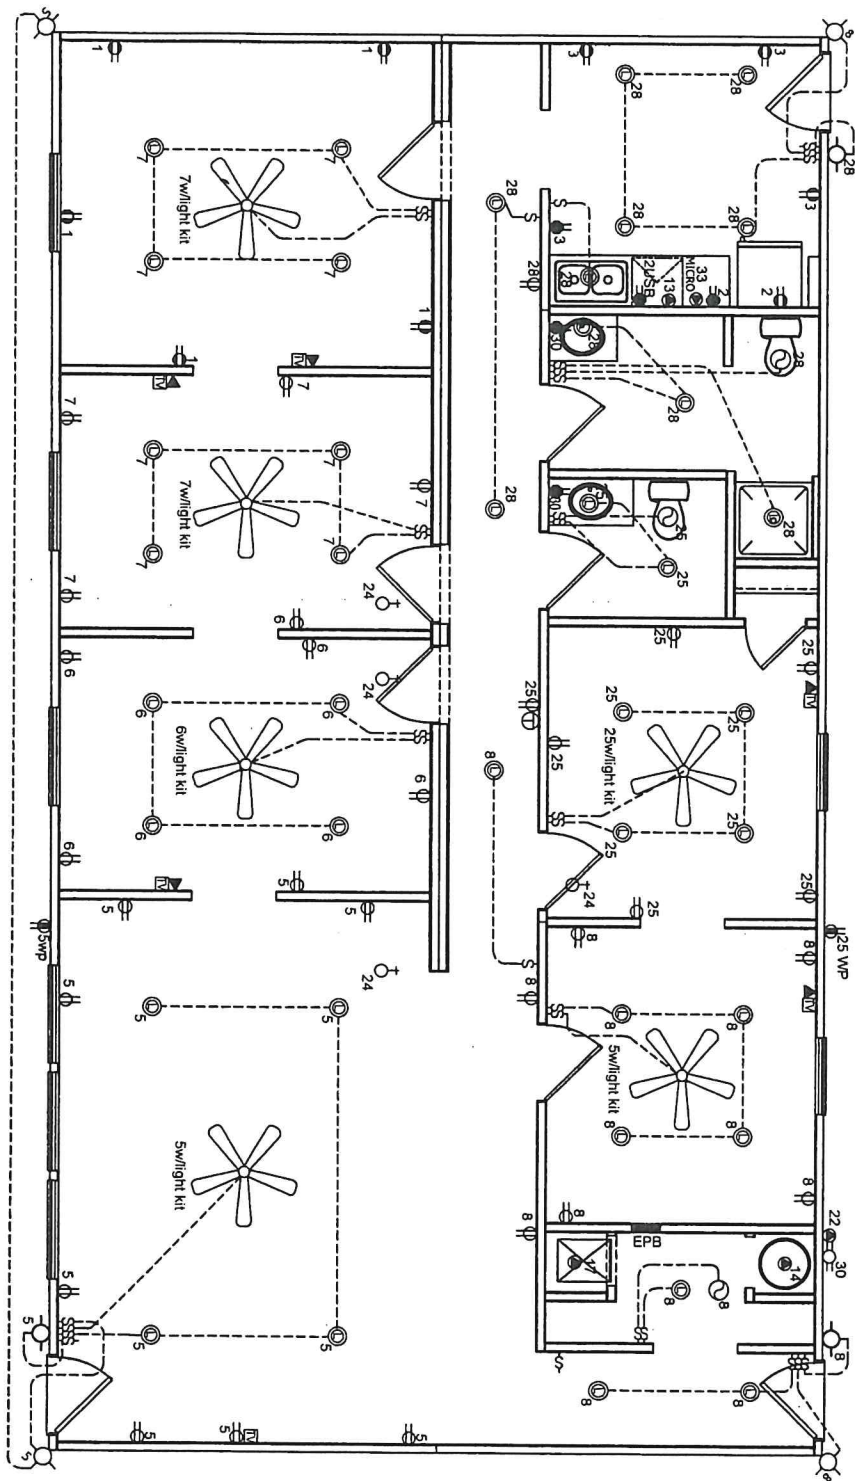

PLEASE NOTE: Champion Homes reserves the right to make changes at any time in prices, specifications and design without notice and/or obligation. All dimensions and specifications are nominal and subject to change. It is also the responsibility of the Retailer, Builder, Developer, and/or Consumer to verify and submit specs to all regulatory agencies including but not limited to Cities, Counties, protective covenants, etc., prior to ordering the home. All changes required by local regulatory agencies will be the responsibility of the seller/buyer unless properly submitted to the manufacturing facility prior to the order placement and acceptance. All changes will be considered on a case-by-case basis and charged accordingly. Champion Homes will not take responsibility for additional requirements without having full knowledge of such at the time the order is placed. All design details and notes are suggestive only and are subject to the jurisdiction of the state and local codes. See local building department for first time and soil requirements.

PROPRIETARY AND CONFIDENTIAL
THESE DRAWINGS AND SPECIFICATIONS ARE ORIGINAL
PROPRIETARY AND CONFIDENTIAL MATERIALS OF CHAMPION
COPYRIGHT © 1975-2007 BY CHAMPION

CHAMPION

501 S. BURLESON BLVD. BURLESON, TX 76028



TITLE:
ELECTRICAL PLAN

MODEL:

125-0FC3256A-10517

30'-0" x 55'-0" 2 BEDROOM/2 BATH

DATE: 02/19/21

SCALE: 1/8" = 1'-0"

DRAWN BY: MMR

REVISIONS:

SHEET NO.:

EP-101

PAGE: