

NAPLES LUXURY MOTOR SUITES

3584 Plover Ave Naples FL 34117

New Construction Motor Condominiums



From \$999,950

2,454 square feet

Mezzanine

Naples Luxury Motor Suites are upscale, gated, secure, and climate-controlled auto storage units located about 10 miles east of the Gulf Coast. Each suite is 2,454 square feet with a 14' x 14' electric roll-up garage door, making it easy to store your car, RV, or boat. The suites also feature impact glass windows and doors, an ADA bathroom, epoxy floor finish, mezzanine living area, fire alarm and suppression system, security system, and 3-phase power. Only 9 suites are available, so act now! Call **239-784-3283**



Experience Matters

David R. Bartley, Sr
Broker/General Partner
Bartley Realty LLL


O 239-261-1186
C 239-784-3283
Dave@BartleyRealty.com

5380 Mahogany Ridge Dr,
Naples, FL 34119
www.BartleyRealty.com



BartleyRealty

NAPLES LUXURY MOTOR SUITES

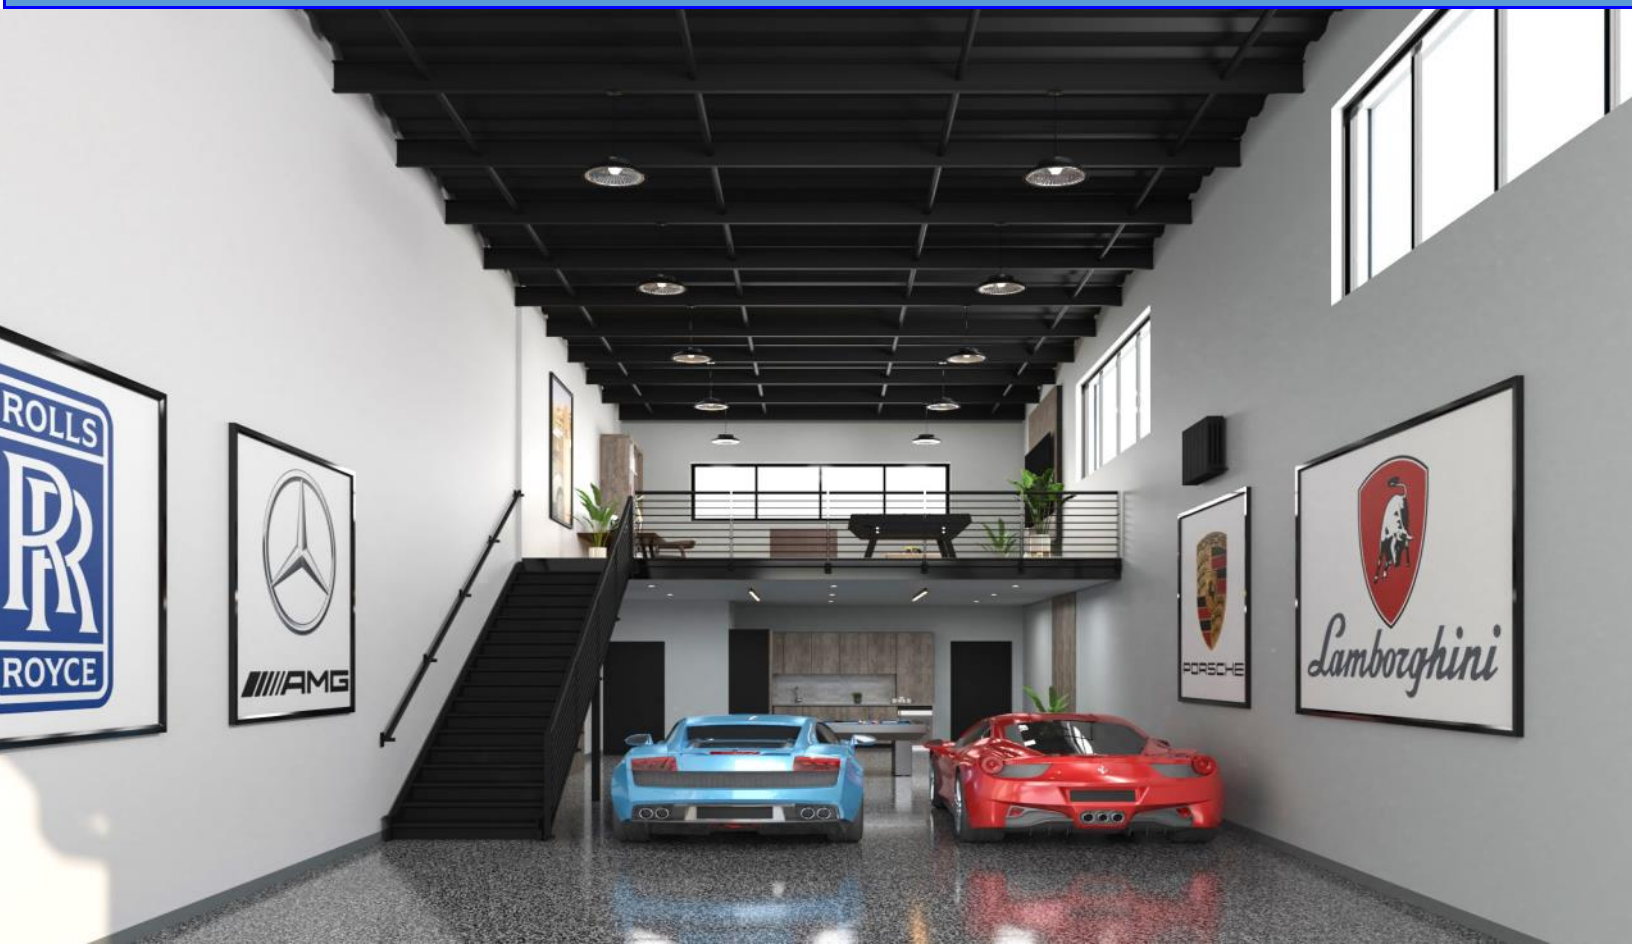

3584 Plover Ave Naples FL 34117 Pricing Sheet 10-17-24

Unit Number	1st Floor	Mezz	Total SF	Sales Price	Lease Rate	Base Rent PY	Base Rent PM
101	1,840	595	2,435	\$1,050,950	\$24.00	\$58,440.00	\$4,870.00
102	1,840	595	2,435	\$999,950	\$24.00	\$58,440.00	\$4,870.00
103	1,840	595	2,435	\$1,020,950	\$24.00	\$58,440.00	\$4,870.00
104	1,840	595	2,435	\$1,050,950	\$24.00	\$58,440.00	\$4,870.00
201	1,840	591	2,431	\$1,050,950	\$24.00	\$58,344.00	\$4,862.00
202	1,840	591	2,431	\$1,020,950	\$24.00	\$58,344.00	\$4,862.00
203	1,840	591	2,431	\$1,020,950	\$24.00	\$58,344.00	\$4,862.00
204	1,840	591	2,431	\$1,020,950	\$24.00	\$58,344.00	\$4,862.00
205	1,840	591	2,431	\$1,050,950	\$24.00	\$58,344.00	\$4,862.00
	16,560	5,335	21,895				

Plover III Condo Assn 2024 Per Unit Owner HOA Expenses

				HOA	HOA	HOA	HOA						
Owner/Tenant	Unit #	Gross S/F	% of Gross	\$PSF	Cost P/M	Cost P/Q	Cost P/Y						
	101	2,435	11.12%	\$4.22	\$855.41	\$2,566.23	\$10,264.92						
	102	2,435	11.12%	\$4.22	\$855.41	\$2,566.23	\$10,264.92						
	103	2,435	11.12%	\$4.22	\$855.41	\$2,566.23	\$10,264.92						
	104	2,435	11.12%	\$4.22	\$855.41	\$2,566.23	\$10,264.92						
	201	2,431	11.10%	\$4.22	\$854.01	\$2,562.02	\$10,248.06						
	202	2,431	11.10%	\$4.22	\$854.01	\$2,562.02	\$10,248.06						
	203	2,431	11.10%	\$4.22	\$854.01	\$2,562.02	\$10,248.06						
	204	2,431	11.10%	\$4.22	\$854.01	\$2,562.02	\$10,248.06						
	205	2,431	11.10%	\$4.22	\$854.01	\$2,562.02	\$10,248.06						
TOTAL		21,895	100.00%		\$7,691.67	\$23,075.00	\$92,300.00						

Naples Luxury Motor Suites
CONSTRUCTION CRITERIA
October 18, 2024

Hurricane Protection:

Building Rated to 162 MPH wind load.

All windows and doors are impact rated.

Floors:

All floors to be a minimum 5", 3000 PSI smooth trowel finish concrete slab over vapor barrier on graded and compacted fill with Epoxy Finish.

Walls:

Demising walls: 6" metal studs, insulated, with 5/8" fire-rated gypsum board to roof deck, primed and painted.

Exterior walls: Masonry block to receive furring strips and 5/8" fire-rated gypsum board to ceiling line, primed and painted.

Ceiling: Painted Black

Doors:

Front door: One (1) 3'-0" glass door with aluminum to match storefront. Building standard hardware including lockset, deadbolt with door closer, weather stripping and threshold.

Rear Exterior Door: One (1) 3'-0" 20-gauge galvanized hollow metal door, painted. Building standard hardware including lockset, deadbolt, door closer, weather stripping and threshold.

Heavy duty motorized, insulated hurricane section door 14' x 14'.

Windows:

All windows to be Low E Impact glass, ¼ grey tint.

Mezzanine with window for natural light, ¼ grey tint.

Fire Protection:

Fire Sprinkler

Developer will install a complete automatic sprinkler system (wet) for the Building and Premises, as required by local codes and Factory Mutual (F.M.) requirements. The design of such a system and the number and location of sprinkler heads to be installed shall be in accordance with the Developer base interior design. Any modifications to base design required by Owner's interior design or proposed use or occupancy shall be performed by the Developer's fire protection contractor for said site and shall be at Owner's sole cost and expense. Sprinkler heads will be provided at approximately a minimum of 10' above finish floor (AFF).

Fire Alarm

Provide fire alarm system as required by the local jurisdiction having authority. Any modifications or additional fire systems and alarms required by Owner's interior design or proposed use, or occupancy shall be performed by the Developer's contractor for said site and shall be at Owner's sole cost and expense. CO/NO2 detectors are provided

HVAC - (Heating, Ventilation, and Air-Conditioning):

1. Provide return and supply air handler split system with fiber board duct system painted to match ceiling.
2. Provide a standard heat/cool thermostat mounted 5'-0" AFF in retail space.
3. One (1) exhaust fan in toilet area.
4. The system shall be designed to meet applicable energy codes and standard mechanical code or SFBC as applicable.

Buyer _____

Seller _____

Electrical Supply:

Panels

225 AMP 208 Three-Phase

Outlets

1. Recessed duplex outlets @ 12'-0" on center (OC) along demising walls approximately 1'-6" AFF.

Light Switches

1. One (1) light switch in restroom (combination light switch/exhaust fan control) with occupancy sensor.
2. One (1) 3-way switch is provided at each entrance (front and back of unit).

Lighting

1. Bright overhead LED lighting
2. Wall-mounted emergency lights per code.

Telephone & Cable:

Leviton Structural Media Enclosure

Security:

Exterior Security Camera with 24-hour access

Each unit receives a security system that can be monitored.

Car Washing Station

Hose bib connection in parking lot for car wash

Ceiling Height:

Clear heights range from approximately 19'4" to 31'.

RV Pump Out:

One location next to the trash enclosures.

Mezzanine:


8" Hollowcore plank deck with 2" concrete topper

Precast concrete and handrail

NOTE: All preceding information is contingent upon approval by local jurisdiction having authority and subject to change by the developer.

Buyer _____

Seller _____

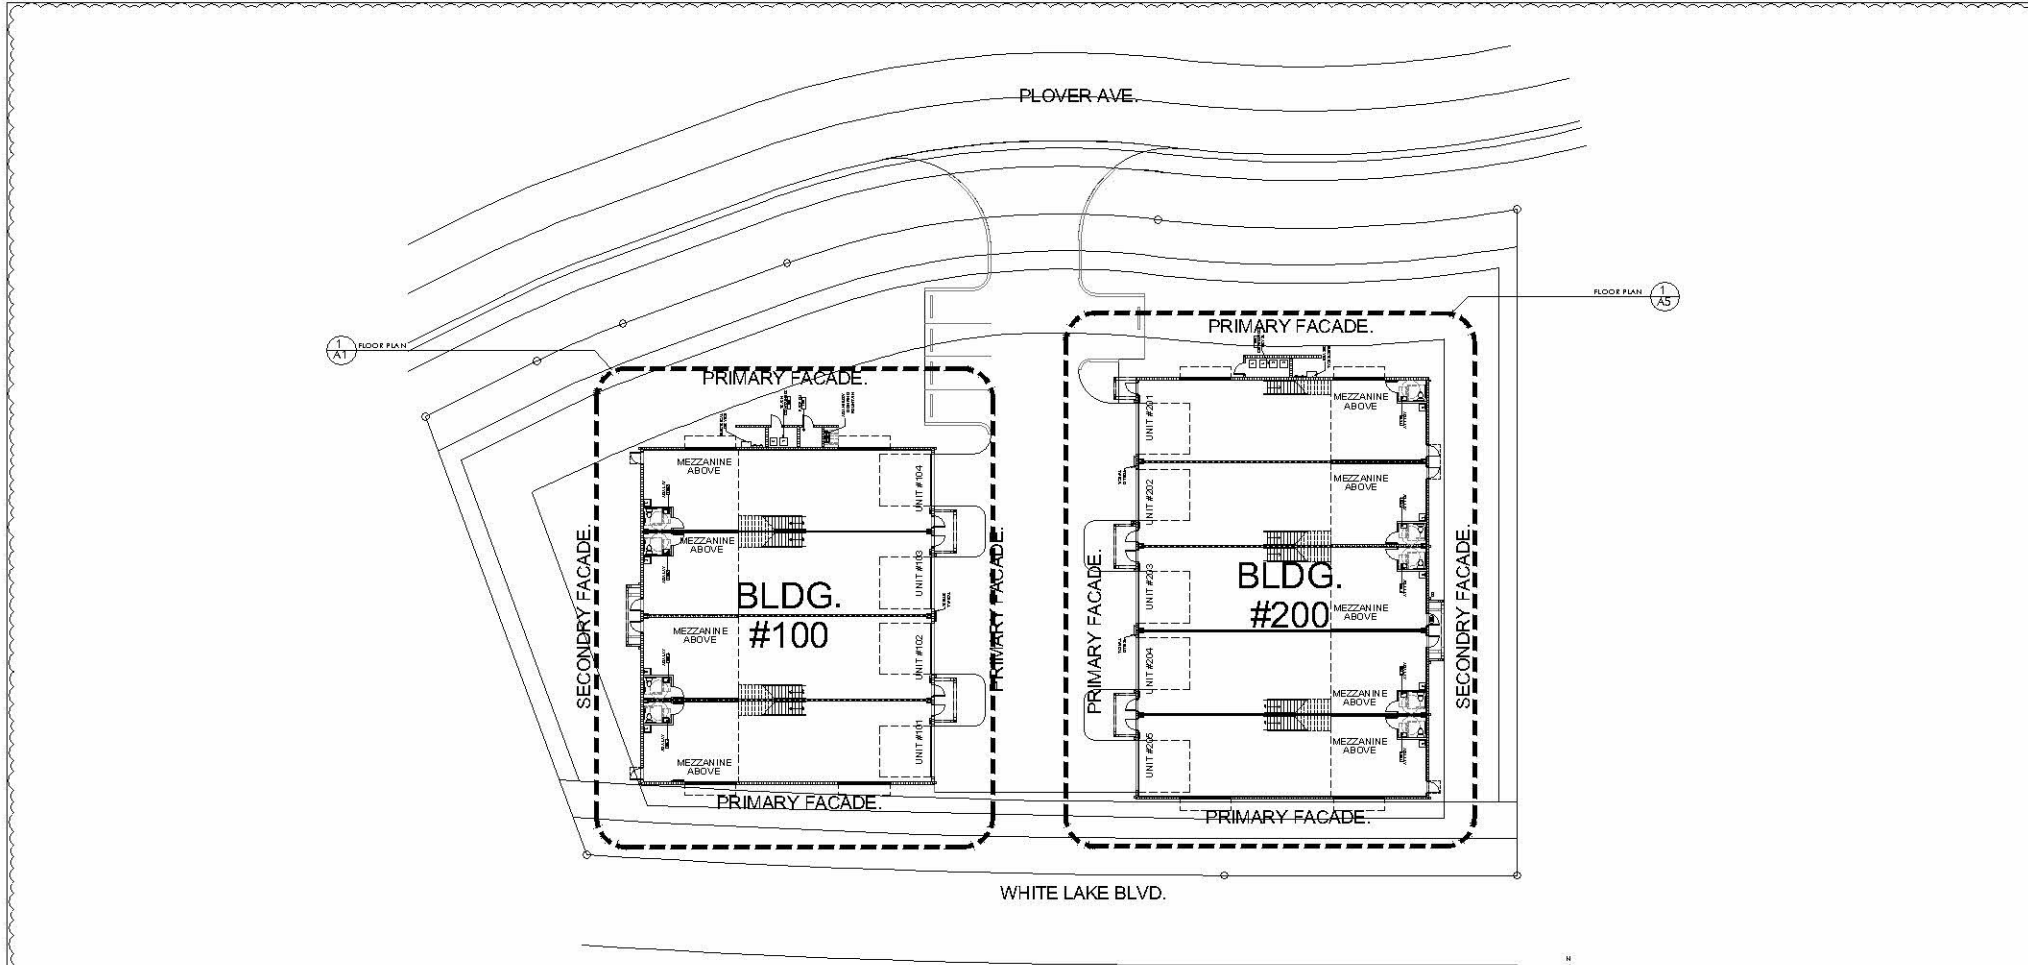

1
A-0 PROPOSED KEY PLAN
SCALE: 1/8"=1'-0"




--	--

REV #	DATE / DESCRIPTION	D. BY	REV #	DATE / DESCRIPTION
1	REV. 1 - 09.12.23	MM		
2				
3				

JOB No.:	Date: 2/17/2023
Drawn By: MM	Checked By: J.P.
Scale: 1/8" = 1'-0"	Project: N.A.

Naples Luxury Auto Condominium
Building 100 & 200

3584 Plover Ave.
 Naples, Florida 34117

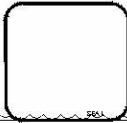



PHOENIX ASSOCIATES OF FLORIDA, INC.
 13180 Livingston Road | Suite #204 Naples | FL 34109 P 239 | 596-9111 F 239 | 596-2637
 Car 10 of 10 of Authority #CA-00007007 Car 10 of 10 of Authority #AA-25031181

PHOENIX ASSOCIATES OF FLORIDA, INC. (PAFI) IS AN EQUAL OPPORTUNITY EMPLOYER. PAFI AND ITS AFFILIATES DO NOT DISCRIMINATE IN EMPLOYMENT ON THE BASIS OF RACE, COLOR, RELIGION, SEX, NATIONAL ORIGIN, ANCESTRY, AGE, MARITAL STATUS, PREGNANCY, GENETIC INFORMATION, DISABILITY, OR ANY OTHER CHARACTERISTIC PROTECTED BY FEDERAL, STATE, OR LOCAL LAWS. PAFI AND ITS AFFILIATES DO NOT DISCRIMINATE IN EMPLOYMENT ON THE BASIS OF SEXUAL ORIENTATION, GENDER, GENDER EXPRESSION, OR GENDER IDENTITY. PAFI AND ITS AFFILIATES DO NOT DISCRIMINATE IN EMPLOYMENT ON THE BASIS OF SEXUAL HARRASSMENT. PAFI AND ITS AFFILIATES DO NOT DISCRIMINATE IN EMPLOYMENT ON THE BASIS OF SEXUAL HARASSMENT. PAFI AND ITS AFFILIATES DO NOT DISCRIMINATE IN EMPLOYMENT ON THE BASIS OF SEXUAL HARASSMENT.

SHEET TITLE
KEY PLAN
BLDG. -100
&
BLDG. 200

SHEET NUMBER
A-0

Naples Luxury Motor Suites Floor Plan with Car

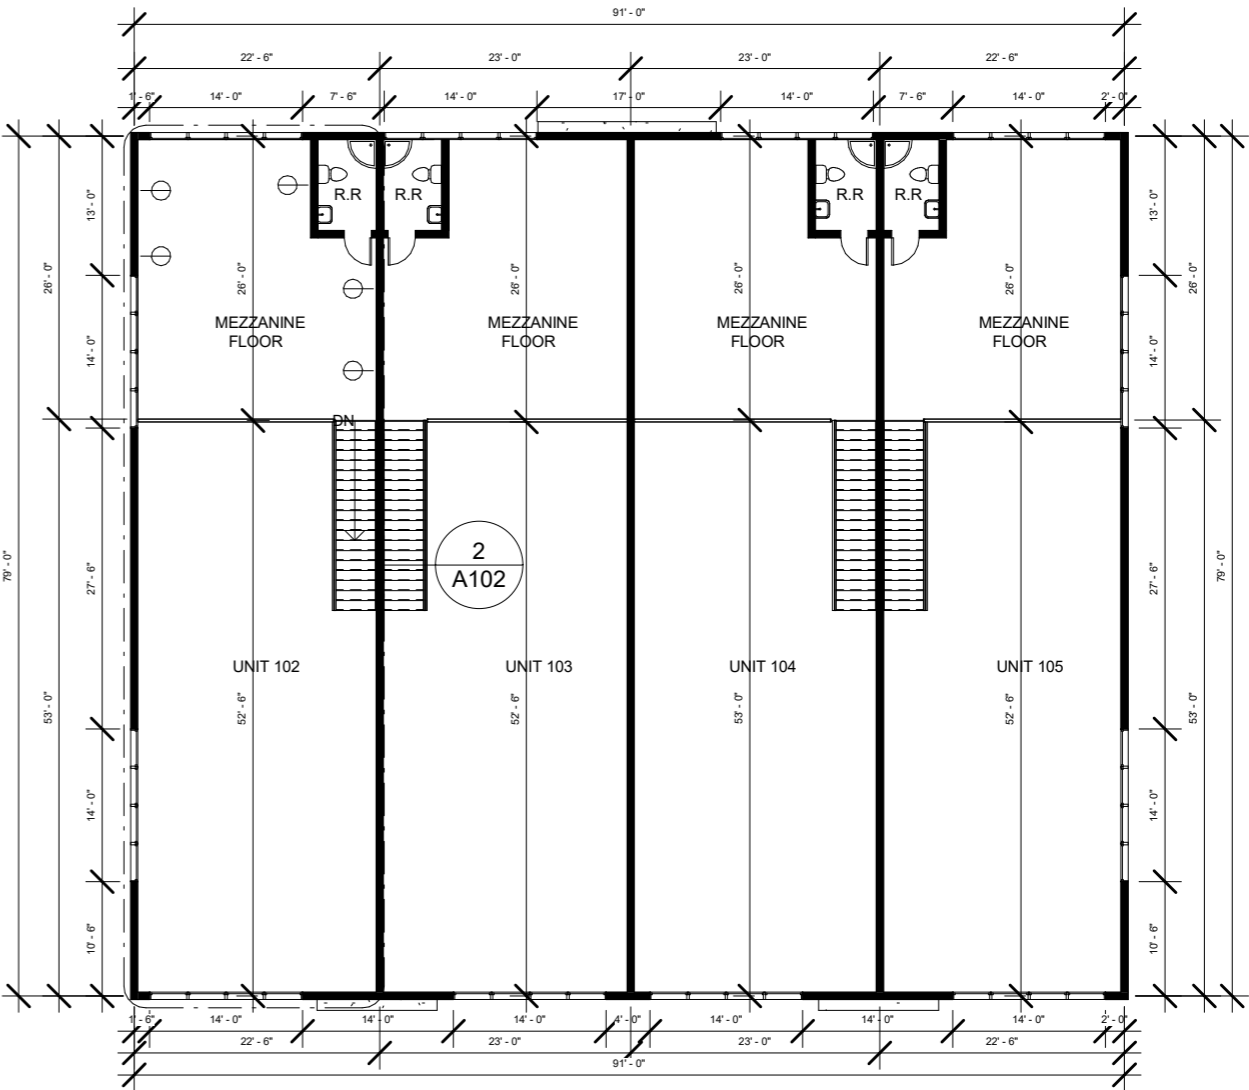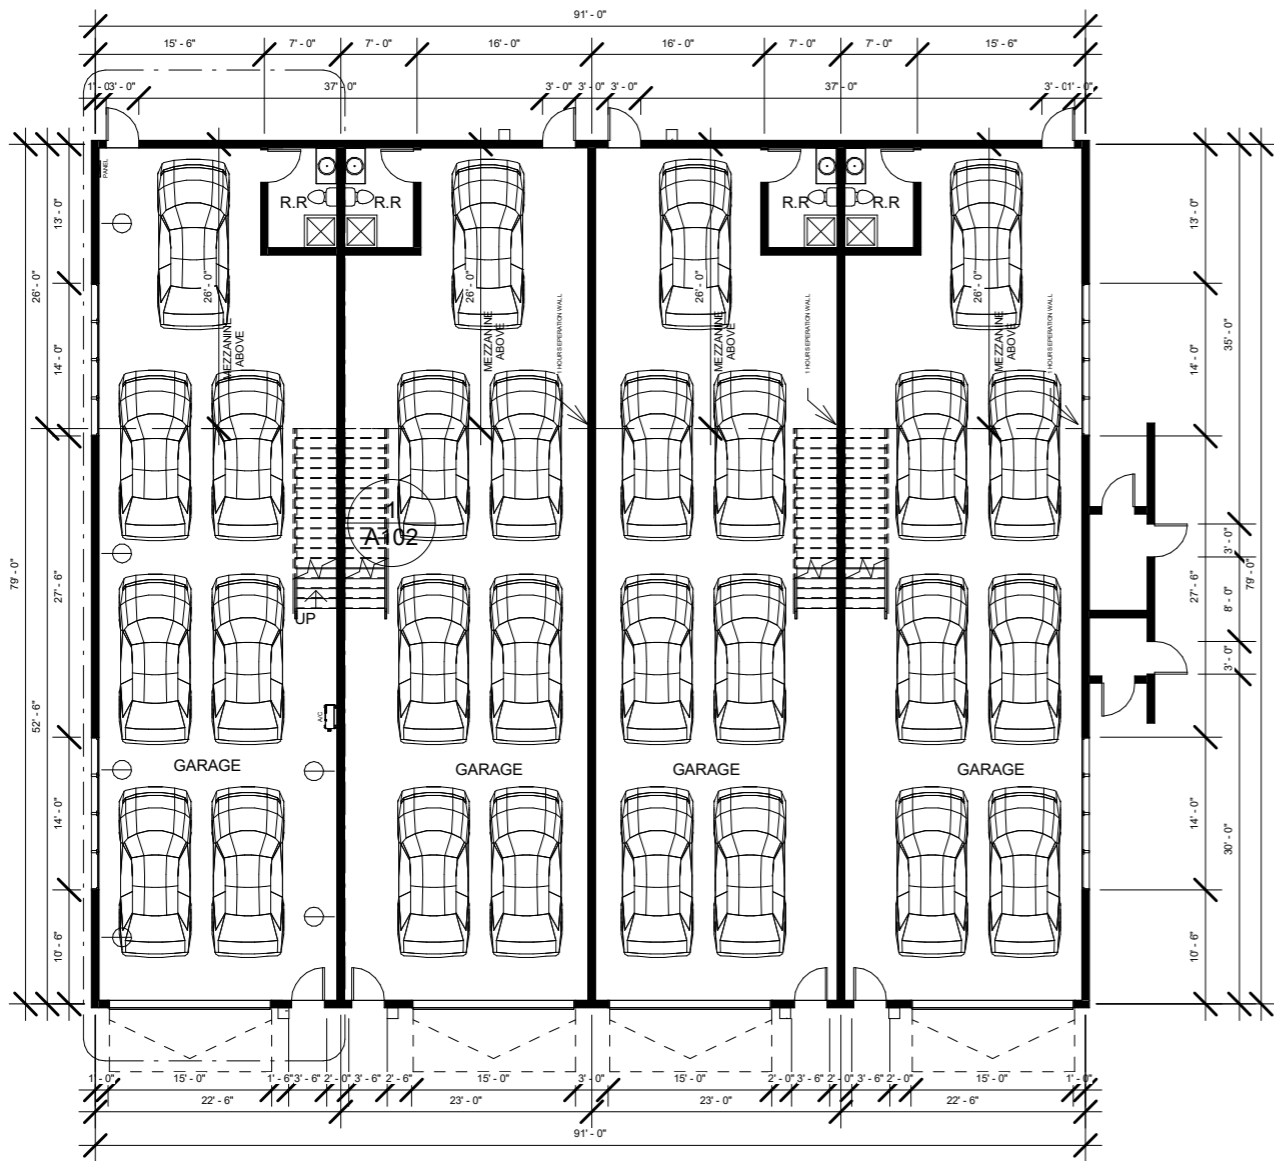


① NGL
1/16" = 1'-0"


② MEZZALINE FLOOR
1/16" = 1'-0"

No.	Description	Date

Owner	Unnamed	
Project Name	Project number	
	Date	
	Drawn by	
Checked by	Scale	1/16" = 1'-0"

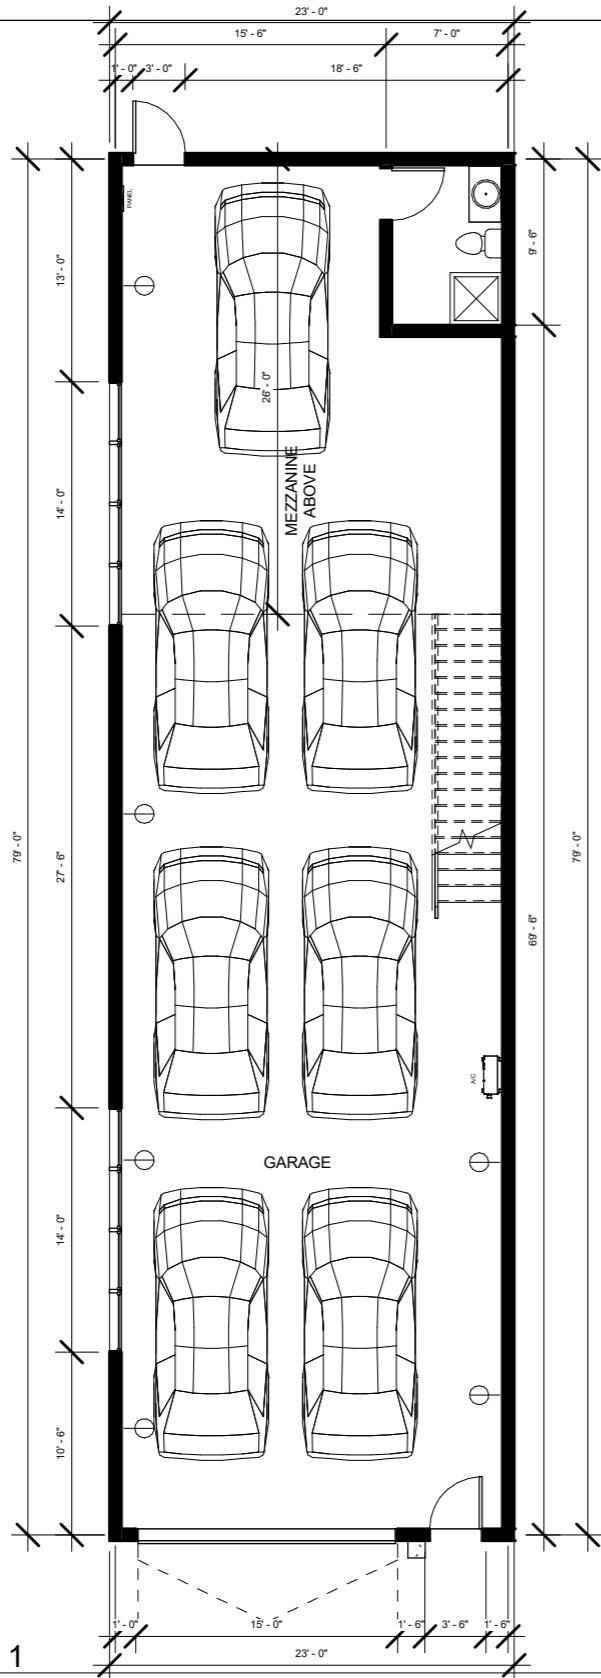

1 NGL - Callout 1
1" = 10'-0"

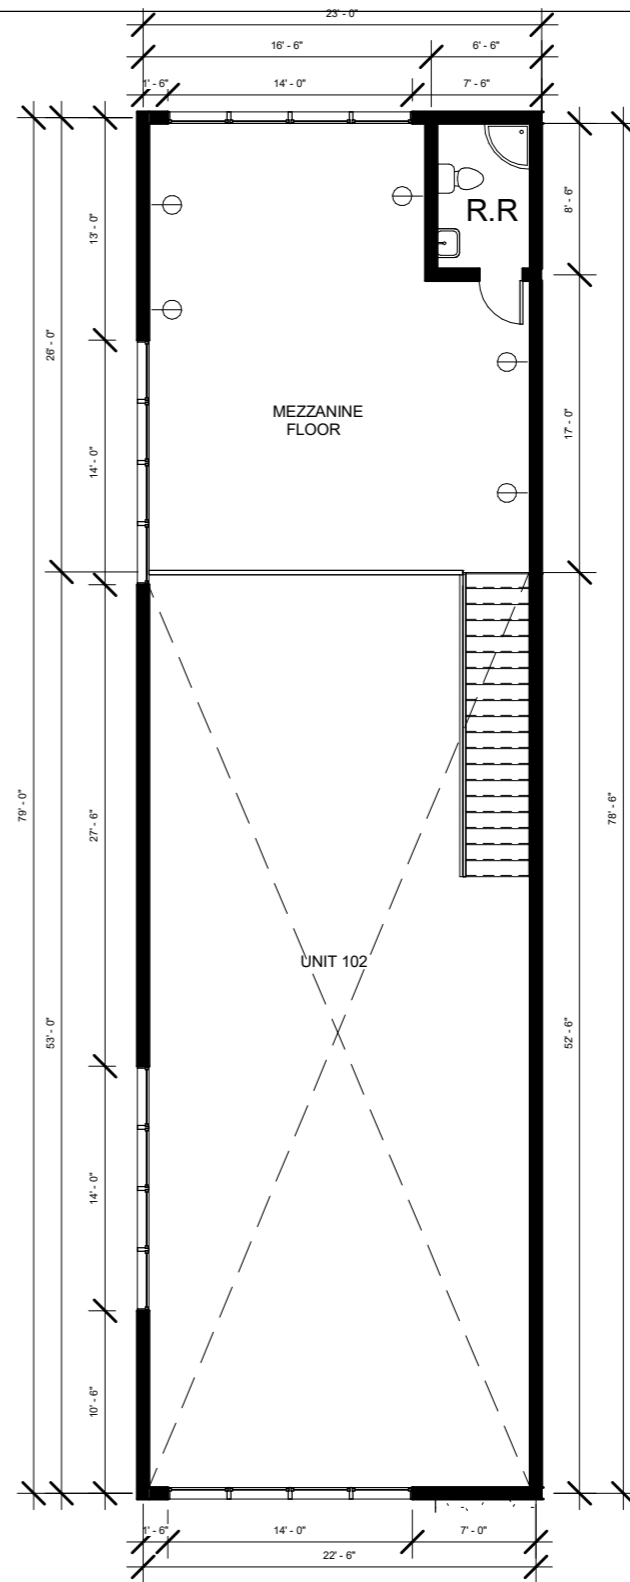

2 MEZZANINE FLOOR - Callout 1
1" = 10'-0"

--	--

No.	Description	Date

<p>Owner</p> <p>Project Name</p>	<p>Unnamed</p> <table border="1" style="width: 100%;"> <tr> <td>Project number</td> <td> </td> </tr> <tr> <td>Date</td> <td> </td> </tr> <tr> <td>Drawn by</td> <td> </td> </tr> <tr> <td>Checked by</td> <td> </td> </tr> </table> <p style="text-align: right;">Scale 1" = 10'-0"</p>	Project number		Date		Drawn by		Checked by	
Project number									
Date									
Drawn by									
Checked by									