


FLOOR PLAN OPTION A
SCALE: 1/8" = 1'

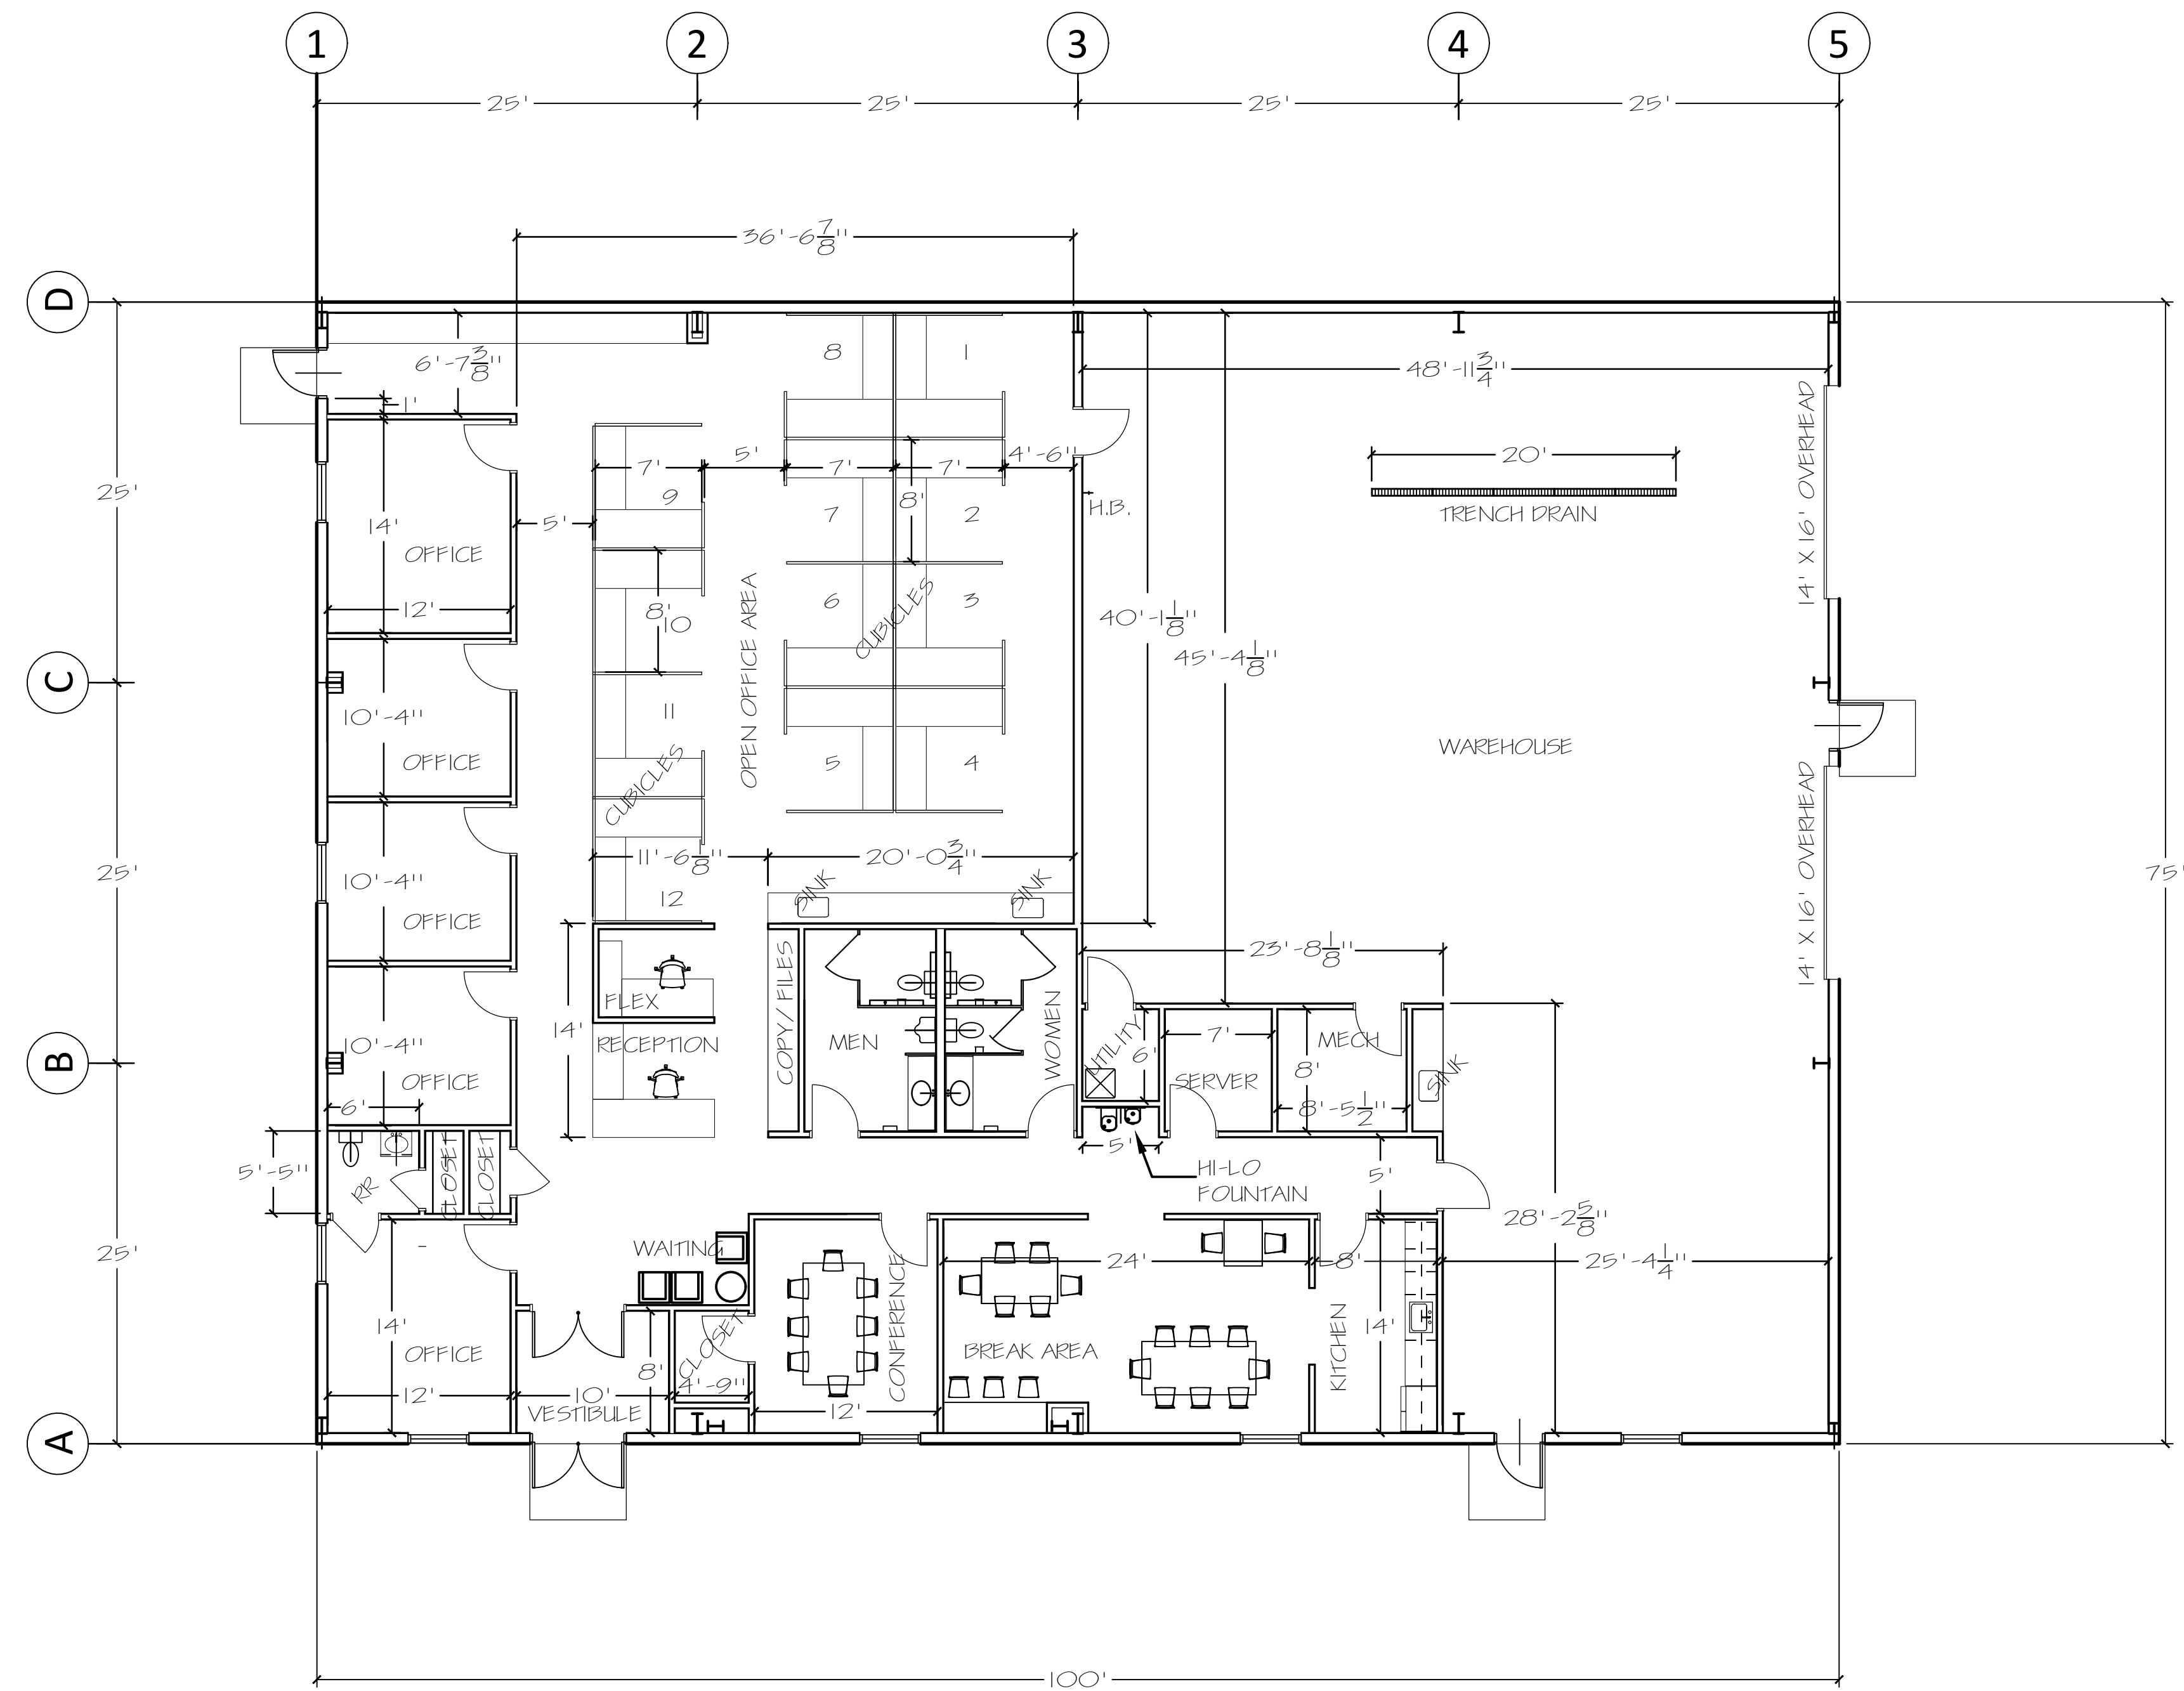

RIVER HILL OFFICES / WAREHOUSE

BURNS ARCHITECTURAL DESIGN
128 PREDONIA ROAD * MERCER, PA 16137
PHONE / FAX: 724 / 475-2350
burnslw@windstream.net

DRAWN BY: VLB
CHECKED BY: VLB
SCALE: 1/8" = 1'
PROJECT #1601
DATE: 9/26/2023
SHEET NO. A - 1