






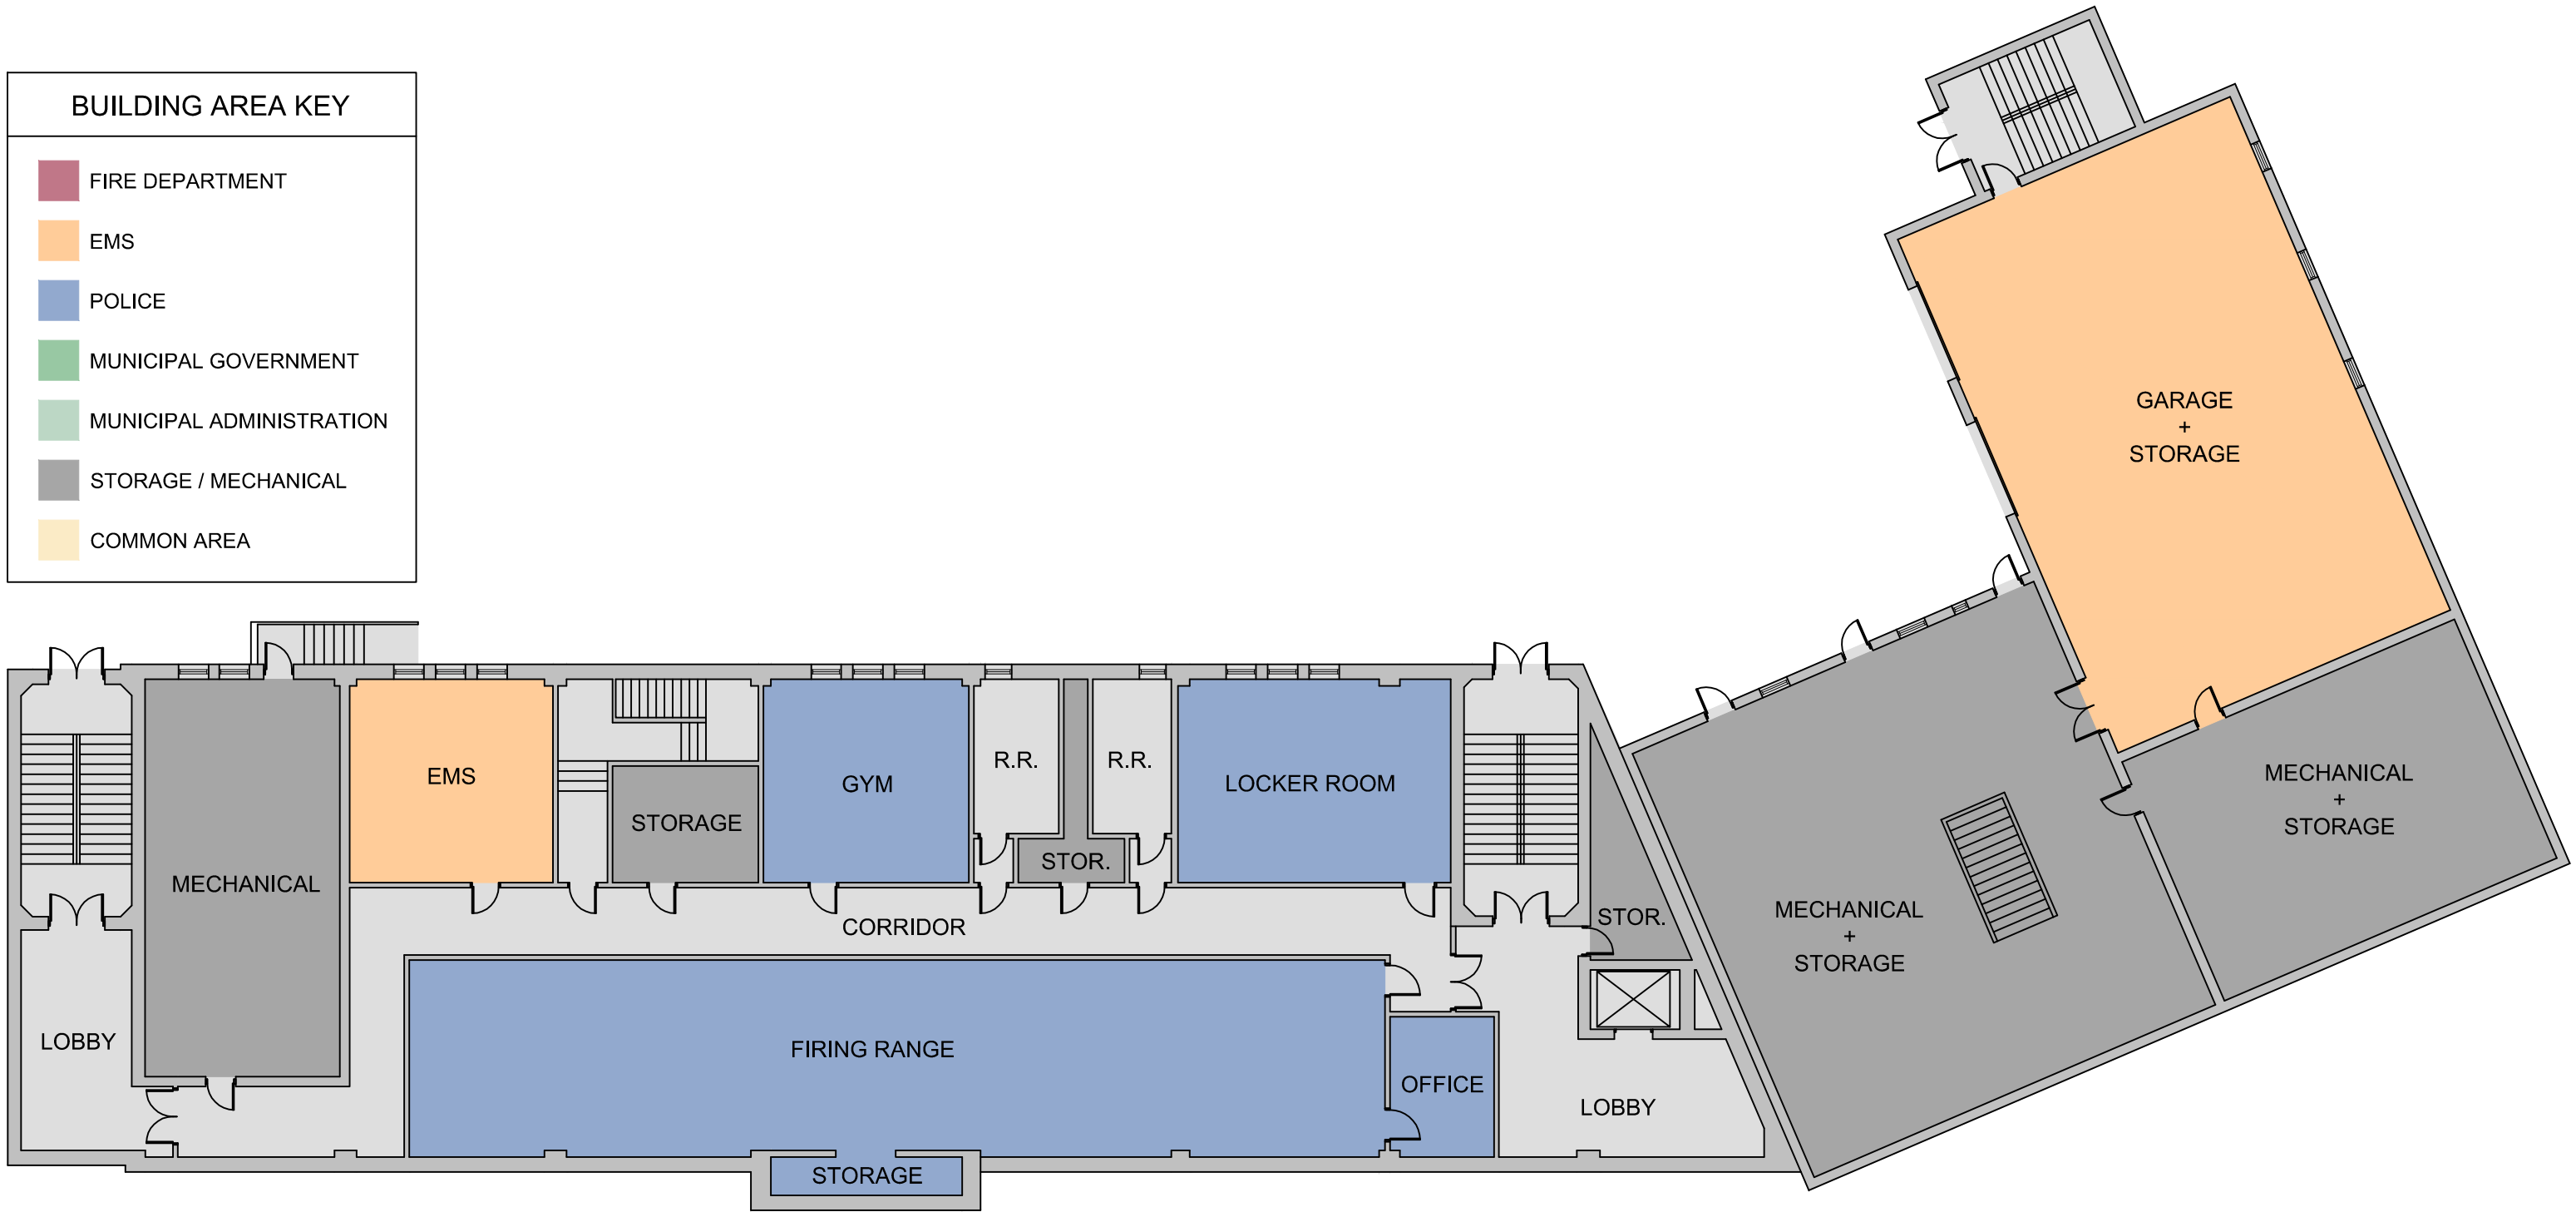


BUILDING AREA KEY	
	FIRE DEPARTMENT
	EMS
	POLICE
	MUNICIPAL GOVERNMENT
	MUNICIPAL ADMINISTRATION
	STORAGE / MECHANICAL
	COMMON AREA



1 BASEMENT FLOOR PLAN
SCALE: 1/16"=1'-0"



PROJECT:
FEASIBILITY STUDY
for
PENN HILLS
MUNICIPAL BUILDING

ADDRESS:
12245 Frankstown Road,
Allegheny County,
Penn Hills, Pennsylvania
15235-3494



BASEMENT FLOOR PLAN
CURRENT BUILDING PROGRAM DIAGRAM



DATE:
07/14/14
SCALE:
1/16" = 1'-0"

DRAWING NO.:
A-00