



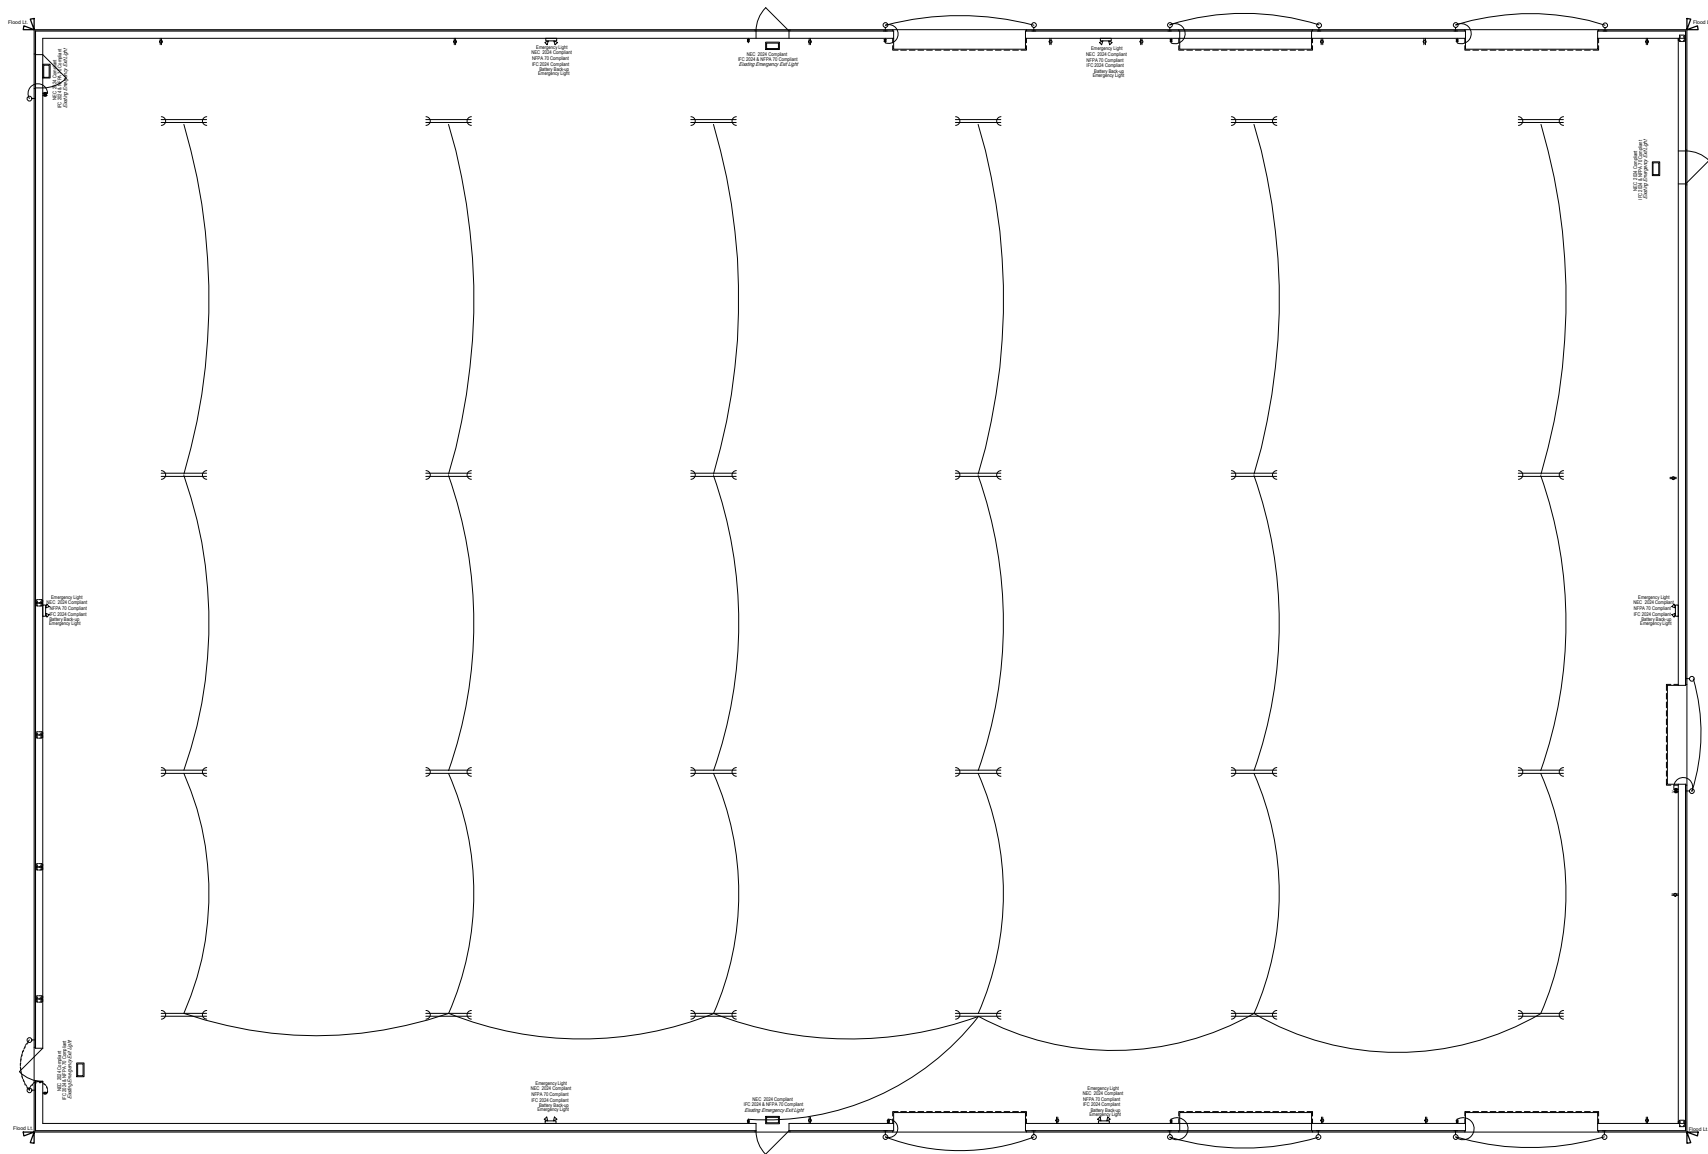

ELECTRICAL PLAN Scale: 3/16"=1'-0"

ELECTRICAL NOTES

1) SERVICE REQUESTED IS UNDERGROUND
1 PHASE

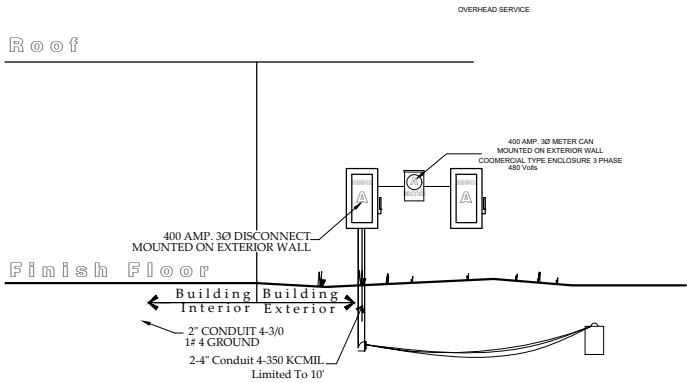

TYPICAL ELECTRICAL RISER DIAGRAM

SCALE: N.T.S.

ELECTRICAL NOTES

1. ONLY NEW PROPOSED WIRING, OUTLETS & LIGHTING SHOWN ON THIS PLAN

2. THIS SPECIFICATION SHEET IS INTENDED AS A GUIDE FOR TRADESMEN. THE FLOOR PLANS ENCLOSED HEREIN ARE SUGGESTIONS FOR THE PLACEMENT OF EQUIPMENT. THEY ARE NOT INTENDED FOR CONSTRUCTION.

3. EXACT EQUIPMENT LOCATIONS MUST BE JOB SITE VERIFIED BY OWNER/ CONTRACTOR AND EQUIPMENT SPECIALIST.

4. FOLLOW MANUFACTURER'S DRAWINGS FOR EXACT REQUIREMENTS FOR ANY EQUIPMENT SUPPLIED. CONSULT WITH MANUFACTURER REP FOR ADDITIONAL INFORMATION.

5. ADDITIONAL CONVENIENCE OUTLETS REQUIRED ON JOBSITE ARE THE RESPONSIBILITY OF ELECTRICAL CONTRACTORS. FOLLOW LOCAL CODE RESTRICTIONS.

Builder Notice

To the best of our knowledge these plans are drawn to comply with owner's and/or builders specifications and any changes made on them after prints are completed will be done at the owner's and/or builders expense and responsibility. The contractor shall verify all dimensions and enclosed drawing. J & I Designs is not liable for errors once construction has begun. While every effort has been made in the preparation of this plan to avoid mistakes, the maker can not guarantee against human error. The contractor of the job must check all dimensions and other details prior to construction and be solely responsible thereafter.

Builder:

1022 E. Tyler Suite #3
Harlingen, Texas 78550
Office: (956) 425-6604
E-mail: jandidesigns@att.net
Javier Martinez (956)345-5151
Ignacio Martinez (956)245-7106



J & I DESIGNS
est. 1993
RESIDENTIAL • COMMERCIAL • INDUSTRIAL • INSTITUTIONAL

CHTO ENTERPRISES

Project Information:
Lot#45 Laguna Circle Road
LAGUNA INDUSTRIAL ESTATES SUBDIVISION
HARLINGEN, TEXAS - CAMERON COUNTY

Prepared for:

Date:
11-11-2025

Plan Number
C-TA-15000-(5)-2025

Sheet:
3

Of:
4

E-1