

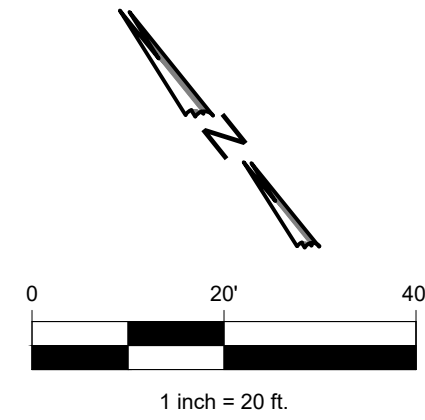


2/11/2025 8:36 AM F:\PROJECTS\PERSONAL WAREHOUSE\PW001 - BOZMAN MTCIVILCAD\EXHIBITS\MARKETING EXHIBIT\BELGRADE MT - MARKETING EXHIBIT.DWG

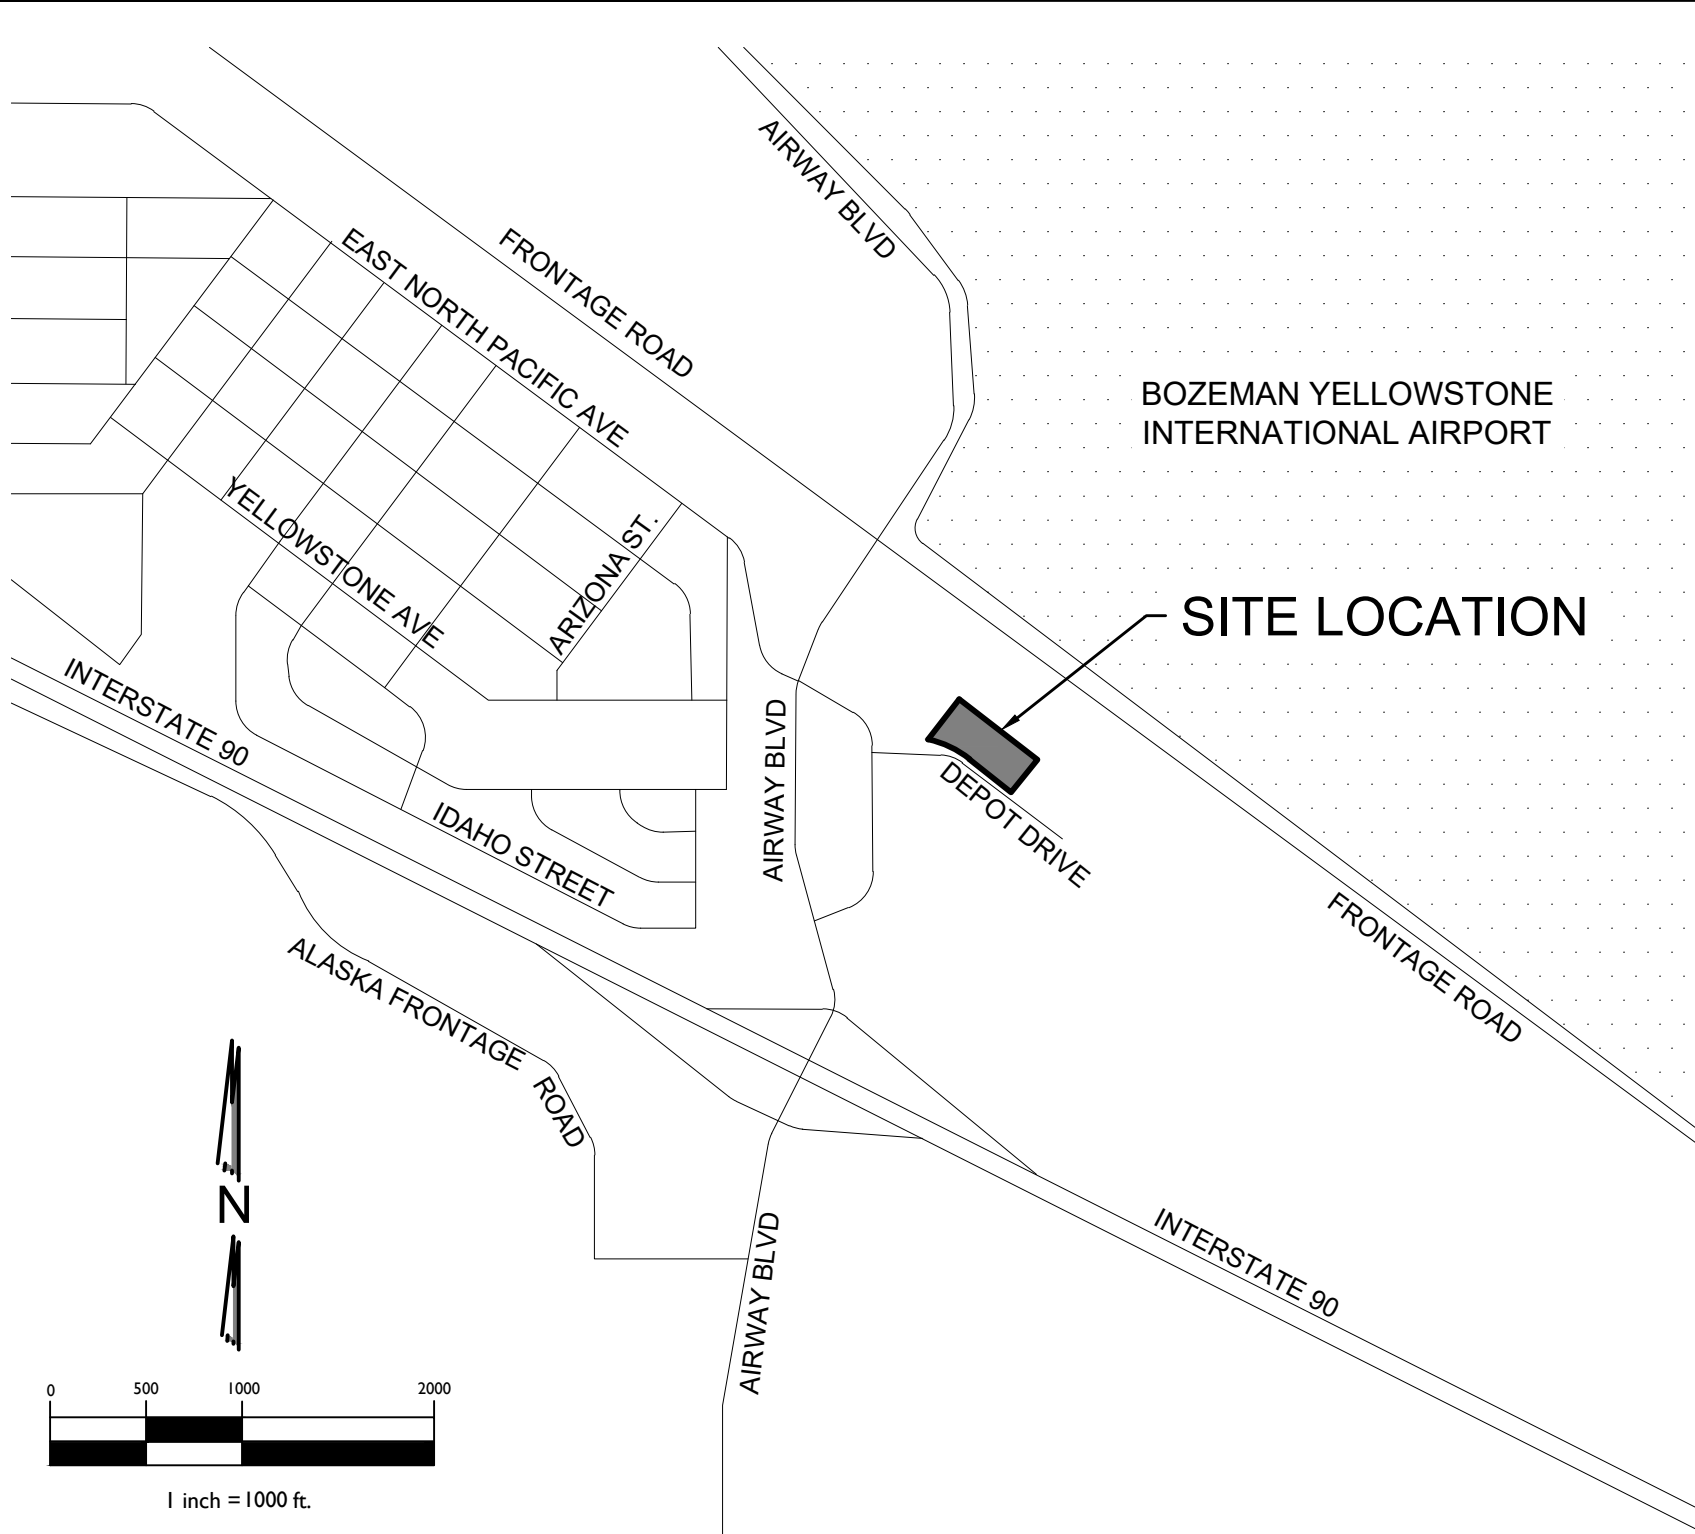

- LEGEND**
- FULLY FINISHED UNITS
 - FRONT LOADED UNITS
 - RESTROOM ONLY NO MEZZANINE
 - LOCATION
 - FINISHED WALLS

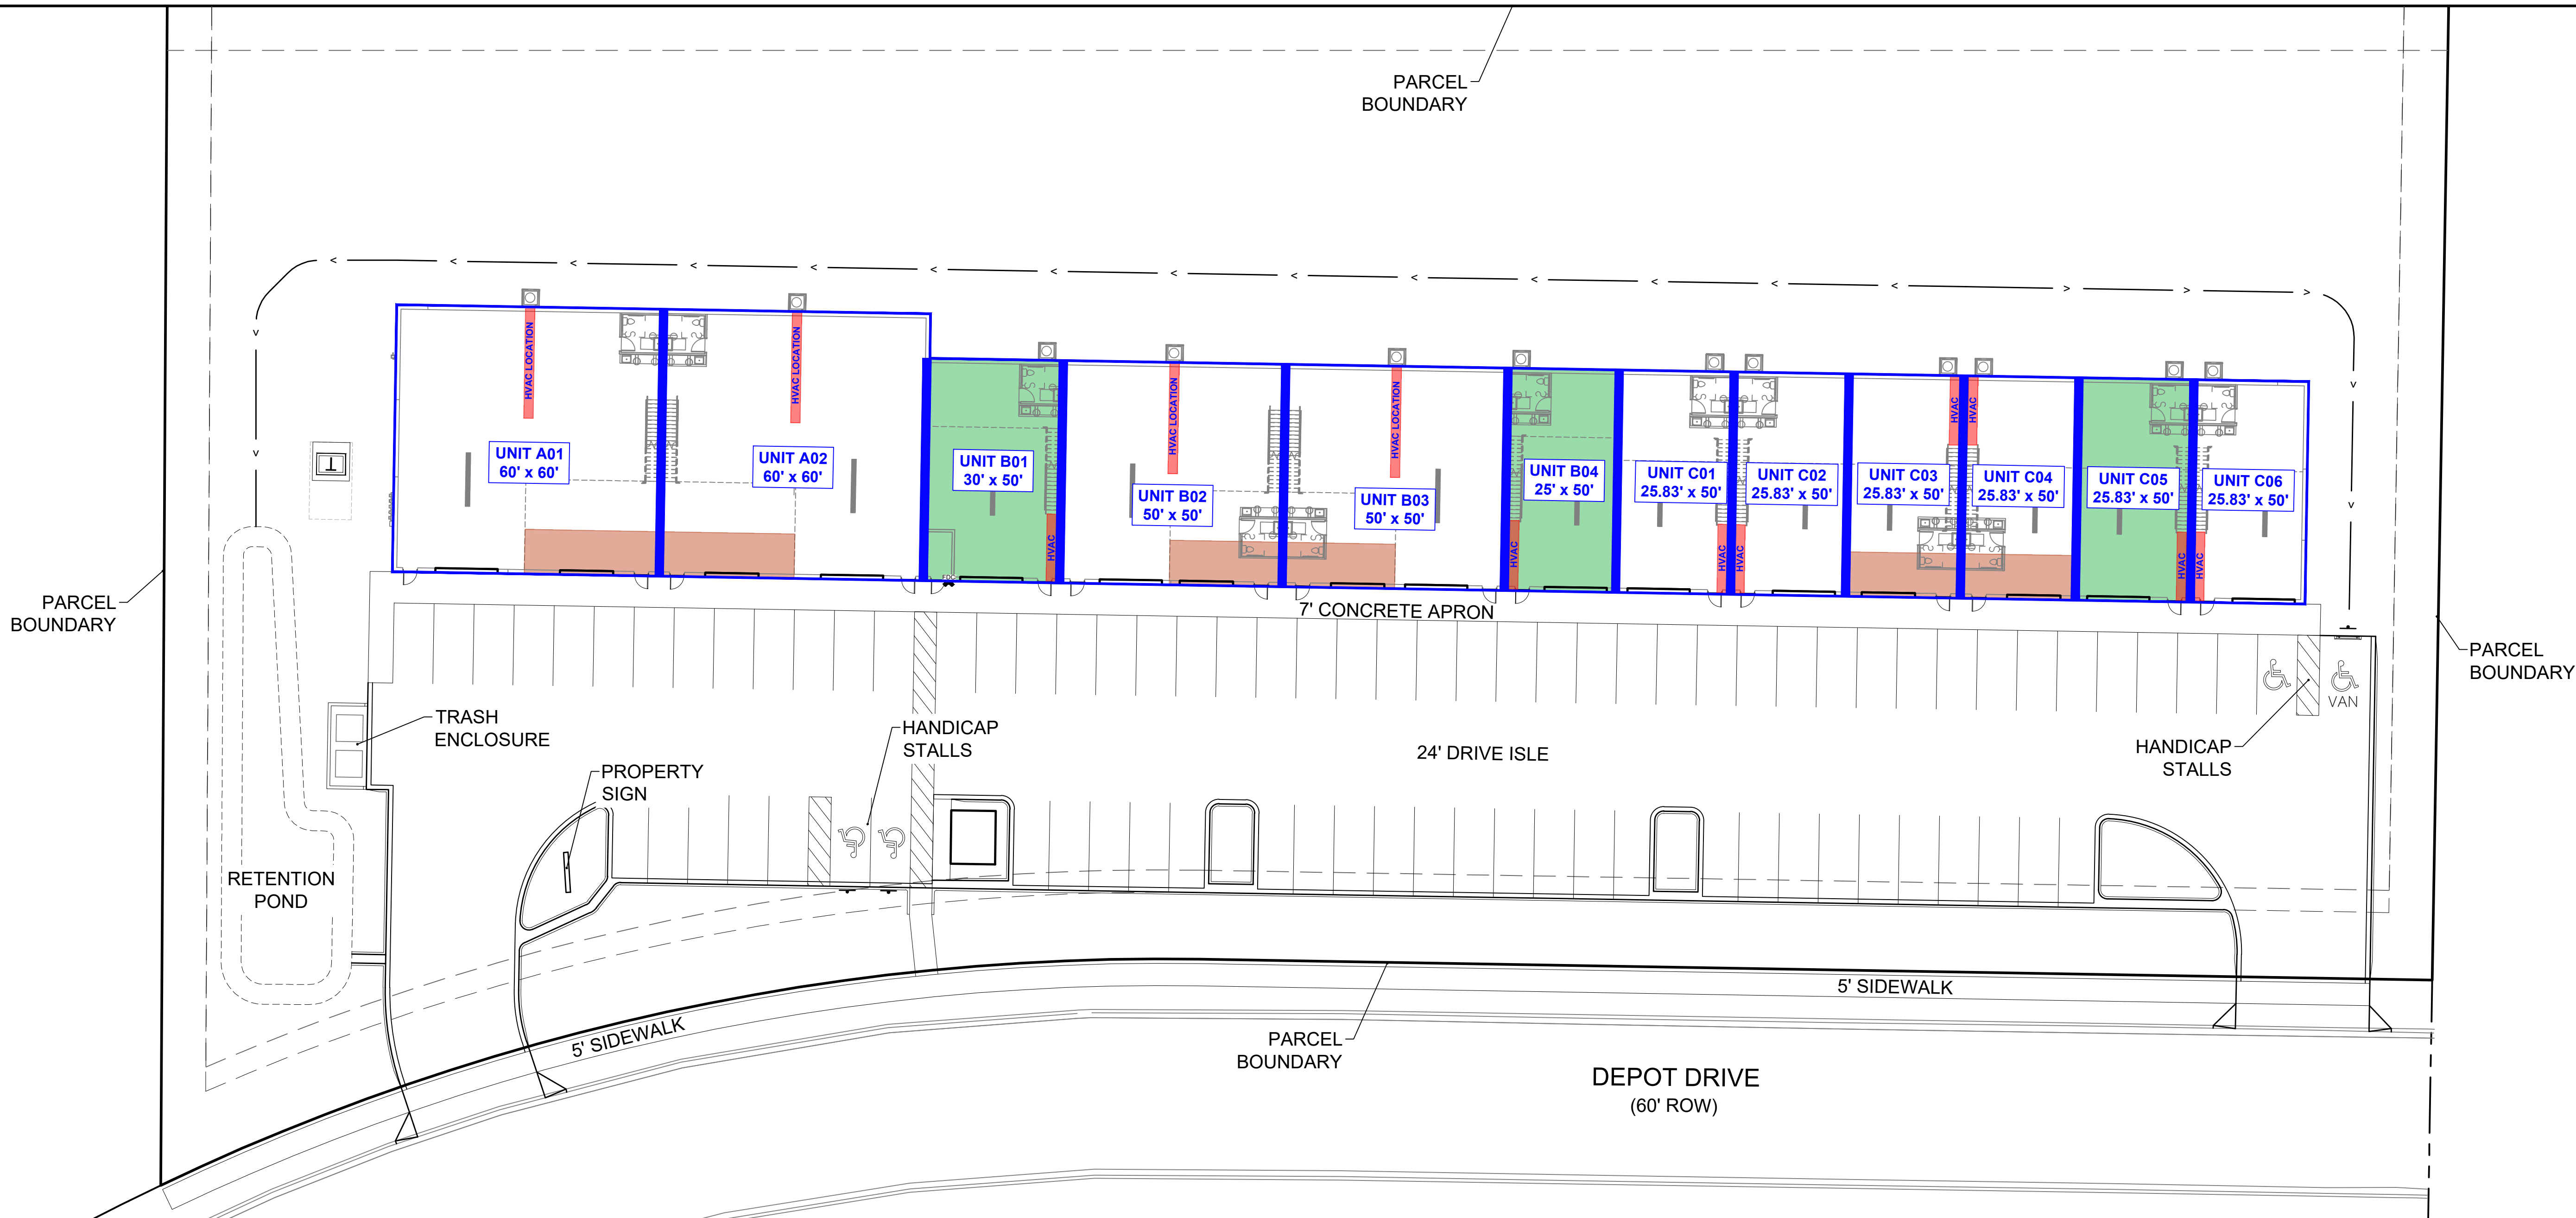

TRACT 2, YELLOWSTONE AIRPORT PLAZA
BELGRADE, MONTANA

SHEET TITLE
MARKETING
PLAN

MARKETING SITE PLAN

HERE CIVIL
CONSULTANTS

PHONE: (336) 554-2424
EMAIL: RMANPATEE@HERECC.COM
HERE CC PROJECT NO: PW-001

PERSONAL
WAREHOUSE
WORK • STORE • PLAY

DESIGNED BY: RJN DRAWN BY: RJN CHECKED BY: RJN

CALL 811 BEFORE YOU DIG