


Legend

IP Camera	27
Network Jack	7
Phone & Network Jack	6
Phone & Network Floor Jack	2
Smoke Detector	14
Heat Detector	6
CO Detector	4
Pull Station	4
Horn & Strobe	10
Visual Strobe	6
Pin & Prox Reader	8
Door Strike	4
Push Bar Door Strike	2
Wiring for Push Bar	2

ROOM SCHEDULE 1

ROOM NUMBER	ROOM NAME	Area
001	Conference room 1	435 SF
002	Hallway	96 SF
003	Office	98 SF
004	Office	78 SF
005	Womens	118 SF
006	Mens	118 SF
007	Break room	162 SF
008	Entry	59 SF
009	Warehouse 2	10367 SF
010	Warehouse 2	2848 SF
012	Warehouse 1	10382 SF
013	Warehouse 1	4082 SF
014	Conference room 2	433 SF
015	Break room	162 SF
016	Mens	118 SF
017	Womens	118 SF
018	Entry	59 SF
019	Office	98 SF
020	Office	78 SF
021	Hallway	96 SF
022	CLOSET 1	11 SF

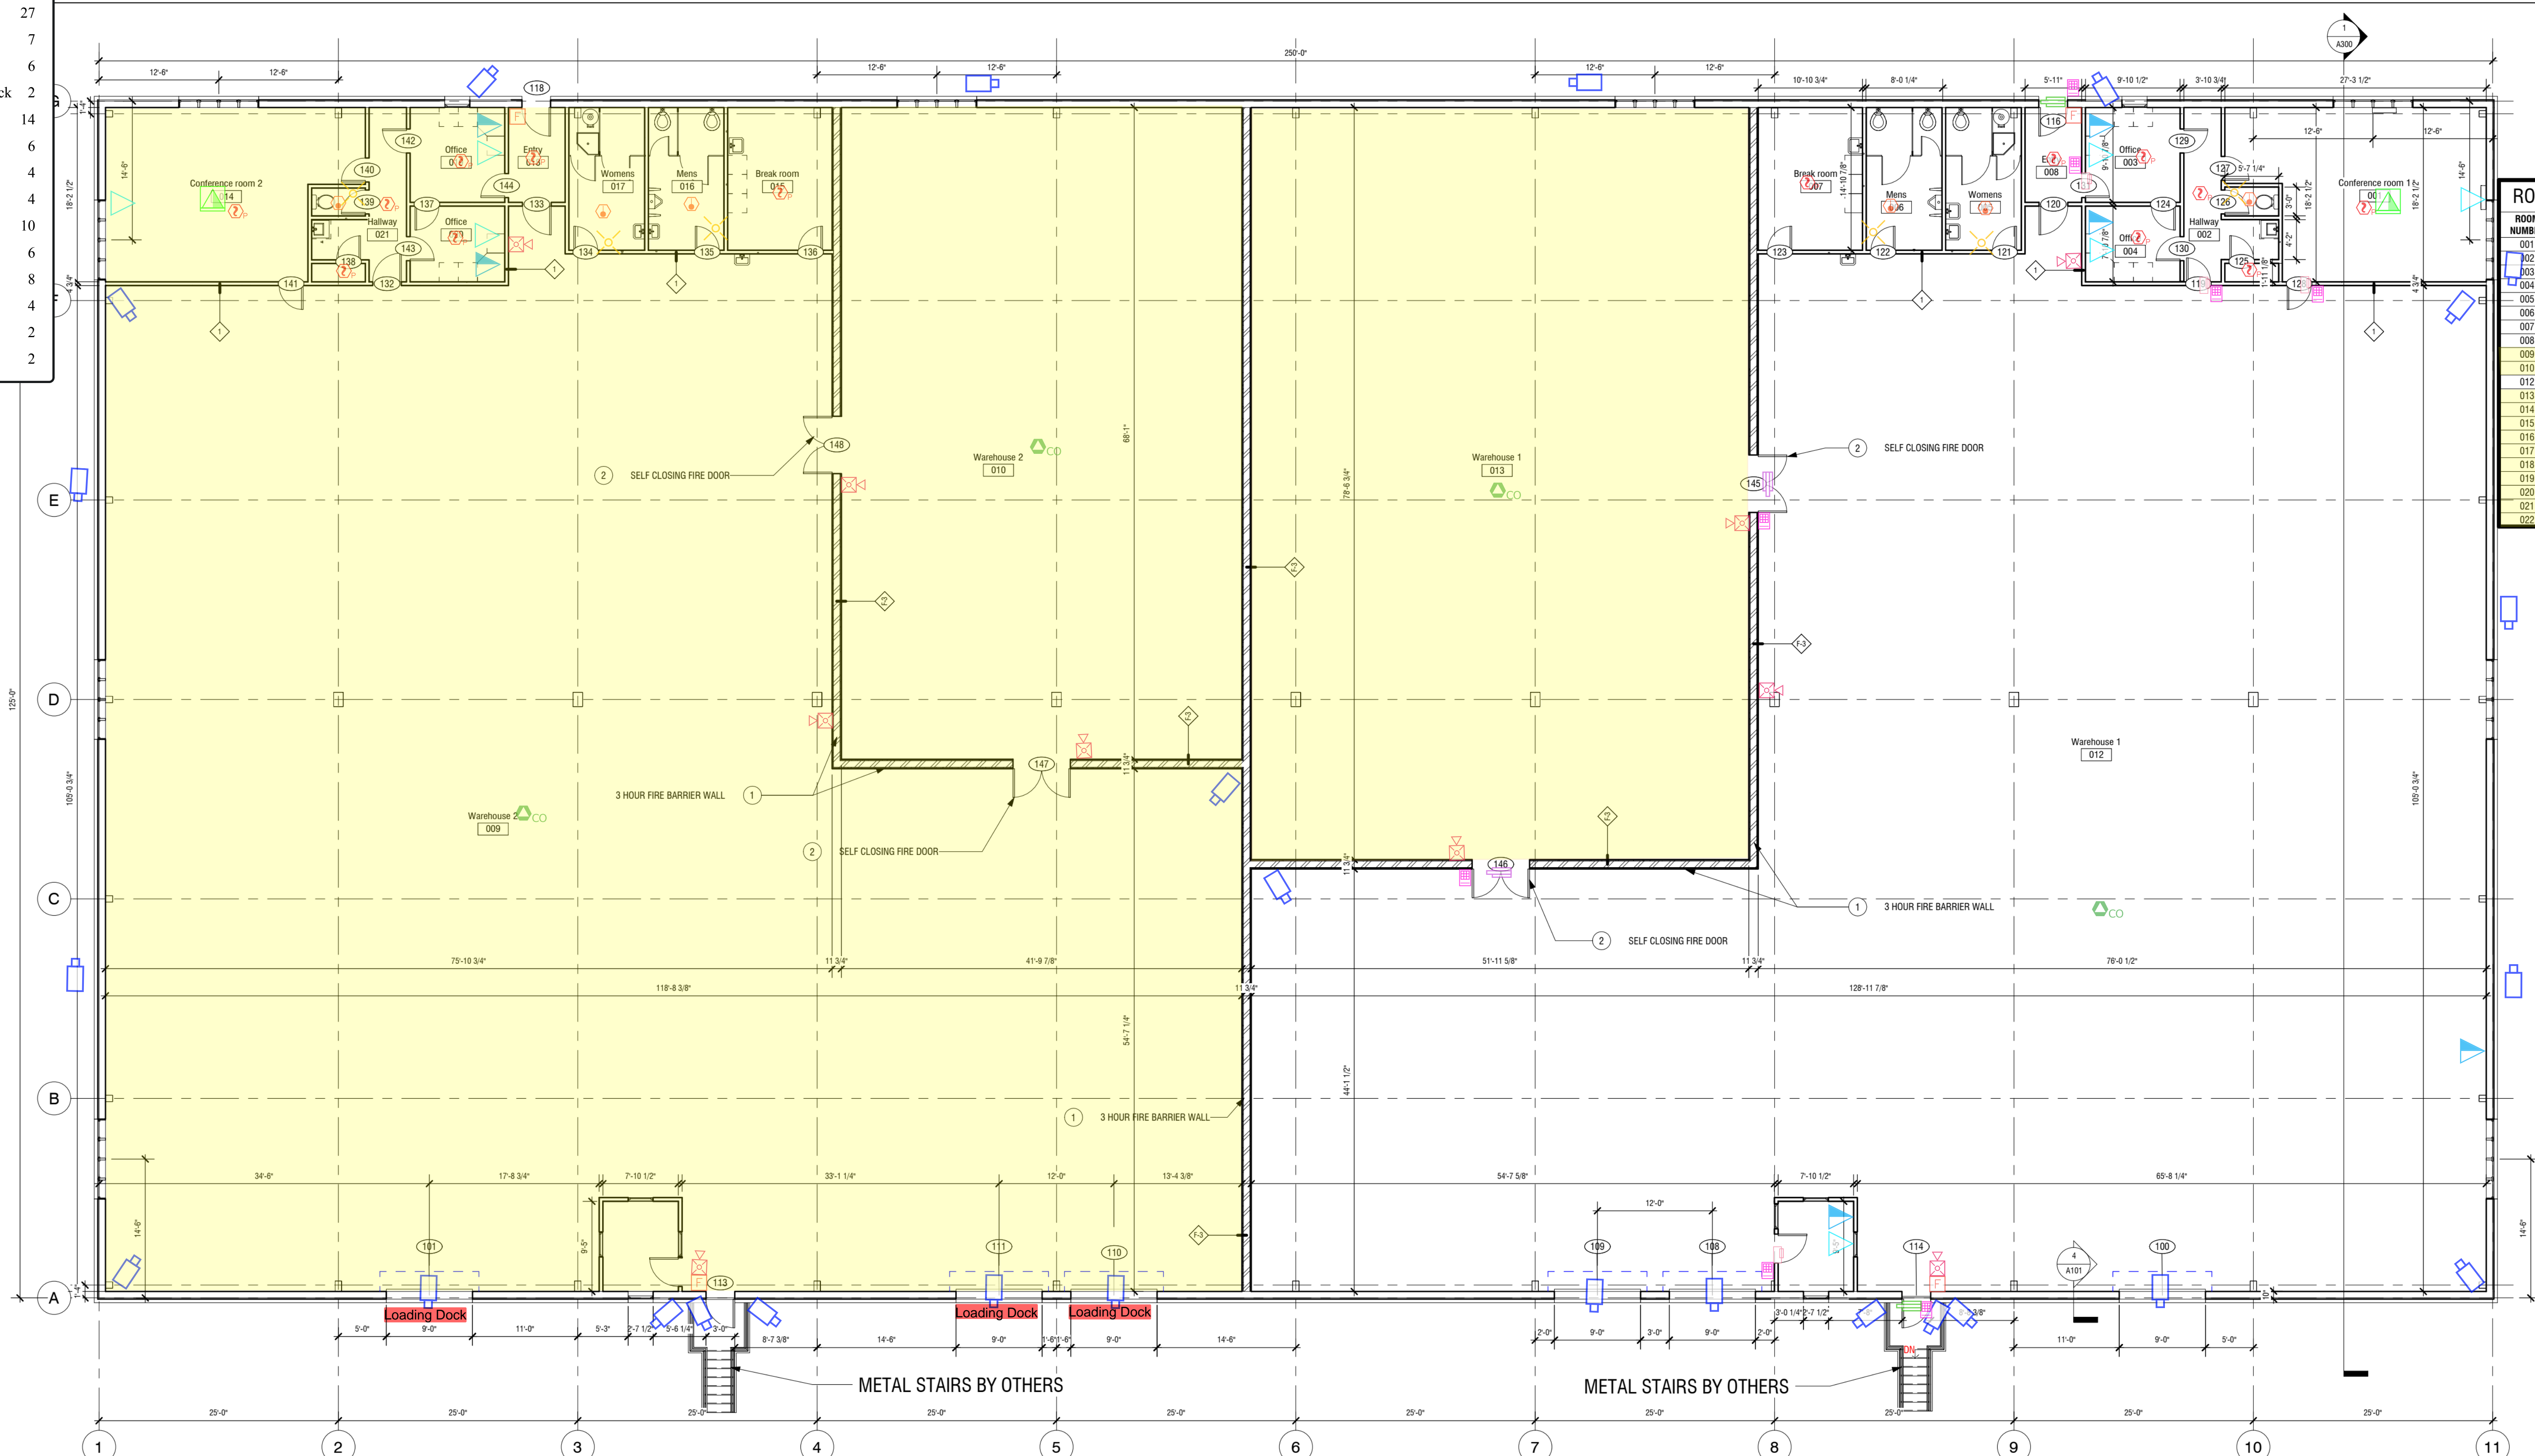

1 LEVEL 1 FLOOR PLAN
1/8" = 1'-0"

FLOOR PLAN NOTES

NO.	DESCRIPTION
1	3 HOUR FIRE BARRIER WALL
2	SELF CLOSING FIRE DOOR



PRO.ARCHITECH@GMAIL.COM



CONSULTANT
HERMAN FISHER ASSOCIATE AIA
3 FRANKFURT RD # 302
MONROE N.Y. 10950
845-537-6001

STRUCTURAL ENGINEER:

REVISIONS:

NO.	DESCRIPTION	DATE

CLIENT NAME:
RGM NY LLC

PROJECT NAME:
WAREHOUSE

SHEET NUMBER:
A100

SHEET NAME:
FLOOR PLAN

PROJECT NUMBER: DATE: **0001** Issue Date

CHECKED BY: **3** DRAWN BY: Checker

2/15/2022 9:54:01 PM