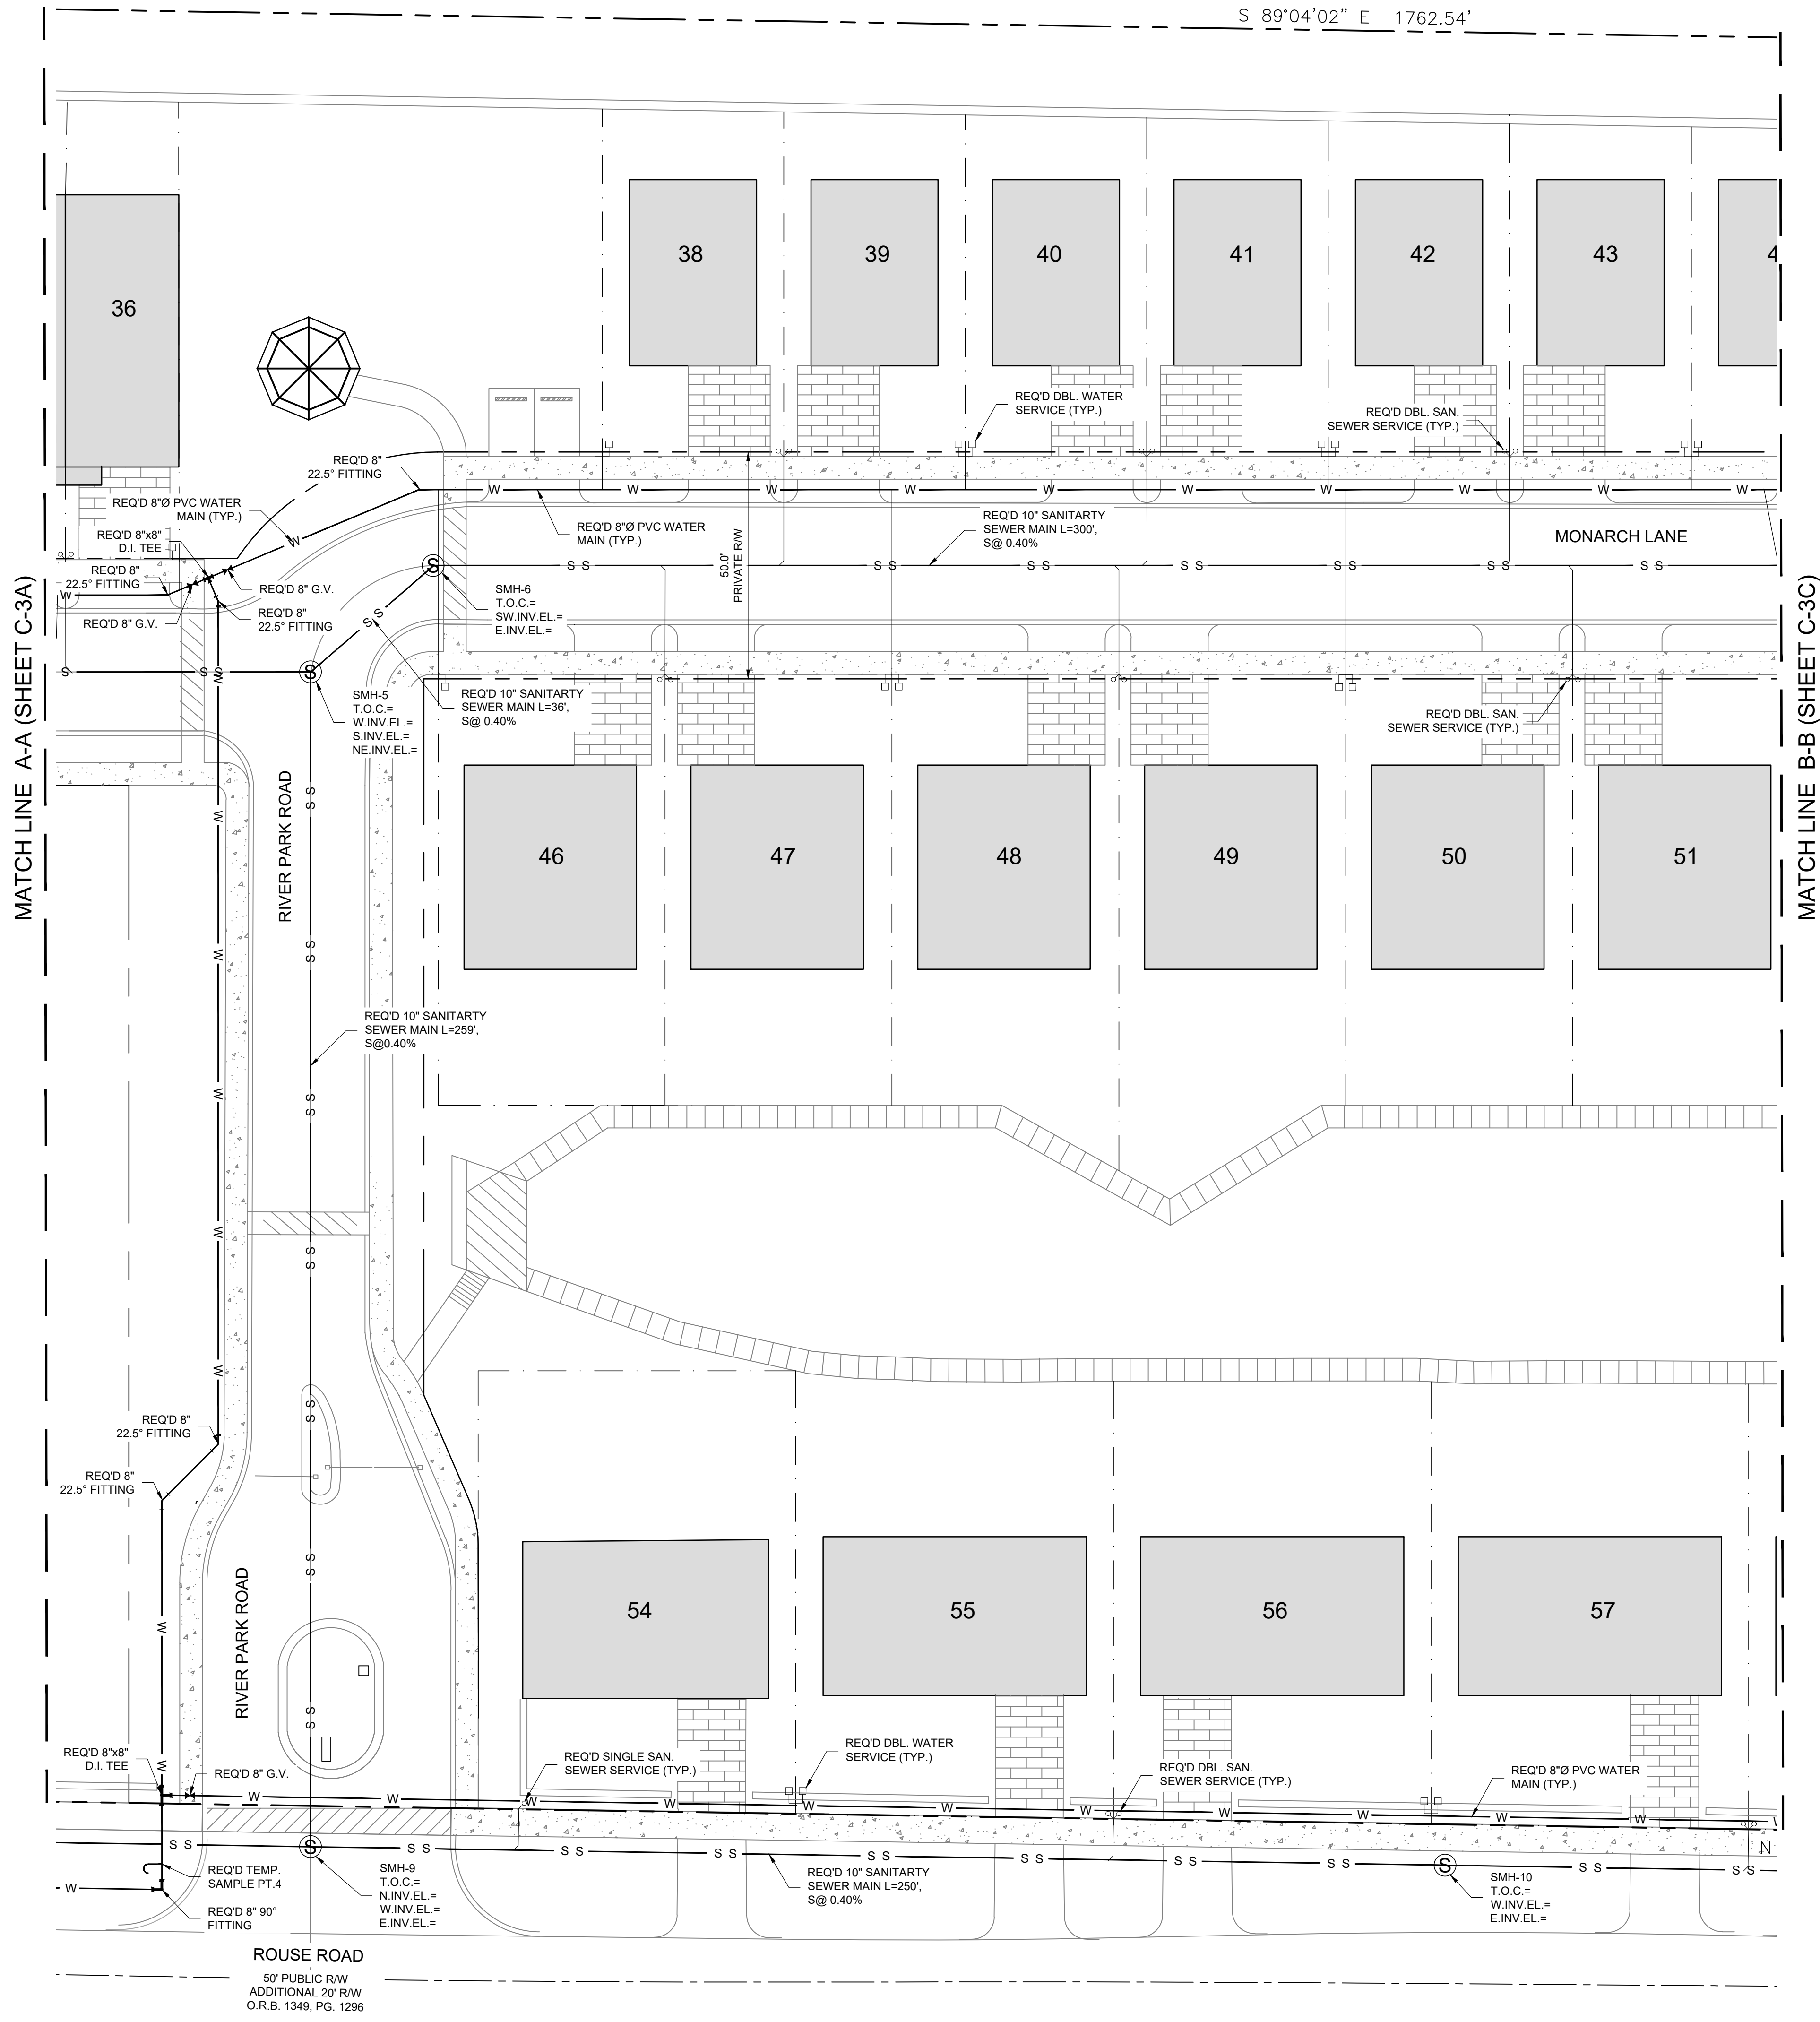


Sanitary Sewer						
Inlet	Type	Top	Pipe Length	Inlet		
				North	South	
S-1	SMH					
S-2	SMH					
S-3	SMH					
S-4	SMH					
S-5	SMH					
S-6	SMH					
S-7	SMH					
S-8	SMH					
S-9	SMH					
S-10	SMH					
S-11	SMH					
S-12	SMH					
S-13	SMH					
S-14	SMH					

Mills, Short & Associates

WEBSITE: www.MillsShortAssociates.com

PHONE: 772.226.7282

C.A. #: 30698

700 22nd Place, Suite 2C/2D

Vero Beach, Florida 32960

SEAL

ISSUE	DATE	COMMENTS

SANCTUARY COVE

250 ROUSE

FORT PIERCE, FL 34946

THIS SHEET UTILITY PLAN

DRAWN BY WBD

PROJ. NO. 21-XXXX

DATE 04-21-2023

SHEET NO.

CHECKED BY JWM

APPROVED BY JWM

SCALE: SEE SHEET

C-3B