

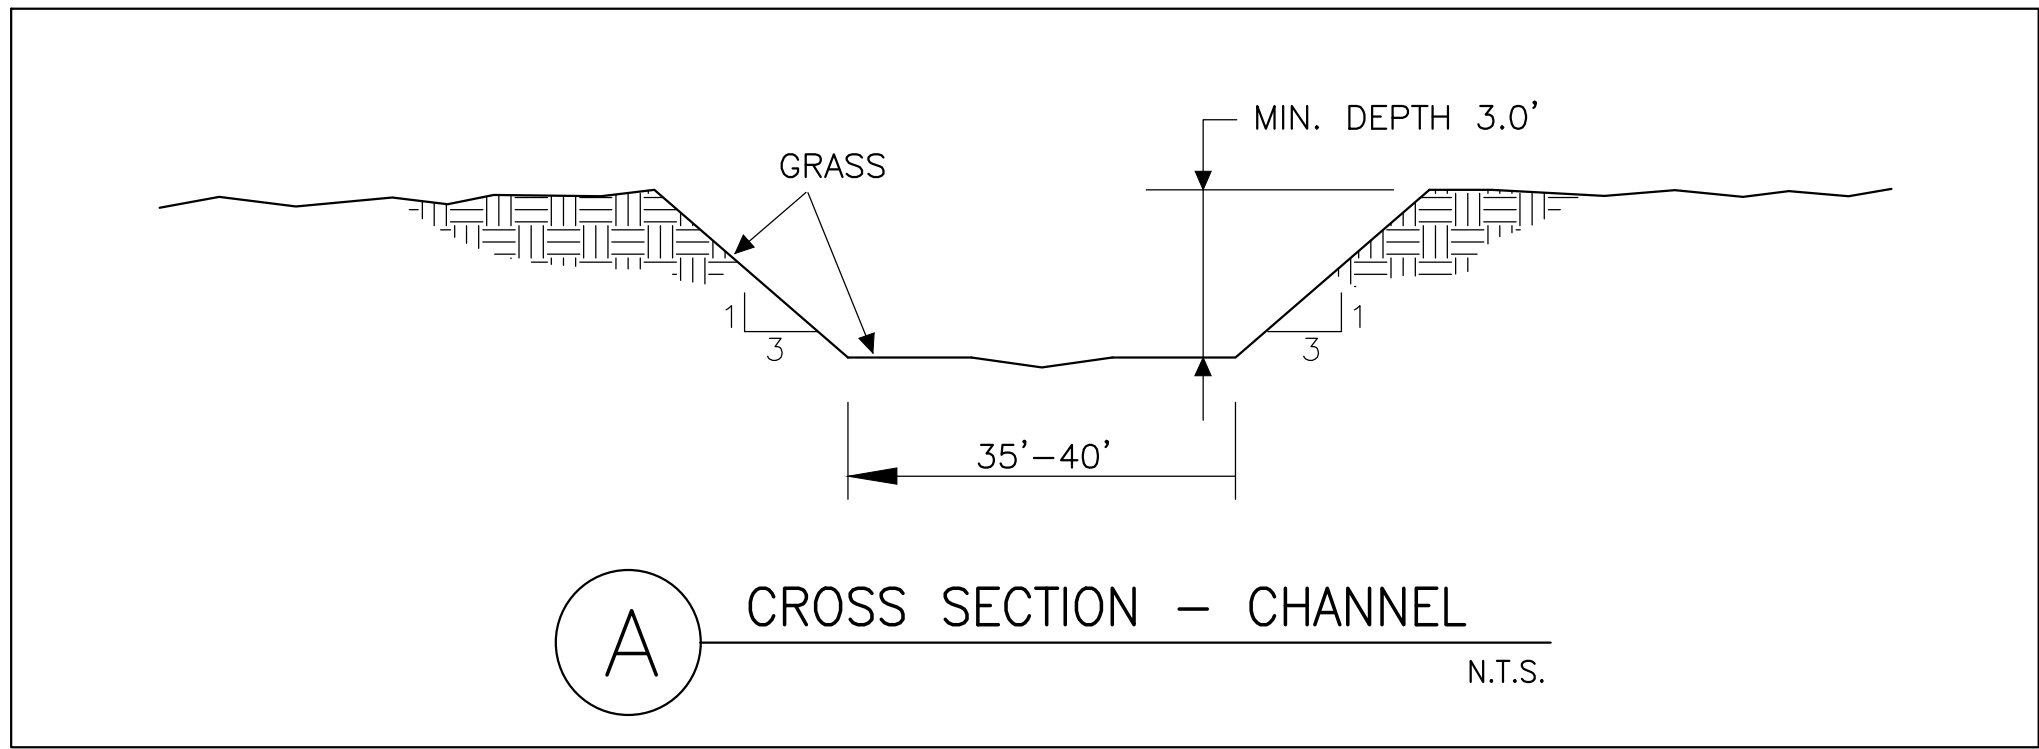


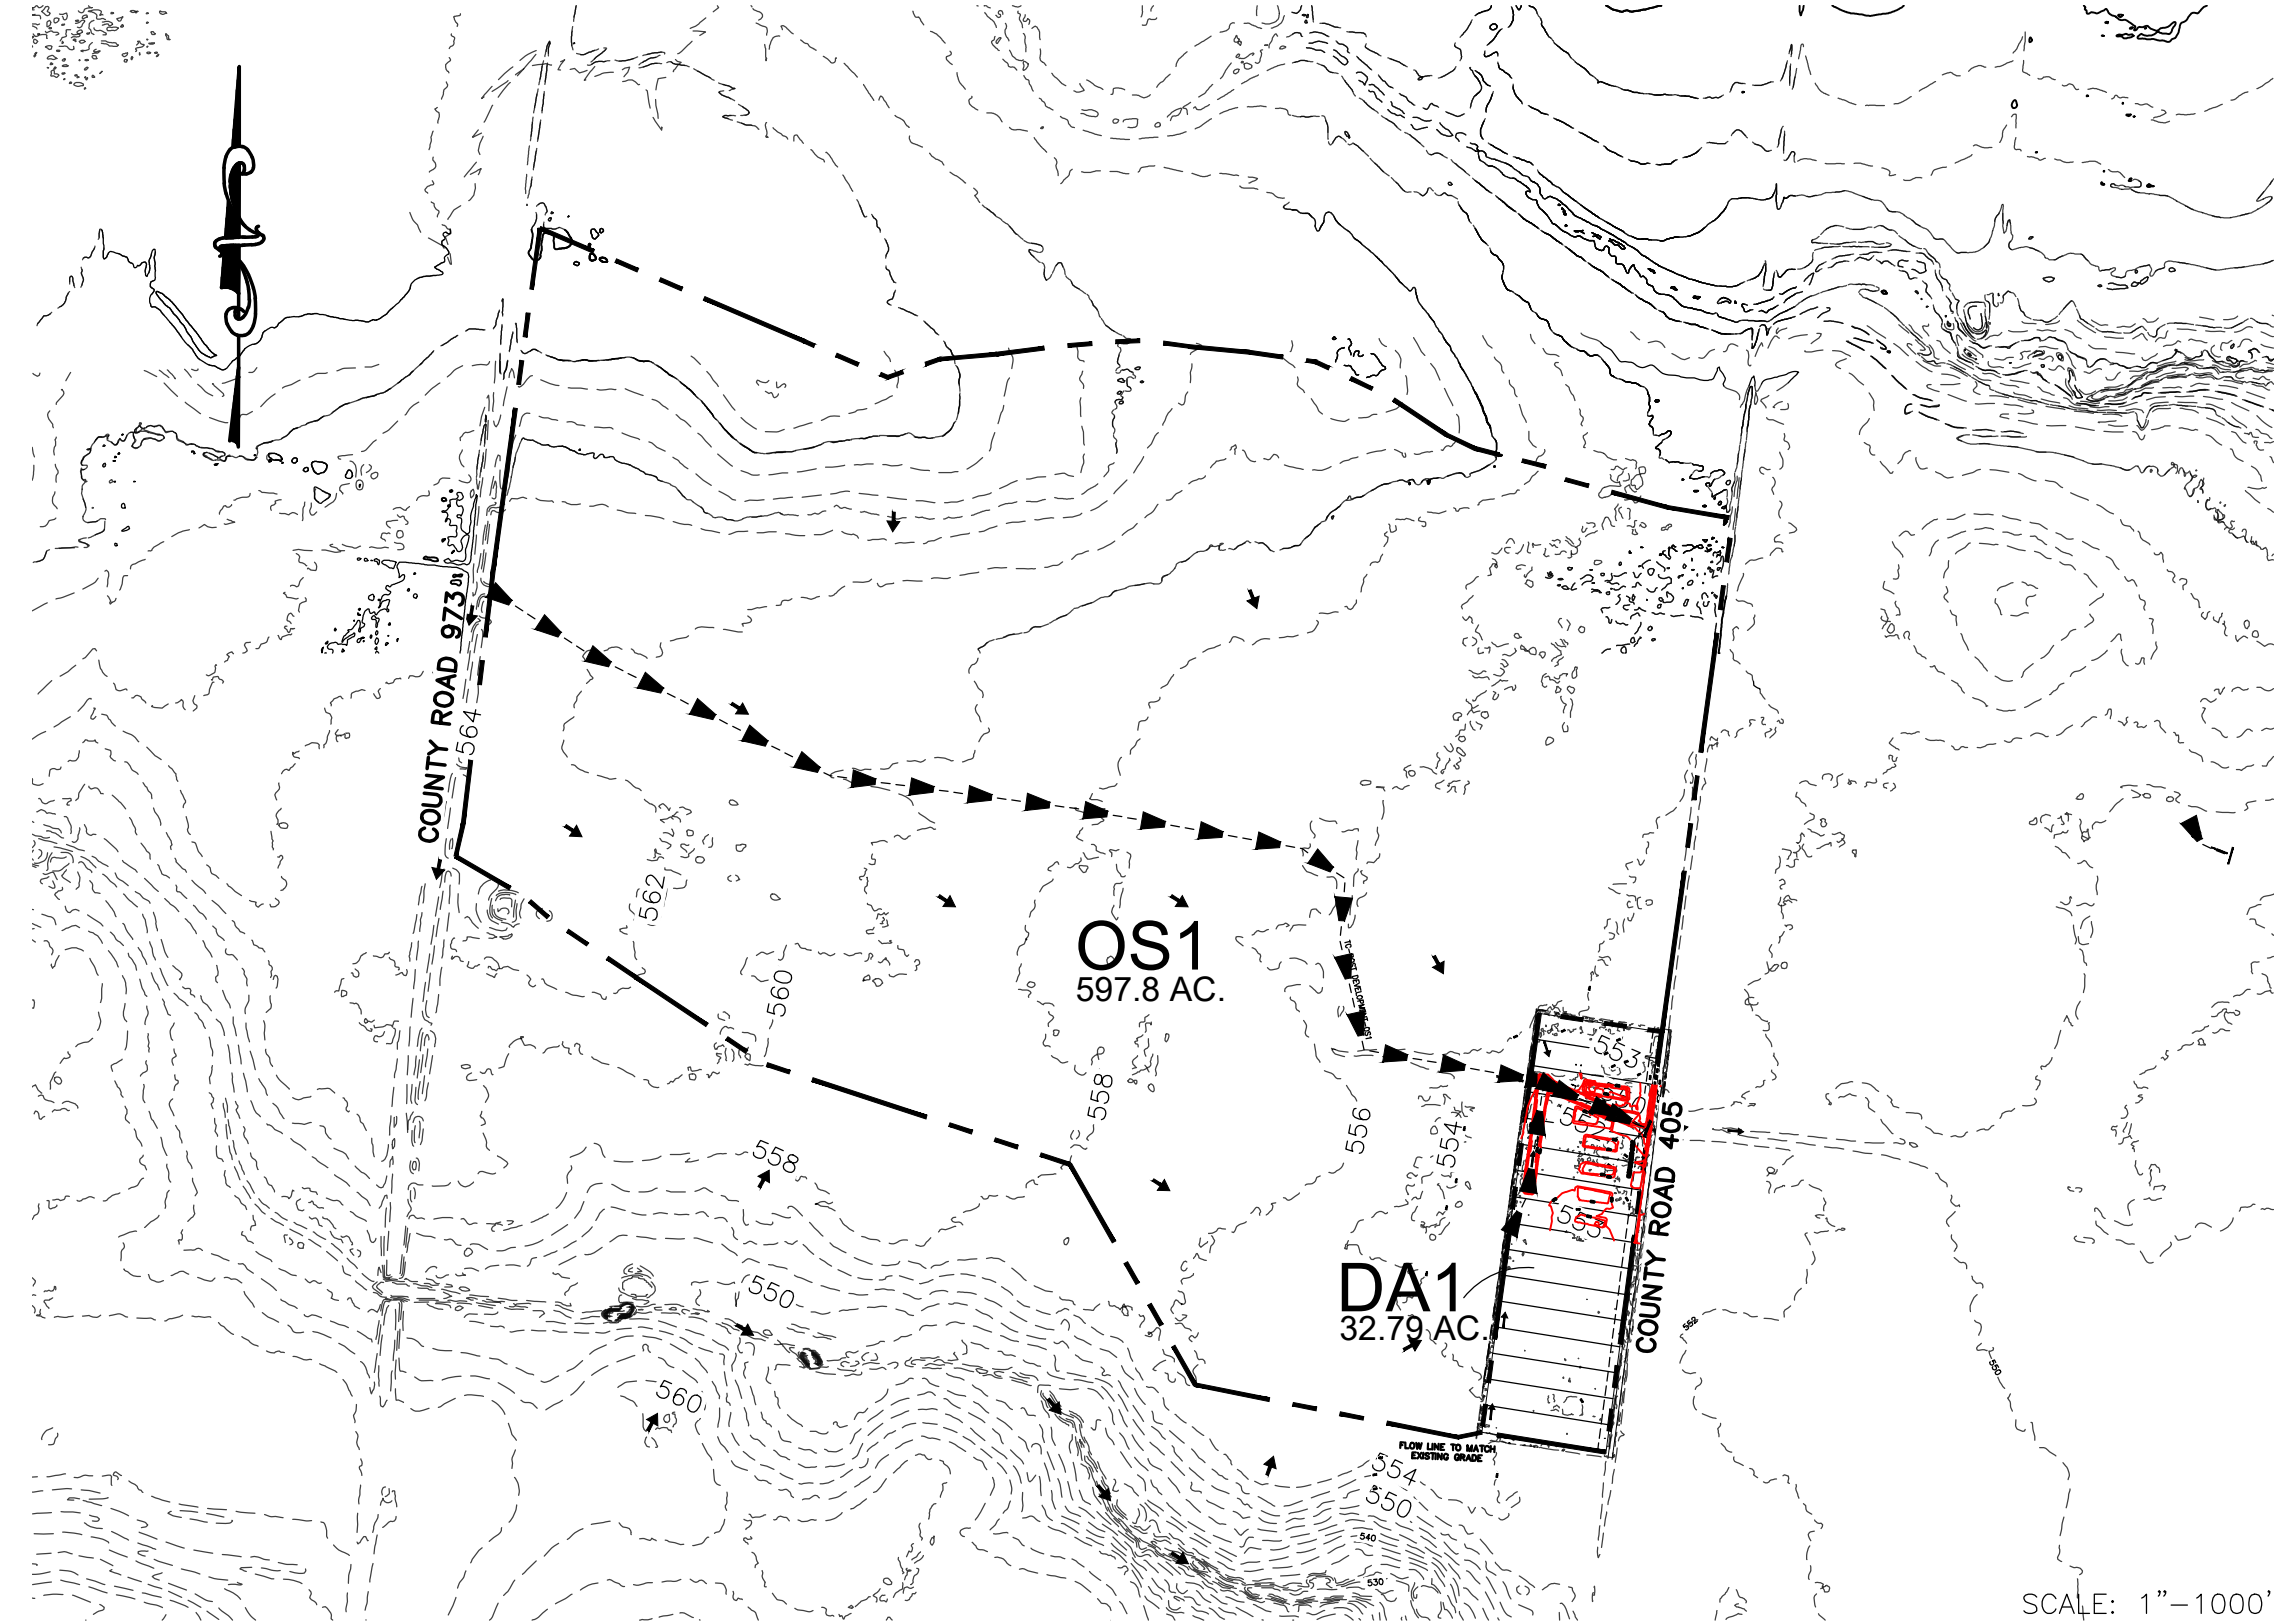


- DRAINAGE LAYOUT STANDARD NOTES:**
1. THE BUILDER, THROUGH HIS ENGINEER OR AUTHORIZED REPRESENTATIVE, SHALL ACQUIRE ALL REQUIRED NATIONWIDE PERMITS, SUCH AS CWA 401, 402 AND/OR 404 PERMITS, AS APPROPRIATE, FROM THE USEPA.
 2. OFF-SITE TOPOGRAPHICAL INFORMATION IS PRESENTED FOR DRAINAGE ANALYSIS PURPOSES ONLY AND IS NOT TO BE USED FOR CONSTRUCTION.
 3. TOPOGRAPHICAL INFORMATION PRESENTED HEREIN IS DERIVED FROM AN ON-SITE SURVEY CONDUCTED ON MARCH 17, 2018 BY TEXAS LAND SURVEYING INC.
 4. CHANNEL TRANSITION SHALL START 75' UPSTREAM OF THE PROPOSED DRIVEWAY CROSSING.
 5. NO FILL SHALL BE PLACED WITHIN EXISTING CHANNEL BOUNDARIES.
 6. NO PERMANENT STRUCTURE THAT OBSTRUCTS THE DRAINAGE, SHALL OCCUR WITHIN EXISTING CHANNEL BOUNDARIES.
 7. ALL HOUSE PADS SHALL MAINTAIN POSITIVE DRAINAGE AWAY FROM PAD AT MINIMUM OF 5% (SLOPE), FOR A MINIMUM DISTANCE OF 10' AROUND THE PERIMETER.
 8. DEVELOPER MUST MAINTAIN CHANNELS MOWED AND FREE OF SILT TO ASSURE PROPER DRAINAGE AND AVOID PONDING.

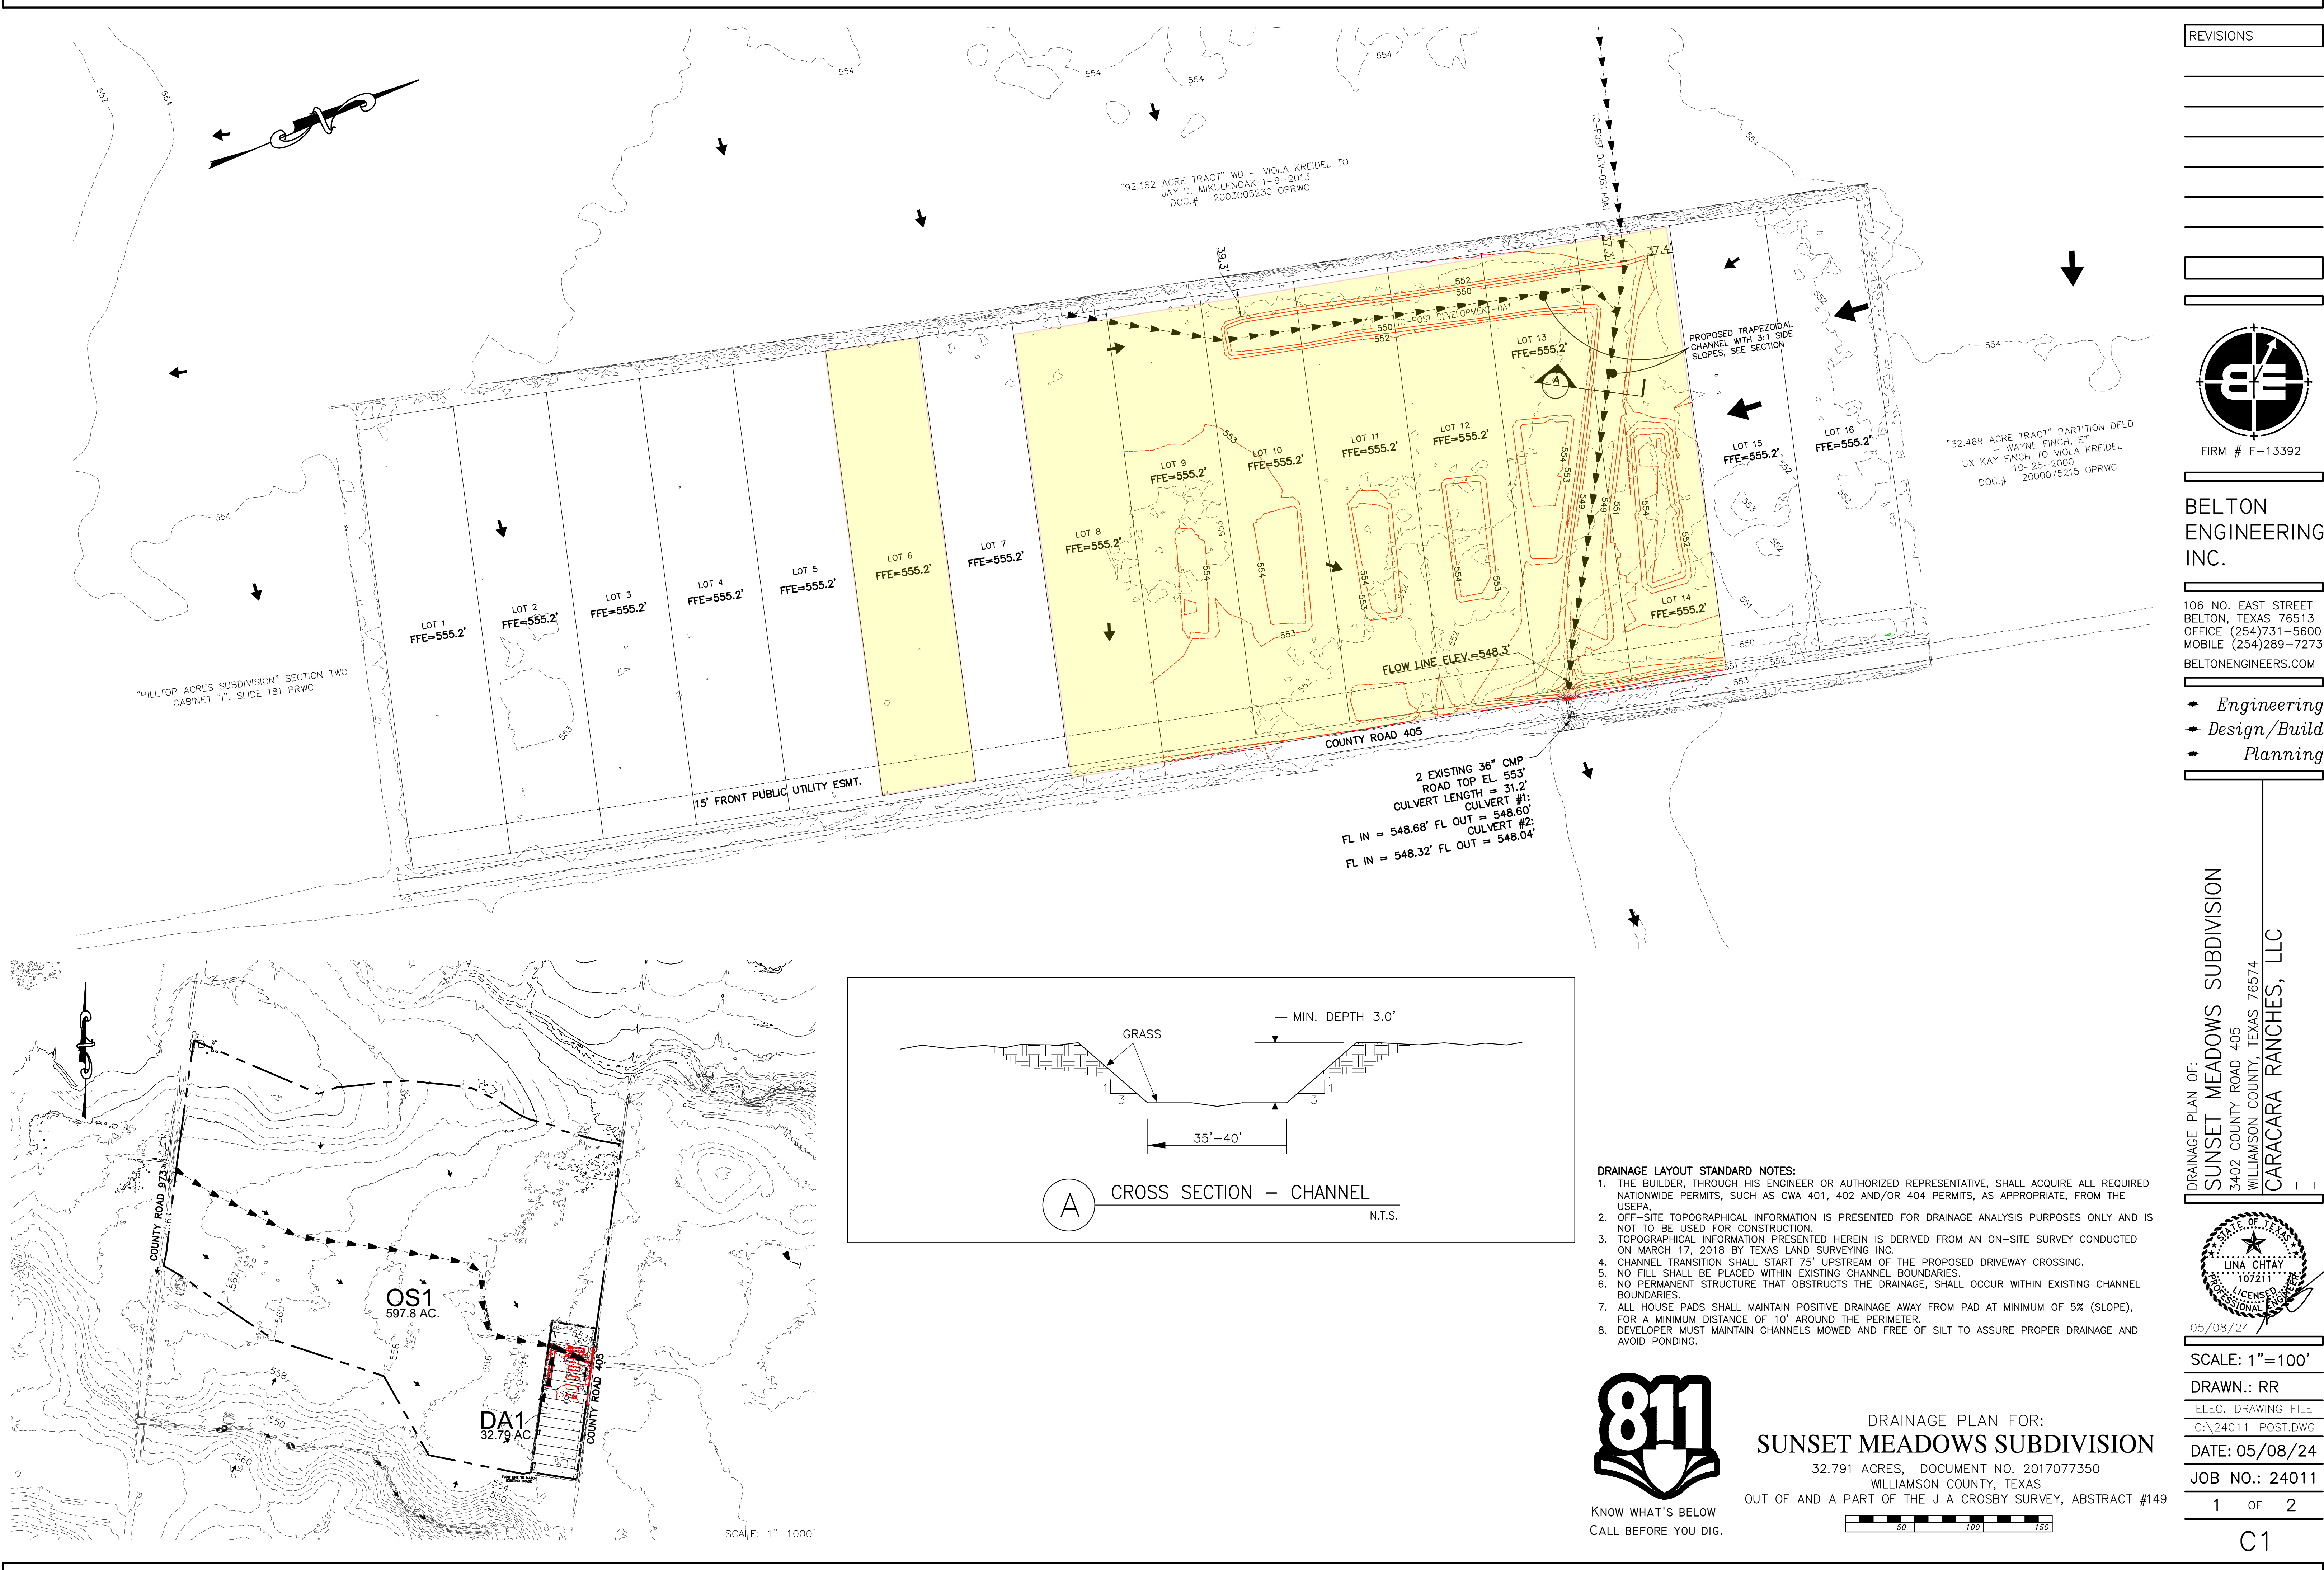


DRAINAGE PLAN FOR:
SUNSET MEADOWS SUBDIVISION

 32.791 ACRES, DOCUMENT NO. 2017077350
WILLIAMSON COUNTY, TEXAS
OUT OF AND A PART OF THE J A CROSBY SURVEY, ABSTRACT #149



REVISIONS

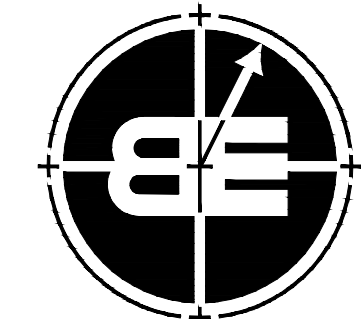


FIRM # F-13392

**BELTON
ENGINEERING
INC.**

106 NO. EAST STREET
BELTON, TEXAS 76513
OFFICE (254)731-5600
MOBILE (254)289-7273
BELTONENGINEERS.COM

• *Engineering*
• *Design/Build*
• *Planning*

DRAINAGE PLAN OF:
SUNSET MEADOWS SUBDIVISION
3402 COUNTY ROAD 405
WILLIAMSON COUNTY, TEXAS 76574
CARACARA RANCHES, LLC

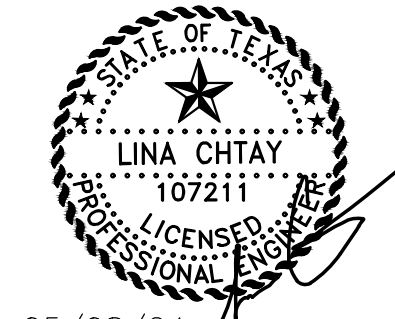

05/08/24

SCALE: 1"=100'

DRAWN.: RR

ELEC. DRAWING FILE
C:\24011-POST.DWG

DATE: 05/08/24

JOB NO.: 24011

1 OF 2

C1