


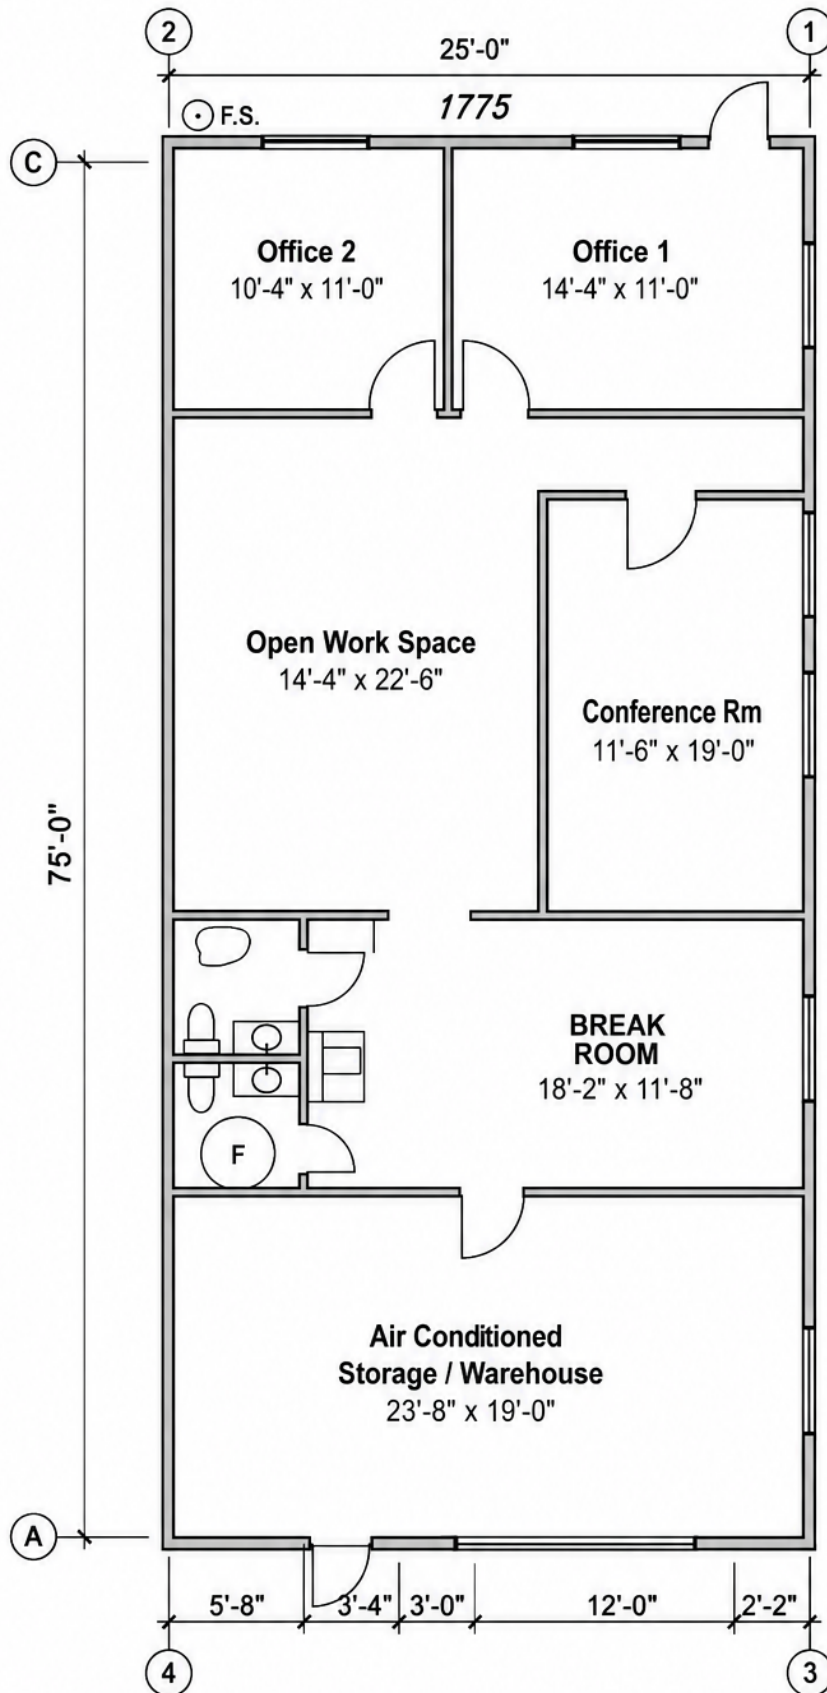

FLOOR PLAN

1775 (Address/ID)

Scale: 1/8" = 1'-0"

LEGEND

- F.E. Fire Extinguisher
- F.S. Floor Sink