



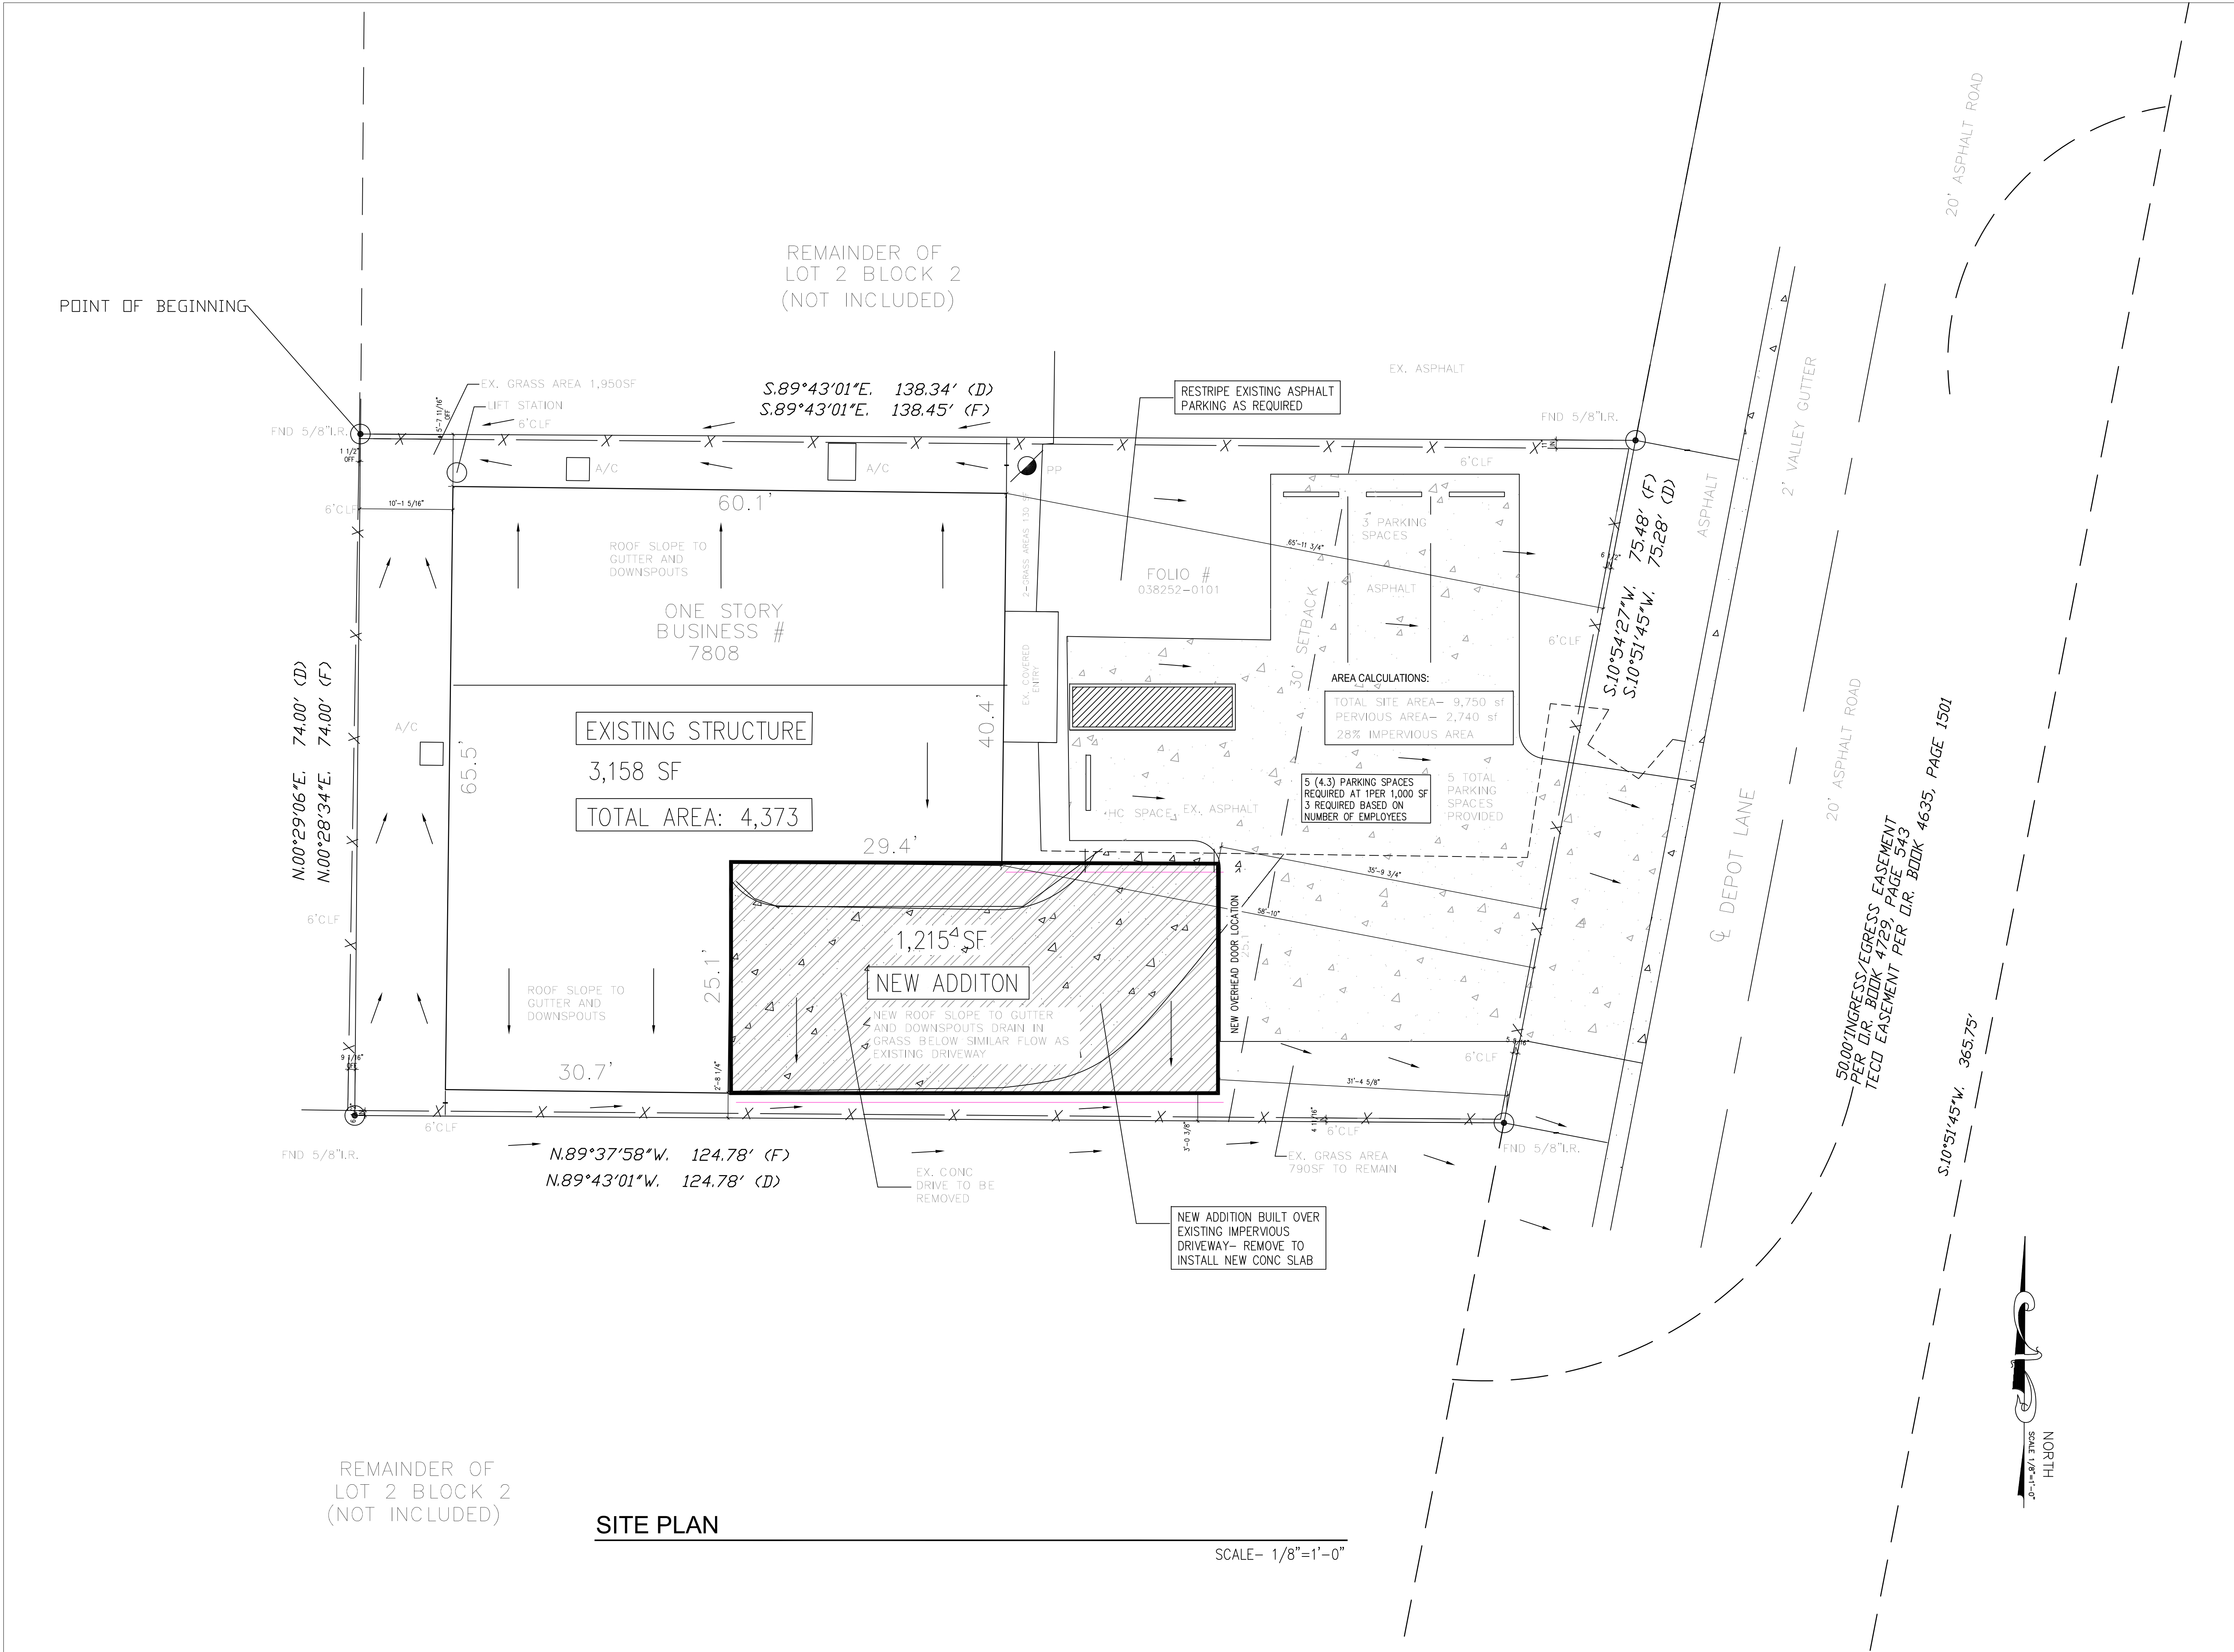

NO.	DESCRIPTION	DATE



Due Amici Warehouse Building Addition	7808 Depot Lane Tampa Florida 33637
--	-------------------------------------

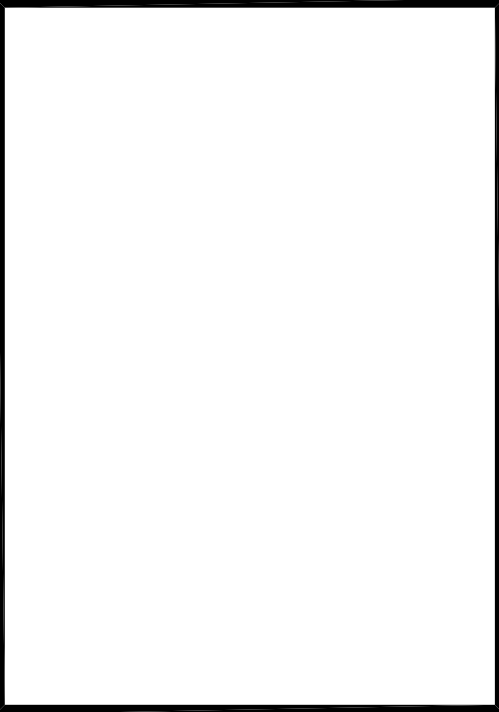




ARCHITECTS
KREHER WEHLING JACQUETTE
1923 E 7th AVE
TAMPA FLORIDA 33605
TEL: 813.760.1588
GREG@WEHLING.COM
AR 0091800

SEAL


GREGORY T WEHLING, AIA
AR 0091800


SHEET TITLE:
SITE PLAN- PROPOSED ADDITON
DATE: 11/29/21
SCALE: AS SHOWN
SHEET NO.: AS-001

7808 Depot Lane Tampa Florida 33637

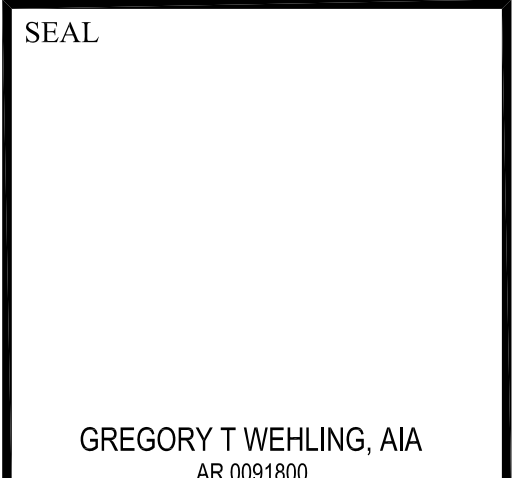

A-101

 

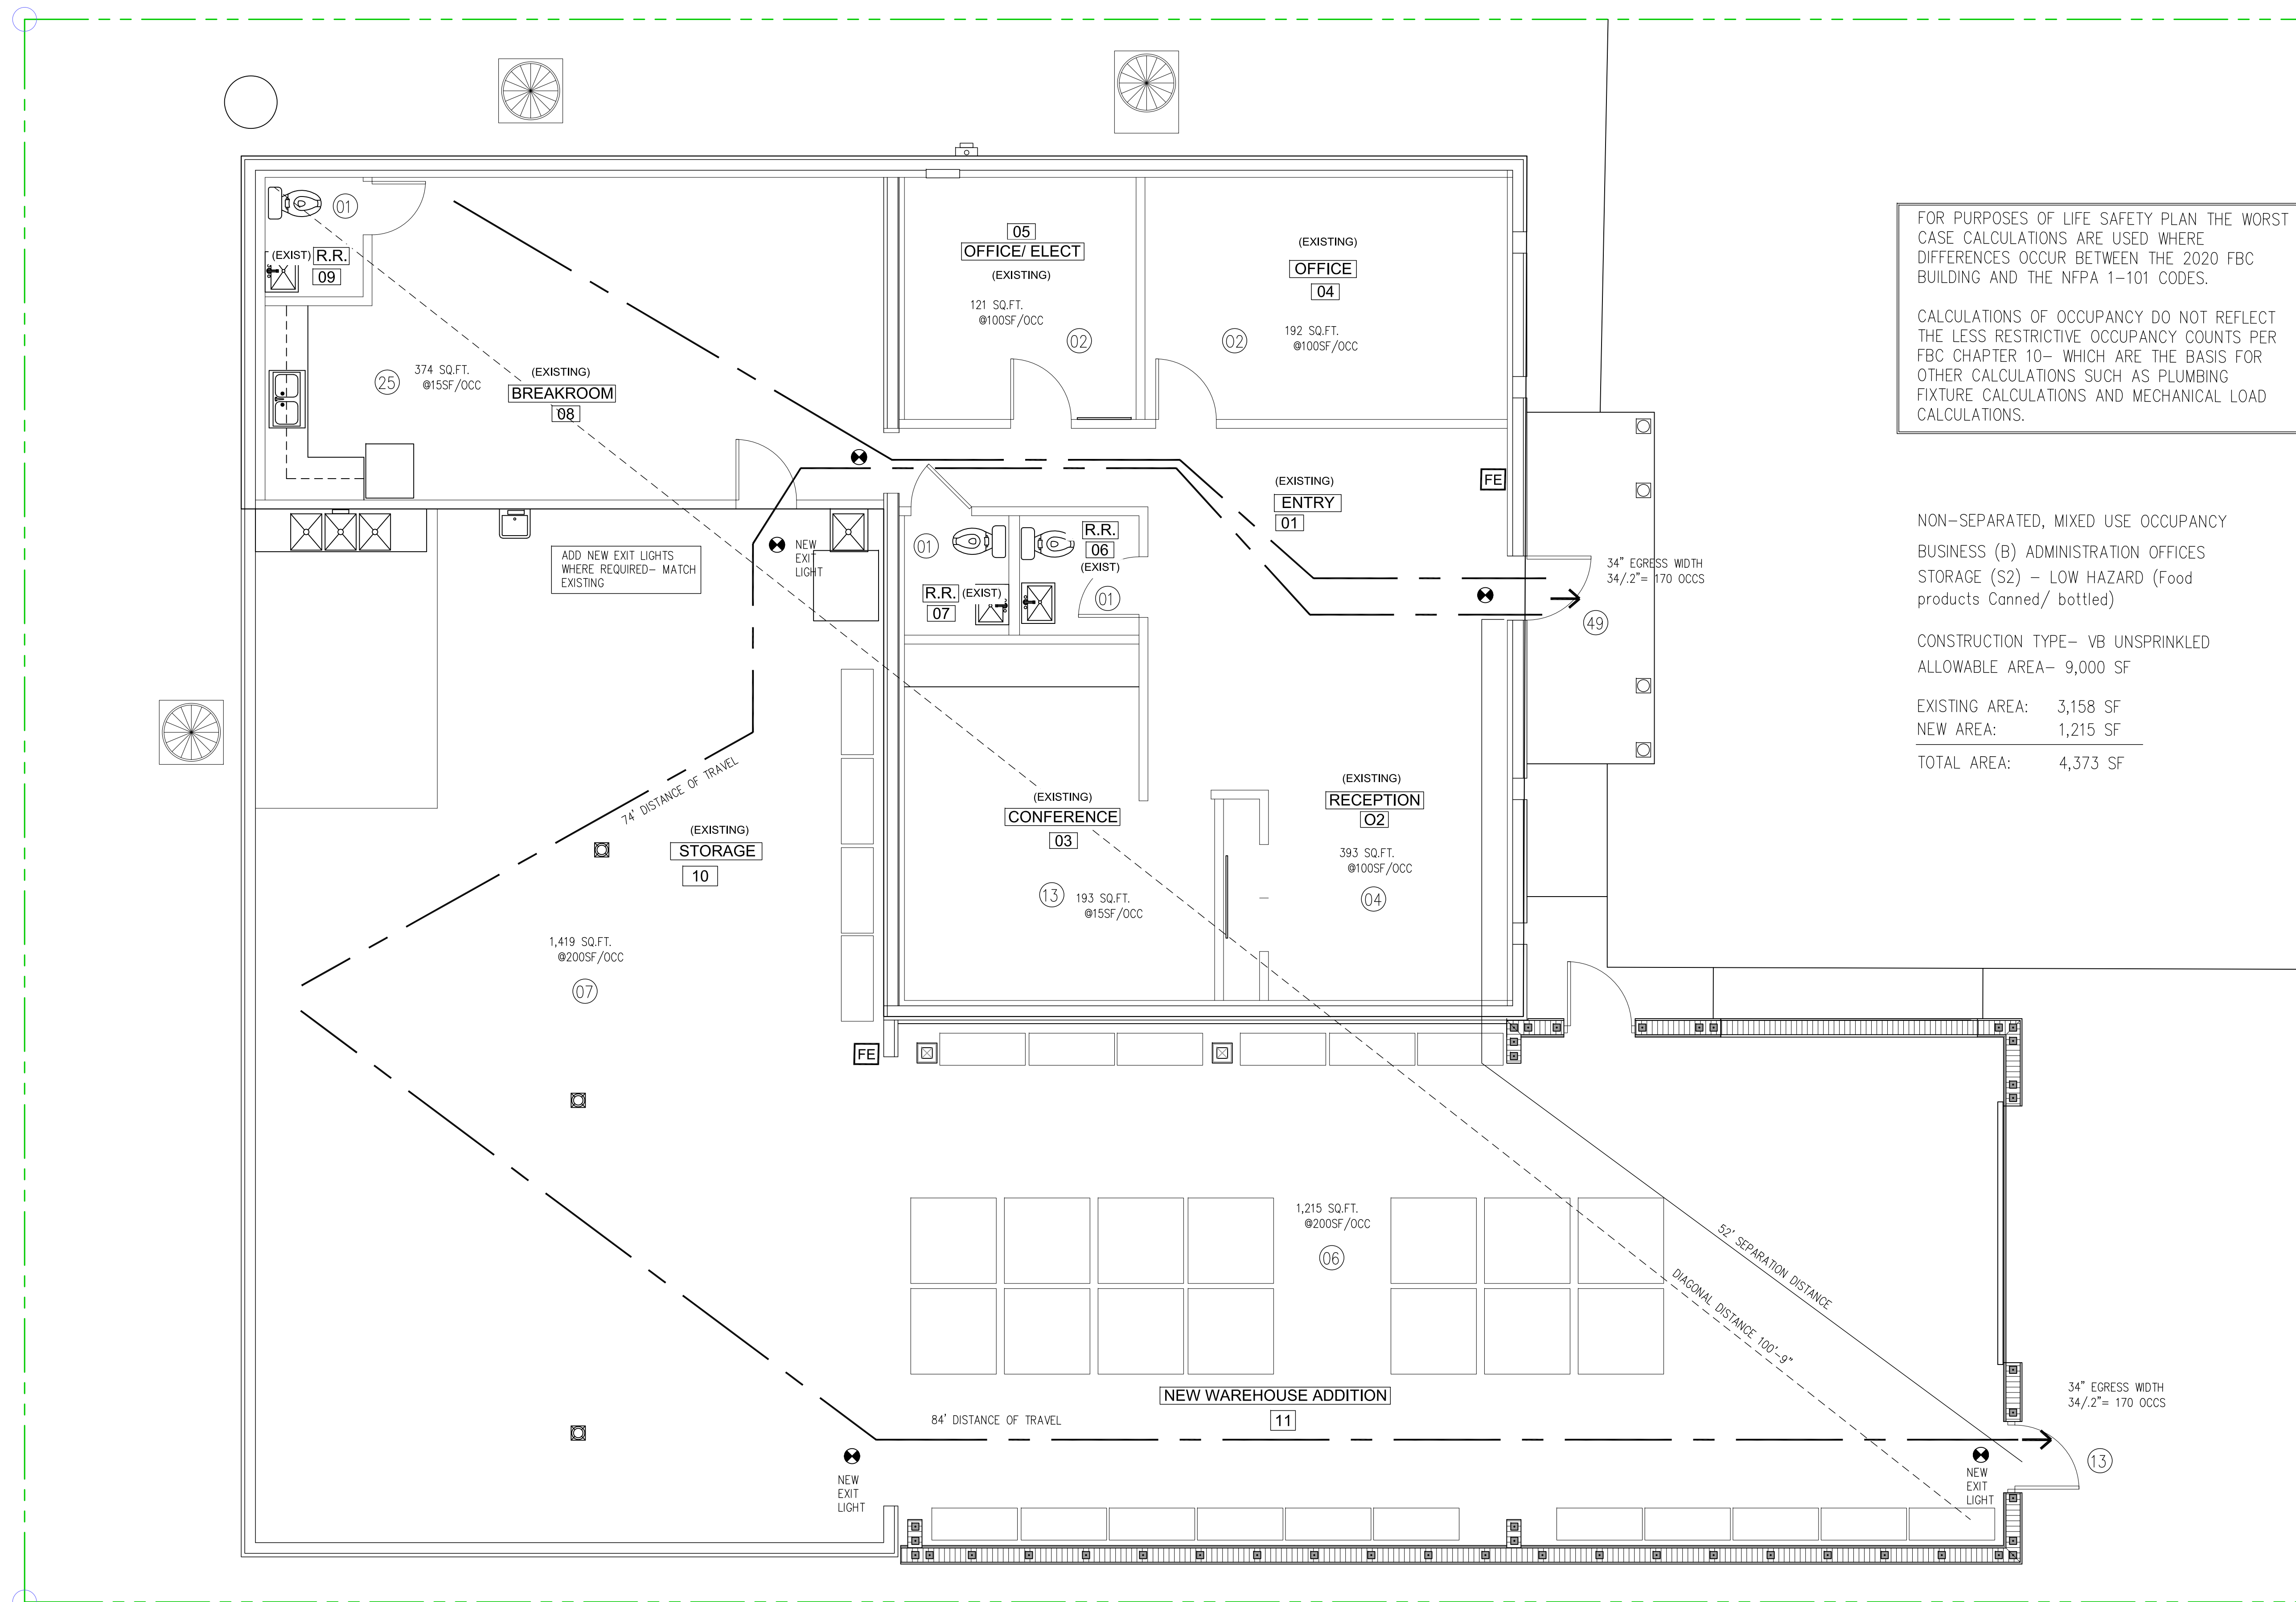

FOR PURPOSES OF LIFE SAFETY PLAN THE WORST CASE CALCULATIONS ARE USED WHERE DIFFERENCES OCCUR BETWEEN THE 2020 FBC BUILDING AND THE NFPA 1-101 CODES.

CALCULATIONS OF OCCUPANCY DO NOT REFLECT THE LESS RESTRICTIVE OCCUPANCY COUNTS PER FBC CHAPTER 10- WHICH ARE THE BASIS FOR OTHER CALCULATIONS SUCH AS PLUMBING FIXTURE CALCULATIONS AND MECHANICAL LOAD CALCULATIONS.

NON-SEPARATED, MIXED USE OCCUPANCY
BUSINESS (B) ADMINISTRATION OFFICES
STORAGE (S2) - LOW HAZARD (Food products Canned/ bottled)

CONSTRUCTION TYPE- VB UNSPRINKLED
ALLOWABLE AREA- 9,000 SF

EXISTING AREA: 3,158 SF
NEW AREA: 1,215 SF
TOTAL AREA: 4,373 SF

NO.	DESCRIPTION	DATE

Due Amici Warehouse
Building Addition

7808 Depot Lane Tampa Florida 33637

ARCHITECTS

KREHER WEHLING JACQUETTE

1923 E 7th AVE
TAMPA FLORIDA
33605

TEL: 813.765.1588
GREG@WEHLING.COM
AR 0091800

SEAL

GREGORY T WEHLING, AIA
AR 0091800

SHEET TITLE:

LIFE SAFETY PLAN

DATE: 11/29/21

SCALE: AS SHOWN

SHEET NO.: LS-101