


PARKING
BELOW

LEGEND

- ▲ - MAIN ENTRY
- AFF. - ABOVE FINISH FLOOR
- C.B. - CIRCUIT BREAKER PANEL
- F.D. - FLOOR DRAIN
- H.W. - HOT WATER TANK
- N.I.C. - NOT IN CONTRACT

PINEVALE ST. ↑

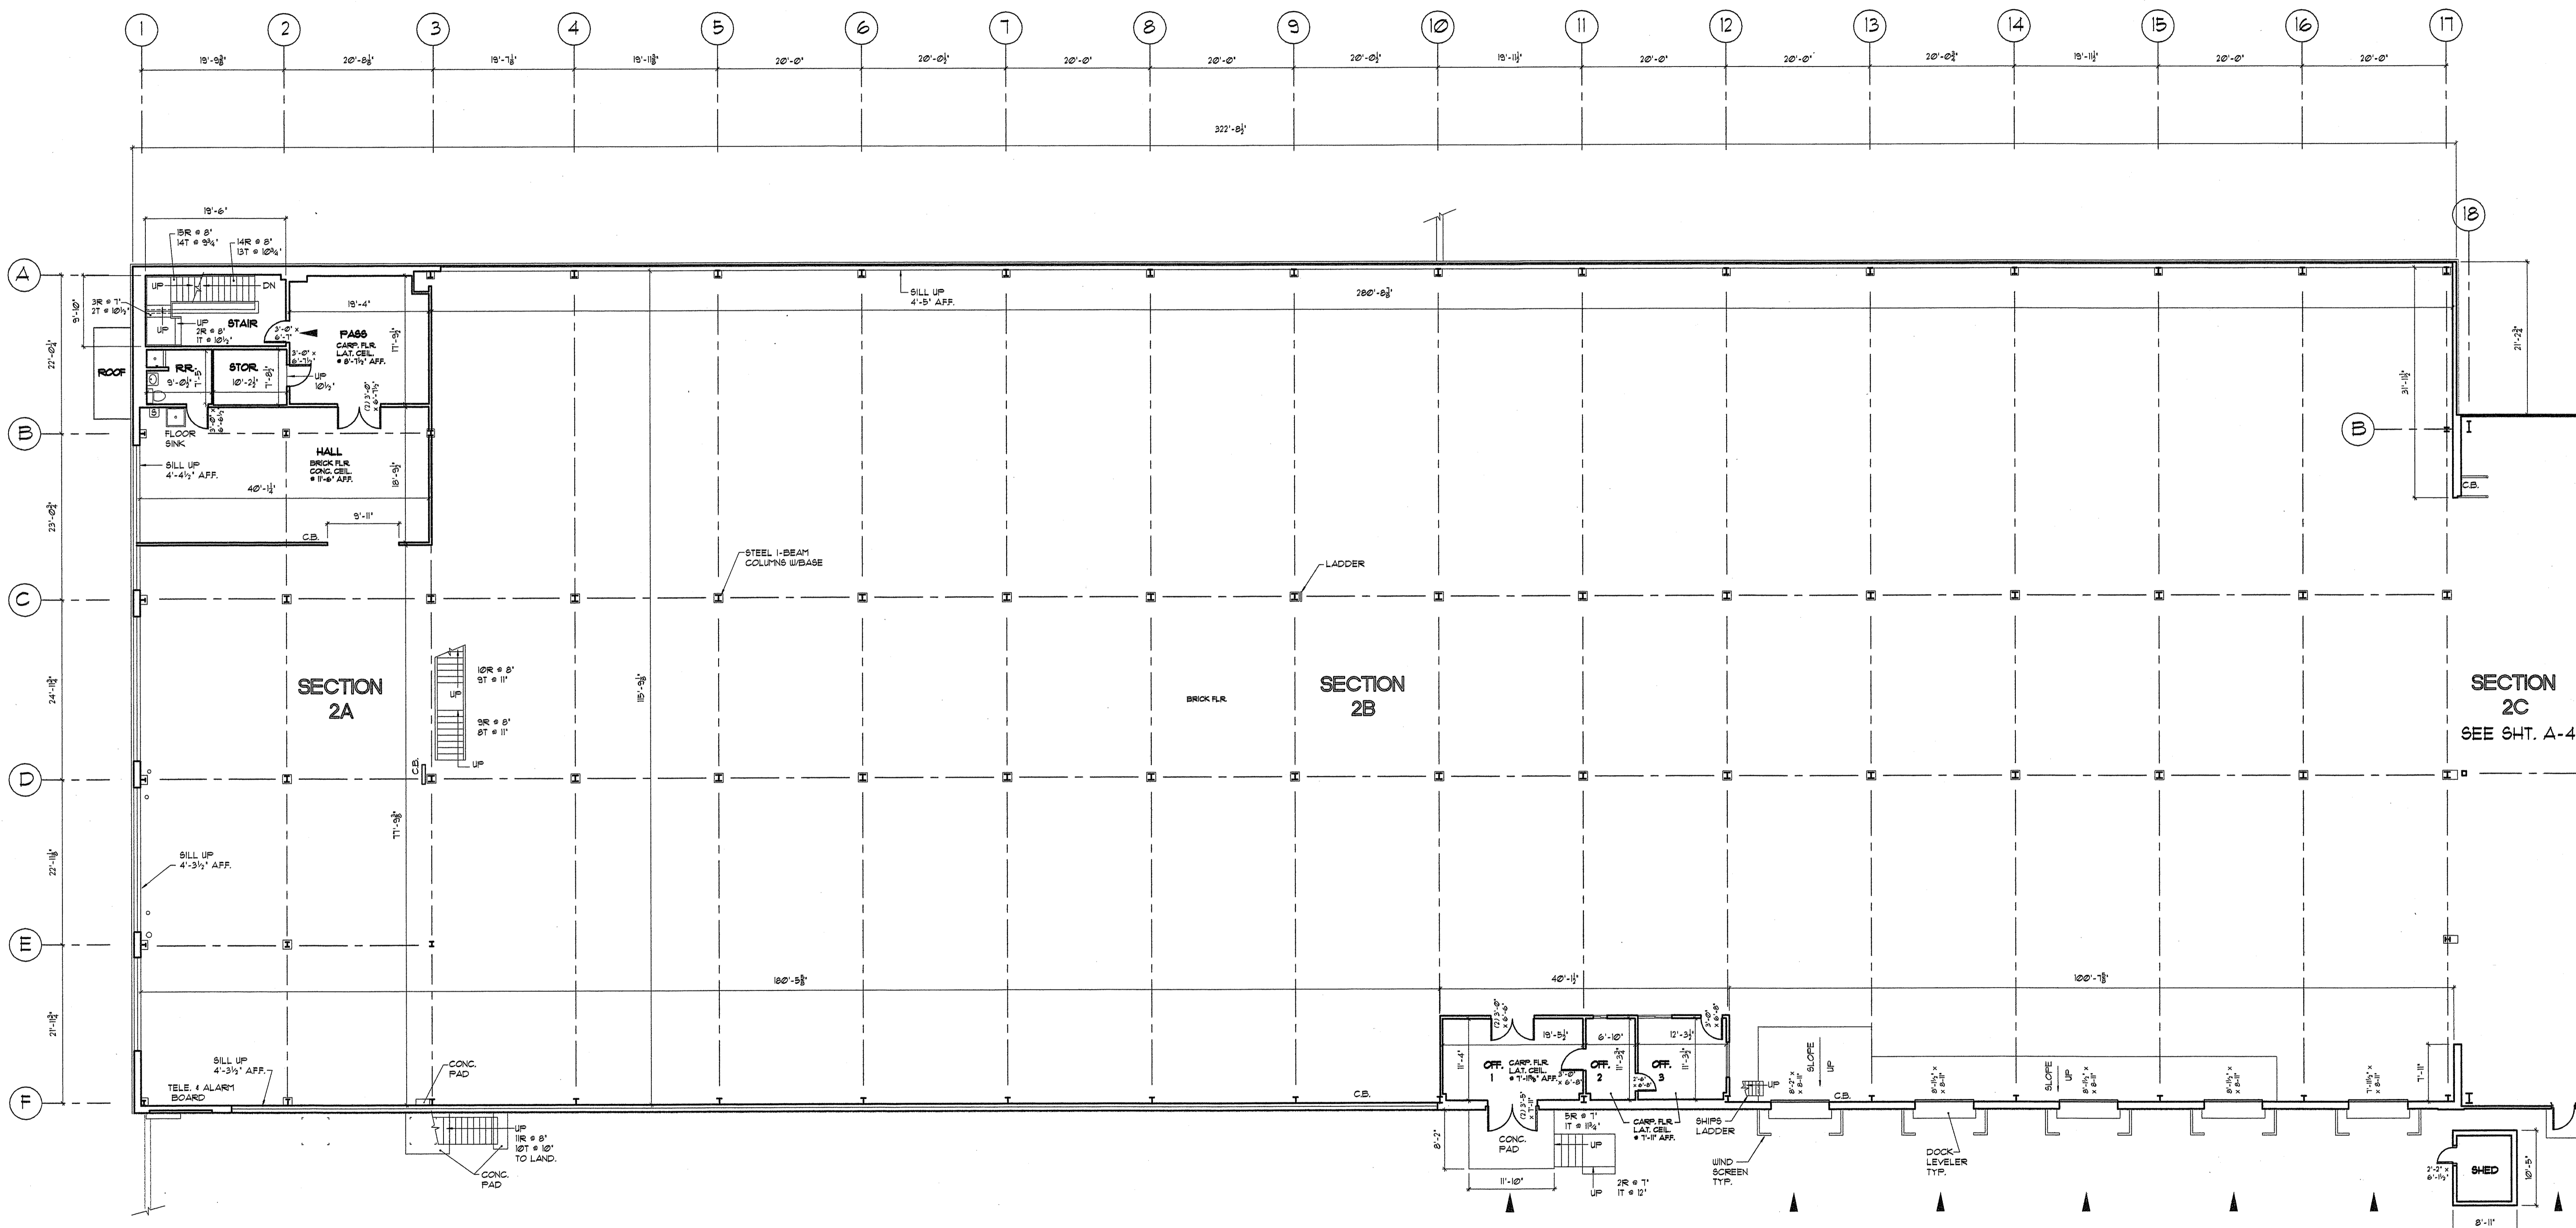

PARTIAL EXISTING SECOND FLOOR PLAN

SCALE:

3/32" = 1'-0"

GENERAL NOTES:

1. ALL DIMENSIONS ARE ±
2. SQUARE FOOTAGE IS CALCULATED BY INCLUDING ONE-HALF OF DEMISING WALL AND ALL EXTERIOR WALLS.

TITLE PARTIAL EXISTING SECOND FLOOR PLAN 91 PINEVALE ST. SPRINGFIELD, MA.	AMERICAN MEASURING SERVICE		DRAWING NUMBER A-3	
	P.O. BOX 60044 SPRINGFIELD, MASSACHUSETTS 01138 Telephone 413 221-6824		DATE: 04/7/70 SCALE: 3/32" = 1'-0" PROJ. NO.: 13-066B	DESIGNED: DAF/AM6 CHECKED: APPROVED:
	3-B-28			
	13-066B			


PARKING



← PINEVALE ST. →
BELOW

LEGEND

- ▶ - MAIN ENTRY
- AFF. - ABOVE FINISH FLOOR
- C.B. = CIRCUIT BREAKER
- C. TILE = CERAMIC TILE
- D.F. = DRINKING FOUNTAIN
- F.D. = FLOOR DRAIN
- HW = HOT WATER TANK
- L.A.T. = LAY IN ACOUSTICAL TILE
- Ø = SIZE

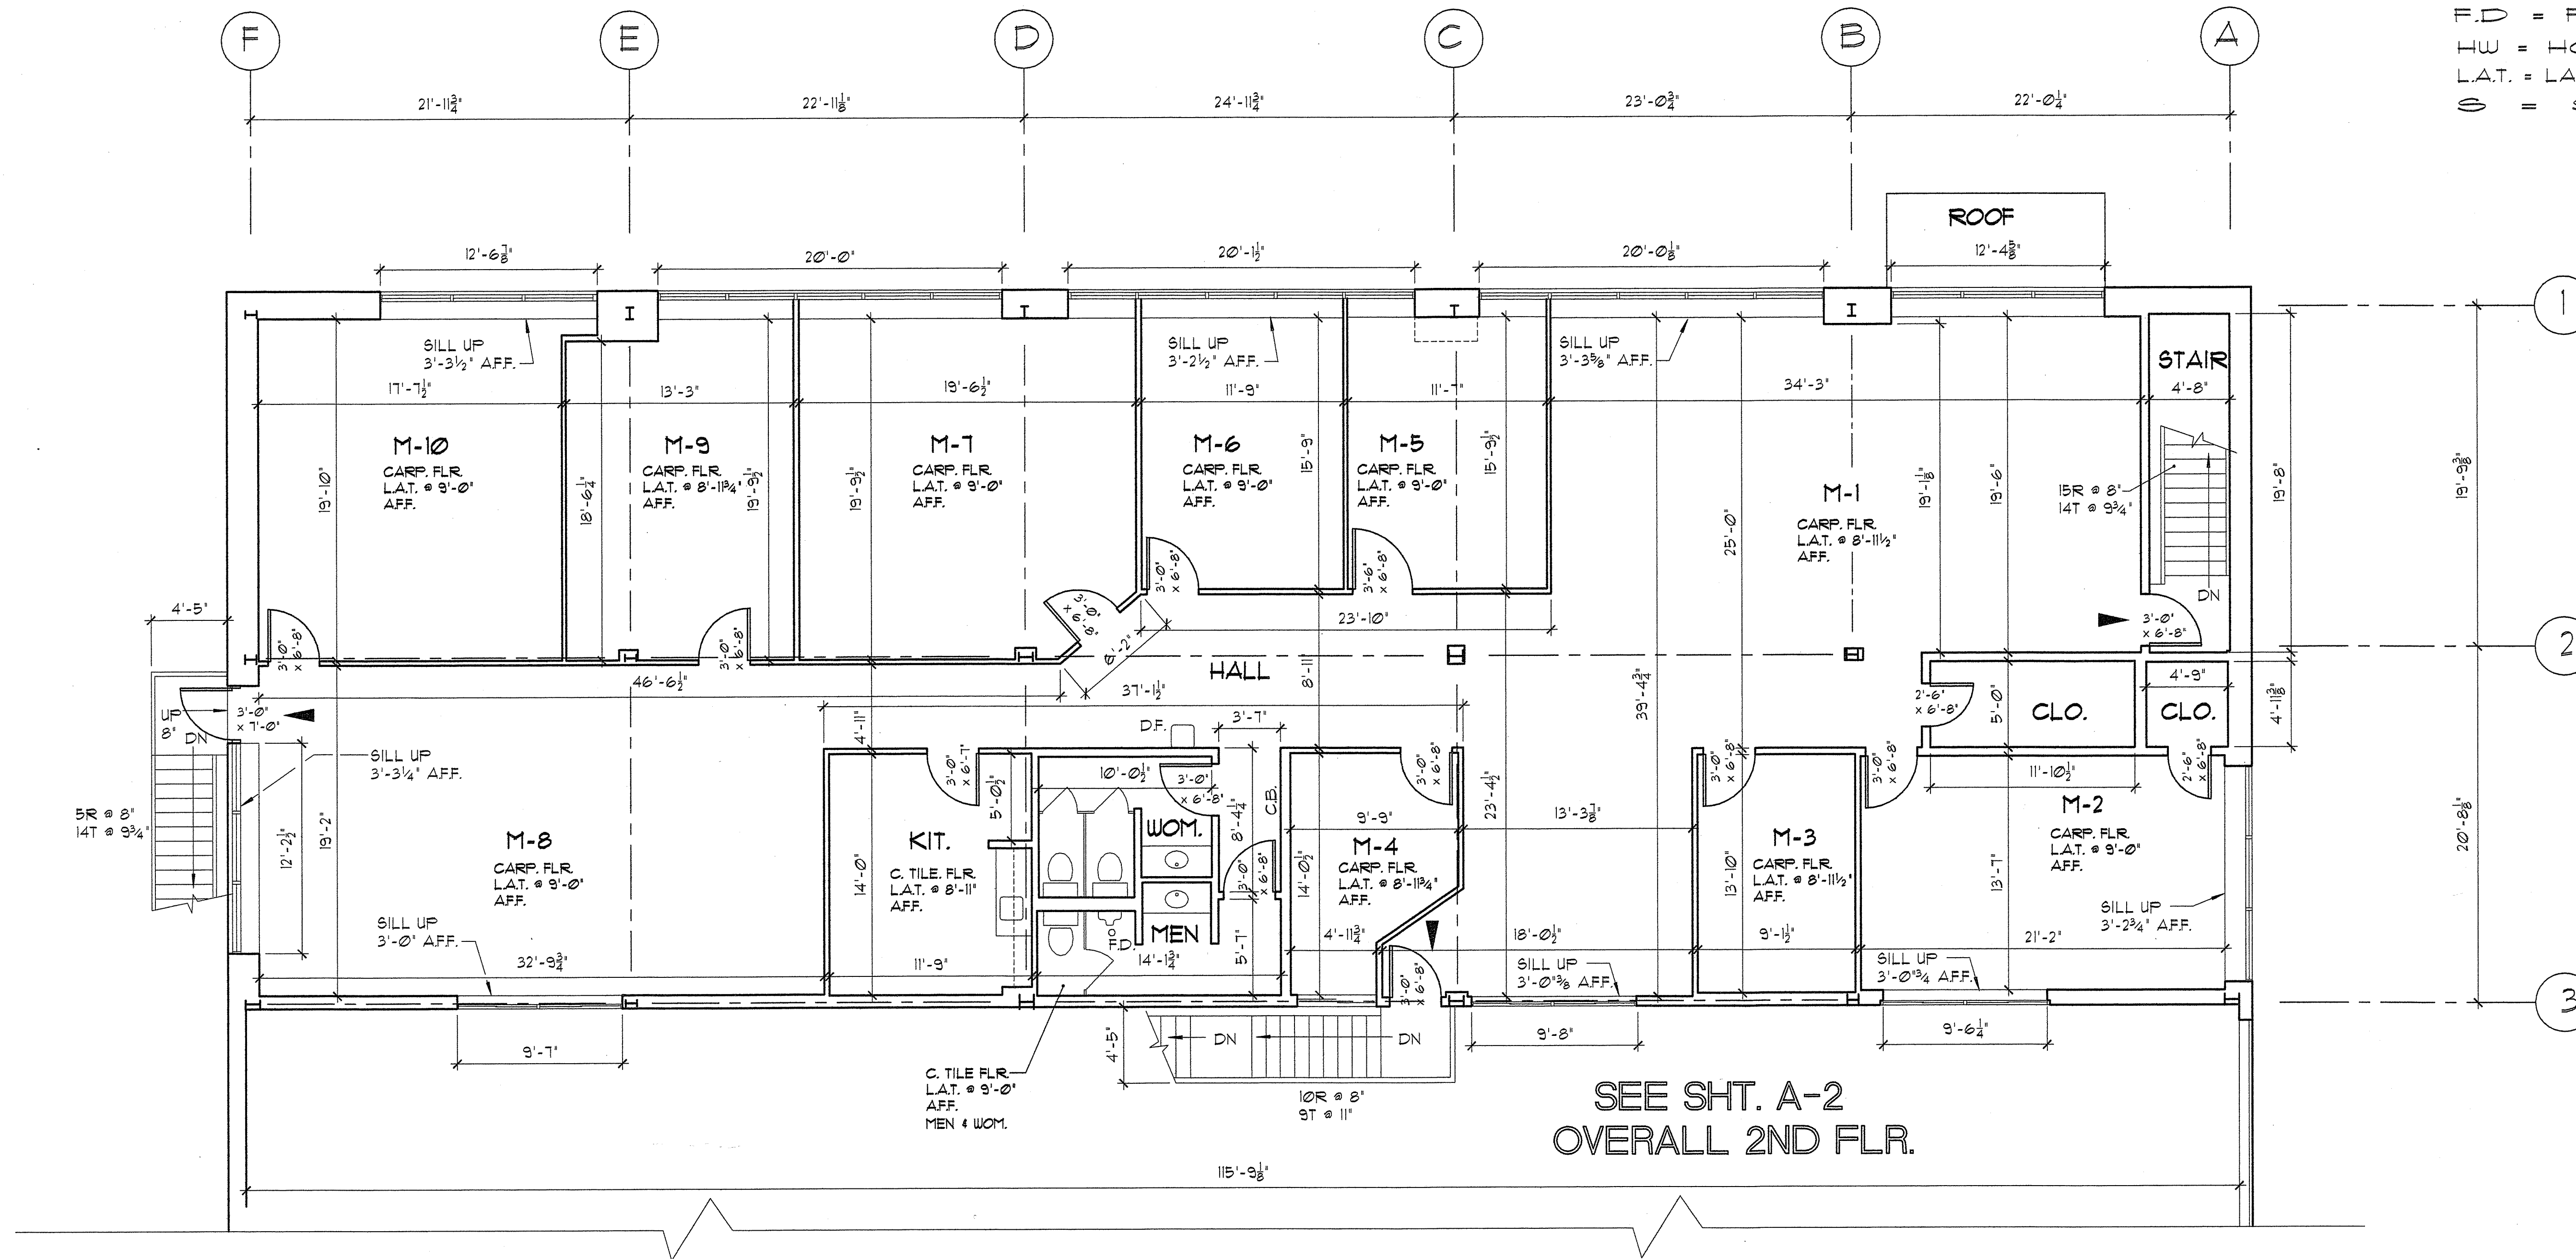

EXISTING MEZZANINE PLAN

SCALE:

4,895 SQ. FT.

3/16" = 1'-0"


GENERAL NOTES:

1. ALL DIMENSIONS ARE ±


TITLE
**EXISTING MEZZANINE
 FLOOR PLAN**
 91 PINEVALE ST.
 SPRINGFIELD, MA.

**AMERICAN
 MEASURING
 SERVICE**

P.O. BOX 80044
 SPRINGFIELD
 MASSACHUSETTS 01138
 Telephone 413 221-8824

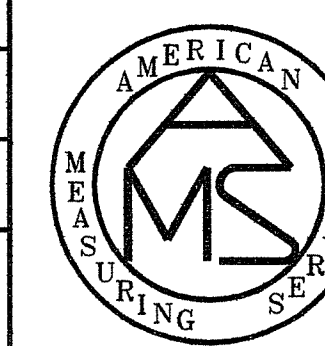


DRAWING NUMBER
A-5
 DATE: 06/07/13
 SCALE: 3/16" = 1'-0"
 PROJ. NO.: 13-06D
 DRAWN: DAF/AM5
 CHECKED:
 APPROVED:

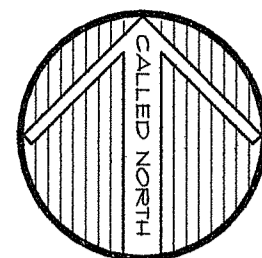

LEGEND

- ▲ - MAIN ENTRY
- A.F.F. - ABOVE FINISH FLOOR
- C.B. - CIRCUIT BREAKER PANEL
- F.D. - FLOOR DRAIN
- G.T. - GAS METER
- GYP. BD. CEIL. - GYPSUM BOARD CEILING
- H.W. - HOT WATER TANK
- L.A.T. - LAY IN ACOUSTICAL TILE
- O.W.S.J. - OPEN WEB STEEL JOISTS
- - TILE
- ▽ - VINYL TILE

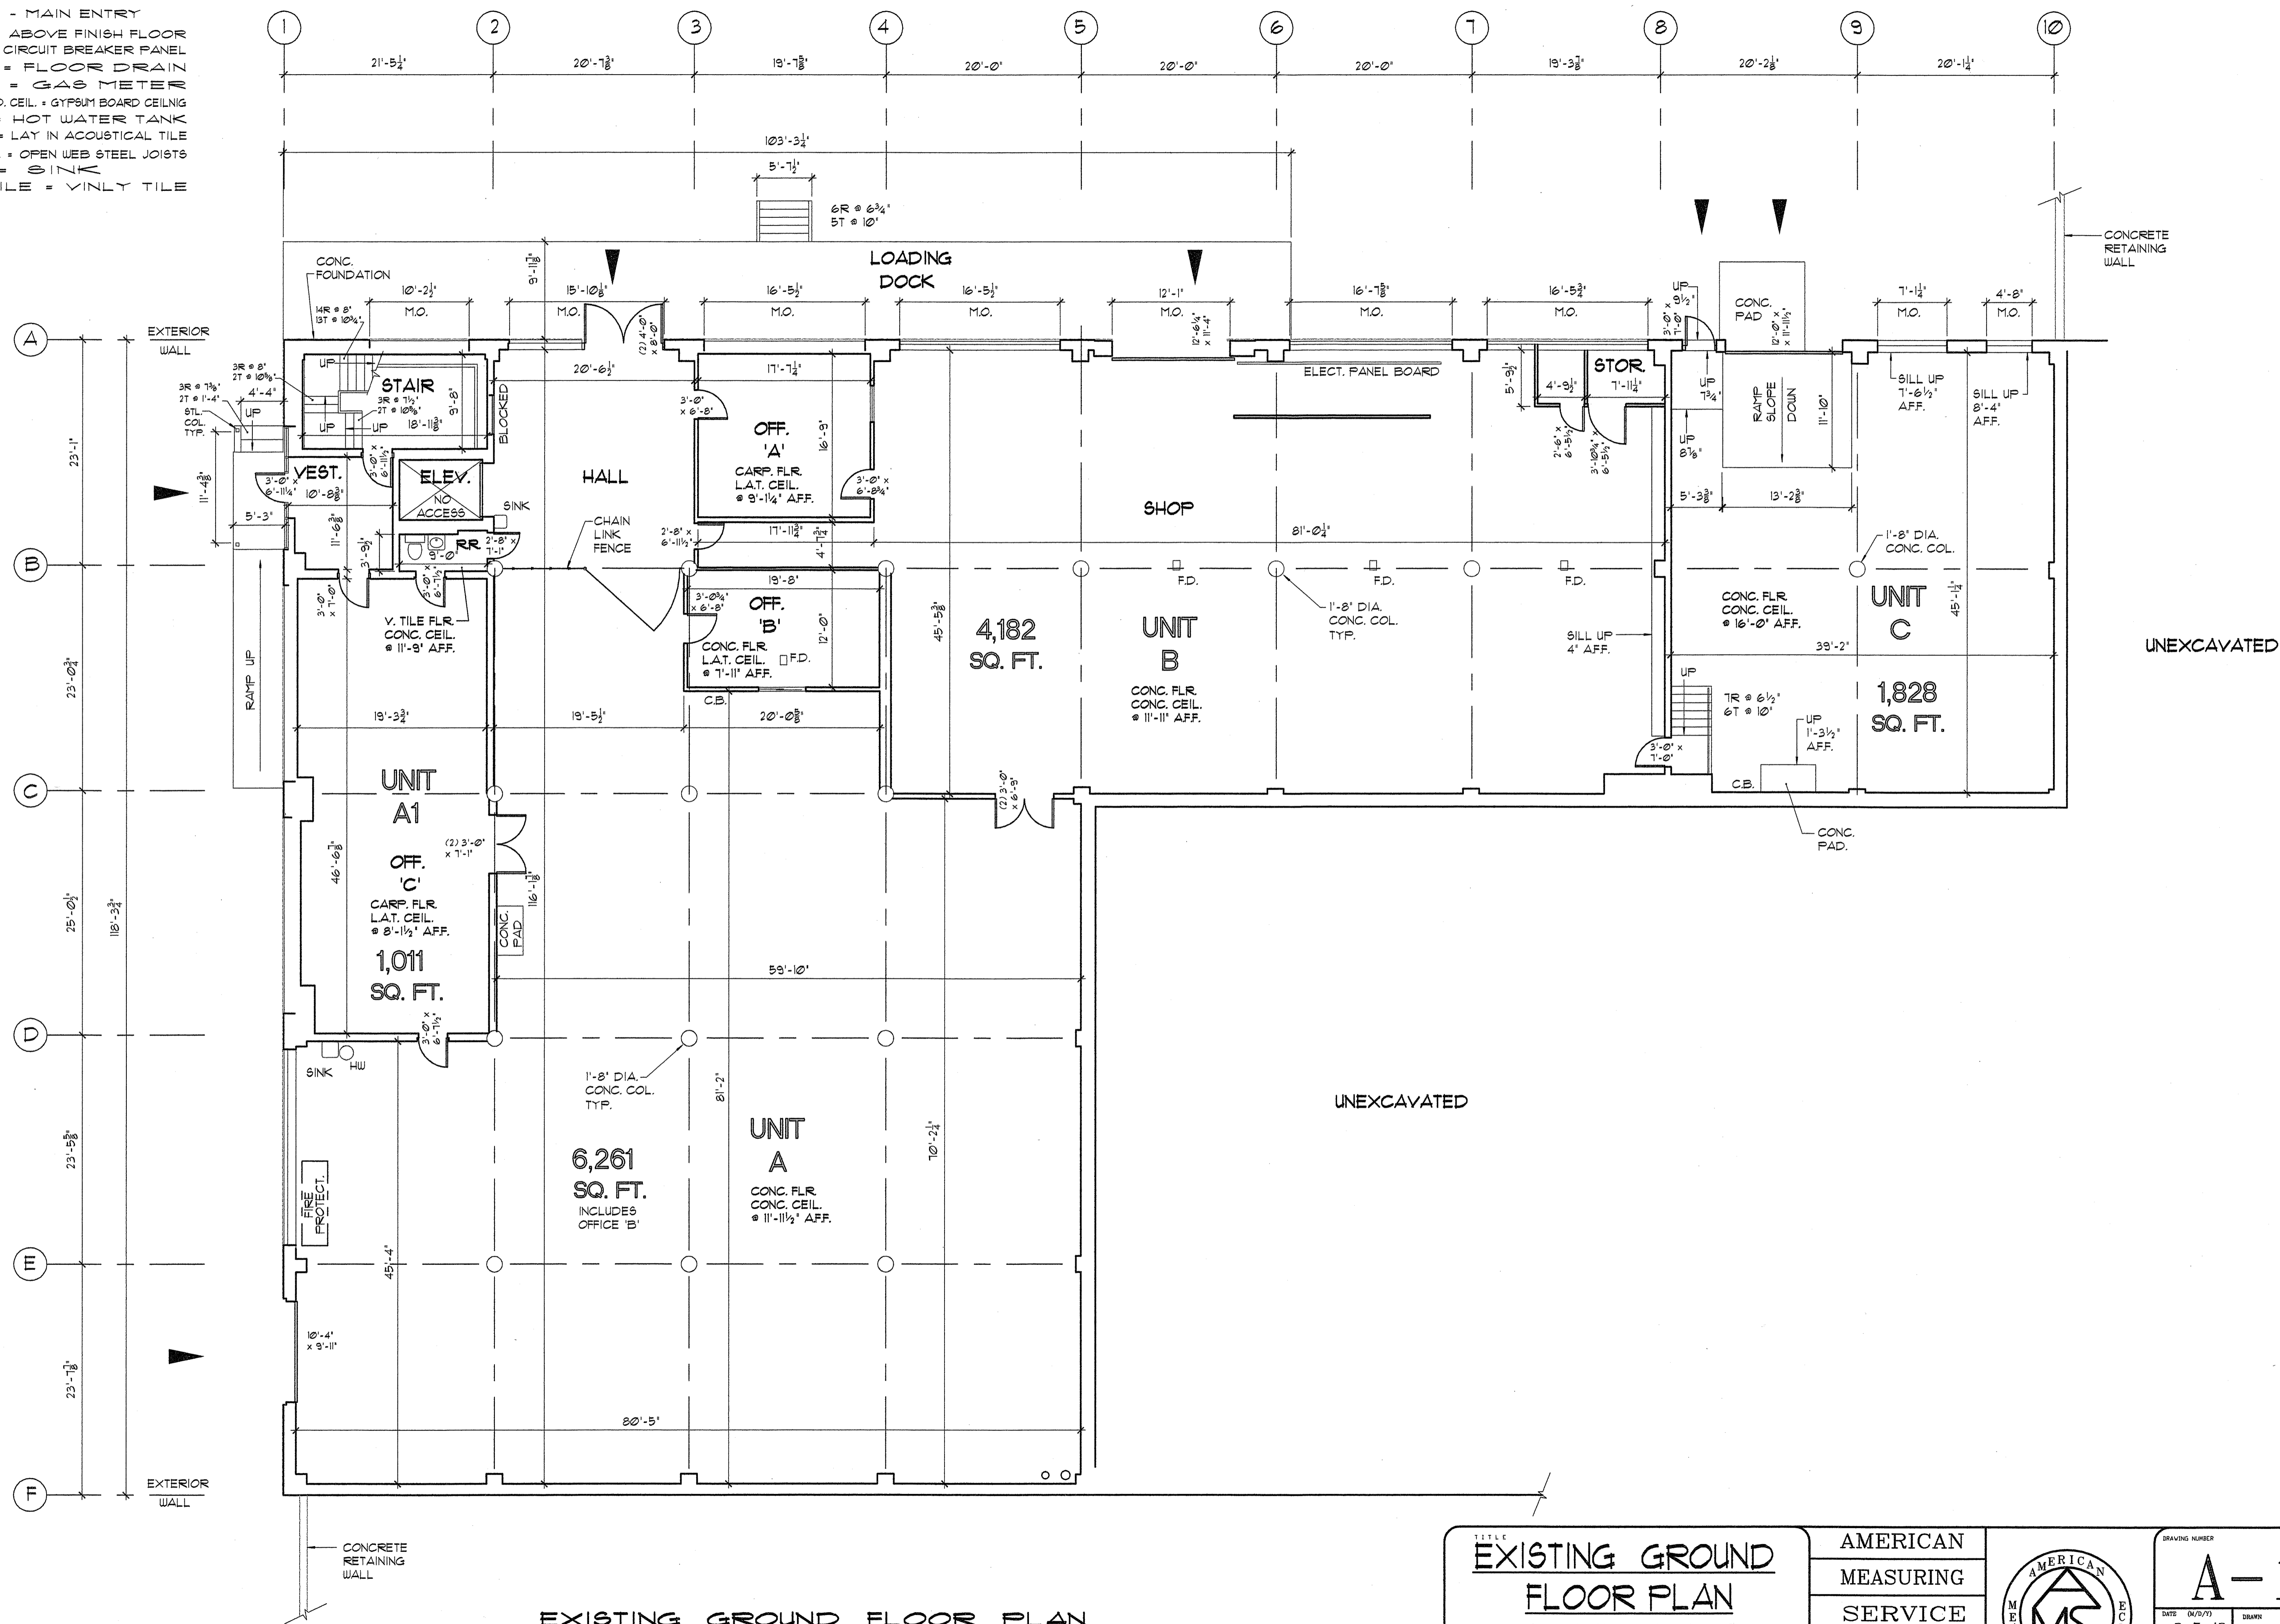

GENERAL NOTES:
 1. ALL DIMENSIONS ARE ±

EXISTING GROUND FLOOR PLAN

SCALE: 1/8" = 1'-0"
 14,287 SQ. FT.

EXISTING GROUND
 FLOOR PLAN
 91 PINEVALE ST.
 SPRINGFIELD, MA.

**AMERICAN
 MEASURING
 SERVICE**
 P.O. BOX 60044
 SPRINGFIELD
 MASSACHUSETTS 01138
 Telephone 413 221-6824



DRAWING NUMBER
A-1
 DATE: 04/07/71
 3-5-13
 SCALE: 1/8" = 1'-0"
 PROJ. NO.: 13-06
 DRAWN: DAF/AM'S
 CHECKED:
 APPROVED: