


# Floor Plan

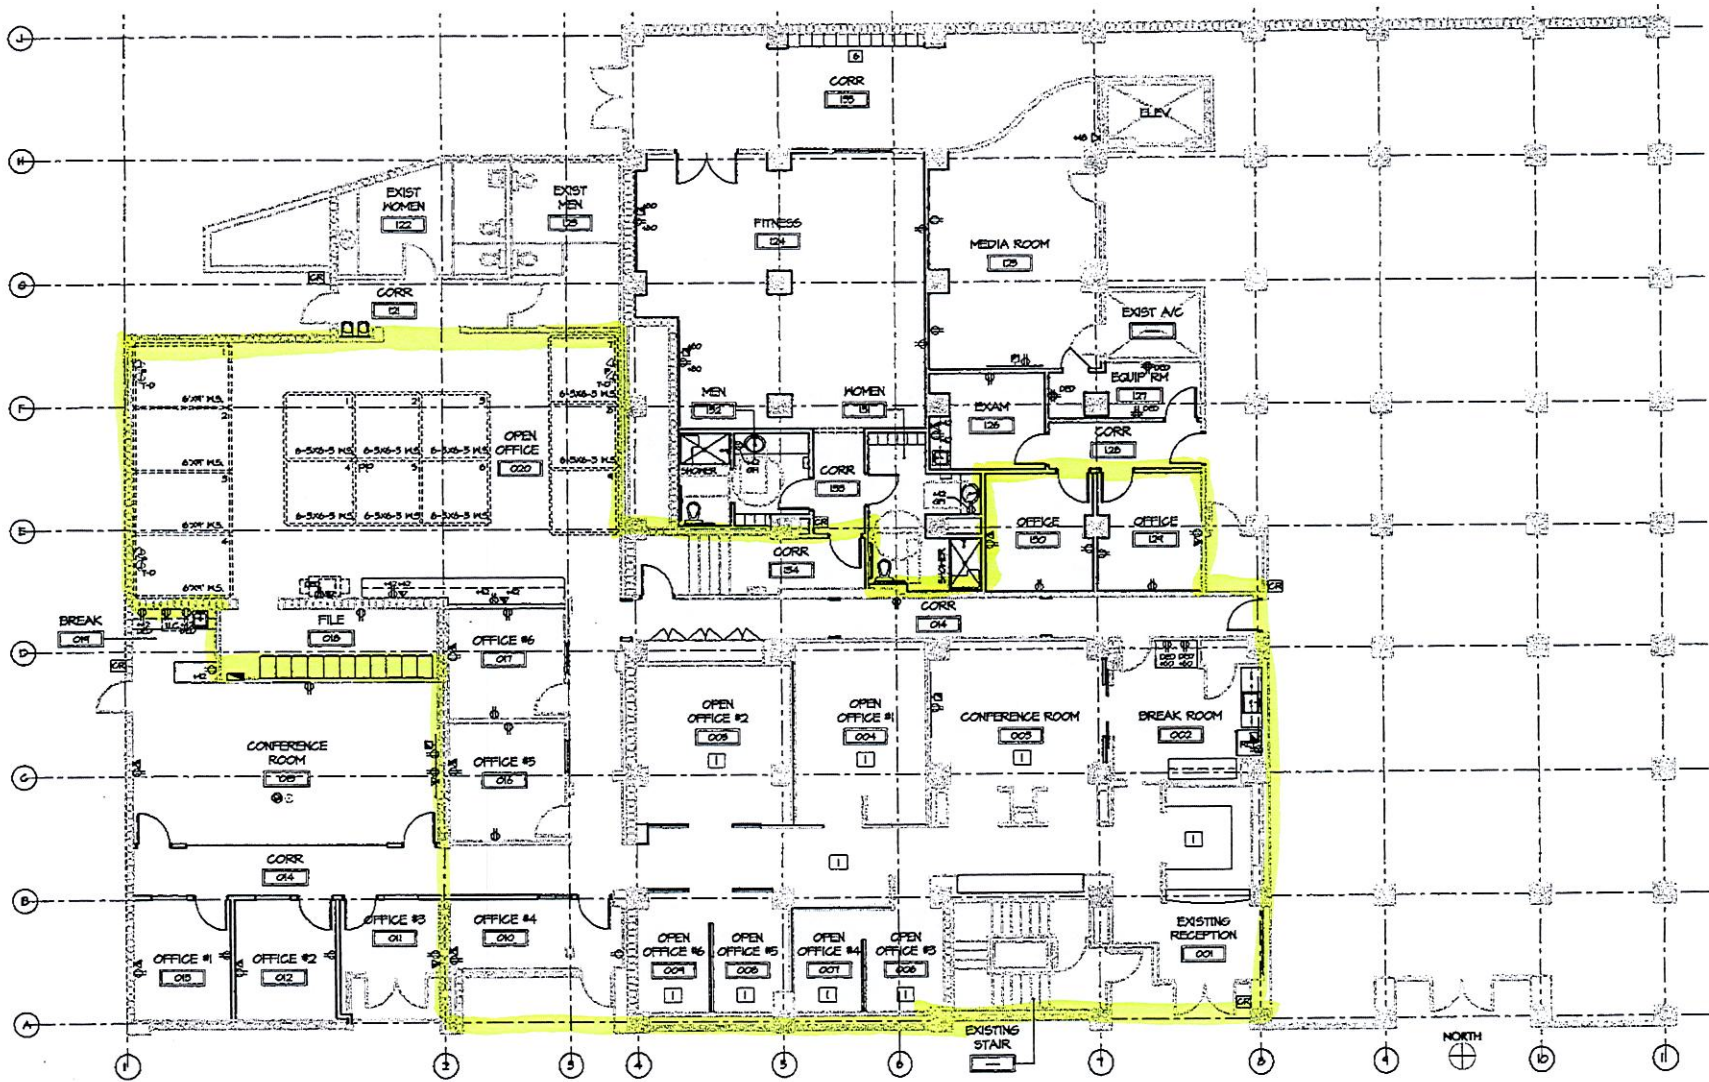

**POWER AND DATA PLAN**  
SCALE 1/8" = 1'-0"