




THOMAS TWOMEY,
PE # 25626
JIM PAINE,
RA # 9524
2831A EXCHANGE CT.
WEST PALM BEACH,
FLORIDA, 33409
(561) 686-5853

METRO
DESIGN GROUP
(561) 686-5853

MARIE BIRDIE
7116 S DIXIE HIGHWAY
WEST PALM BEACH, FLORIDA 33405


SCALE: 1/4" = 1'-0"

REVISIONS:
A 7/24/2024 AC REV.

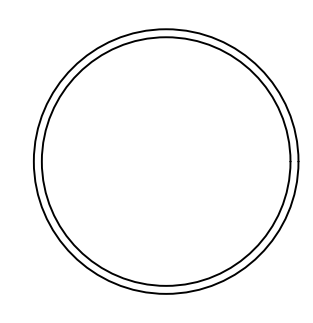

DATE: 16AUG2023
DRAWN: PTR
ACAD FILE: MARIEBIRDIE

SHEET#
2.2e
OF
11

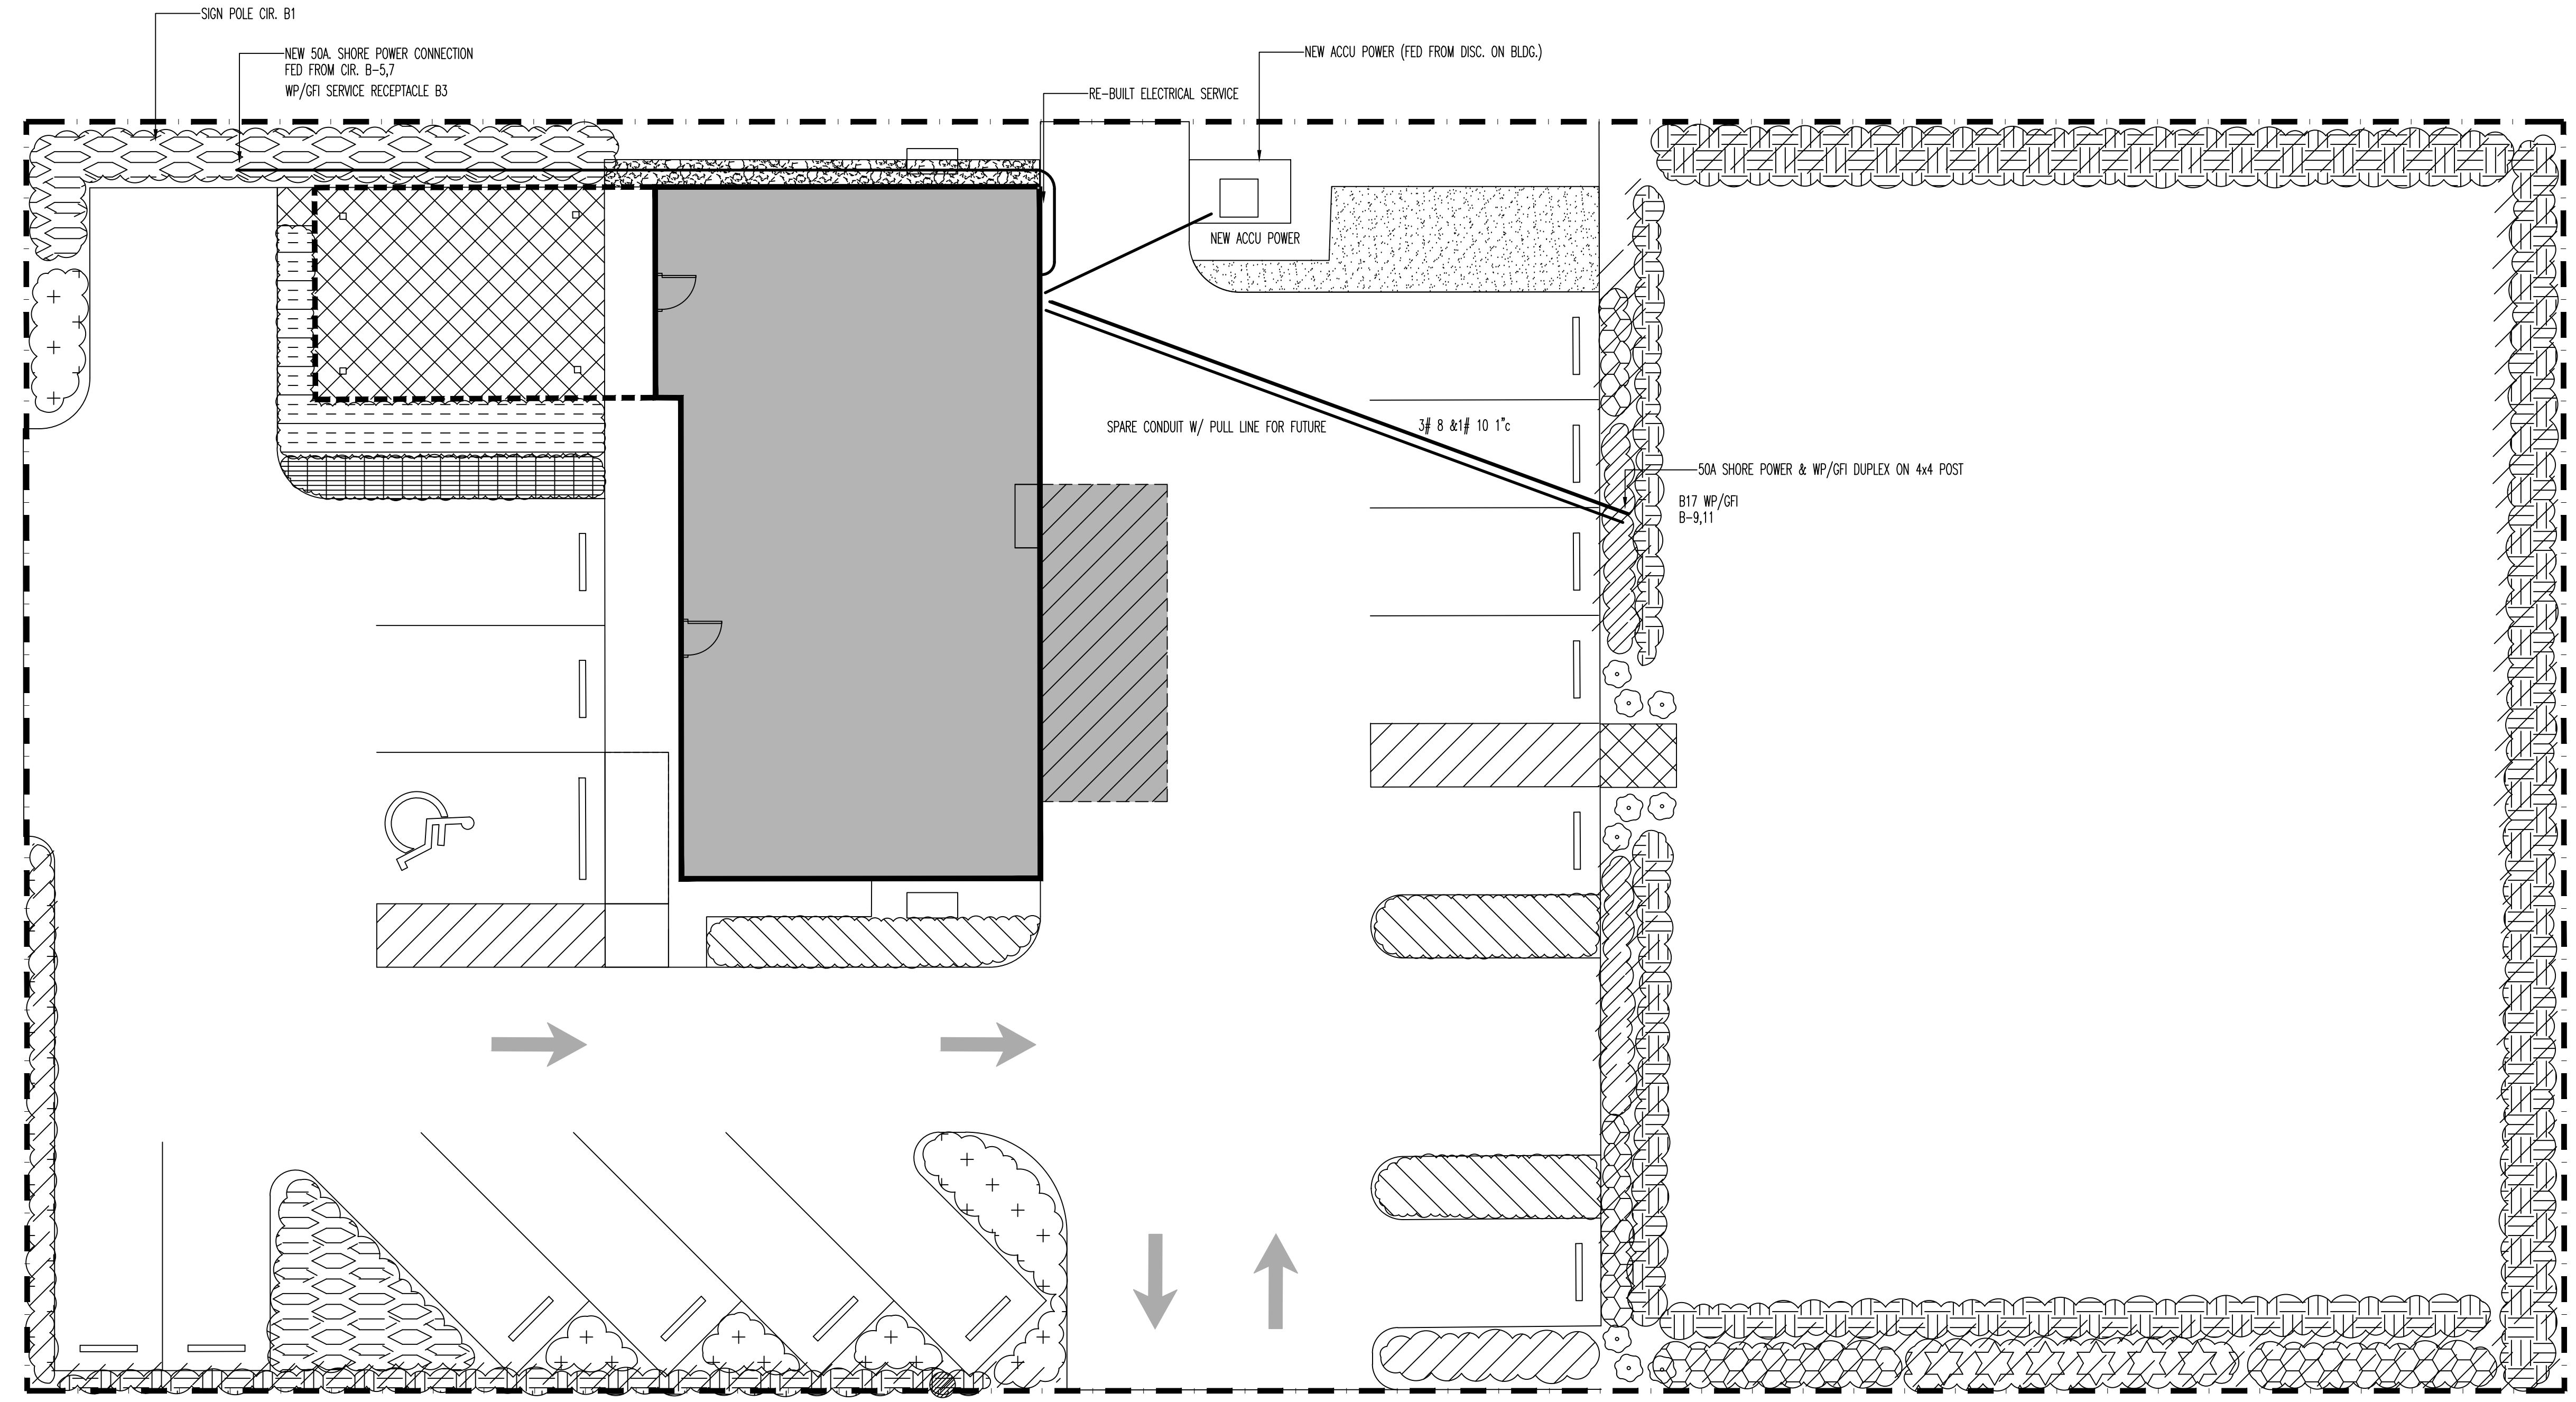

THOMAS J. TWOMEY, PROFESSIONAL ENGINEER, STATE OF FLORIDA,
LICENSE NO. 25626
THIS ITEM HAS BEEN DIGITALLY SIGNED AND SEALED BY
THOMAS J. TWOMEY, P.E., ON 06/12/2024 USING A DIGITAL SIGNATURE.
PRINTED COPIES OF THIS DOCUMENT ARE NOT CONSIDERED SIGNED
AND SEALED AND THE SHA AUTHENTICATION CODE MUST BE
VERIFIED ON ANY ELECTRONIC COPIES.

CONSULTING ENGINEER:
THOMAS TWOMEY, P.E. #25626
(561) 688-2844 FAX 686-5862
2831-A EXCHANGE COURT
WEST PALM BEACH, FLORIDA 33409

SITE ELECTRICAL PLAN
1/8" = 1'-0"