


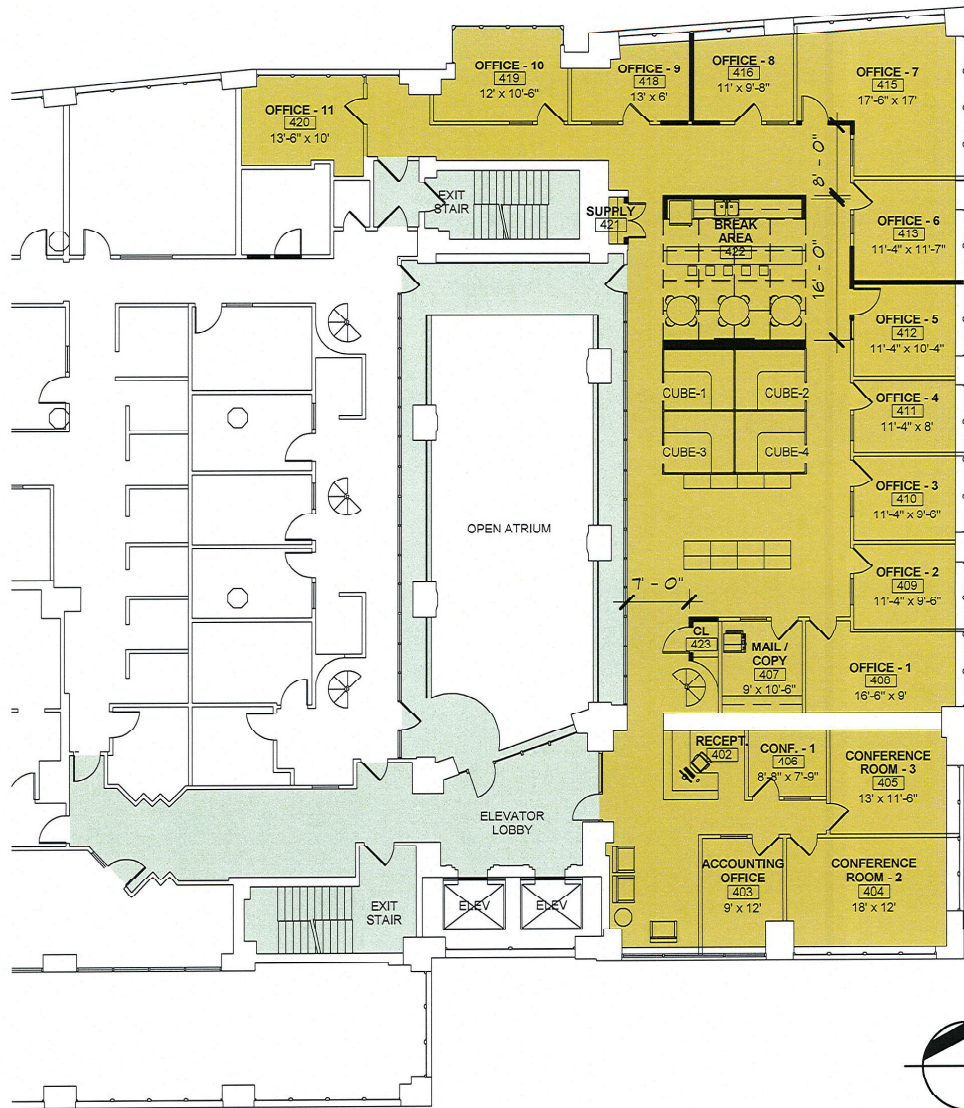

Copyright © 2016, Bivens + Associates Architects, PLLC.
Drawing Name: S:\B+A_JOBS\1083_500 Plum Bridgewater Place\1083-026_4th Flr ISS\A3CH1083-026_1.rvt
Date Plotted: 11/2/2016 8:53:39 AM

PROPOSED TENANT FLOOR PLAN
4th Floor Plan

Drawn By: MLL Project No: 1083.026
Checked By: IKB Date: 11/02/16
Scale: 1/16" = 1'-0"



SK-11