


NATURAL GAS FIRED UNIT HEATER SCHEDULE									
TAG	CFM	RPM	ELECTRICAL DATA			HEATING CAPACITY			MAX OPERATING WEIGHT
			VOLTS	HP	RPM	EAT MBH	LAT MBH	INPUT MBH	OUTPUT ARTJ MBH
UH-1									
UH-2									
UH-3									
UH-4									
UH-5									
UH-6									
UH-7									

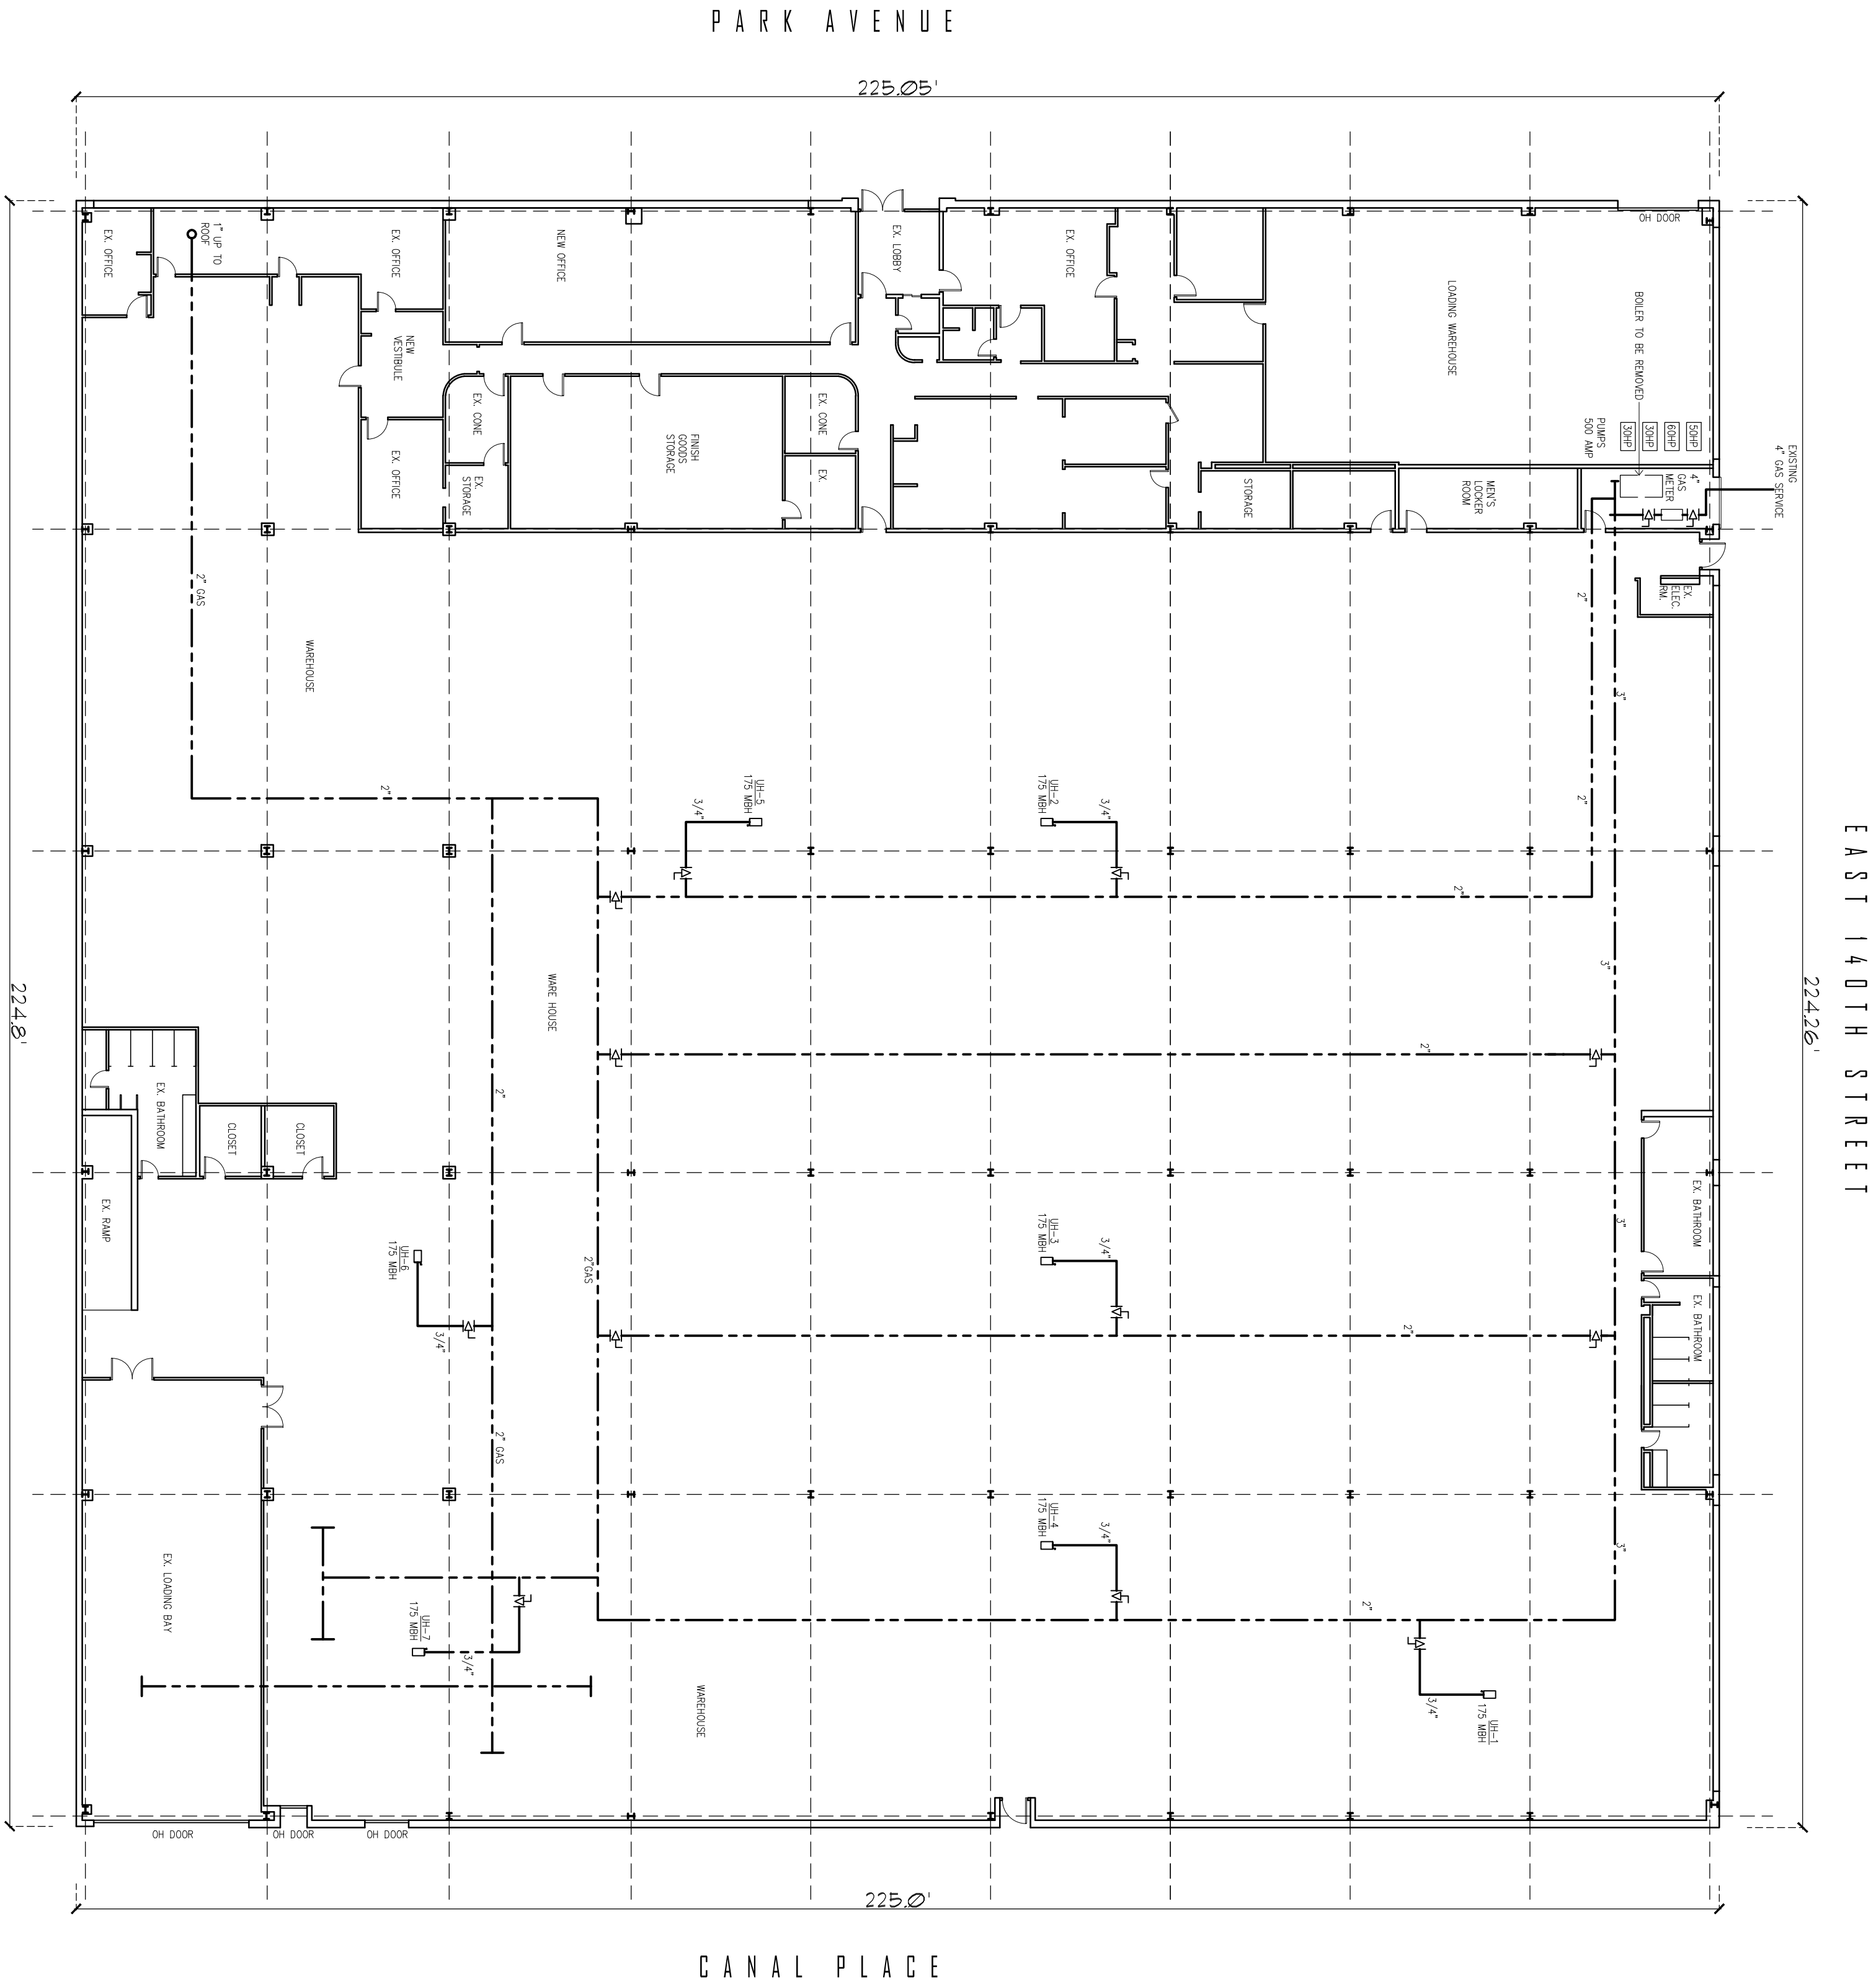

FIRST FLOOR PLAN SCALE: 1/8" = 1'-0"

