



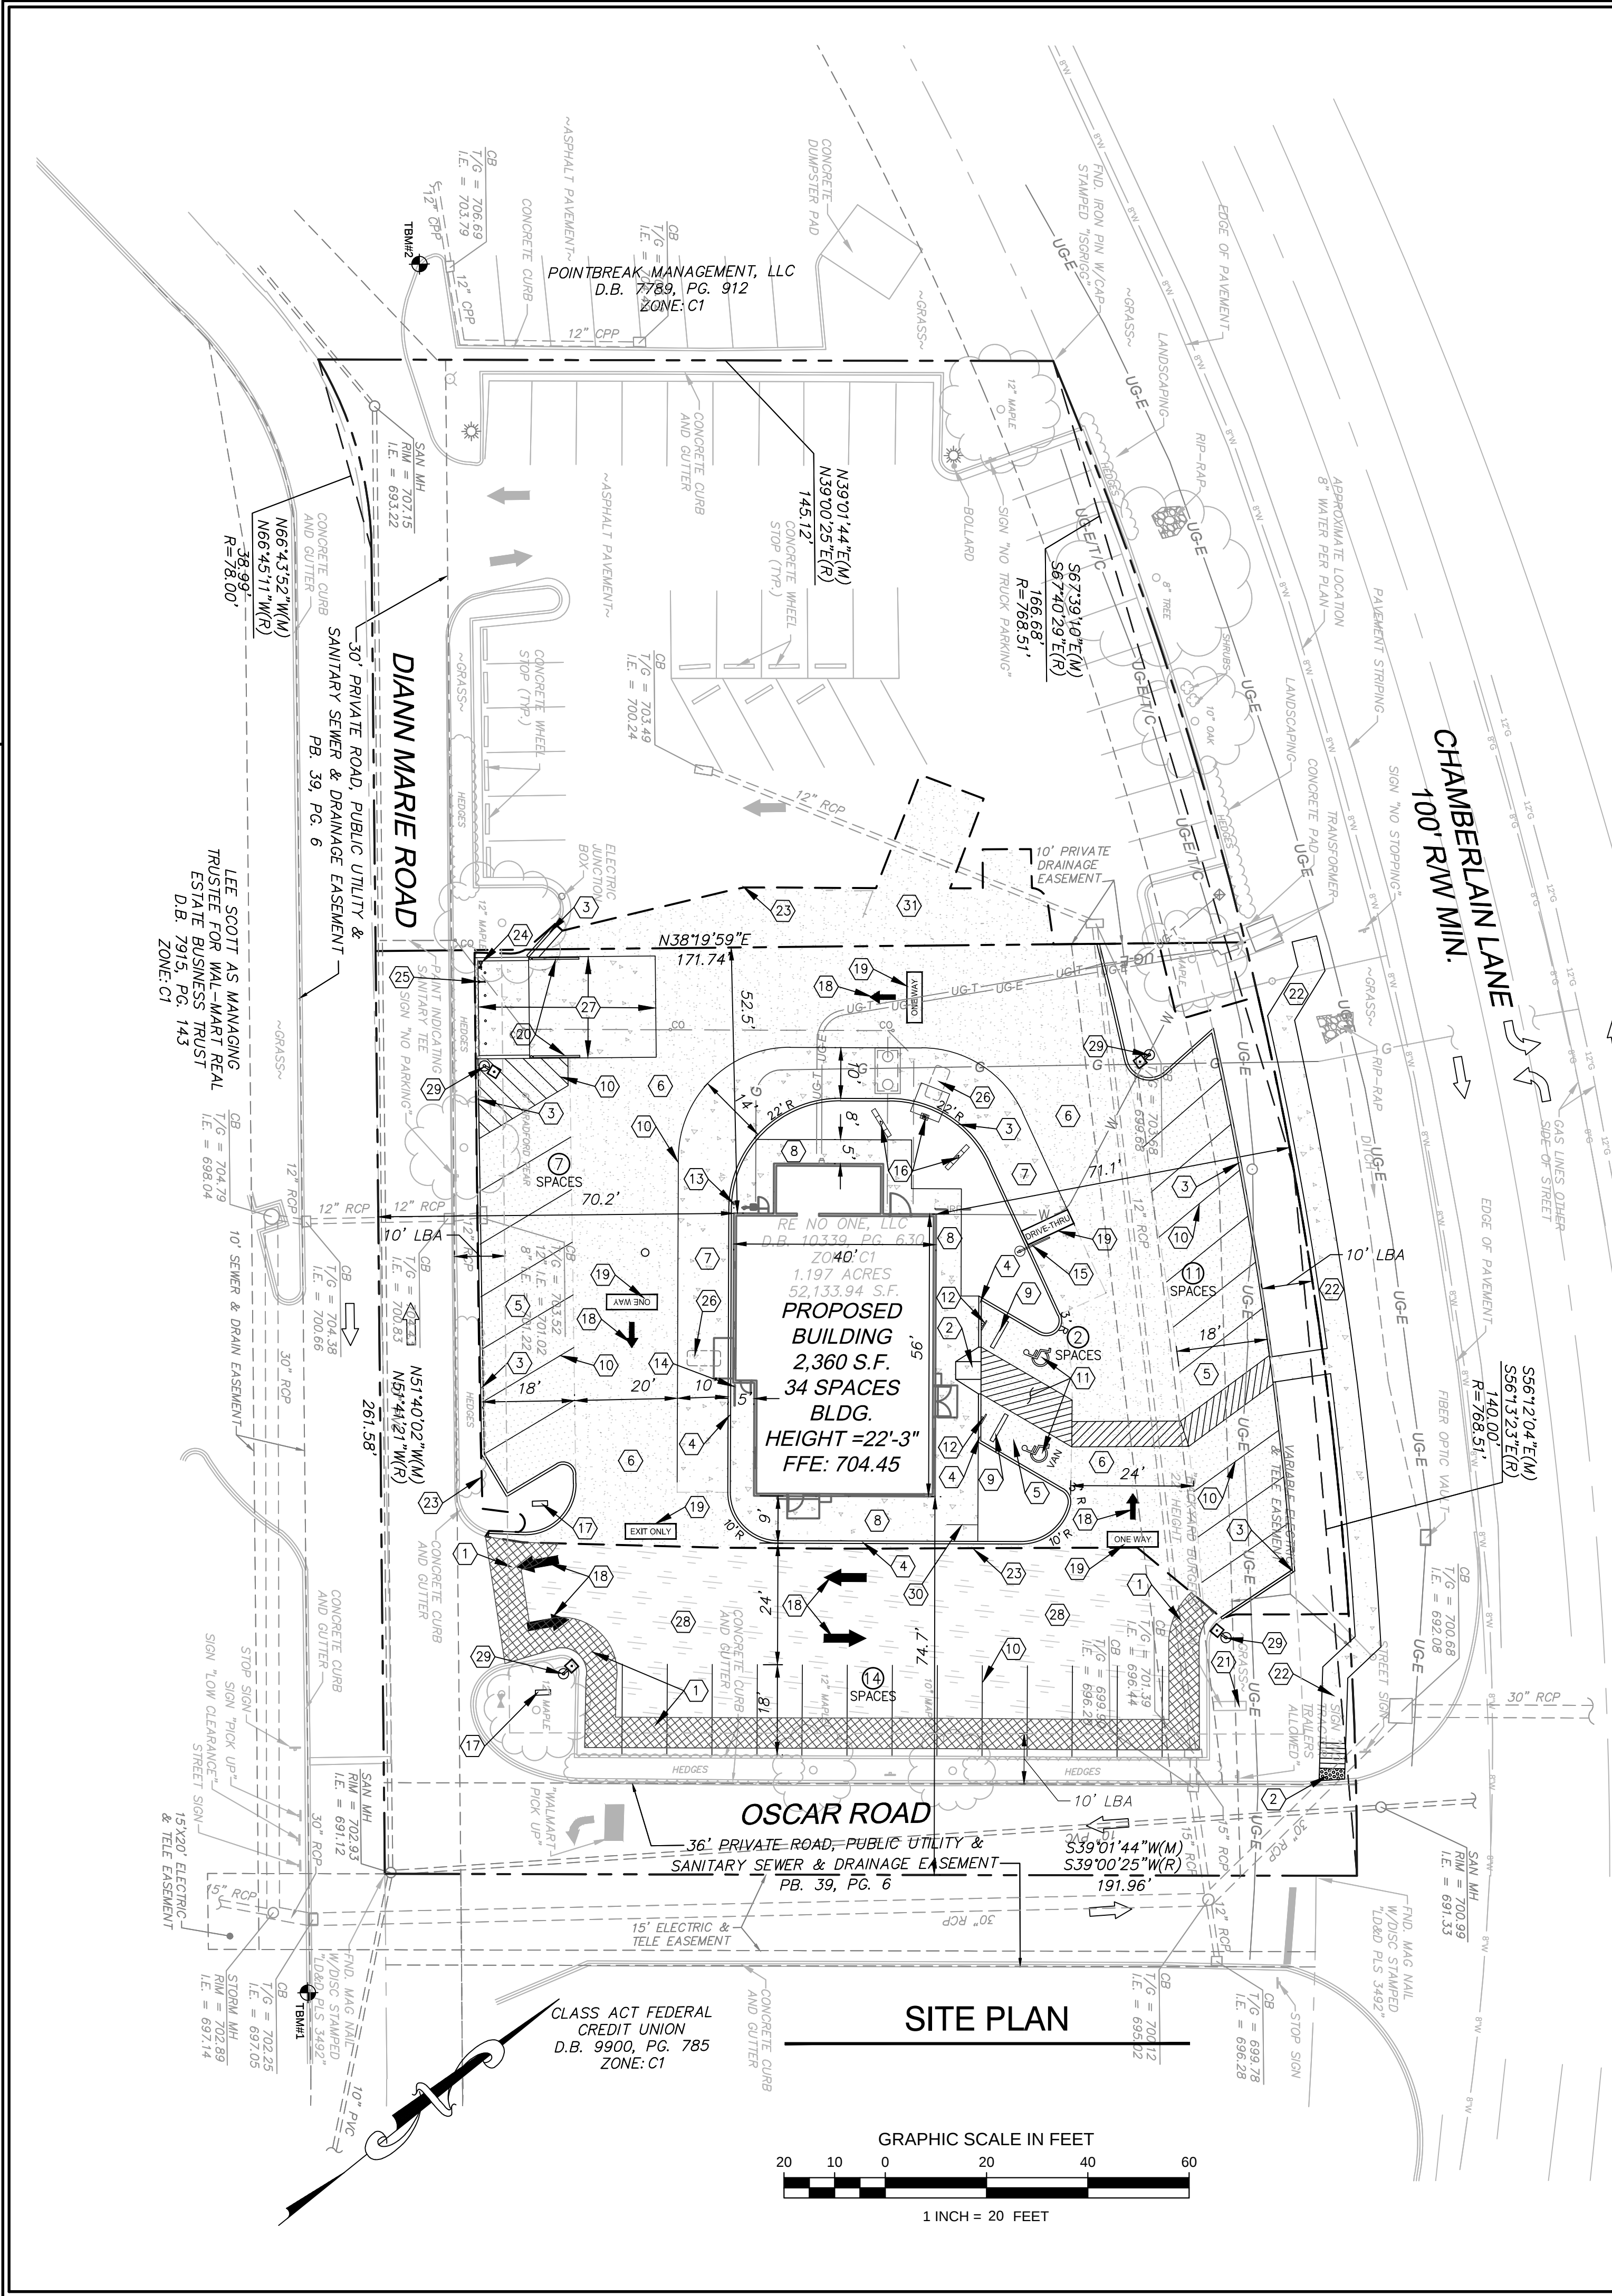

KEY NOTES

- 6 FEET WIDE BY 1-1/2 INCH DEEP PAVEMENT MILL.
- CONSTRUCT ADA COMPLIANT RAMP. SEE DETAIL 1, SHEET C7.0.
- CONSTRUCT RAISED CURB. SEE DETAIL 2, SHEET C7.0.
- CONSTRUCT CONCRETE CURB ADJACENT TO CONCRETE SIDEWALK. SEE DETAIL 3, SHEET C7.0.
- LIGHT DUTY ASPHALT PAVEMENT. REFER TO GEOTECHNICAL REPORT FOR PAVING SECTIONS AND SPECIFICATIONS.
- HEAVY DUTY ASPHALT PAVEMENT. REFER TO GEOTECHNICAL REPORT FOR PAVING SECTIONS AND SPECIFICATIONS.
- LIGHT DUTY CONCRETE PAVEMENT. REFER TO GEOTECHNICAL REPORT FOR PAVING SECTIONS AND SPECIFICATIONS.
- INSTALL CONCRETE SIDEWALK. SEE DETAIL 6, SHEET C7.0
- INSTALL CONCRETE WHEELSTOP. TYPICAL AT HANDICAP SPACES AND STANDARD SPACES FRONTING 6 FOOT OR LESSER WIDTH SIDEWALKS. SEE DETAIL 7, SHEET C7.0.
- PAINT 4-INCH SOLID WHITE PARKING STRIPES PER MANUAL FOR UNIFORM TRAFFIC DEVICES (2009 EDITION).
- PAINT ACCESSIBLE PARKING SPACES SYMBOLS, TEXT, AND DIAGONALS. SEE DETAIL 8, SHEET C7.0.
- INSTALL ACCESSIBLE PARKING SIGN. SEE DETAIL 10, SHEET C7.0.
- INSTALL CONCRETE FILLED PIPE BOLLARD. SEE DETAIL 11, SHEET C7.0.
- INSTALL SAFETY RAILING. SEE DETAIL 12, SHEET C7.0.
- INSTALL CLEARANCE BAR. SEE DETAIL 13, SHEET C7.0.
- INSTALL PREVIEW, ORDER CONFIRMATION AND MENU BOARDS. SEE DETAILS 14 AND 15, SHEET C7.0.
- INSTALL DIRECTIONAL SIGNS. SEE DETAILS 16, SHEET C7.0.
- PAINT DIRECTIONAL ARROW. SEE DETAILS 17, SHEET C7.0.
- PAINT DIRECTIONAL TEXT. SEE DETAILS 18, SHEET C7.0. SEE PLAN FOR TEXT.
- INSTALL DUMPSTER ENCLOSURE. SEE ARCHITECTURAL PLANS (BY OTHERS) FOR DETAILS.
- EXISTING PYLON SIGN TO BE RETROFITTED TO HARDEE'S SIGNAGE STANDARDS.
- CONSTRUCT SIDEWALK PER LOUISVILLE METRO PUBLIC WORKS STD. DWG. NO. 420.
- LIMITS OF DEMOLITION.
- INSTALL OUTDOOR ELECTRICAL OUTLET. SEE ELECTRICAL SITE PLAN (BY OTHERS) FOR DETAILS ON CIRCUIT CONNECTIONS.
- HOSE BIBB - WOODFORD Y30 WITH 3/4" COPPER COLD WATER LINE FROM THE BUILDING.
- INSTALL DRIVE THRU DETECTOR LOOP.
- INSTALL CONCRETE DUMPSTER PAD. SEE ARCHITECTURAL PLANS FOR DETAILS.
- 1-1/2 INCH ASPHALT PAVEMENT OVERLAY. REFER TO GEOTECHNICAL REPORT FOR MATERIAL SPECIFICATIONS.
- CONSTRUCT SITE LIGHTING. SEE PHOTOMETRIC PLAN.
- INSTALL 4~BIKE, BIKE RACK.
- COMPACTED DGA WITHIN DEMOLISHED PAVEMENT AREA OUTSIDE OF PROPERTY.

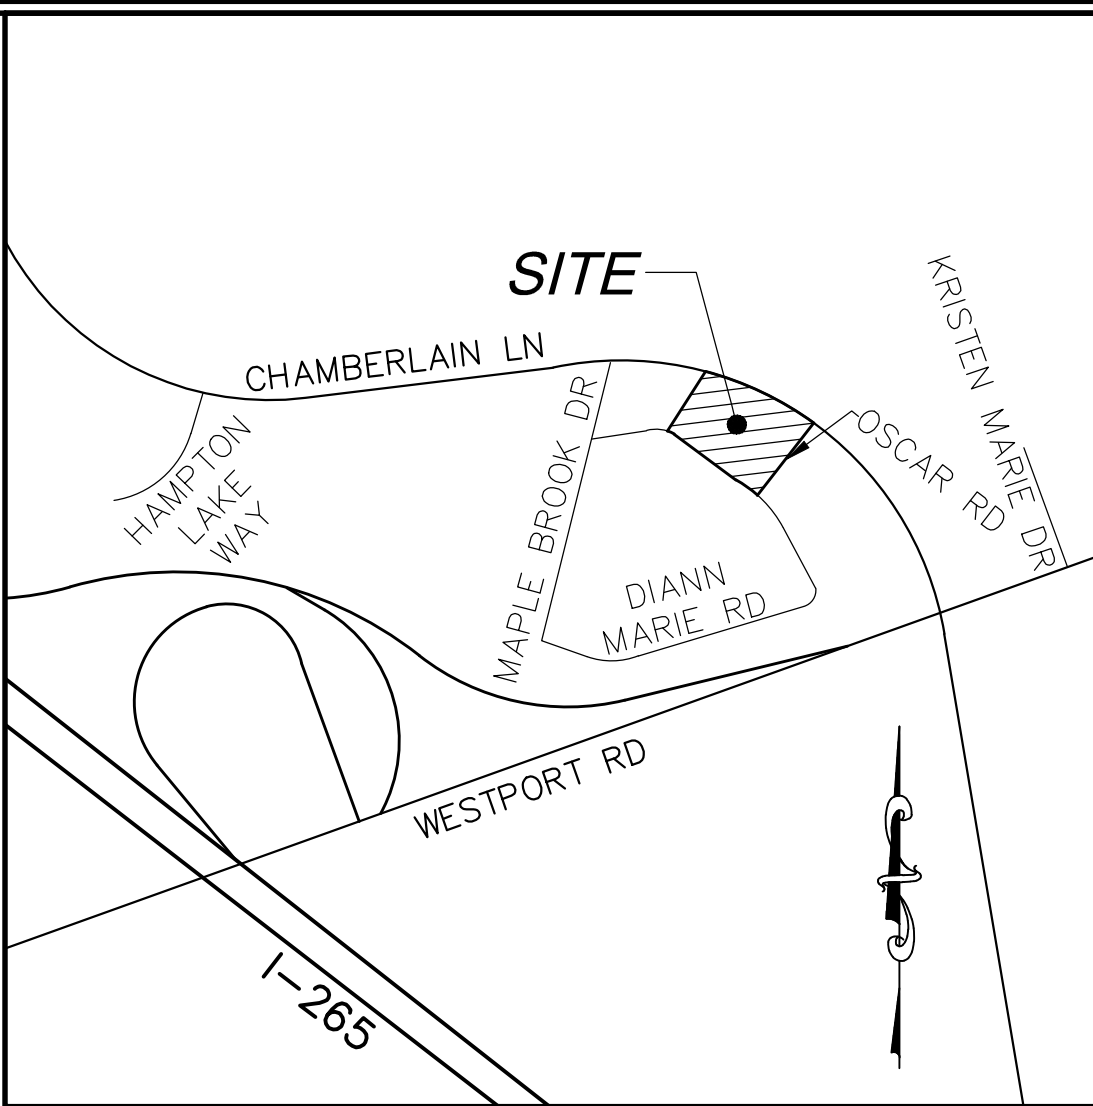

VICINITY MAP
NOT TO SCALE

TBM INFORMATION

- TBM#1 - SQUARE CUT IN CONCRETE CURB LOCATED SOUTH OF THE INTERSECTION OF OSCAR ROAD AND DIANN MARIE ROAD.
ELEVATION: 702.79 NAVD 88
- TBM#2 - SQUARE CUT IN CONCRETE CURB LOCATED 28'± NORTH OF SOUTHWEST PROPERTY CORNER.
ELEVATION: 707.42 NAVD 88

LEGEND

SEE "GENERAL NOTES AND LEGEND" SHEET C0.1 FOR LEGEND OF PROPOSED CONSTRUCTION AND "REFERENCE SURVEY" SHEET C0.2 FOR LEGEND OF EXISTING CONDITIONS.

FLOOD NOTE

THE PROPERTY SHOWN HEREON IS NOT LOCATED WITHIN A 100 YEAR FLOOD ZONE AS INDICATED BY FLOOD INSURANCE RATE MAP NO. 21111C0019E DATED DECEMBER 5, 2006.

UTILITY NOTE


LOCATIONS OF UNDERGROUND UTILITIES ARE APPROXIMATE AND ARE BASED UPON AN ALTA/NSPS LAND TITLE SURVEY PREPARED BY PRISM ENGINEERING & DESIGN GROUP, LLC. NEITHER THE ENGINEER NOR HIS REPRESENTATIVES HAVE VERIFIED OR OBSERVED THE ACTUAL INSTALLATION OF THE UTILITIES SHOWN. EXACT LOCATIONS OF ALL EXISTING UTILITIES ARE NOT CERTAIN.

UTILITY PROTECTION NOTE

ALL UTILITIES ON THESE PLANS ARE APPROXIMATE. INDIVIDUAL SERVICE LINES ARE NOT SHOWN. THE CONTRACTOR OR SUB-CONTRACTOR SHALL NOTIFY THE UTILITY PROTECTION CENTER "KENTUCKY 811" (TOLL-FREE PHONE NO. 1-800-752-6007 OR LOCAL 502-266-5123), 48 HOURS IN ADVANCE OF ANY CONSTRUCTION ON THIS PROJECT. THIS NUMBER WAS ESTABLISHED TO PROVIDE ACCURATE LOCATION OF EXISTING BELOW GROUND UTILITIES (I.E.: CABLES, ELECTRICAL WIRES, TELEPHONE LINES, GAS, AND WATERLINES). THE CONTRACTOR SHALL BE RESPONSIBLE FOR BECOMING FAMILIAR WITH ALL UTILITY REQUIREMENTS SET FORTH ON THE PLANS AND IN THE TECHNICAL SPECIFICATIONS AND SPECIAL PROVISIONS.



PRISM ENGINEERING
& DESIGN GROUP, LLC
2309 WATKINSON TRAIL, SUITE 200
LOUISVILLE, KENTUCKY 40299
OFFICE (502) 491-8891
FAX (502) 491-8898
WWW.THEPRISMDESIGNGROUP.COM

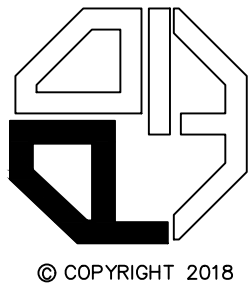

NOT FOR
CONSTRUCTION
FOR BIDDING
ONLY

Hardee's
HARDEE'S T-31ST
URBAN CONTEMPORARY PROTOTYPE
11201 OSCAR ROAD
LOUISVILLE, KY 40241

NO.	REVISIONS	DATE	
		DESCRIPTION	

SITE PLAN	DRAWN	CHECKED	APPROVED	PAGE

CKE SITE ID.:

DATE:
February 8, 2019

SHEET NUMBER:

C2.0

WM# 11867