

REVISIONS

3	03 26 02	PAINT SELECTION
2	02 20 02	TENANT REVISION
1	01 22 02	PERMIT SUBMITTAL
A	01 08 02	TENANT REVIEW
ISSUE NO.	DATE	ITEM

PROFESSIONAL STAMP

PROJECT INFORMATION

INTERCON NW
FIFE LANDING NORTH
Building B
FIFE, Washington

SHEET INFORMATION

RELEASE FOR: TENANT REVIEW
TITLE: FLOOR PLANS
DESIGNED BY: RT
DRAWN BY: RT
REVIEWED BY: RB
APPROVED BY: RB
DATE: 01 08 02
SHEET NO:
PROJECT NO: 97016.148.1145

A2.1


KEYNOTES

- 1 GWB ON ROOM SIDE ONLY.
2 EXIST CONC TILT-UP WALL PANEL


ELECTRICAL LAYOUT KEYNOTES

- ▲ TELEPHONE DATA
⦿ POWER DEDICATED
⦿ POWER

* PROVIDE EXIT SIGN PER
GENERAL NOTE #9/SHT T1.1

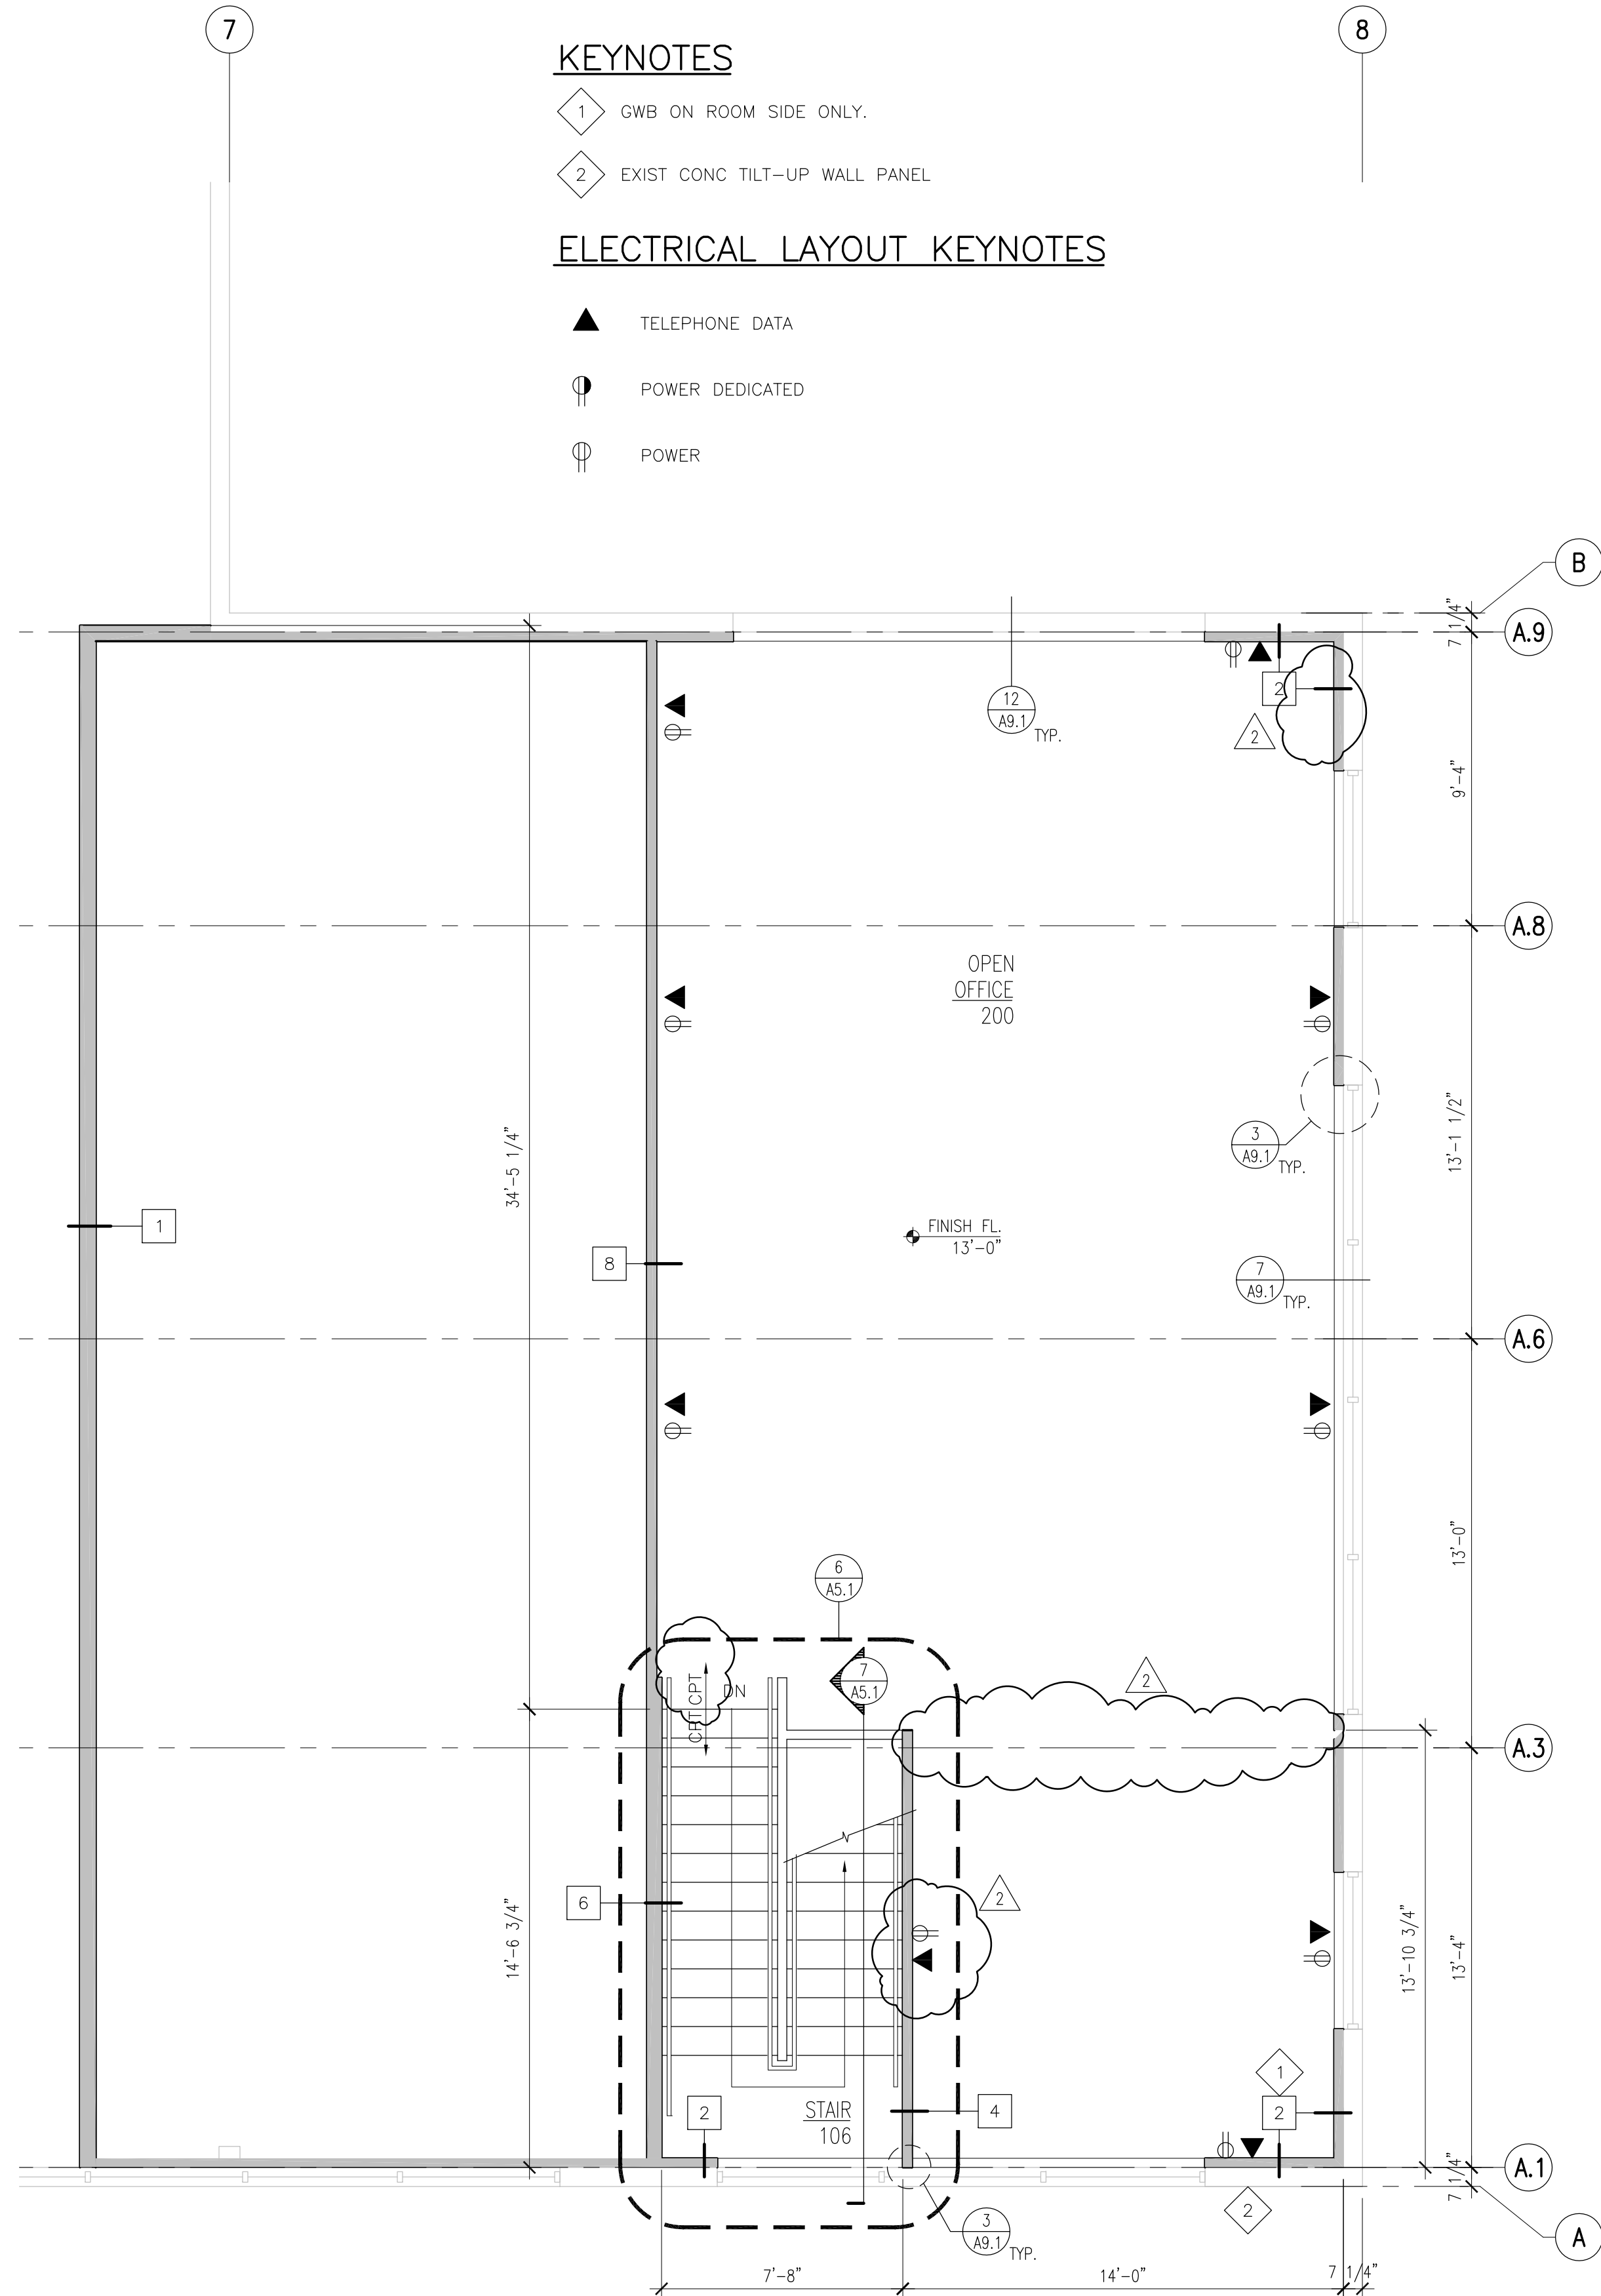

NORTH
SECOND FLOOR PLAN
SCALE: 1/4"=1'-0"

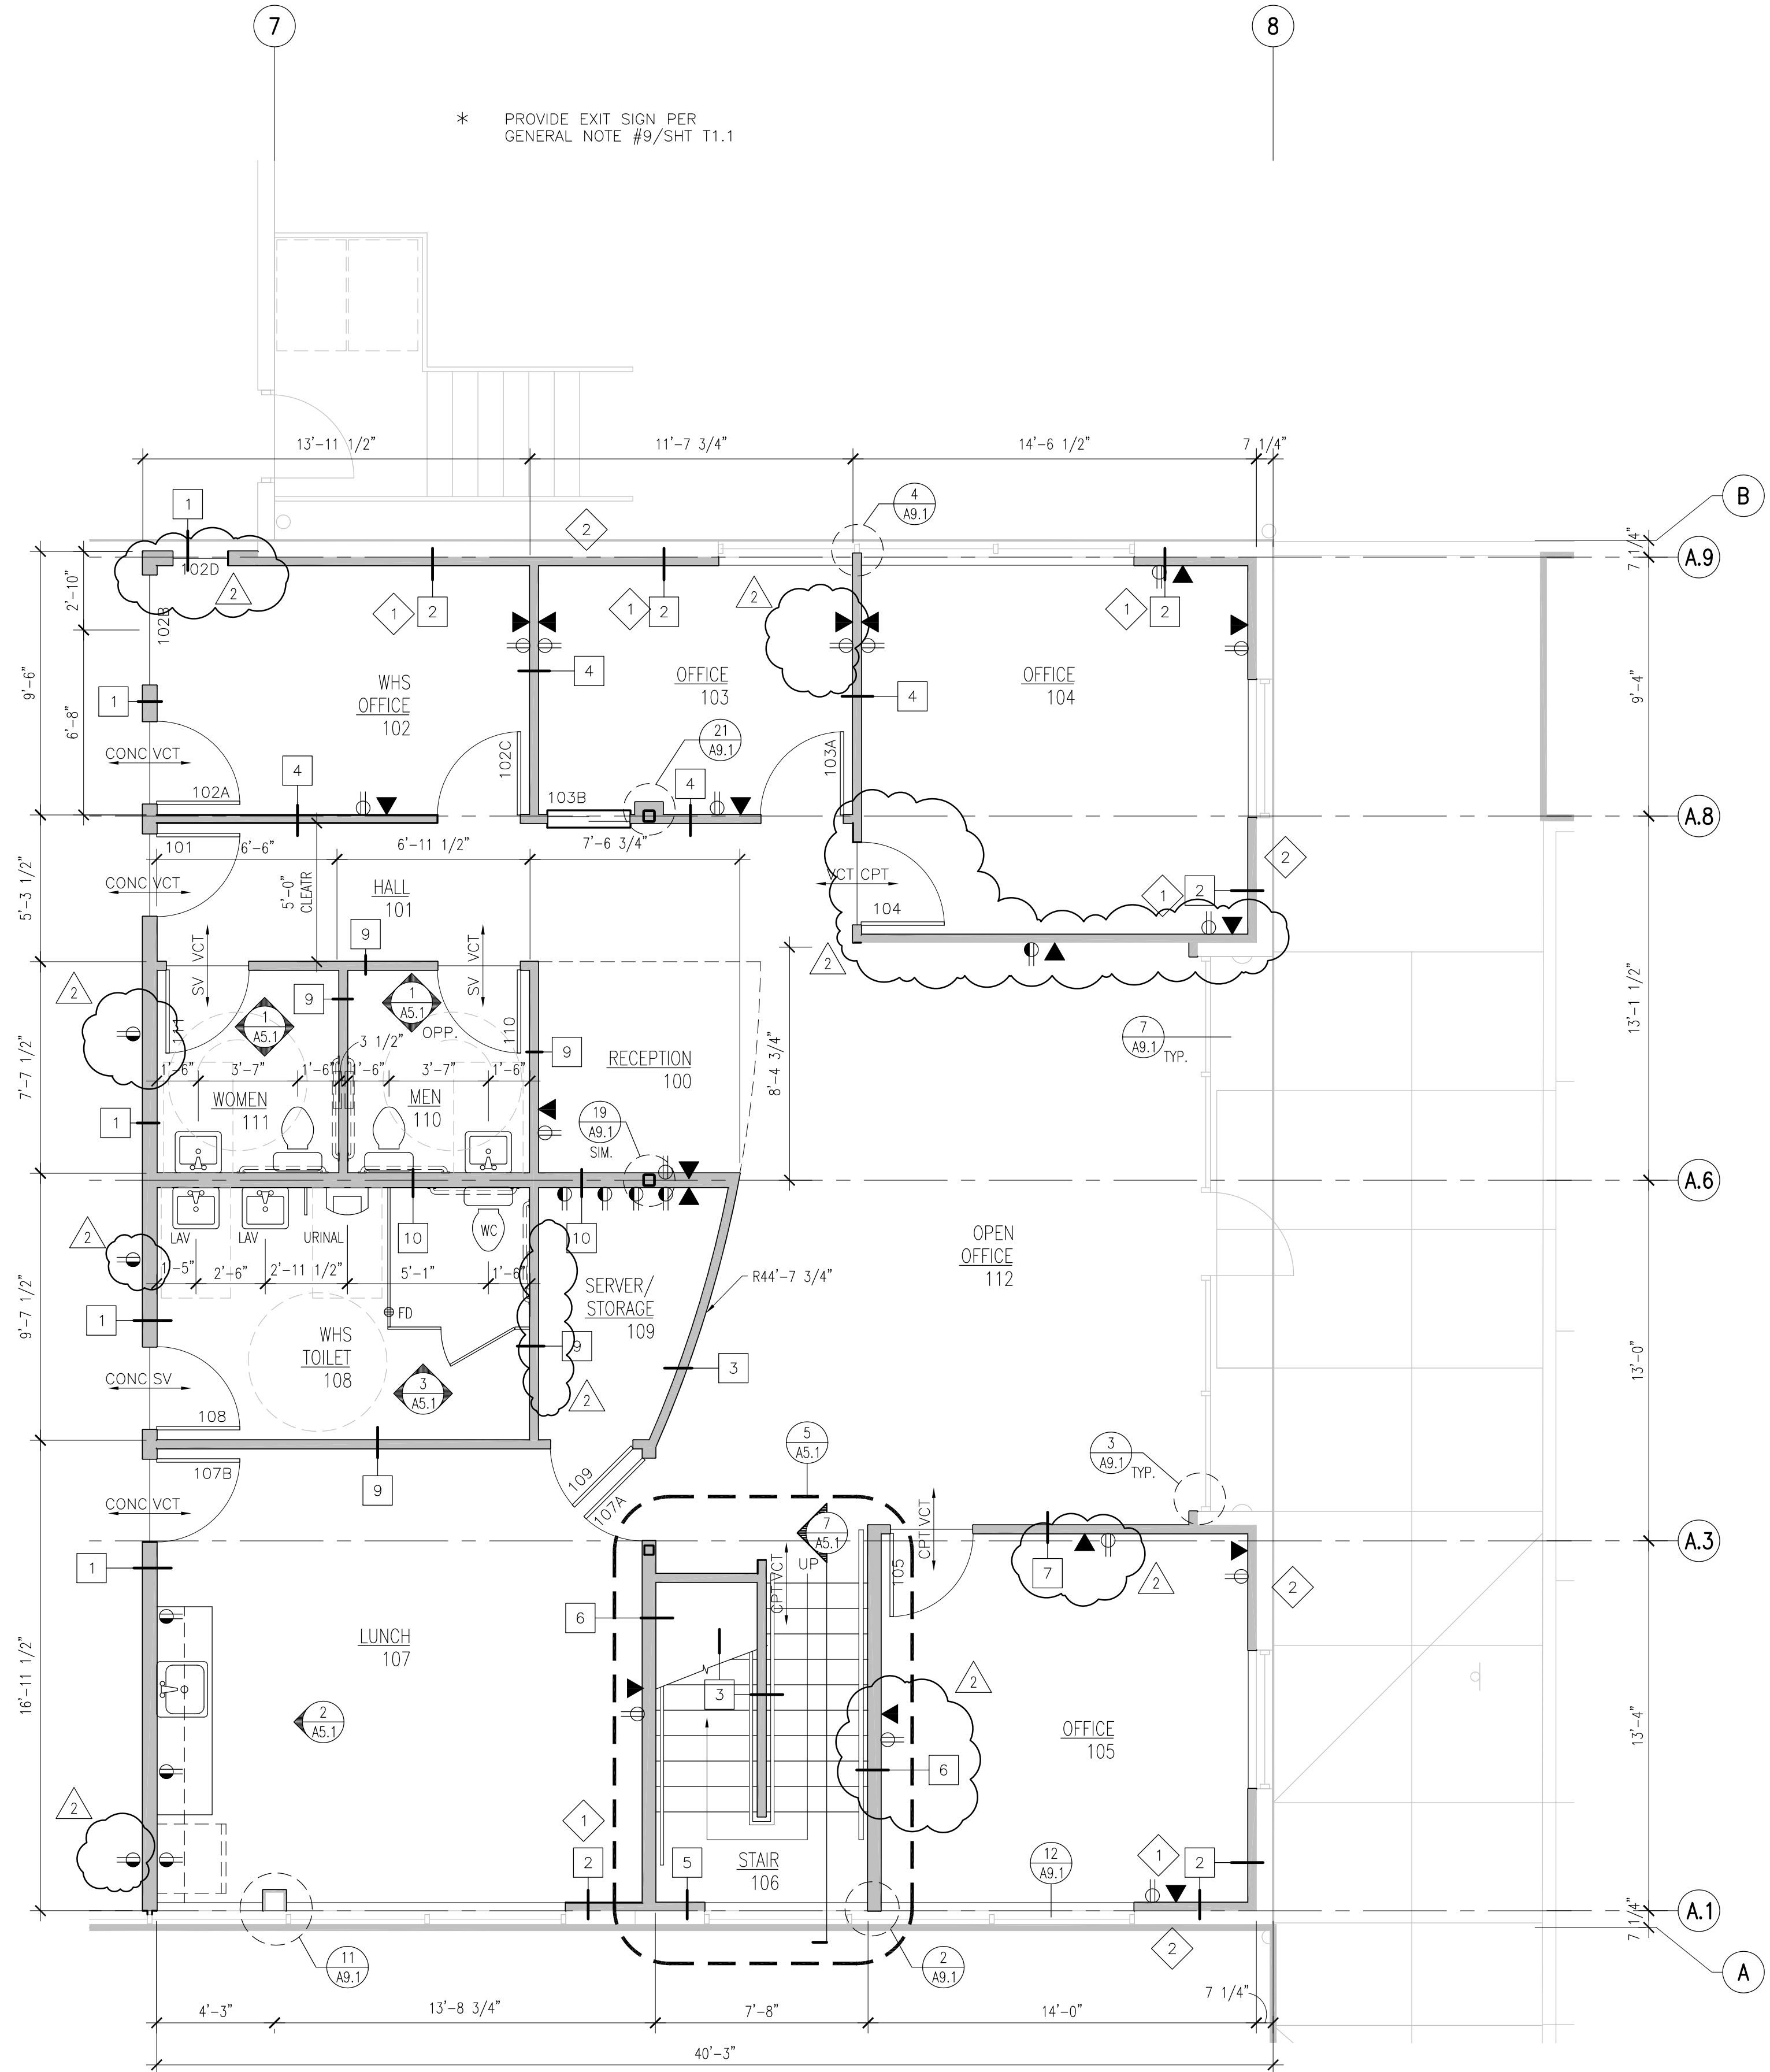

NORTH
FIRST FLOOR PLAN
SCALE: 1/4"=1'-0"