
 


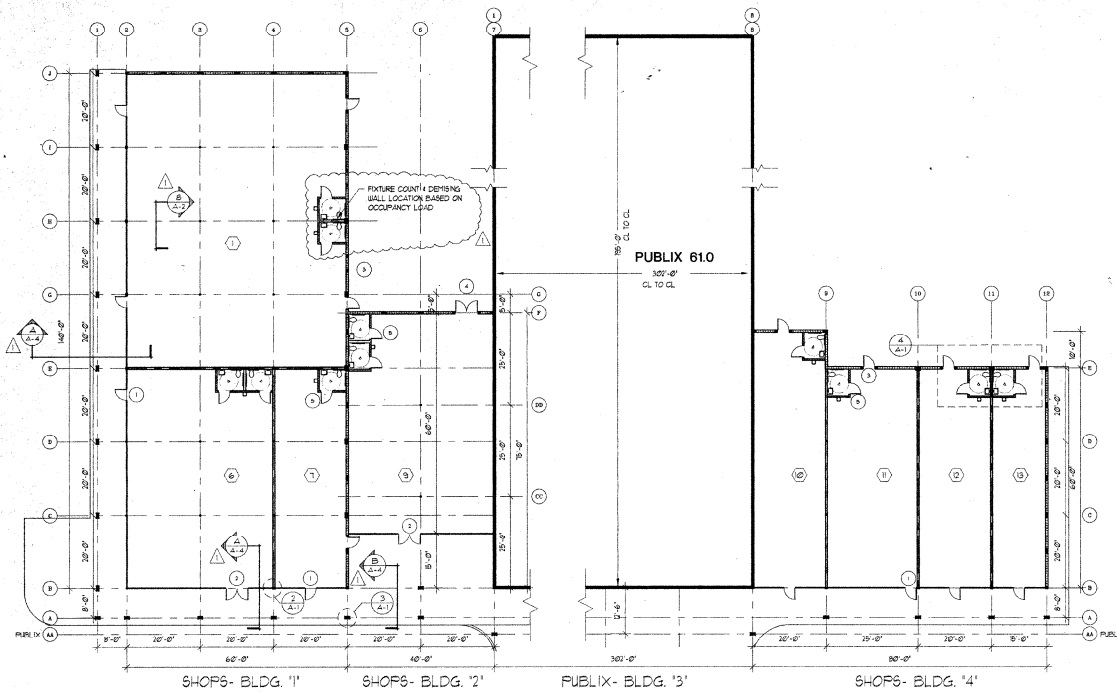


1 FLOOR PLAN

A-1 SCALE 1/8"=1'-0"




2 TYPICAL DEMISING PARTITION DETAIL

 A-1 SCALE 1/2"=1'-0"




2A TYPICAL DEMISING PARTITION SECTION

A-1 SCALE 1/2"=1'-0"

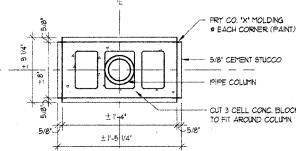


3 TYPICAL SIDEWALK COLUMN DETAIL (SHOPS ONLY)

A-1 SCALE 1/2"=1'-0"

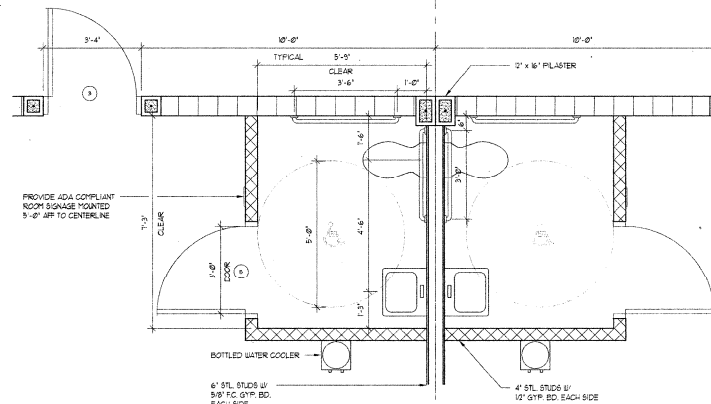

4 ACCESSIBLE TOILET PLAN (TYP) W/ REAR DOORS

A-1 SCALE 1/2"=1'-0"

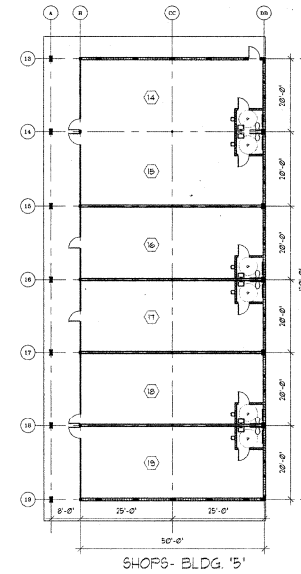

GENERAL NOTES

- OCCUPANCY CLASS "MERCANTILE"
- ALL BUILDINGS ARE TYPE IV - UNPROTECTED
-NO FIRE SPRINKLER
-NO FIRE ALARM SYSTEM
- MATERIALS
ROOF STRUCTURE: NON-COMBUSTIBLE BUILT-UP ROOFING
CLASS "A" ON 1" INSULATION BOARD ON 1/2" STEEL
DECKING ON STEEL BAR JOISTS @ 24" O.C. 3 PLY
EXTERIOR WALLS: 8" CMH WITH DWR-G-BAL + 1/2" OC
(PAINT)
INTERIOR DEMISING WALLS: 5/8" PRECAST SHEETROCK
EACH SIDE OF 8" STEEL STUDS @ 16" O.C. FULL HEIGHT
TO ROOF DECK (1 HR FIRE RATING - UL 485)
STOREFRONTS: NOM 2 X 4 ALUM. FRAME WITH 1/4"
TEMPERED GLASS + 3/4" X 7/8" ALUM. GLASS DOOR
(CLEAR ANCHORED ALUM.)
CEILING: 2" X 4" X 5/8" TEXTURED CEILING BOARD
IN 2" X 4" ALUM. GRID SUSPENSION SYSTEM (WHITE)
REAR EXTERIOR DOORS: 3/4" X 7/8" FLUSH HOLLOW
METAL DOORS IN HOLLOW METAL FRAMES
THE COMPLETED CONSTRUCTION OF THESE
TENANT SHOPS SHALL ADHERE TO PERMIT
CONSTRUCTION QUALITIES AND TYPES IN
SECTIONS OF THE COMPLETE PUBLIX
SPECIFICATIONS, ON SHEETS PM-1 TO PM-8
OF PUBLIX PLANS, EXCEPT AS MAY BE
NOTED HEREIN, INCLUDING PLUMBING & ELECTRICAL.
PUBLIX TECHNICAL SPECS. AND FINISHES
DO NOT NECESSARILY PERTAIN TO TENANT SHOPS.

DOOR SCHEDULE

1	3/4" X 7/8" ANCHORED ALUMINUM FULL GLASS STOREFRONT DOOR W/ THRESHOLD, WITH 1/4" TEMPERED GLASS, CLOSER, DEADBOLT LOCK, PUSH, PULL
2	PAIR OF 3/4" X 7/8" ANCHORED ALUMINUM FULL GLASS STOREFRONT DOOR, WITH 1/4" TEMPERED GLASS, CLOSERS, DEADBOLT LOCK, PUSH, PULL, W/ THRESHOLD
3	3/4" X 6-1/2" HOLLOW METAL FRAME DOOR IN HOLLOW METAL FRAME W/ LOCKSET, CLOSER, THRESHOLD, + LOCKGUARD (PAINT FINISH)
4	PAIR OF 3/4" X 6-1/2" HOLLOW METAL FRAME DOORS IN HOLLOW METAL FRAME W/ LOCKSET, CLOSER ON ACTIVE DOOR, THRESHOLD, LOCKGUARD, BOTT. PIN HOLDER (PAINT FINISH)
5	3/4" X 6-1/2" WOOD FRAME W/ PRIVACY LOCK, DOOR STOP (PAINT FINISH)


DOORS 1 + 2 W/ 1/2" PR. BUTTS, SECURED PIN

FINAL LOCATIONS OF DOORS 1 + 2 + 4 DETERMINED BY TENANT

IF LEARNED BEFORE INSTALLATION

ALL DOORS ON ACCESSIBLE ROUTE SHALL HAVE LEVER OPERATED MECHANISMS.

PUSH-TYPE MECHANISMS ON U-SHAPED HANDLES.

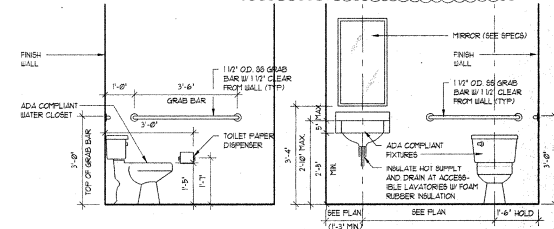

5 ACCESSIBLE TOILET MOUNTING HEIGHTS

A-1 SCALE 1/2"=1'-0"

W.H. DYER CO.
2411 MILL CREEK CT
TALLAHASSEE, FLORIDA

LAKE ELLA PLAZA
TALLAHASSEE FLORIDA
BLACKBERRY & ASSOC.
MOBILE ALABAMA

FLOOR PLANS AND DETAILS DEC -4 2001

SCALE	DRAWN BY	DATE	REVISED	SHEET
VARIES	IH	6/4/01	1/11/2001	A-1