
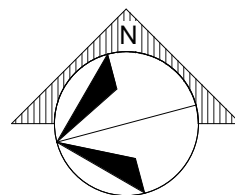


PROJECT NOTES

- ALL TILT PANEL WIDTHS ARE TO CENTERLINE OF CONCRETE PANEL VERTICAL JOINT U.N.O
- COORDINATE ALL MECH. ELEC. PLUMB. PENETRATIONS WITH THEIR RELATED DISCIPLINES. INSTALLER TO VERIFY ALL LOCATIONS AT CONCRETE SLAB.
- TILT PANEL LIFTING EYES AND BRACING HOLES TO BE GROUTED AND RUBBED SMOOTH.
- PAINT ALL STEEL COLUMNS:
 - FIRE EXTINGUISHER COLUMNS: SAFETY RED BELOW 12'-0" AFF
 - ALL OTHER COLUMNS: SAFETY YELLOW BELOW 12'-0" AFF
 - ALL COLUMNS: WHITE ABOVE 12'-0" AFF
- FIRE PROTECTION RISERS AND INSPECTOR LINES TO BE PAINTED RED
- FIRE SUPPRESSION SYSTEM TO BE A DEFERRED SUBMITTAL. SYSTEM TO MEET ALL APPLICABLE CODES. SUBMIT AND OBTAIN ALL STATE AND LOCAL APPROVALS PRIOR TO INSTALLATION.

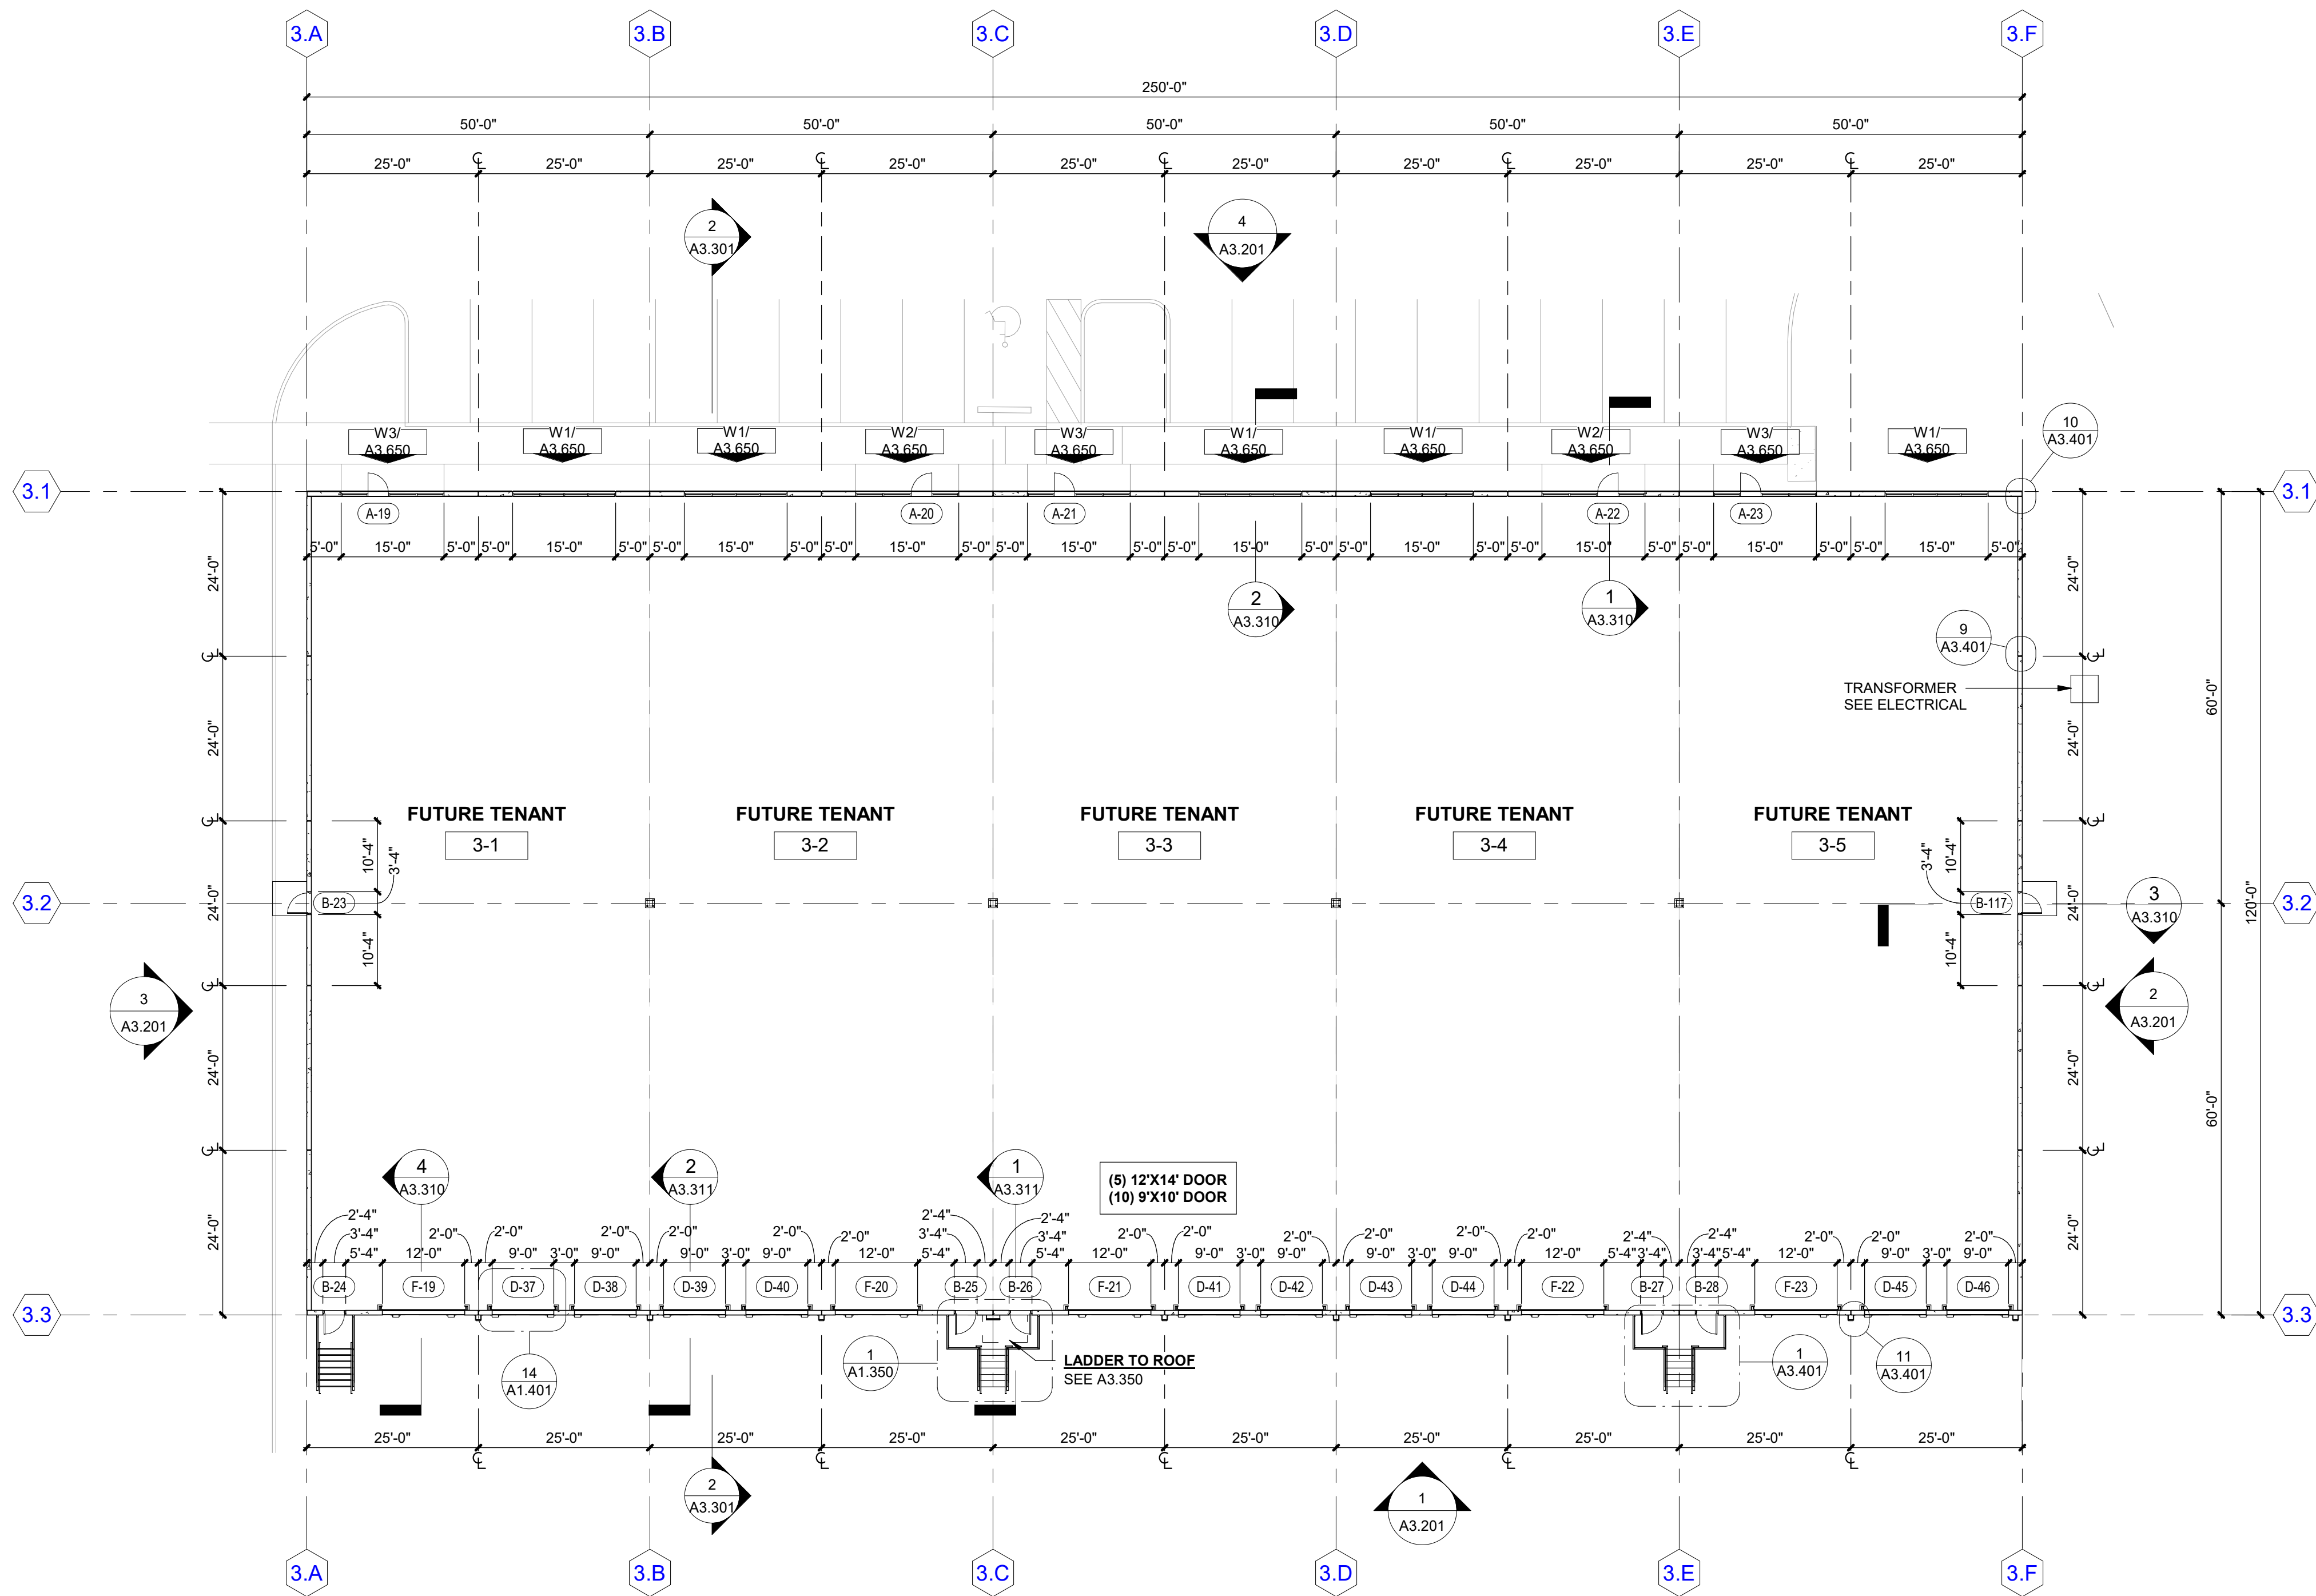

1 BUILDING 3 FLOOR PLAN
A3.101 SCALE: 1/16" = 1'-0"