


MEANS CHIROPRACTIC CENTER

LEE COUNTY, FLORIDA

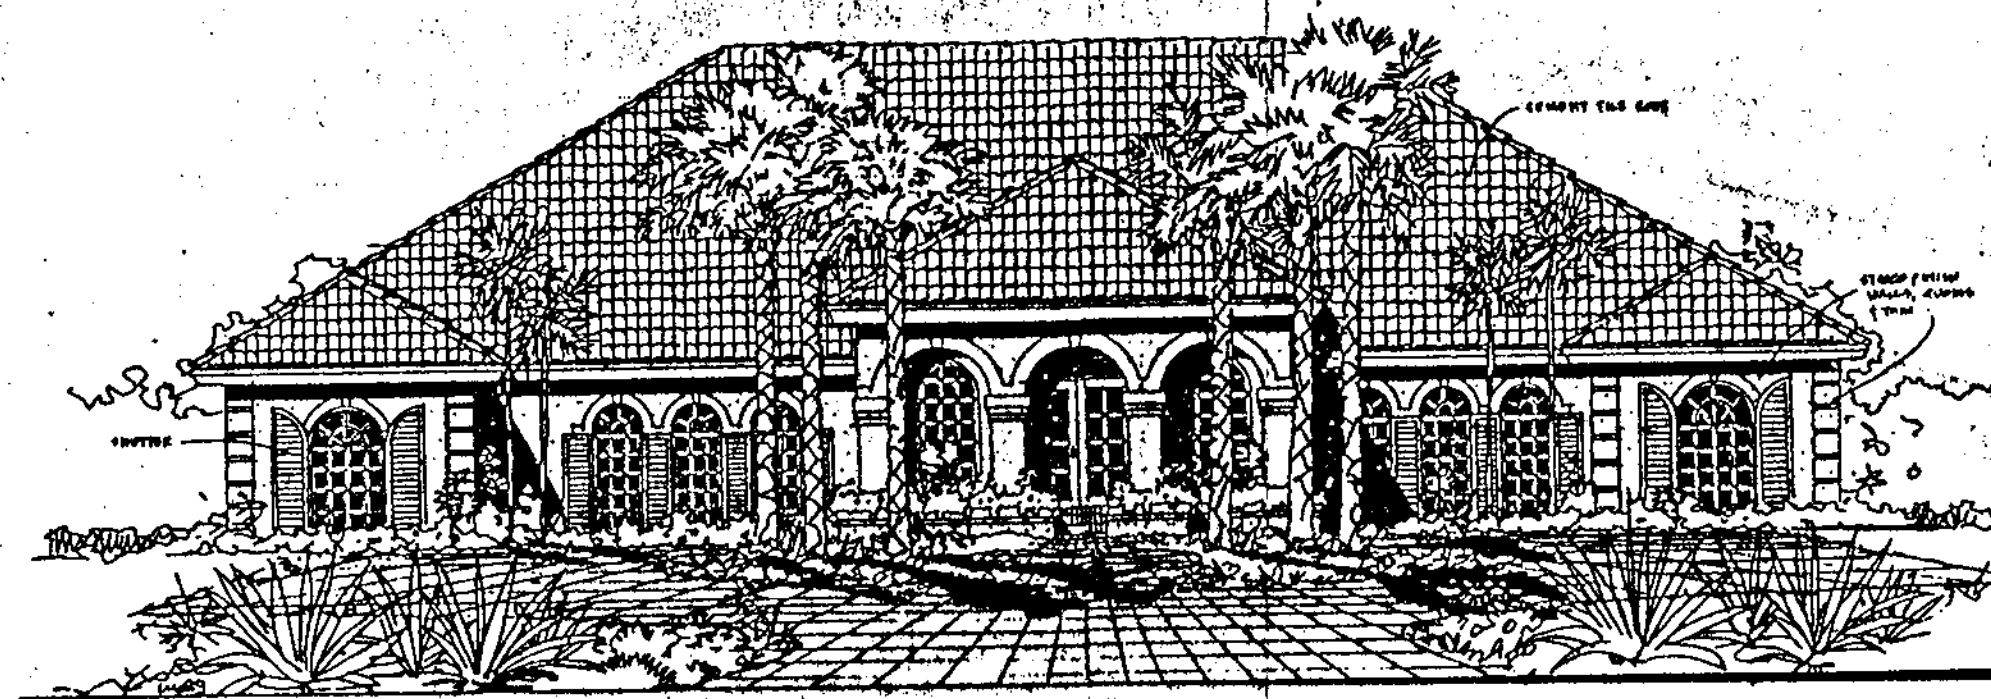

INDEX of DRAWINGS	
Pg. #	DESCRIPTION
A-1	FOUNDATION PLANS
A-2	FLOOR PLANS
A-3	FUTURE SECOND FLOOR PLUMBING
A-4	SECTIONS/PORT COCHERE RISER
A-5	FRONT ELEVATION-LL.DESIGN CONSTR.
A-6	LEFT & RIGHT SIDE ELEVATIONS
A-7	REAR ELEVATION/SECTIONS
A-8	H.V.A.C. LAYOUT
E-1	ELECTRICAL PLAN/ELEC. RISER
E-2	ELECTRICAL PLAN/LIGHTING
P-1	PLUMBING PLAN

REVISIONS	BY
JAN. 28, 1992	
FEB. 10, 1992	



RICHARD LEE WU
ASSOCIATES
ARCHITECTS
3400 Radio Rd., Suite 101
Naples, FL 33962


DRAWN	JDA
CHECKED	WU
DATE	11-24-91
SCALE	
JOB NO.	
SHEET	
COVER	

RICHARD LEE WU
ARCHITECT FL. CERT. NO. A00012785

REVISIONS	BY
JAN. 28, 1992	



DRS. RICKIE MARK MEANS

DRAWN
CHECKED
DATE 11-24-91
SCALE
JOB NO.
SHEET A-2
OF SHEETS

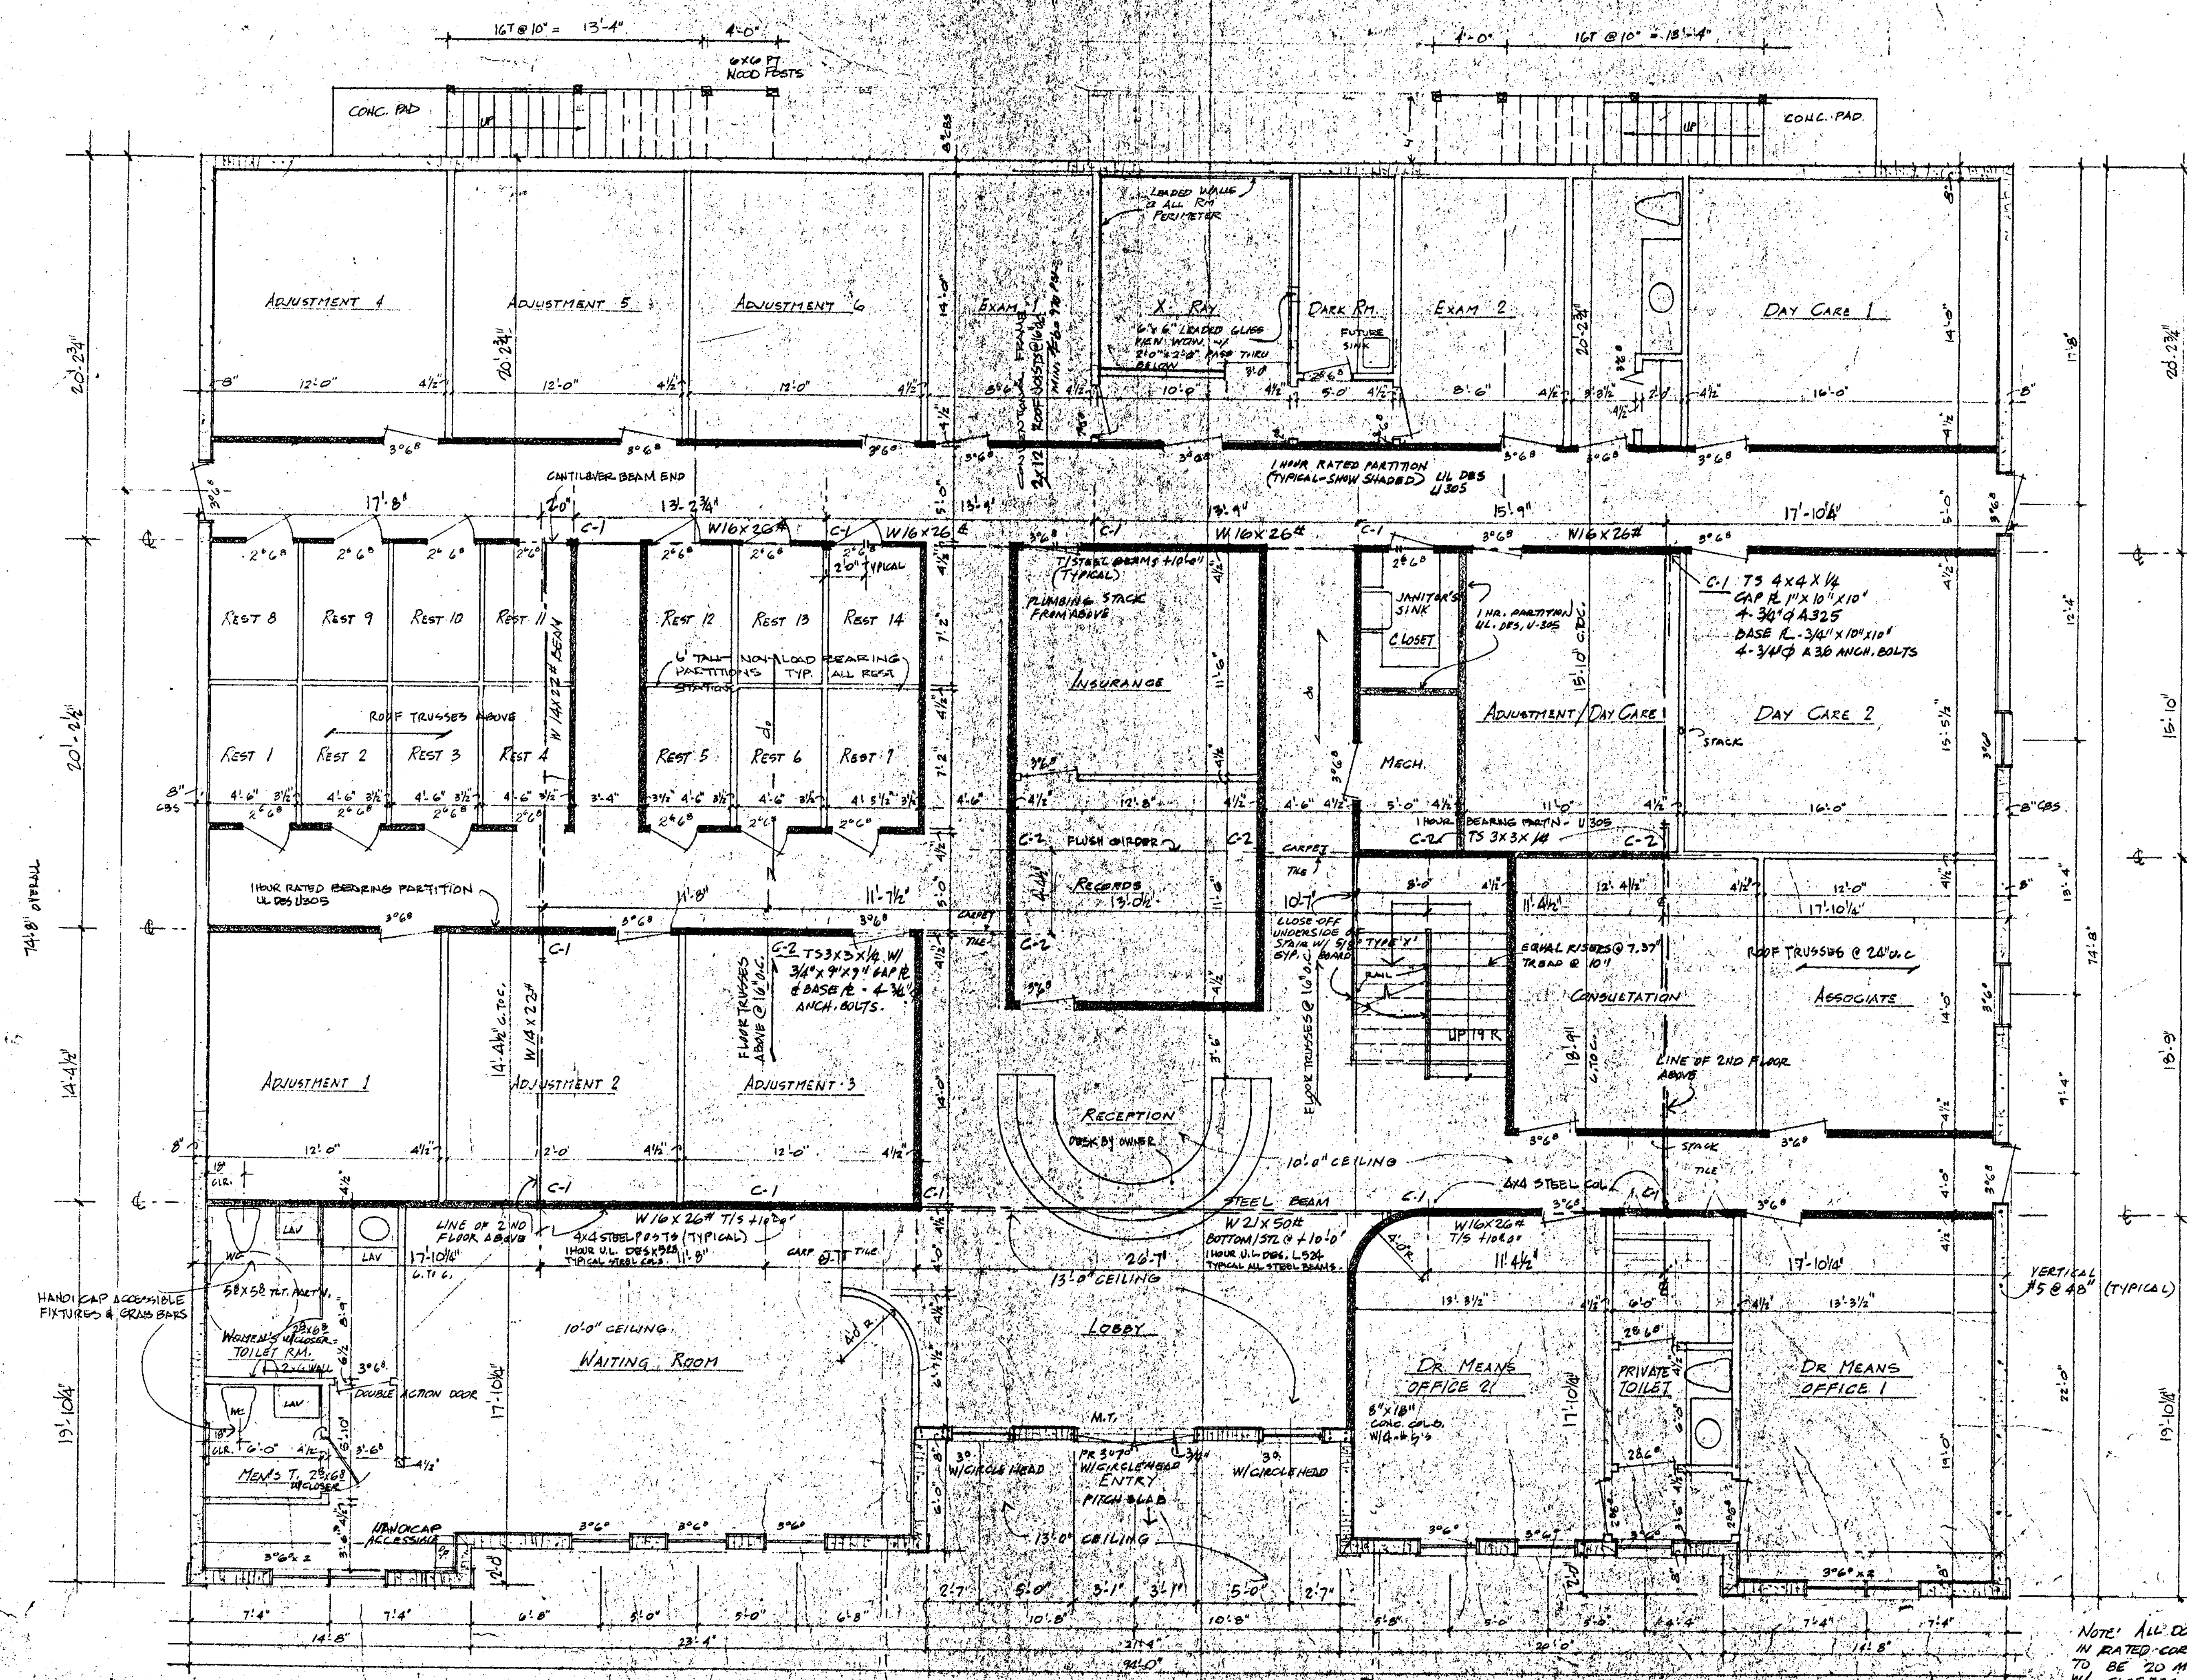

FLOOR PLAN 1/4"=1'-0"

DRAWN
CHECKED
DATE 11.24.91
SCALE
JOB NO.
SHEET

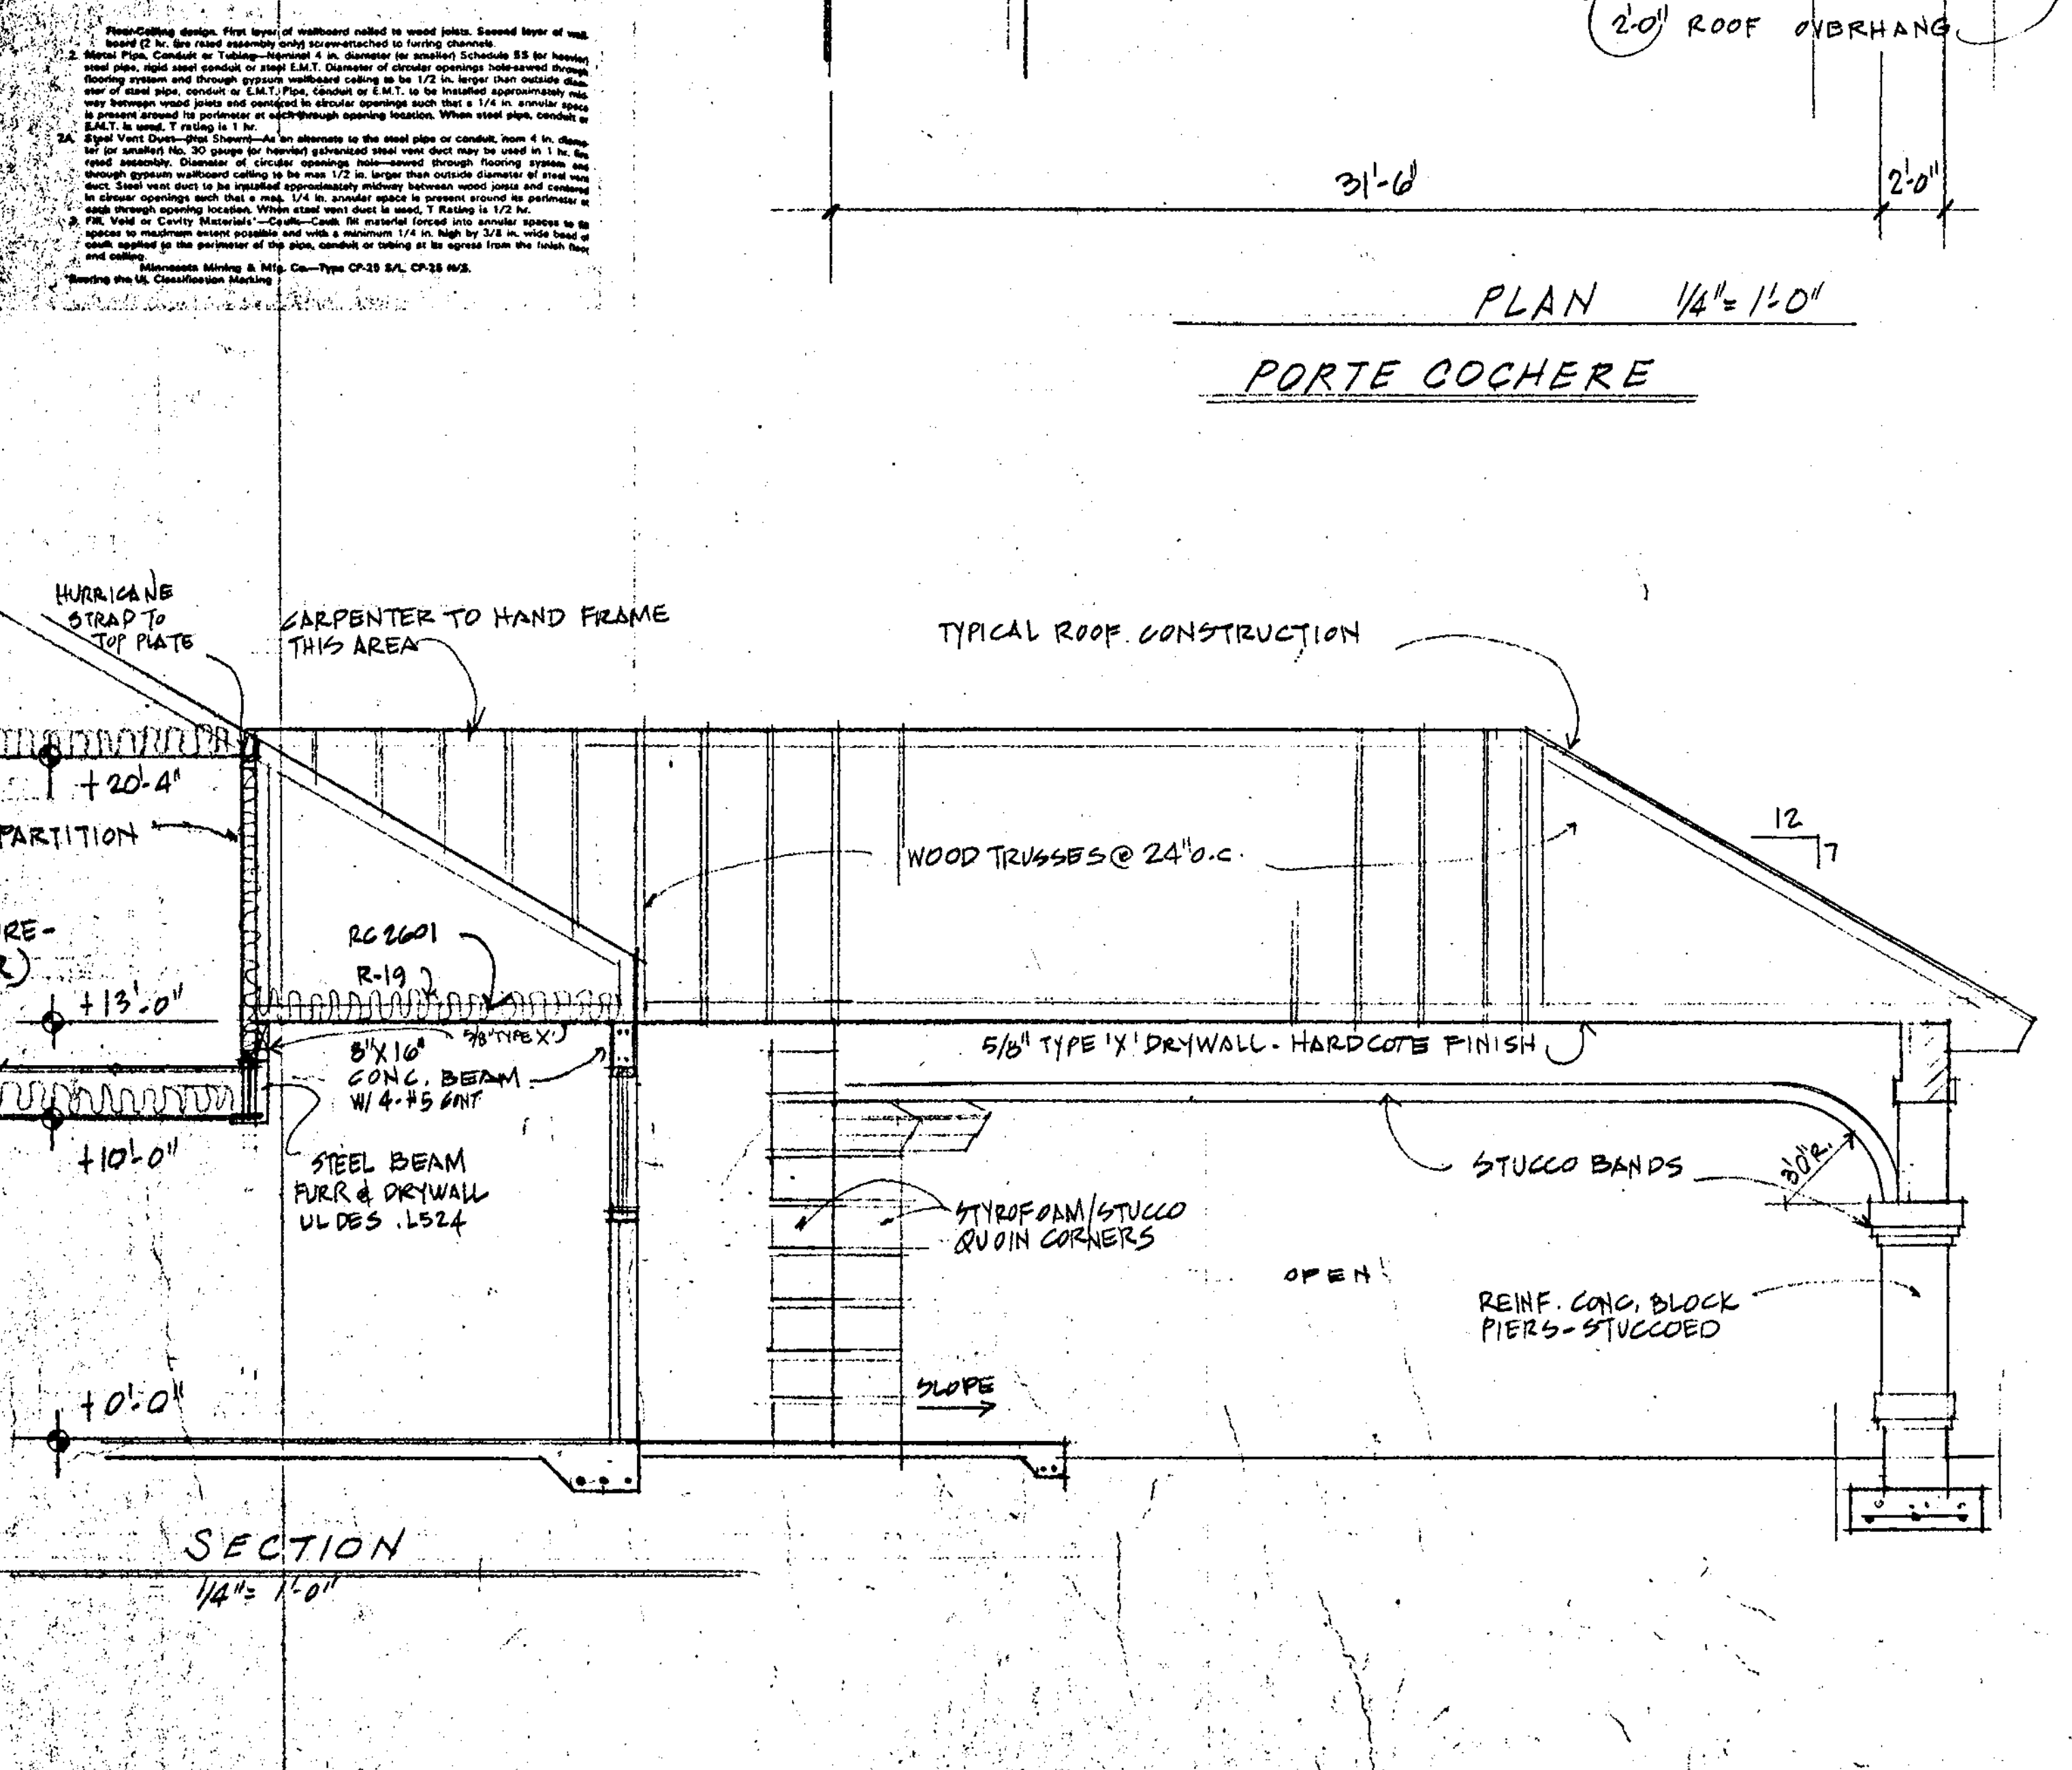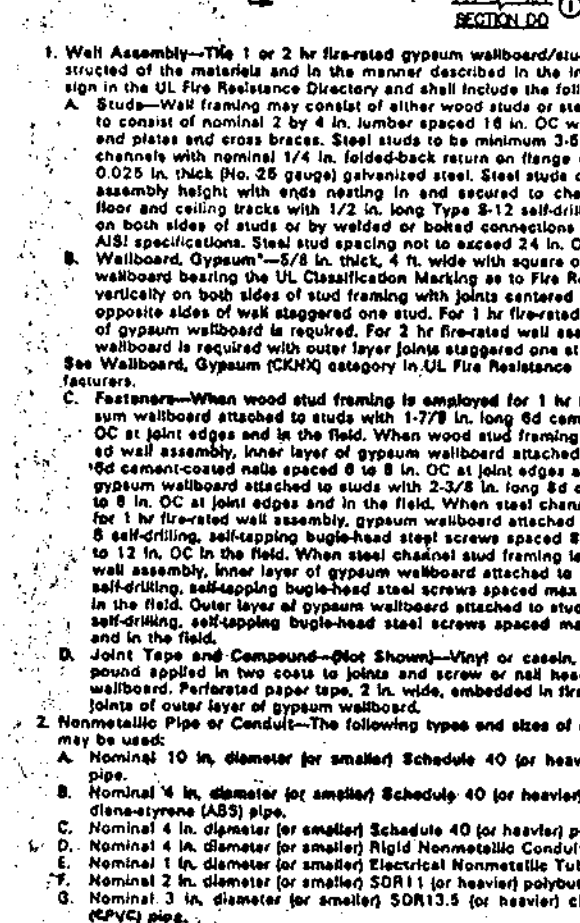
[illegible]

1. The first step is to identify the problem or question that needs to be answered. This involves understanding the context and the specific requirements of the task.


CP

REVISIONS	BY
JUN. 28, 1997	

DRAWN
CHECKED
DATE 11.24.91
SCALE
JOB NO.
SHEET
41.6
OF
SHEETS


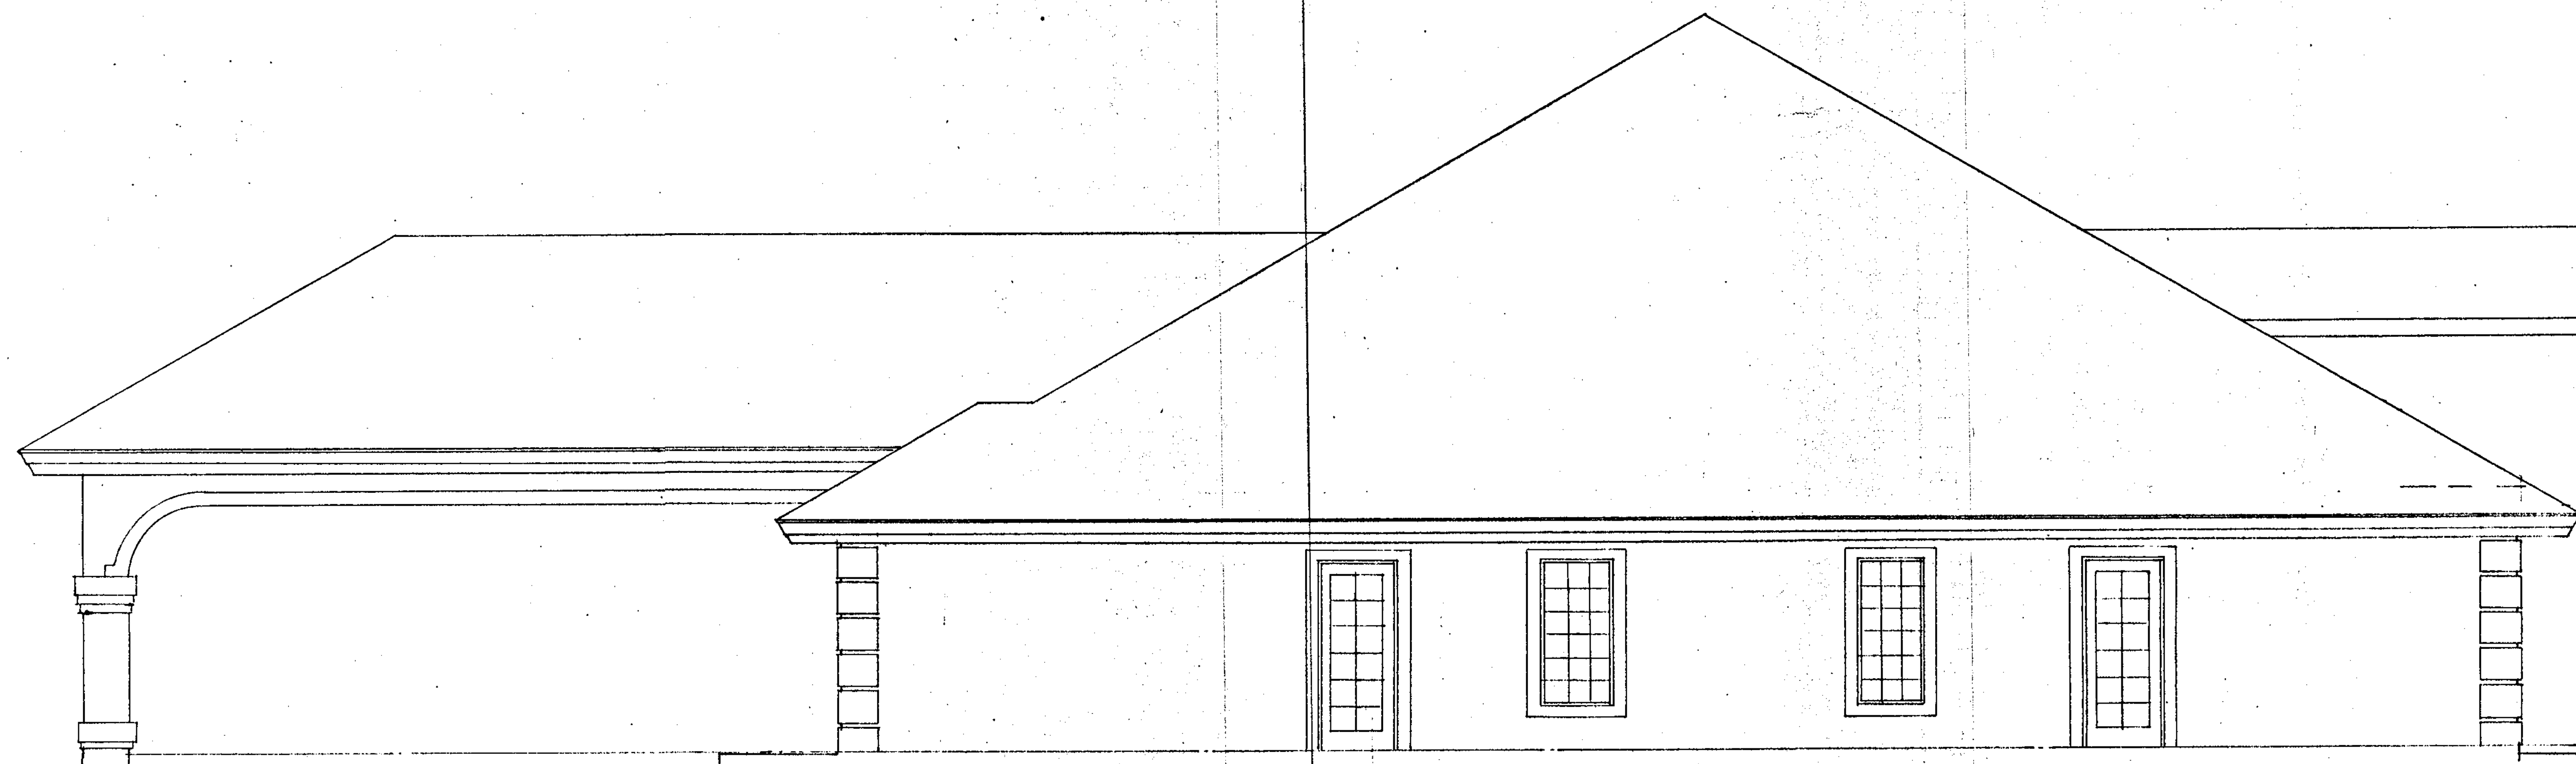


RIGHT SIDE ELEVATION
1/4" = 1'-0"

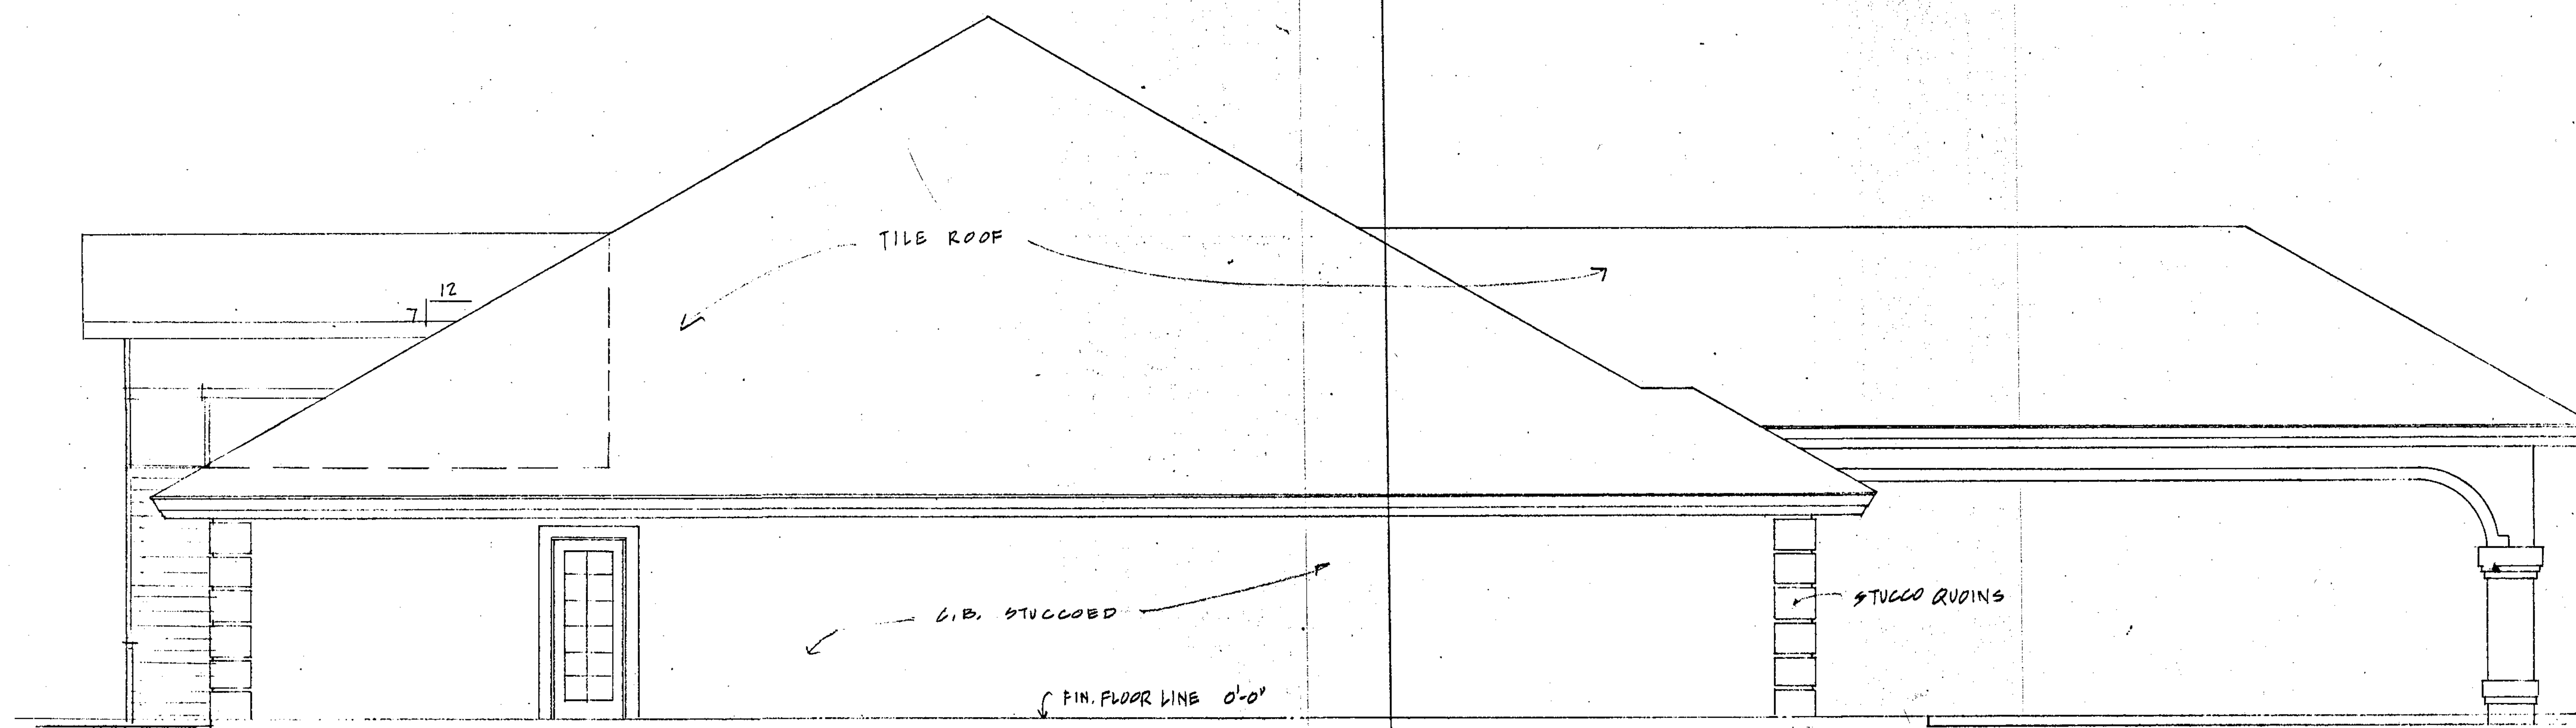

LEFT SIDE ELEVATION
1/4" = 1'-0"

REVISIONS	BY
JAN. 28, 1992	
FEB. 13, 1992	

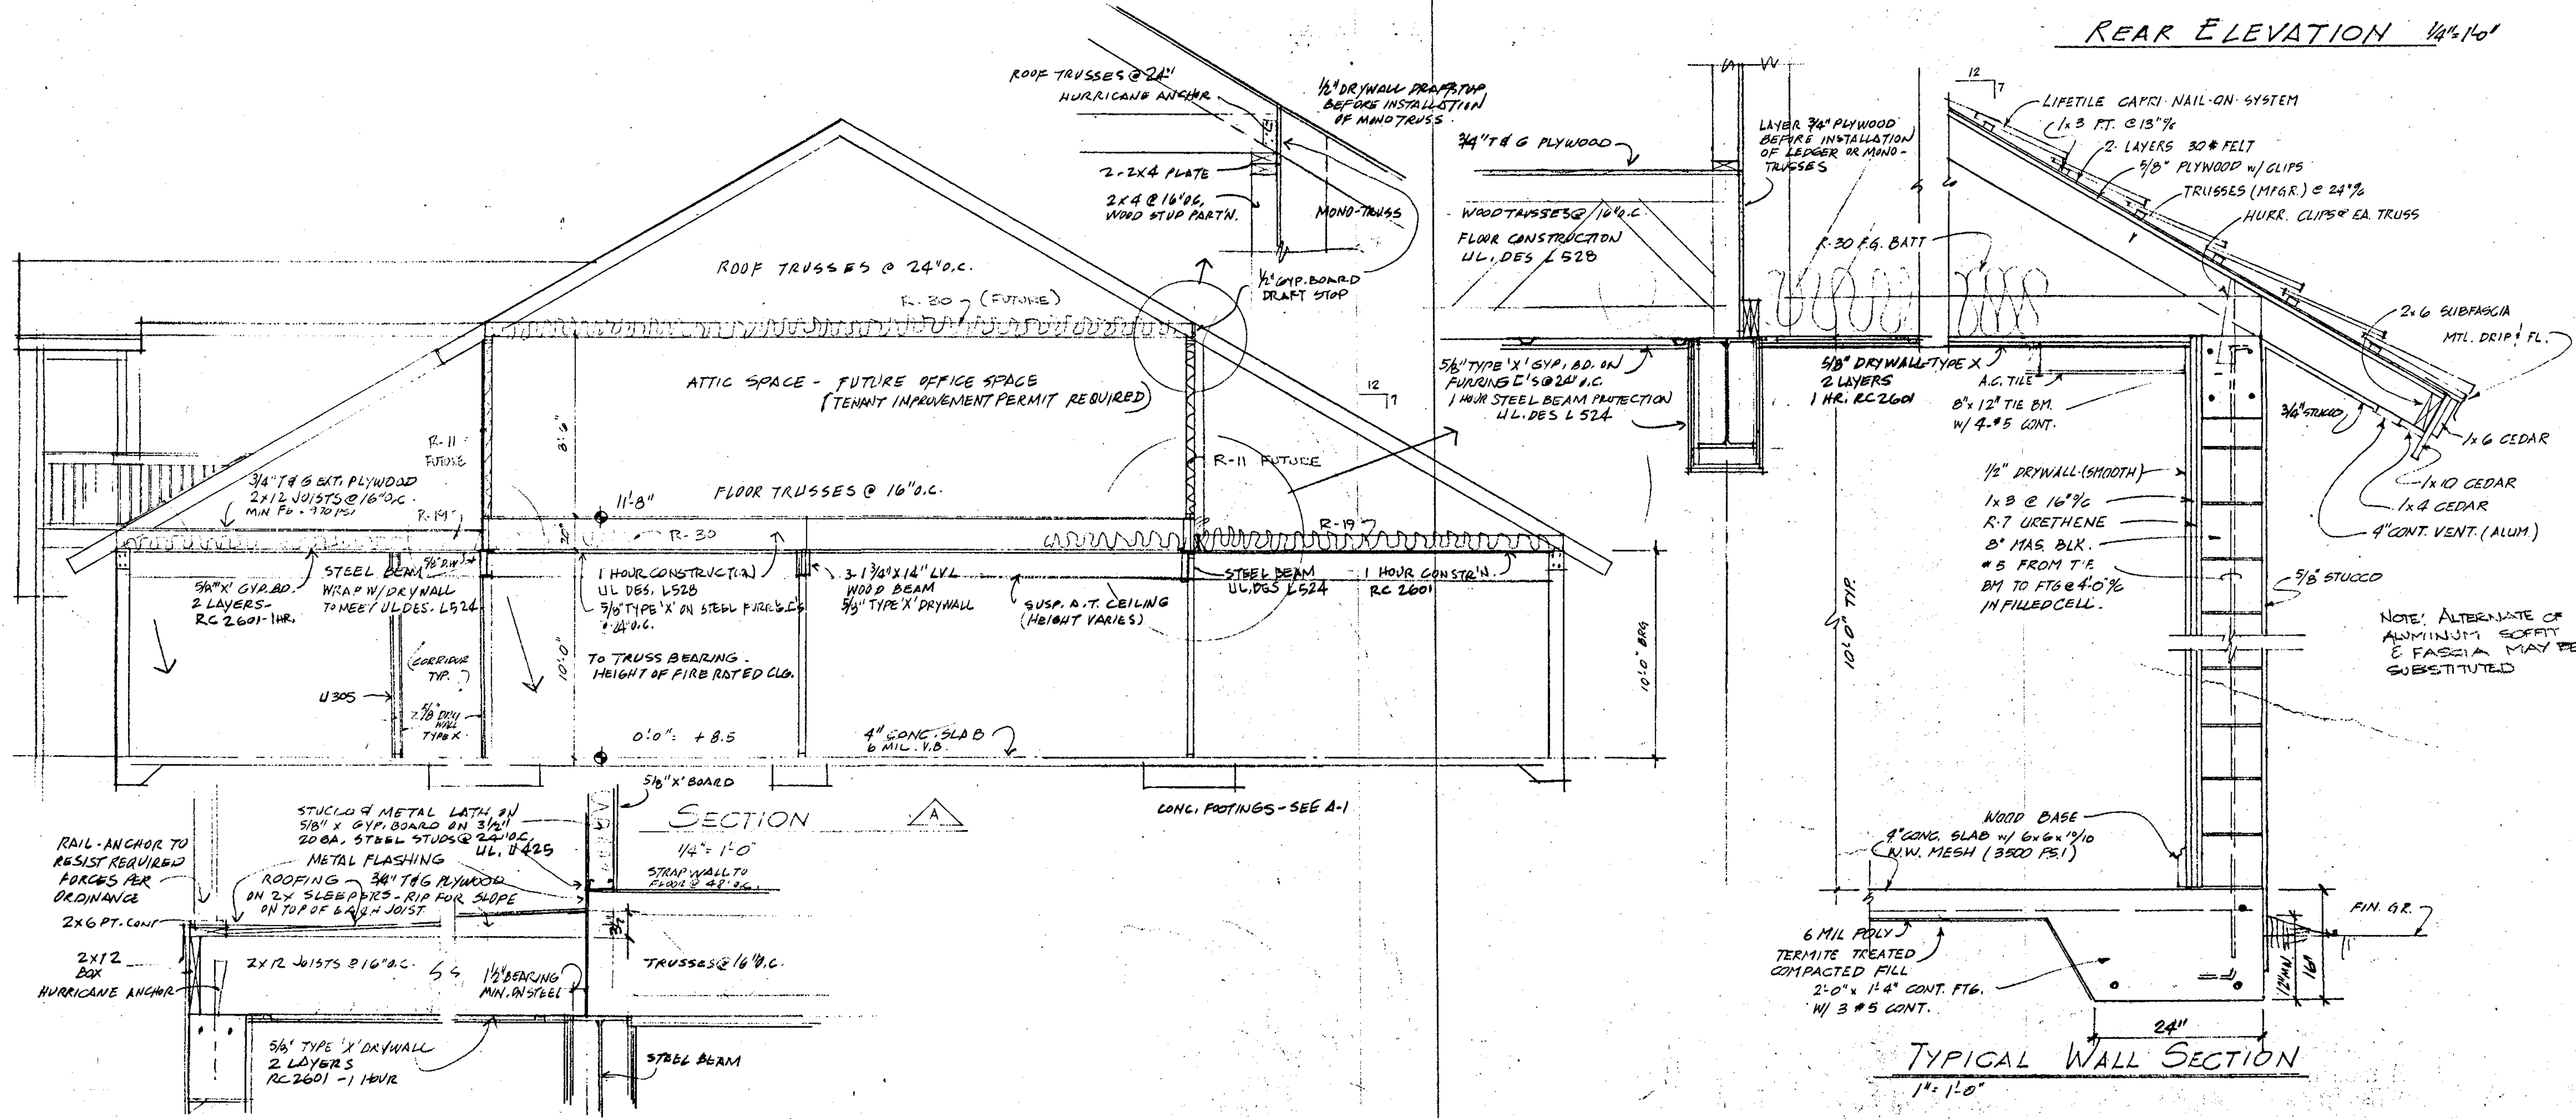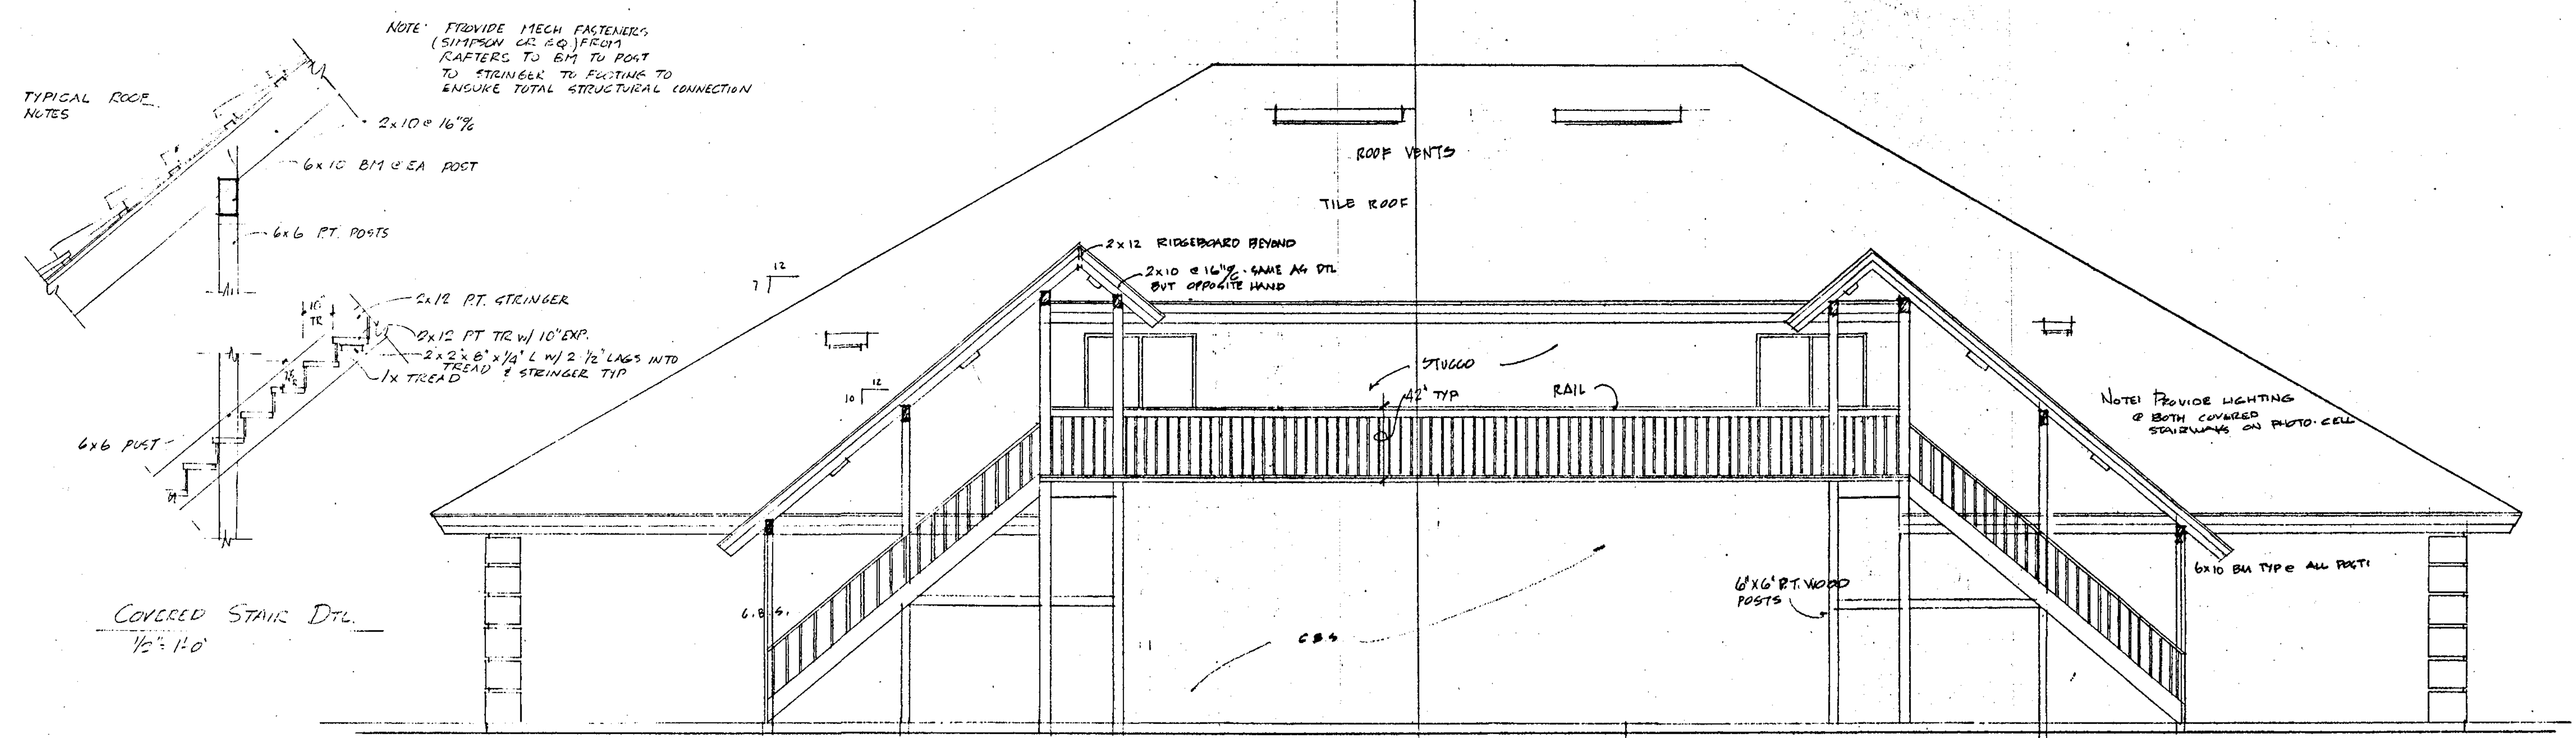

DRAWN
CHECKED
DATE 11.24.91
SCALE
JOB NO.
SHEET
A-7
OF SHEETS

DRAWN

CHECKED

DATE
11-24-91


SCALE


JOB NO.

SHEET

AL-88

OF **SHEETS**

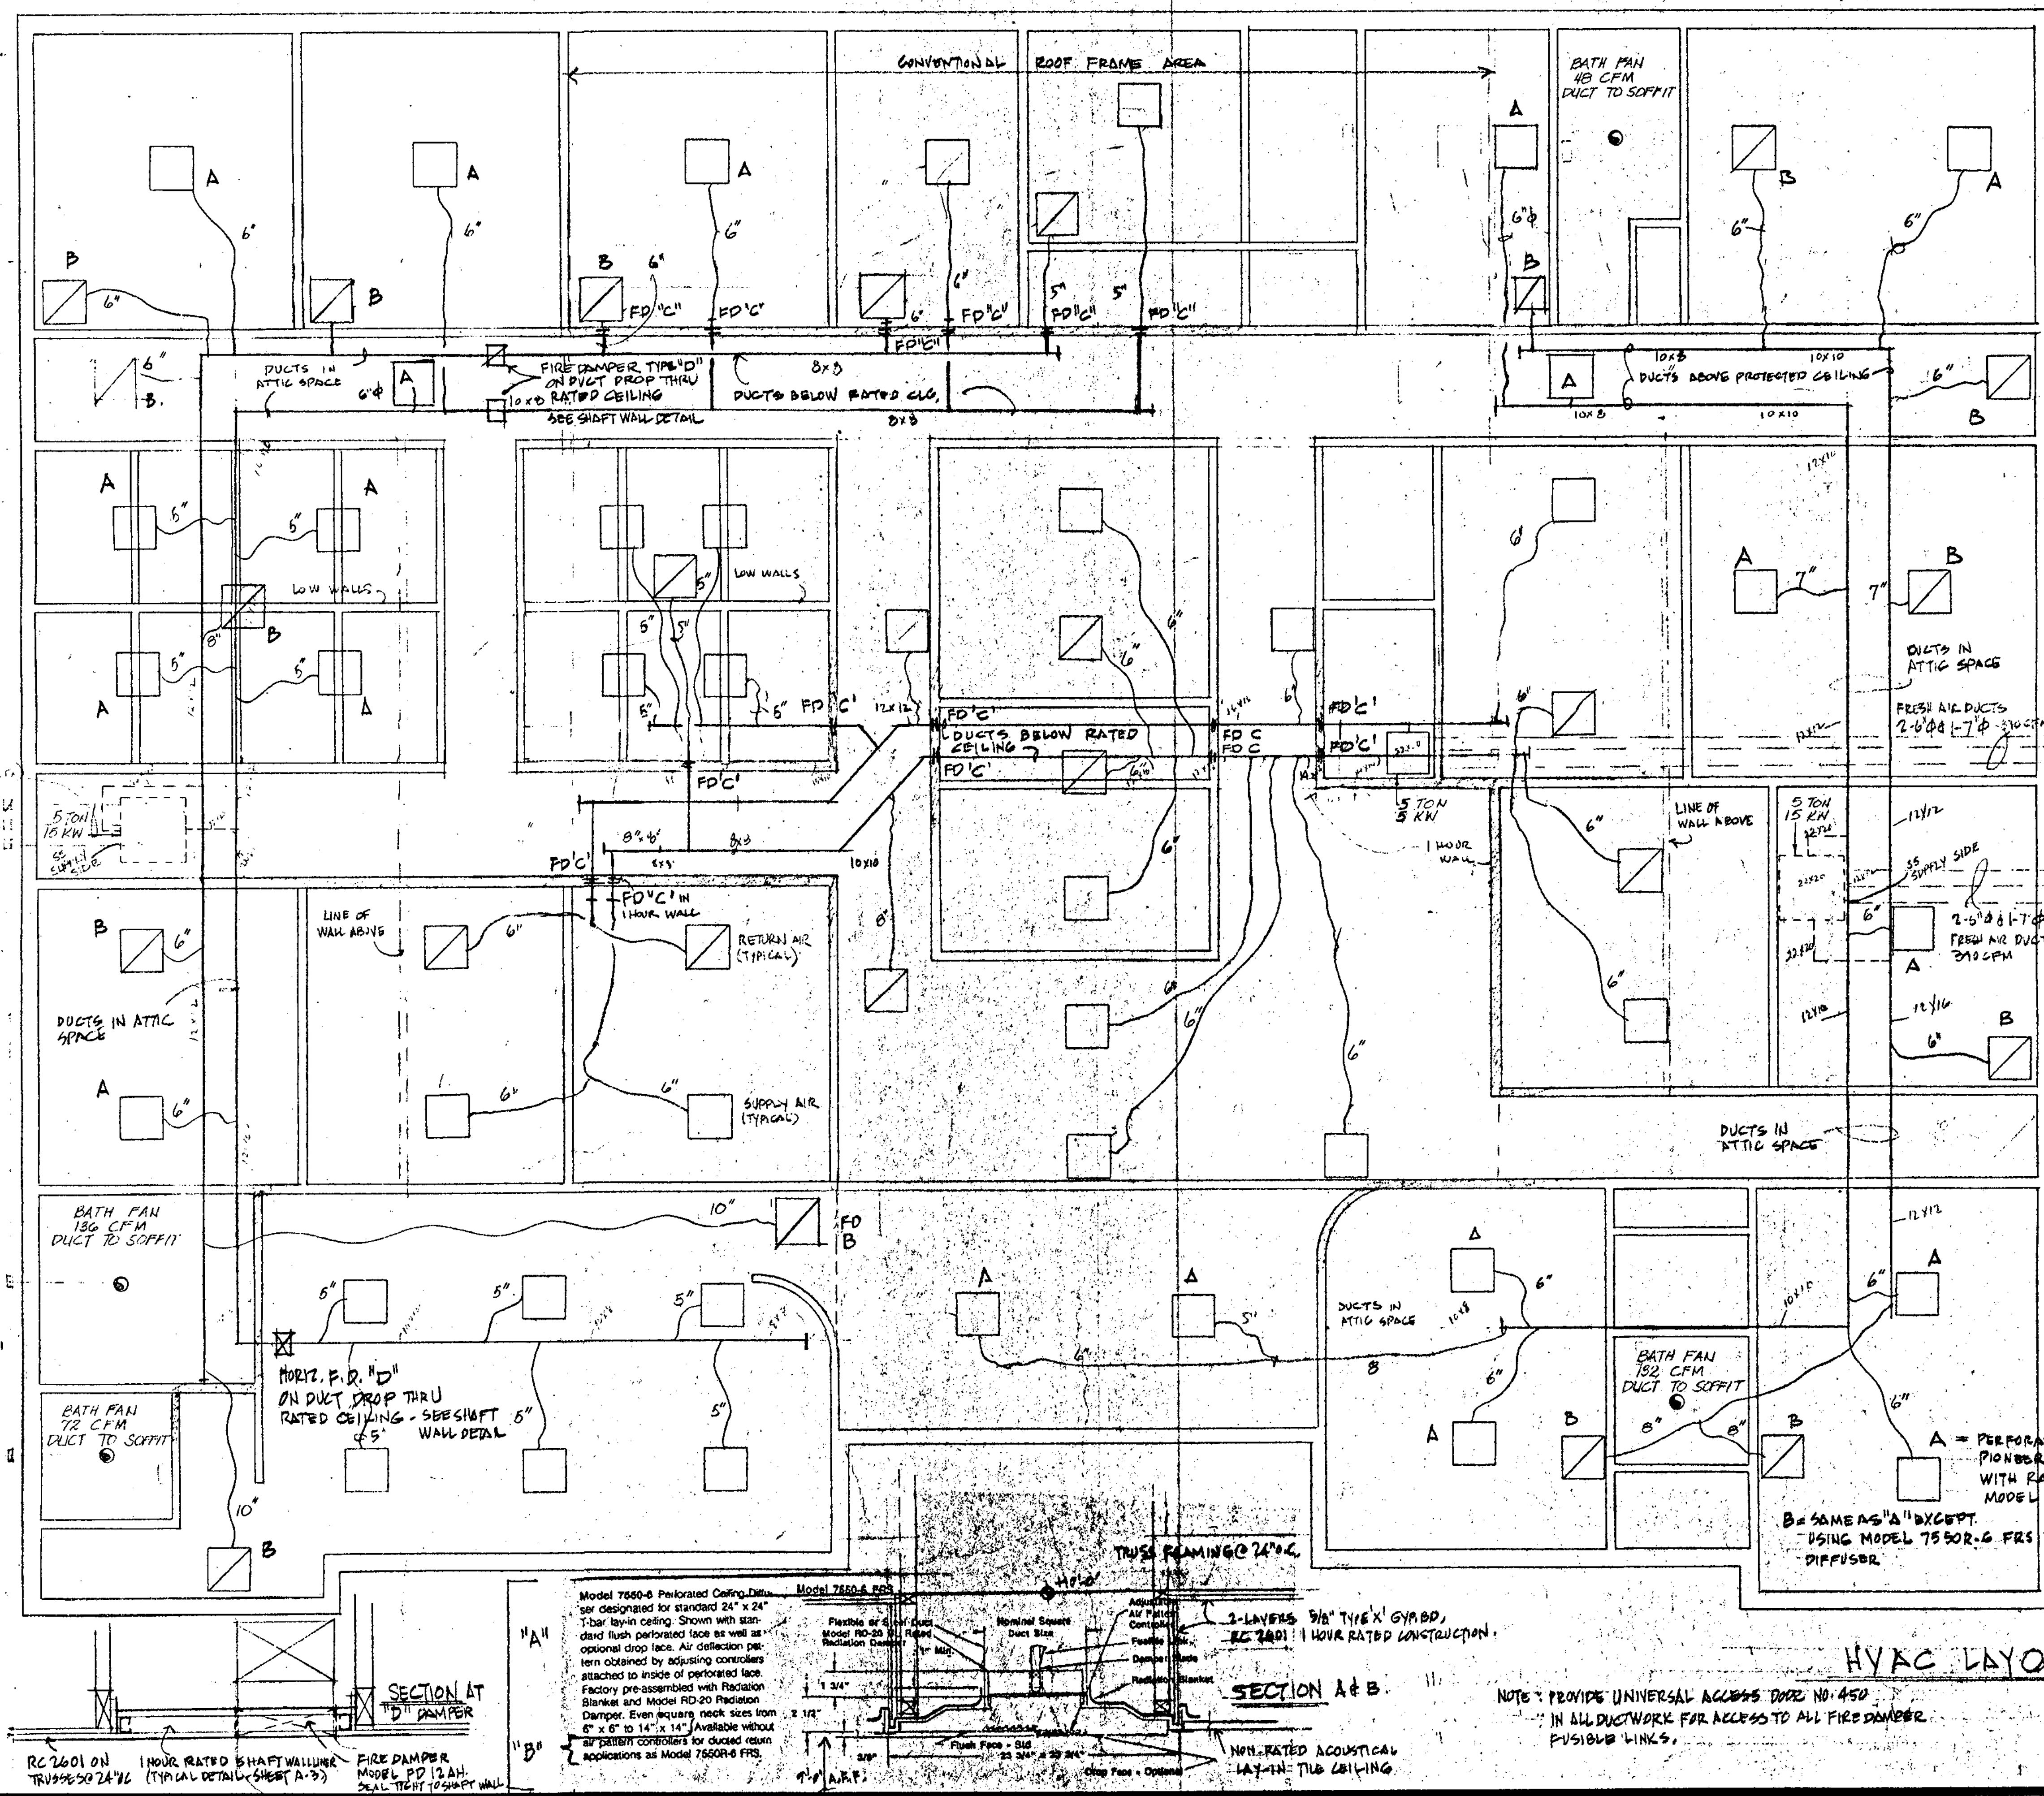


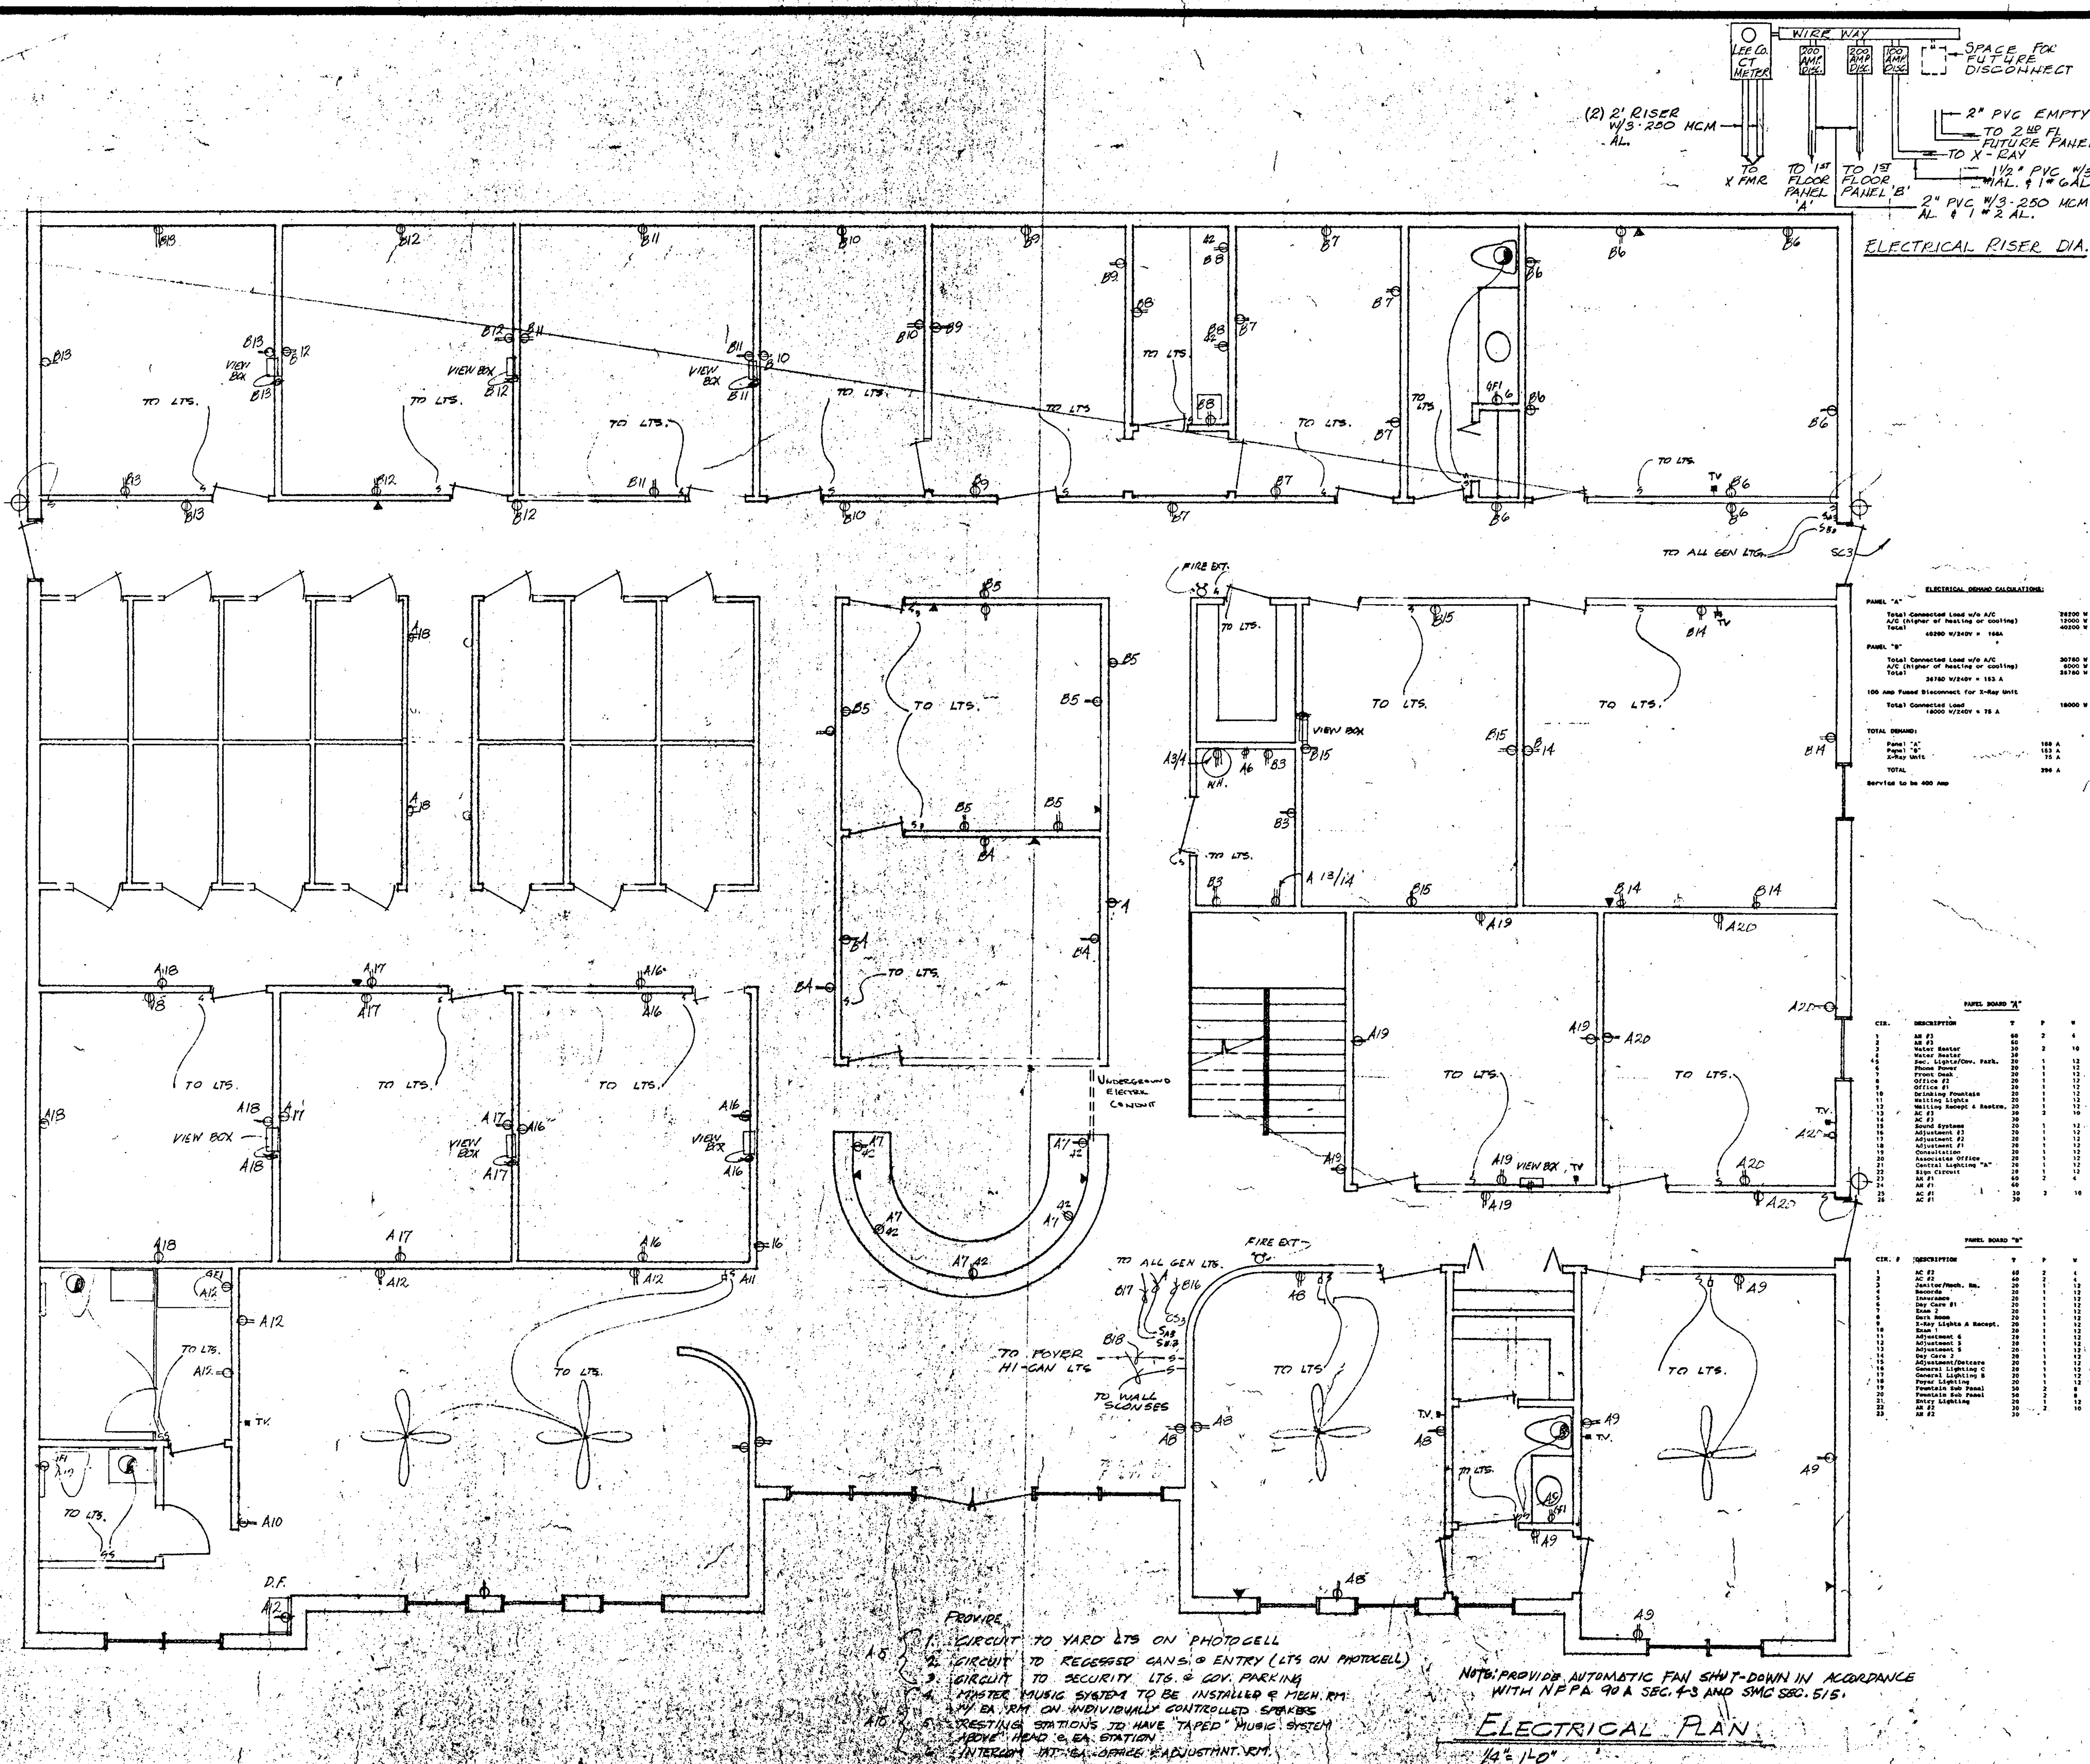

REVISIONS	BY

DRS. RICK & MARK MEANS

DRAWN
CHECKED
DATE 12.24.91
SCALE
JOB NO.
SHEET
E-1
OF SHEETS

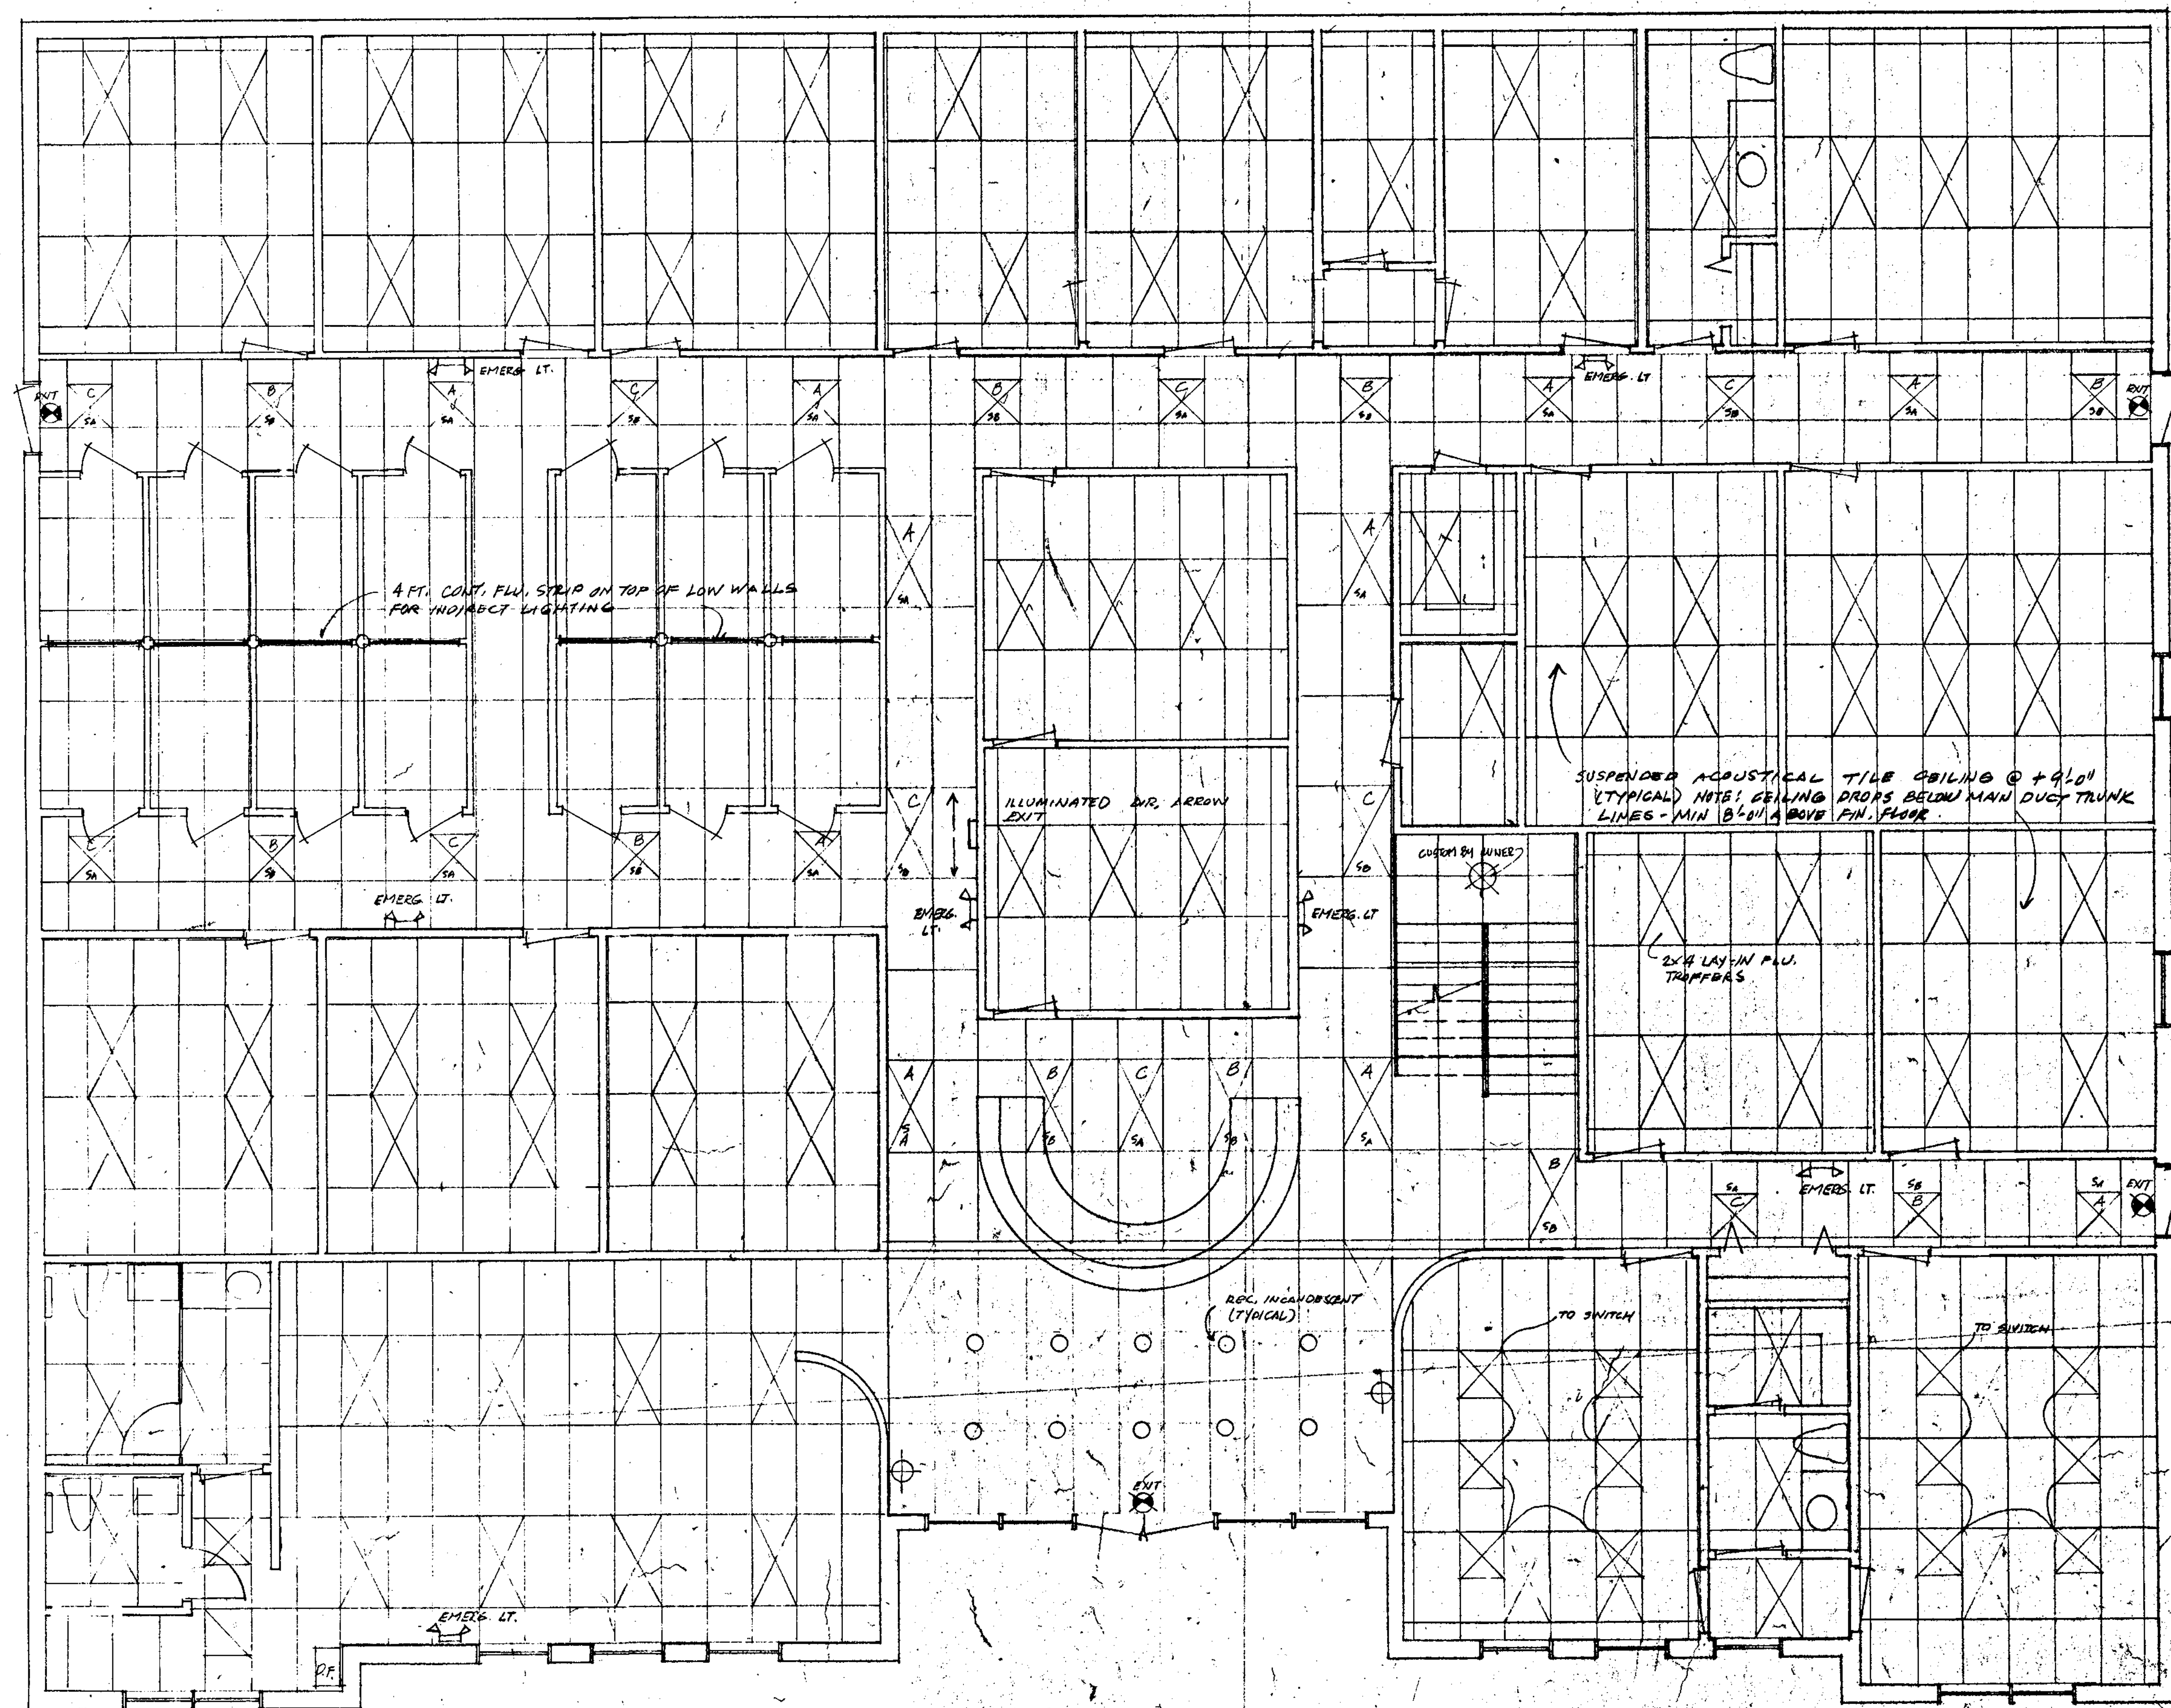

LIGHTING PLAN

1/4" = 1'-0"

REVISIONS	BY

DRS. RICK & MARK MEANS

DRAWN
CHECKED
DATE
12-24-91
SCALE
JOB NO.
SHEET
E-2
OF 1 SHEETS

[illegible]

DRS. RICKS' MARK MEANS

DRAWN
CHECKED
DATE 24-11
SCALE
JOB NO.
SHEET
ST
SHEET

