


STORE MUST BE CONSTRUCTED AS DESIGNED IN THESE FLOOR PLANS SUBJECT TO FEDERAL, STATE AND LOCAL LAWS. RECIPIENT IS RESPONSIBLE FOR ENSURING COMPLIANCE WITH ALL LAWS. IF MODIFICATIONS ARE NECESSARY, PLEASE CONTACT DAI'S STORE DESIGN DEPARTMENT FOR WRITTEN APPROVAL OF THE REQUIRED CHANGES.

THIS DRAWING IS FURNISHED BY DOCTORS ASSOCIATES INC. (DAI) DBA SUBWAY. RECIPIENT MUST DETERMINE IF THIS DRAWING MUST BE SUBMITTED TO A LICENSED ARCHITECT OR SIMILAR PROFESSIONAL UNDER FEDERAL, STATE OR LOCAL LAW. ANY CHANGES MUST BE APPROVED BY DAI.

DO NOT SCALE DRAWING. WRITTEN DIMENSIONS TAKE PRECEDENCE OVER SCALED DIMENSIONS. AND SHALL BE VERIFIED IN THE FIELD BY THE GENERAL CONTRACTOR AND/OR FRANCHISEE/OWNER. ANY DISCREPANCY IN DIMENSIONS SHALL BE BROUGHT TO THE IMMEDIATE ATTENTION OF DAI'S AREA DEVELOPMENT AGENT OR DESIGNATED FIELD REPRESENTATIVE.

THE GENERAL CONTRACTOR AND EACH SUB-CONTRACTOR SHALL MAKE HIS OWN INSPECTIONS AND MEASUREMENTS. DAI AND SUBWAY SHALL NOT BE HELD RESPONSIBLE FOR THE ACCURACY OF DIMENSIONS AND/OR ERRORS AND OMISSIONS IN THE DRAWINGS IF WRITTEN CONFIRMATION HAS NOT BEEN RECEIVED BY DAI'S STORE DESIGN DEPARTMENT.


THIS DRAWING AND THE INFORMATIONAL CONTENT HERE OF IS THE CONFIDENTIAL PROPERTY OF DAI AND IS PROVIDED SOLELY FOR THE USE OF AUTHORIZED FRANCHISEES. THEIR AGENTS AND CONTRACTORS. RECIPIENT AGREES NOT TO REPRODUCE, COPY, USE OR TRANSMIT THIS DRAWING AND/OR ITS INFORMATIONAL CONTENT, IN WHOLE OR IN PART, OR TO ALLOW SUCH ACTION BY OTHERS, FOR ANY PURPOSE, EXCEPT WITH THE WRITTEN PERMISSION OF DAI. ACTING FOR SUBWAY, RECIPIENT FURTHER AGREES TO SUPPLIER THIS DRAWING AND ANY PERMITTED COPIES HEREOF UPON DEMAND.

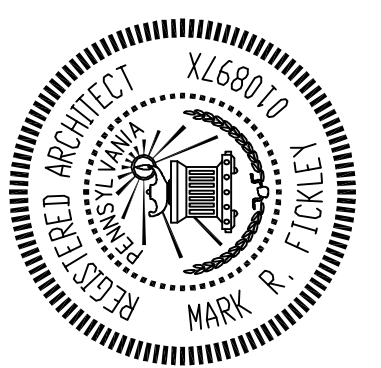


Mark Fickley, RA. - RLA.
 ARCHITECTURE LANDSCAPE ARCHITECTURE PLANNING
 308 OAKWOOD COURT JEFFERSON HILLS, PENNSYLVANIA 15025
 PHONE: (724) 966-1493 • mfickley@comcast.net



WORLD HEADQUARTERS
 (203) 877-4281
 (800) 888-4848
 325 BIC DRIVE
 MILFORD, CT 06461

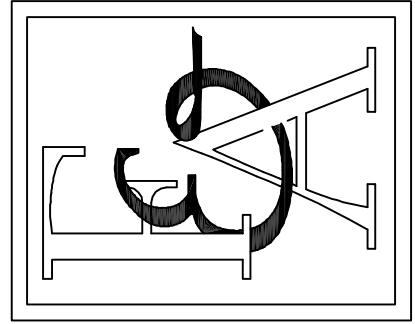

LAYOUT PLAN
SUBWAY - MCKEES ROCKS
THE SHOPPES AT CHARTIERS CROSSING
146 CHARTIERS AVENUE
McKees Rocks, Pennsylvania 15136

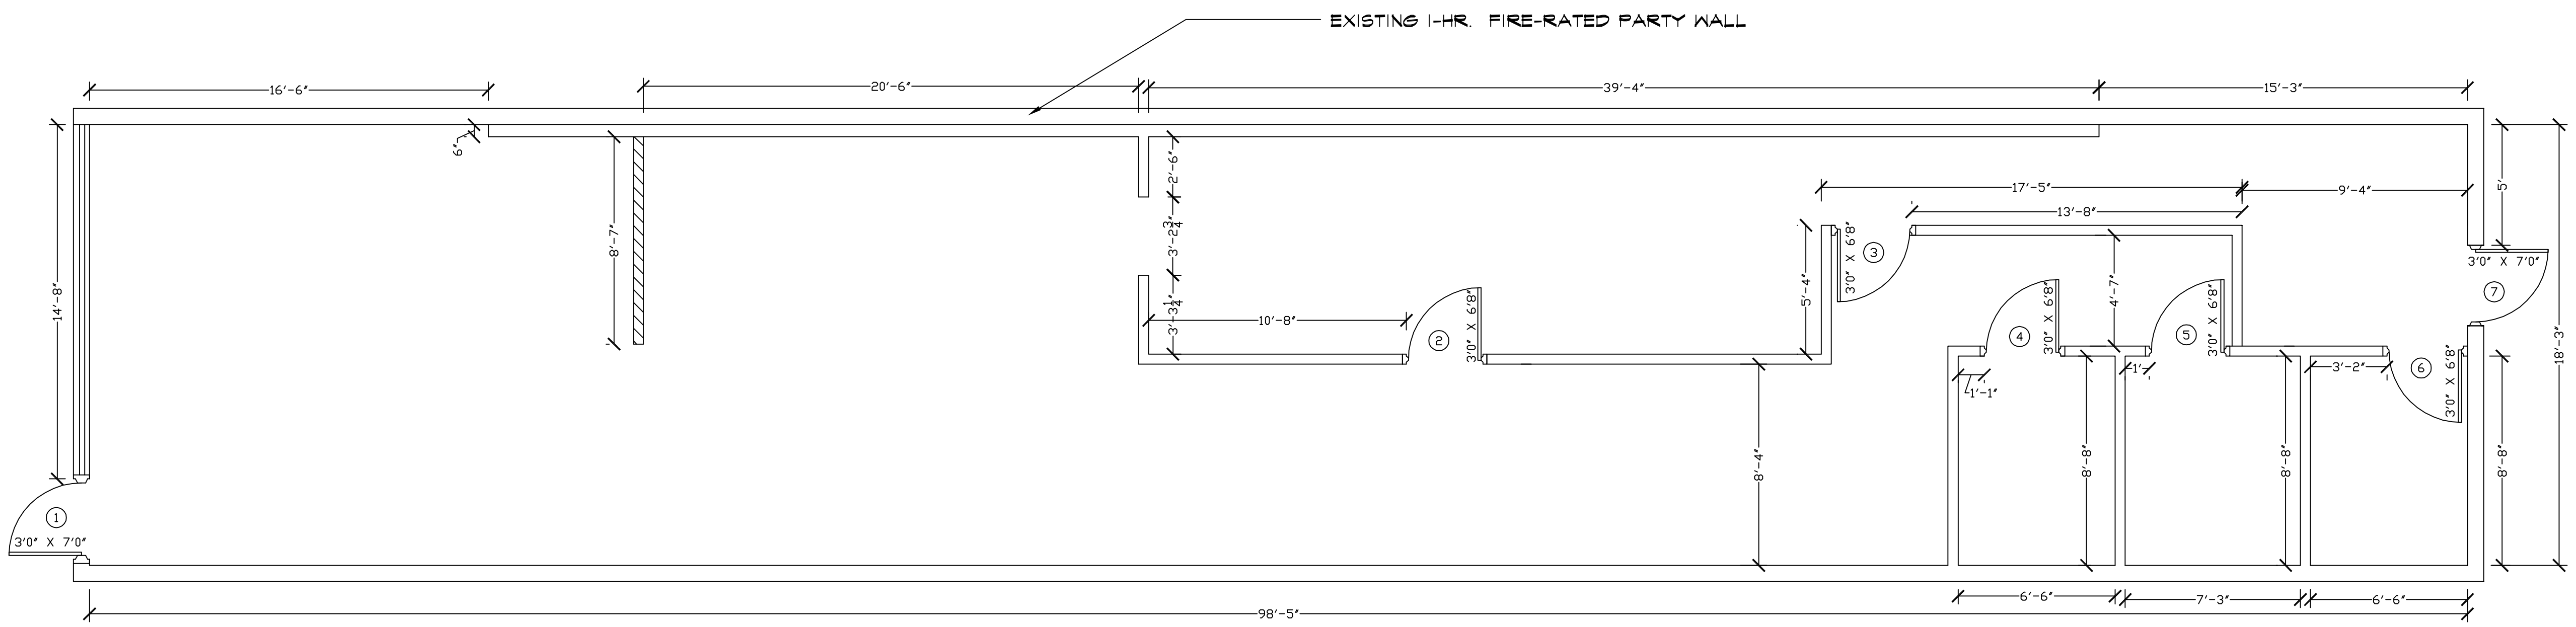

LAYOUT PLAN

1/4" = 1'-0"

FRANCHISEE
 M&N CORPORATION
 104 CARA LIN DRIVE
 PITTSBURGH, PA 15221
 PHONE: 412-537-9617

DEVELOPMENT AGENT - SUBWAY
 WAYNE NONNAMAKER

CONSTRUCTION MANAGER - SUBWAY
 BOB BENNER

NEW LOCATION

GENERAL NOTES:	
-	CEILING HEIGHT IS 10'-0"
-	ELECTRICAL OUTLET HEIGHTS MEASURED TO BOTTOM OF BOX.
-	ONE ELECTRICAL JUNCTION BOX TO BE LOCATED IN CEILING ABOVE EACH WINDOW.
-	STORE DESIGNED WITH CONTOUR SEATING. SHOWN ON PLAN AS SINGLES NOT GROUPS.
-	QUAD MODEL SWS-PLUS WATER FILTRATION SYSTEM IS REQUIRED IN ALL NEW STORES THAT DISPENSE BEVERAGES. THE RECOMMENDED PLACEMENT FOR INSTALLATION IS MOUNTED TO SODA SYRUP RACK BY COCA-COLA. SECONDARY PLACEMENT OPTION IS MOUNTED ON THE BACKROOM WALL. THIRD INSTALLATION OPTION IS MOUNTING INSIDE THE FRONT BEVERAGE COUNTER WHEN SPACE LIMITATIONS OCCUR. REQUIRED. 1/2" INCOMING WATER LINE FEED WITH 1/2" BALL VALVE SHUTOFF AND 1/2" FPT CONNECTION.
-	MINIMUM 110 VOLT, 20 AMP ELECTRICAL SERVICE TO SUPPORT THE CARBONATOR AND WATER BOOSTER (MUST BE DEDICATED CIRCUIT).
-	SMARTCURVE STAND (MFR. DISPLAY-BOX) REQUIRED IN CUSTOMER AREA AT POINT OF ORDER (PREFERRED PLACEMENT).
-	21 3/4" X 15 1/8" BASE 56" (WITHOUT HEADER) OVERALL HEIGHT.
-	BASKET STYLE SECONDARY CHAIR RACK REQUIRED IN CUSTOMER AREA AT POINT OF ORDER (PREFERRED PLACEMENT).
-	EXIT LIGHTS INSTALLED BY G.C. PER LOCAL CODE.
-	EMERGENCY LIGHTS INSTALLED BY G.C. PER LOCAL CODE.
-	EXTINGUISHERS, SMOKE AND FIRE DETECTION SYSTEMS INSTALLED BY G.C. PER LOCAL CODE.
-	LABOR & MATERIAL SUPPLIED BY G.C. UNLESS OTHERWISE NOTED.
-	ALL DIMENSIONS TO BE VERIFIED BY G.C. ON SITE.
-	DECOR SPECIFICATIONS ARE TO BE SUBWAY'S "TUSCANY II" SCHEME.

DATE ISSUED:
8/7/04

JOB NO.
09-34

REVISIONS

SHEET NO.

A-1