



DOOR DASH
2512 HEMP HILL ST
FORT WORTH, TX 76110

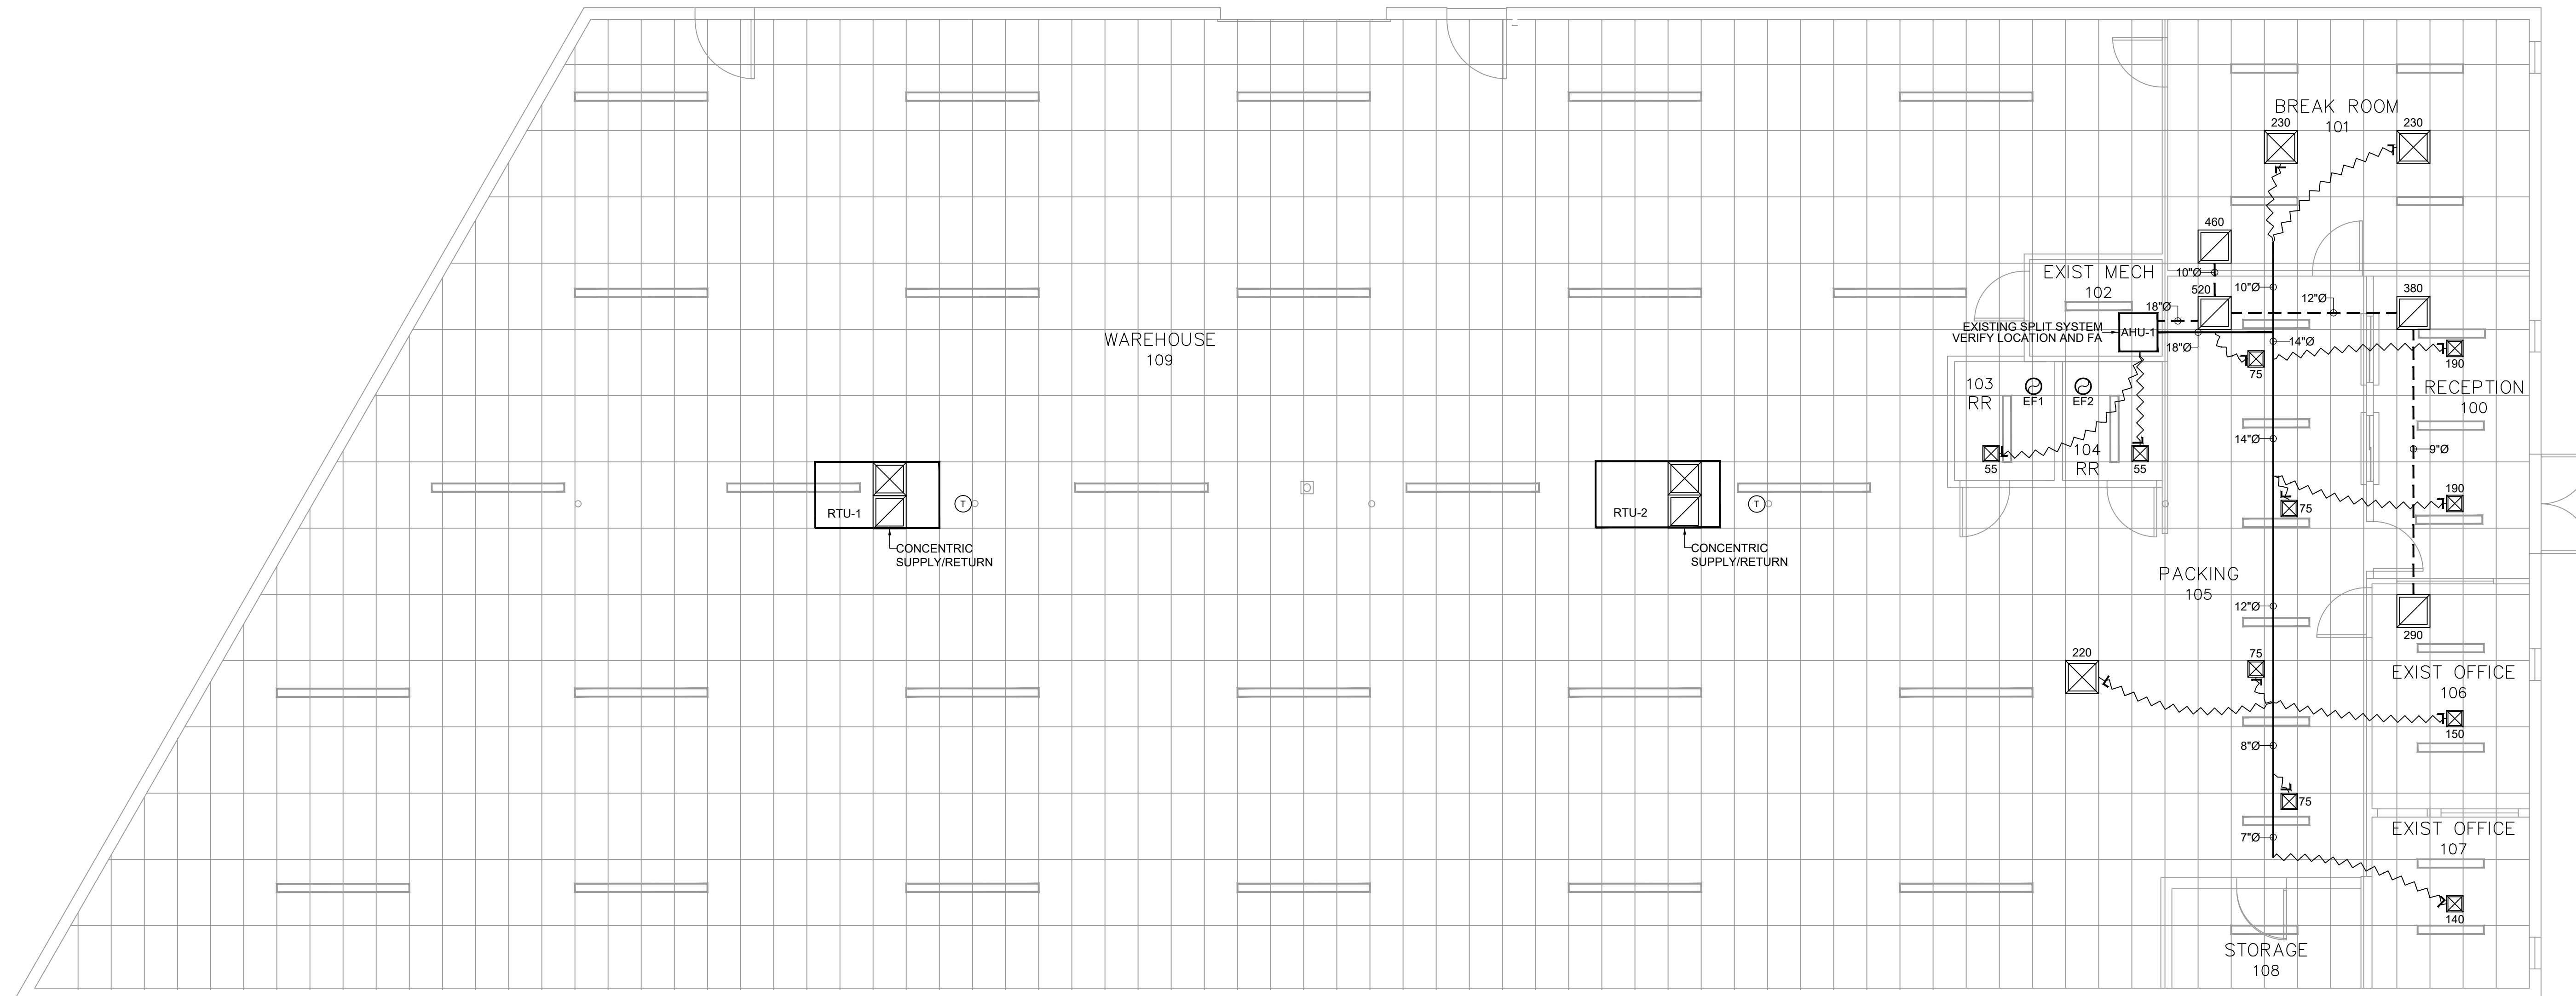

1 MECHANICAL PLAN
SCALE: 3/16"=1'-0"

LARRY L. BLACKMON INC.
ENGINEERING & BUILDING DESIGN
6716 AZLE AVENUE
FORT WORTH, TEXAS 76135
REGISTRATION #: F-002382
EMAIL: larry@blackmonconsultingengineers.com PHONE: 817-238-9801

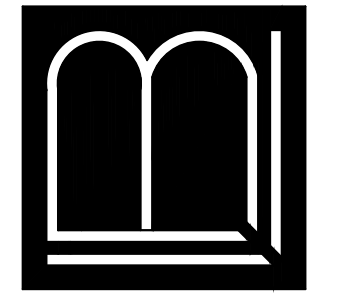

MECHANICAL PLAN

SHEET: M1

DATE: 11/4/2021

DRAWN BY: GFB

DESIGN BY: LLB

NOTE TO BIDDERS
THE INTENT OF THE DRAWINGS HEREIN IS TO REPRESENT A COMPLETE WORKING SYSTEM. ALL BIDDERS SHALL BE RESPONSIBLE FOR PROVIDING AND INSTALLING ALL COMPONENTS NECESSARY TO PROVIDE A COMPLETE WORKING SYSTEM WHETHER SHOWN OR NOT SHOWN ON THE DRAWINGS.