




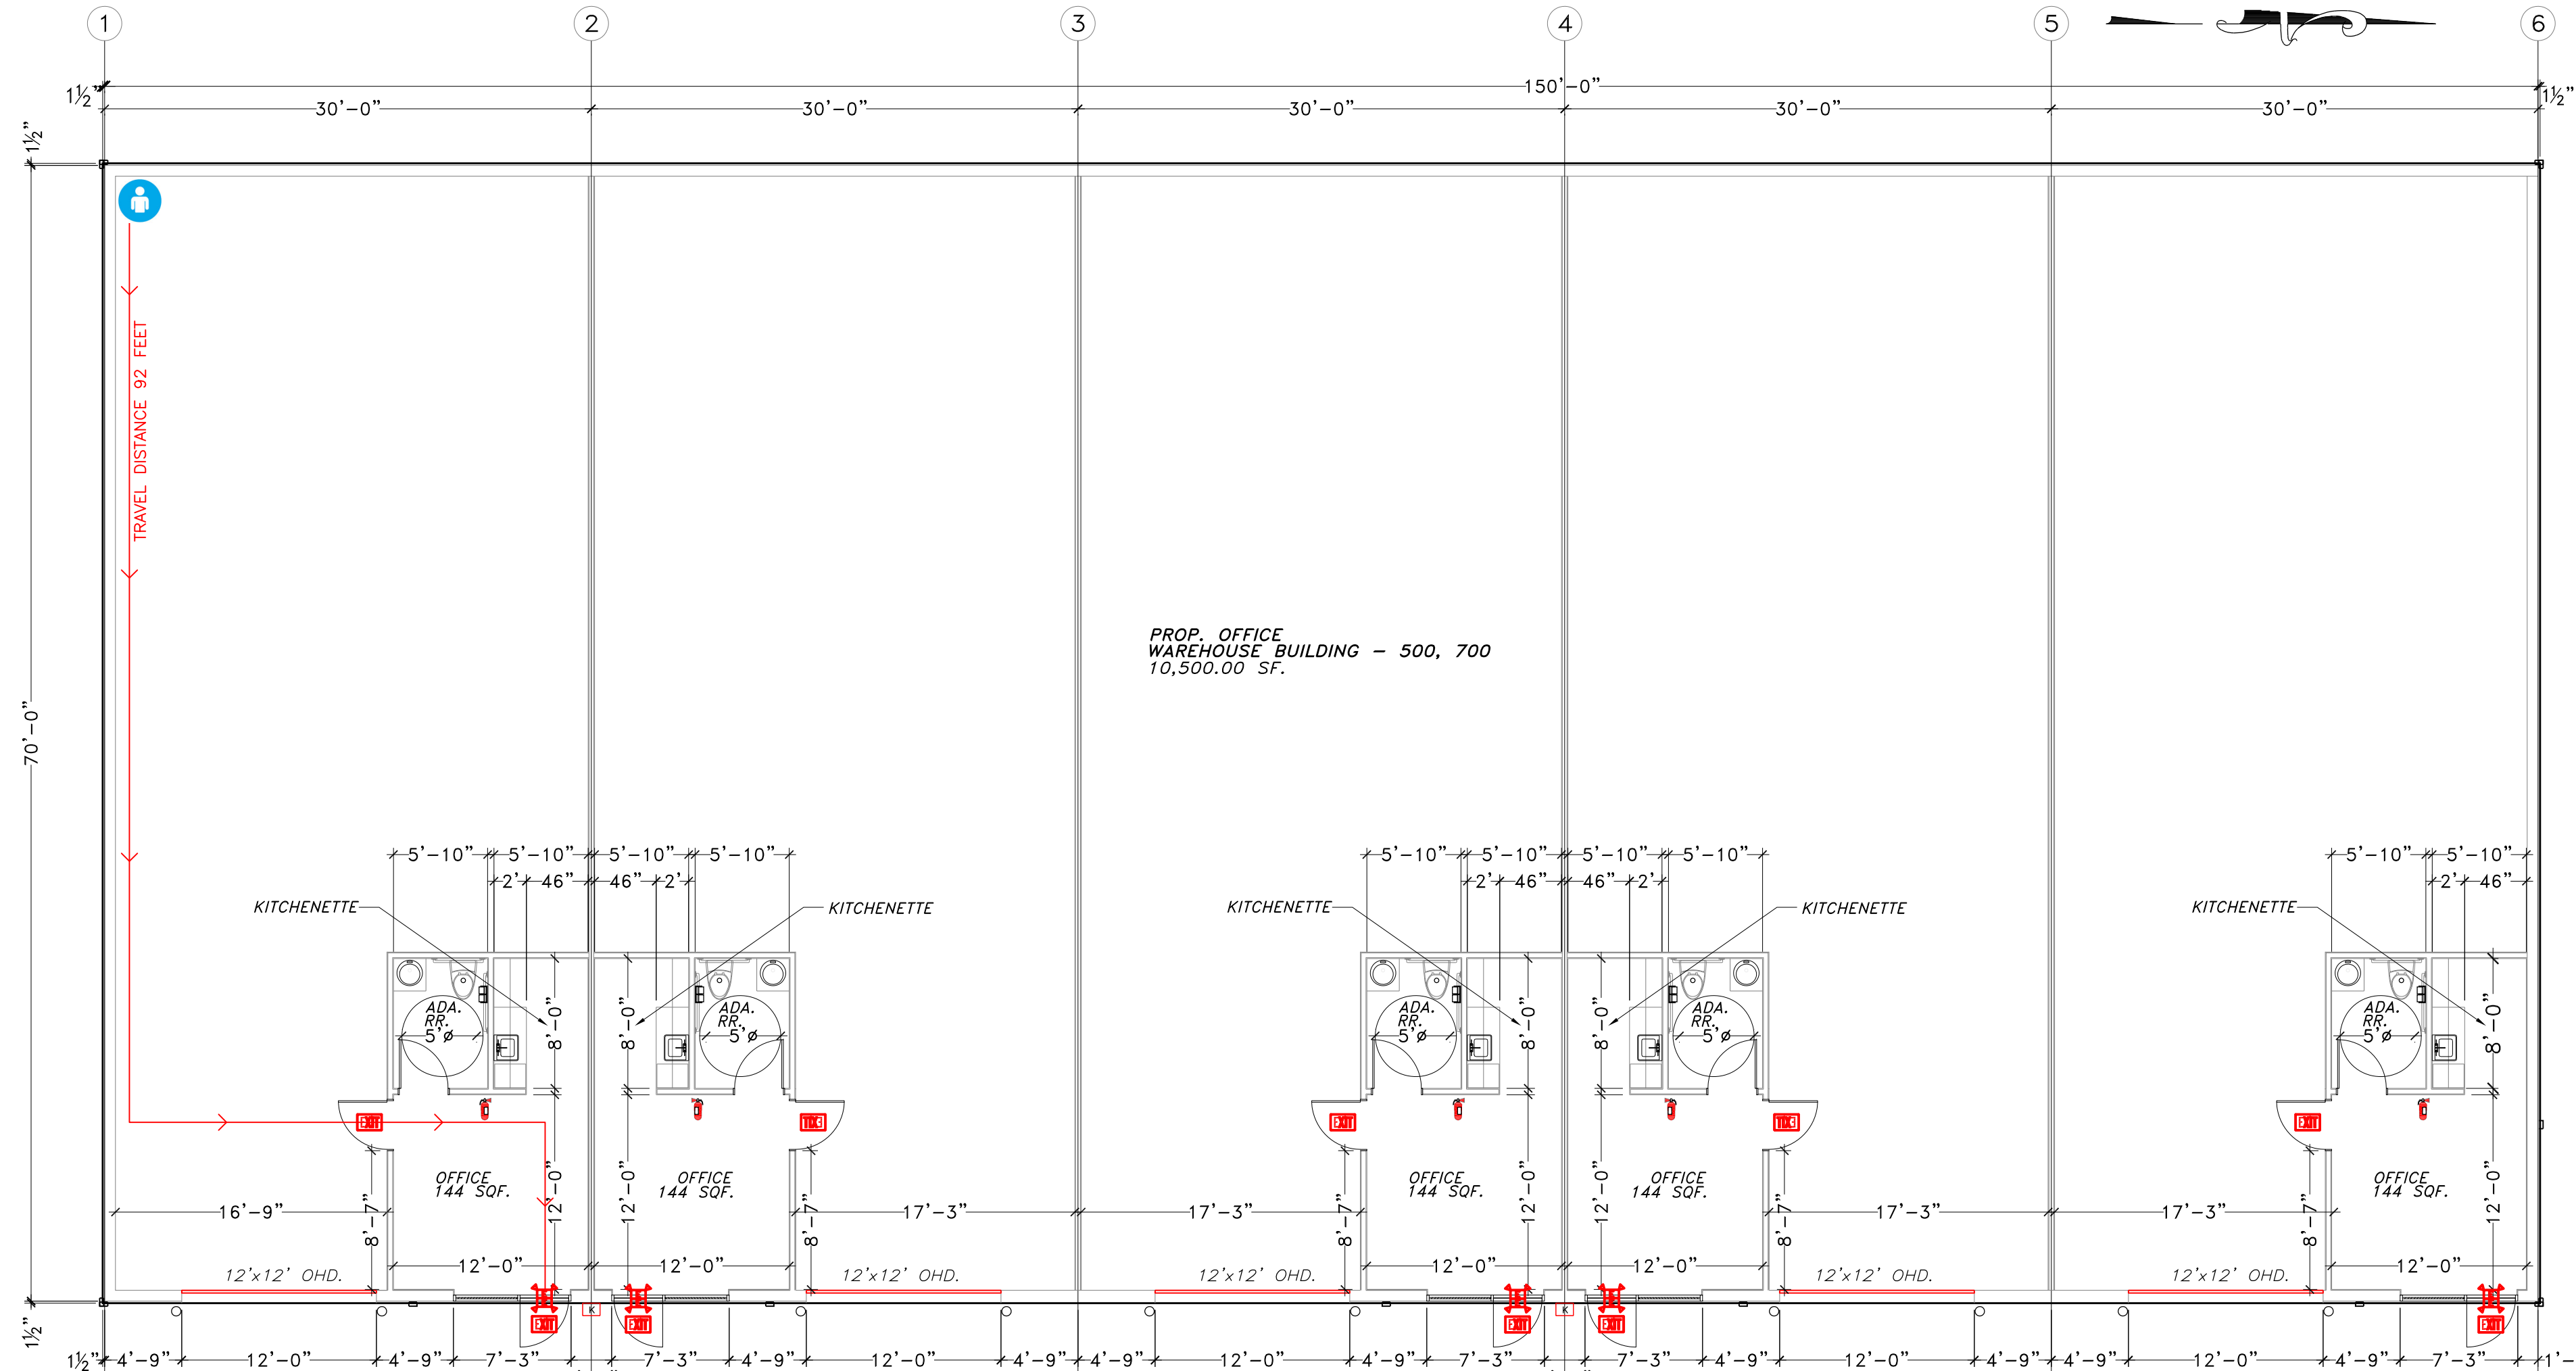


FLOOR PLAN
1/8"=1'-0"

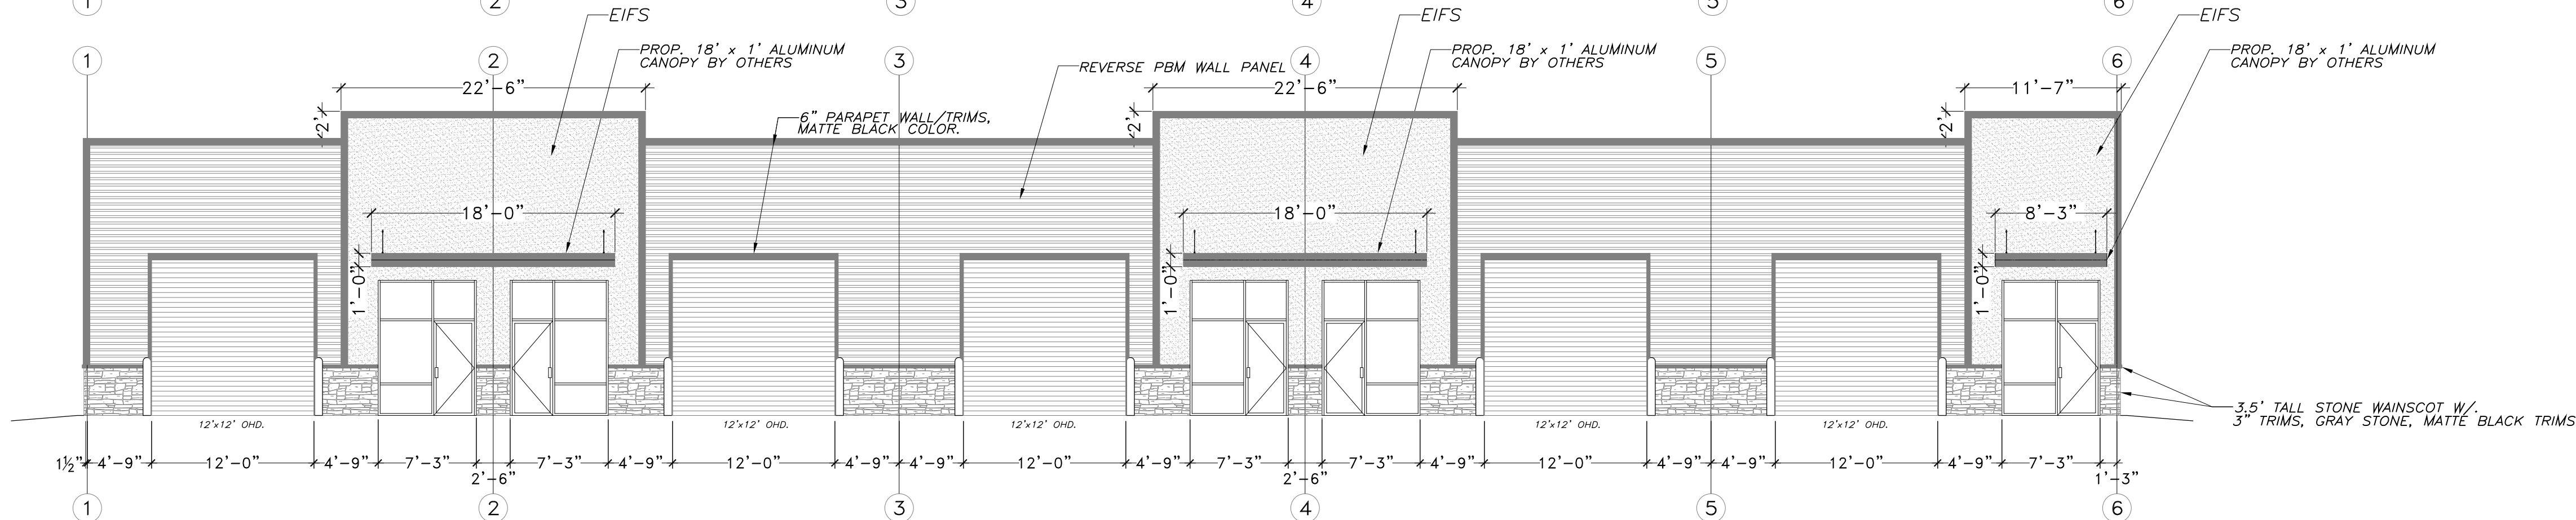

METAL OFFICE WAREHOUSE EAST ELEVATION
1/8"=1'-0"

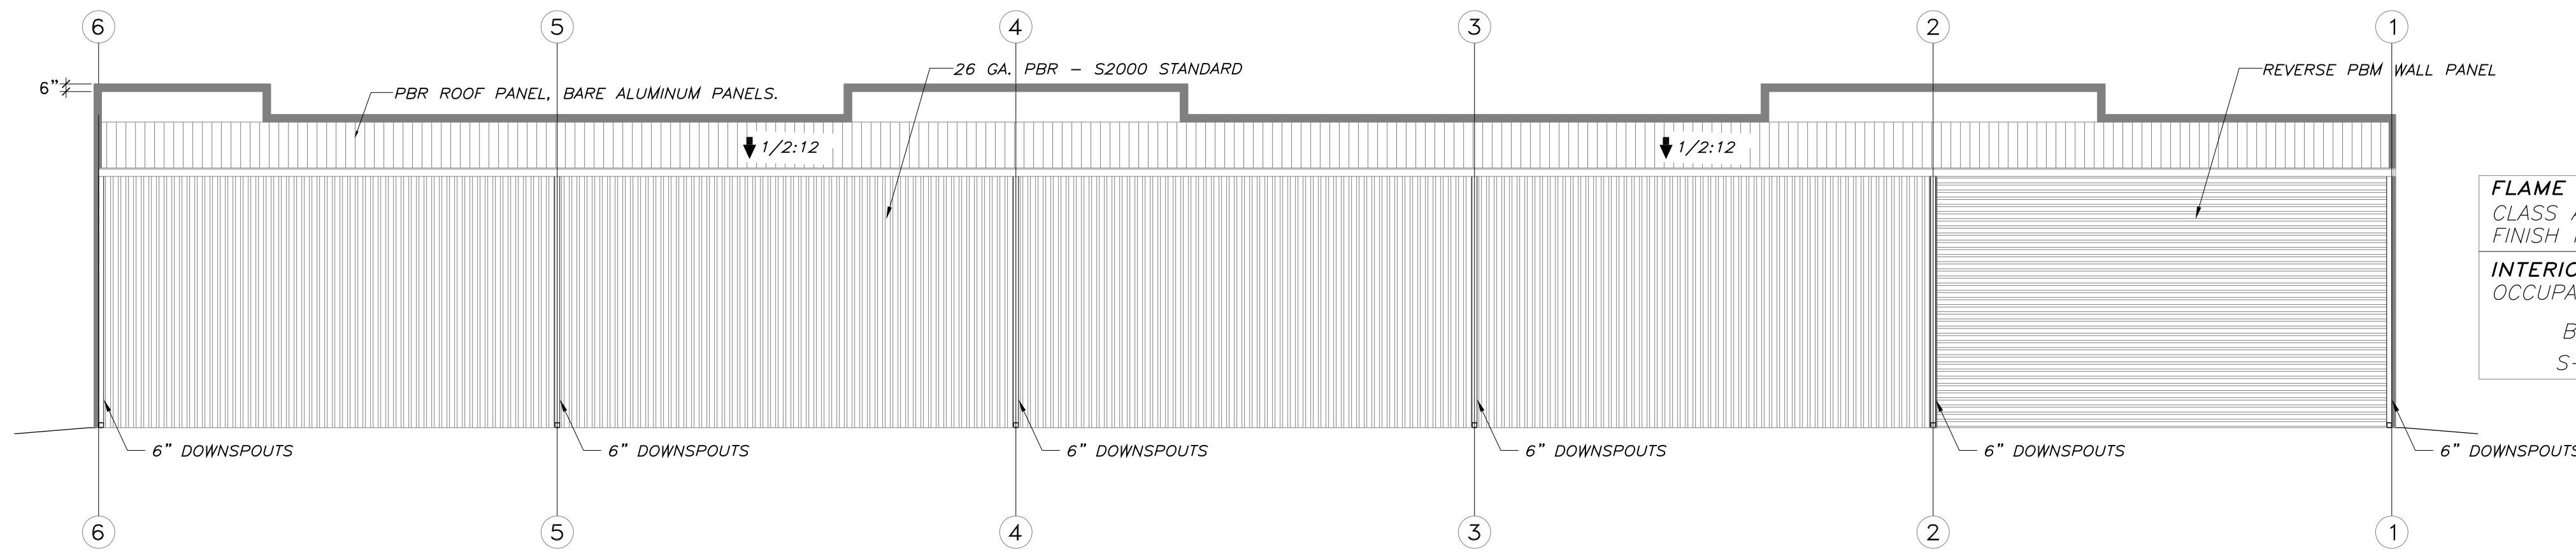

METAL OFFICE WAREHOUSE WEST ELEVATION
1/8"=1'-0"

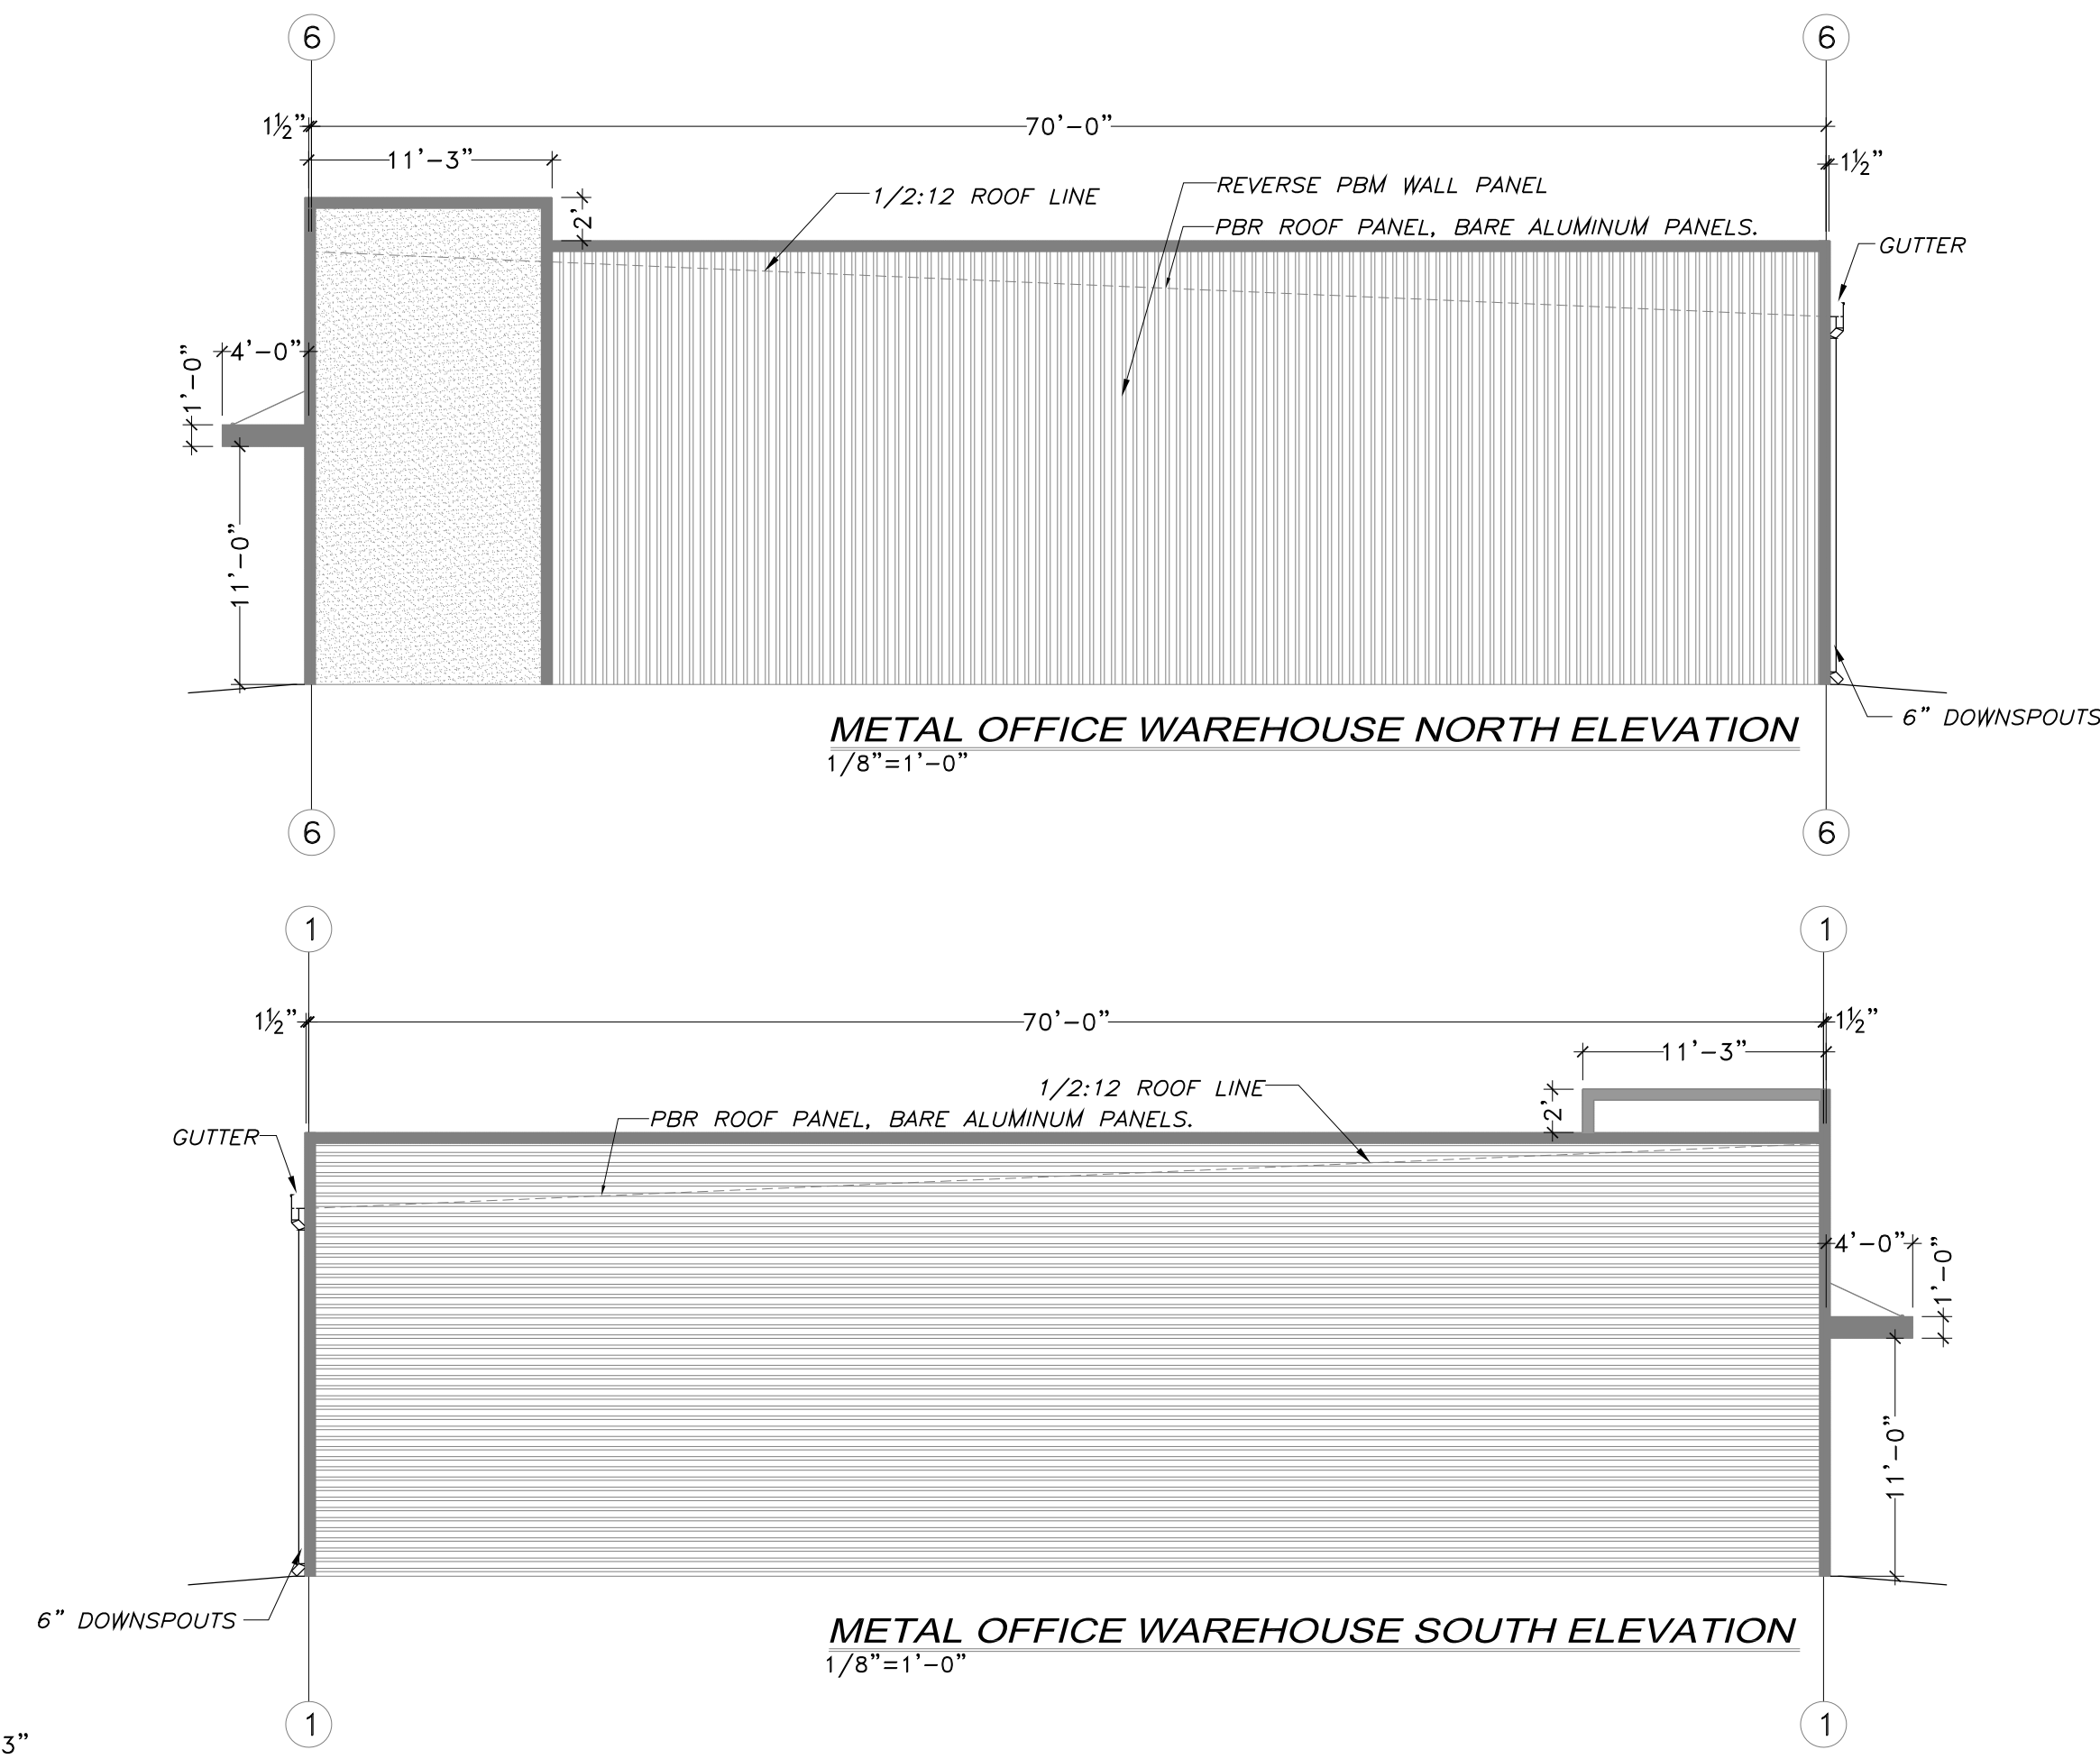

LEGEND

- ILLUMINATED DIRECTIONAL EXIT SIGN
- EXTERIOR AND INTERIOR ILLUMINATED EXIT SIGN WITH BACK UP POWER
- FIRE EXTINGUISHER
- YOU ARE HERE (FIRE ESCAPE DISTANCE)
- KNOX BOX



KNOX BOX


- NOTES:
- VISIT WWW.KNOXBOX.COM/4561 TO PURCHASE A LOCK
 - ENSURE THE FOLLOWING INFORMATION IS LOCATED IN THE YOUR SHOPPING TAB IN THE TOP LEFT CORNER
 - LOCAL FIRE DEPARTMENT/AGENCY, HARRIS CO. MARSHALS OFFICE, HUMBLE, TX 77396 3503 UNINCORPORATED AREAS OF HARRIS COUNTY
 - CONTACT YOUR LOCAL FIRE DEPARTMENT TO OPEN THE KNOX BOX FOR INSTALLATION
 - IF THE FIRE DEPARTMENT IS NOT AVAILABLE TO PROVIDE THE SERVICE LISTED IN STEP (D), VISIT ON OF HCFMO'S LOCATIONS TO SCHEDULE THE LOCKING OF YOUR KNOX BOX.

FLAME SPREAD INDEX:

CLASS A: = FSI: 0-25, CLASS B: = FSI: 26-75, CLASS C: = FSI: 76-200
FINISH MATERIALS TESTED IN ACCORDANCE WITH ASTM E84 OR UL 723.

INTERIOR FINISH

OCCUPANCY GROUP	EXITS ENCLOSURES, EXIT PASSAGEWAYS	CORRIDORS	ROOMS AND ENCLOSED SPACES
B	A	B	C
S-1	B	B	C

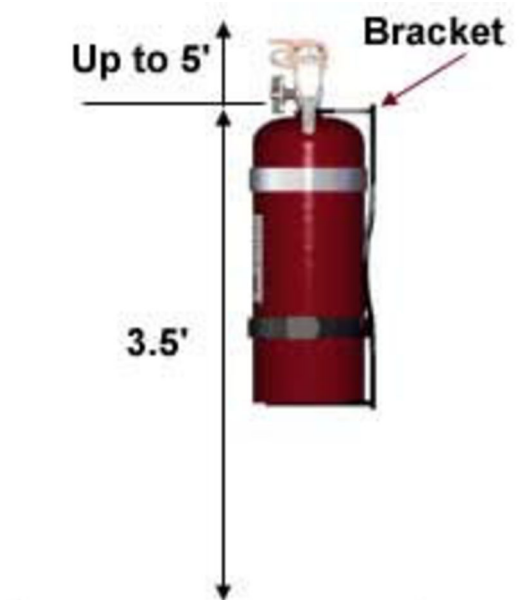

PORTABLE 2-A FIRE EXTINGUISHER PLACEMENT
NTS

M LANZA ENGINEERING, PLLC
CIVIL, MECHANICAL, ELECTRICAL, & PLUMBING
18011 CYPRESS ROSEHILL ROAD, SUITE 6
HOUSTON, TEXAS 77057
P 832.559.3616
F 832.559.4983
m.anza@mlanzaengineering.com
FIRM NO.: F-19716



P.E. STAMP:



DESIGN BY:
Vatsal Monpara
DRAWING BY:
Mario Lanza Jr.
DATE:
March 25, 2024
SCALE:
1/8"=1'-0"
FILE: M/2024/GDL
FLOOR PLAN AND ELEV.
DRAWING: