


QTY	SYM	DESCRIPTION
1	④	135° HEAT DET.-ADDRESSABLE
46	○	PHOTO SMOKE DET.-ADDRESSABLE
3	■	PULL STATION- EXISTING
4	⬮	HORN STROBE- EXISTING
1	⬮	STROBE-15 CANDELA
1	⬮	STROBE-75 CANDELA
5	⬮	EXISTING 15 CANDELA STROBE
2	⬮	HORN STROB-NEW

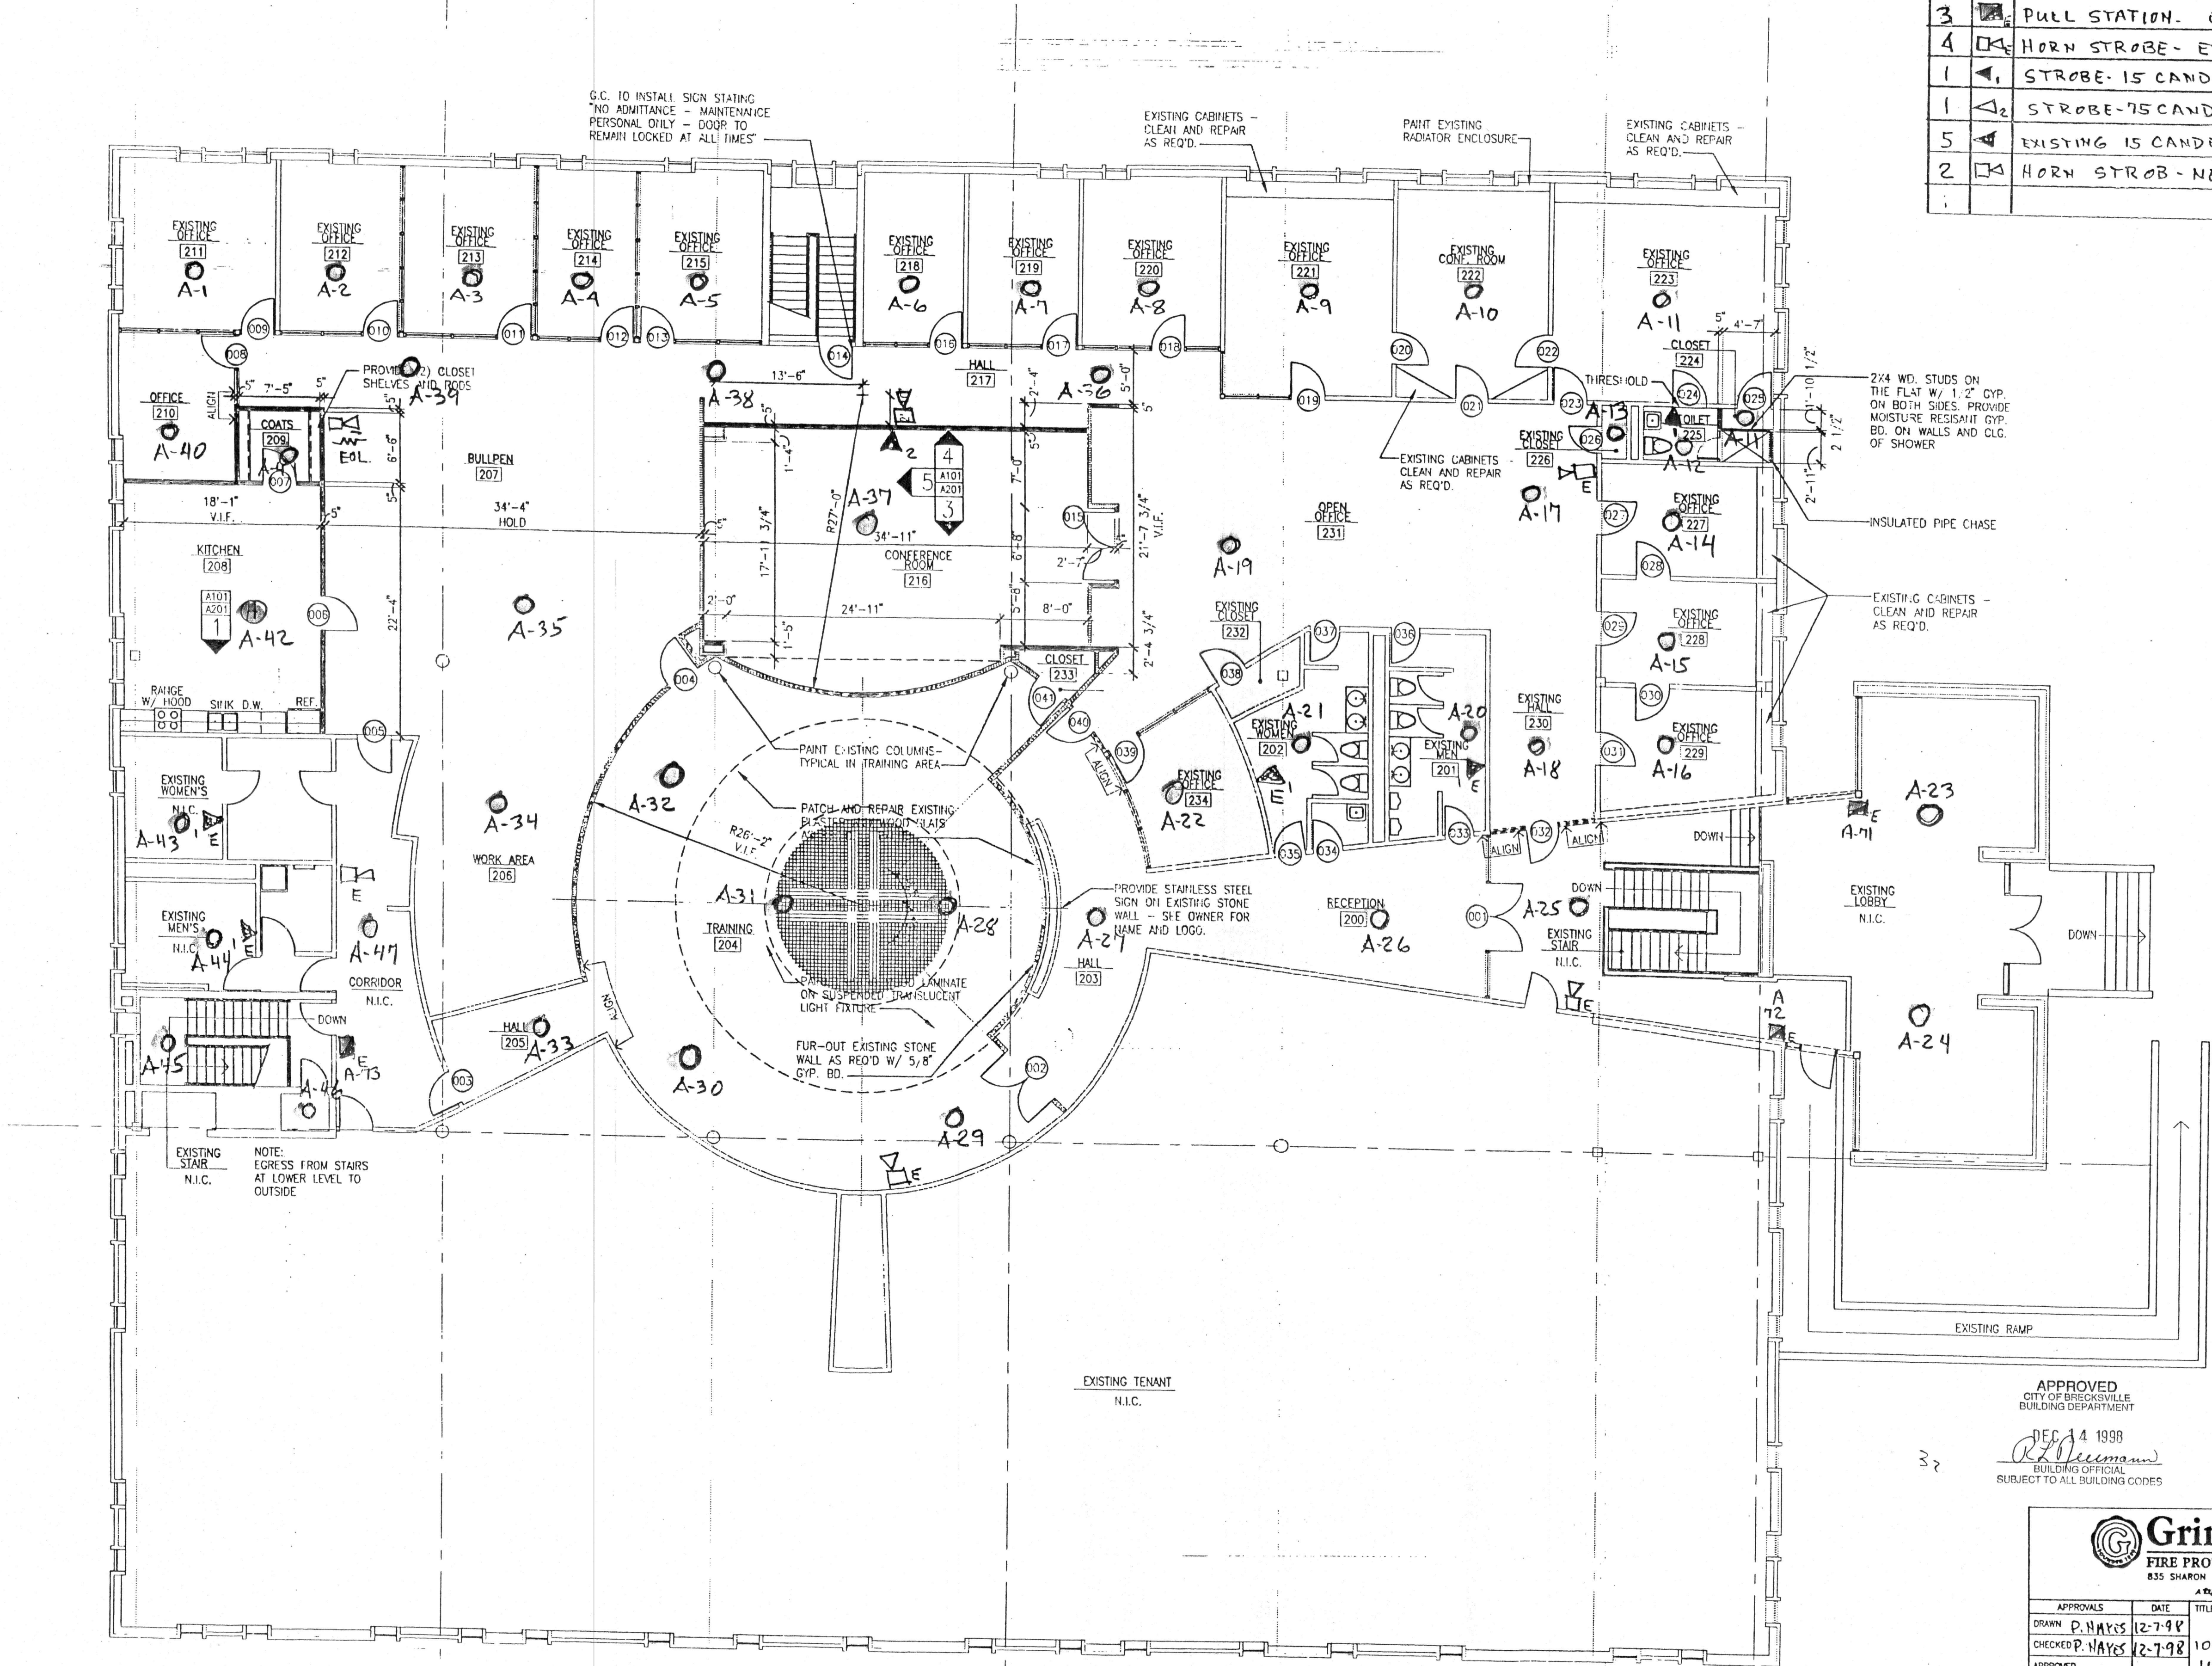

UPPER LEVEL-DEALERS AREA

DRAWING REVIEWED

JOHN S. WETZEL

CERTIFIED FIRE ALARM SYSTEM DESIGNER

STATE OF OHIO

CERTIFICATE NO. F-007

John S. Wetzel 12/15/98

(SIGN & DATE)

APPROVED

DEC 14 1998

R. Deussen

BUILDING OFFICIAL

SUBJECT TO ALL BUILDING CODES


Grinnell

FIRE PROTECTION SYSTEMS COMPANY

835 SHARON DRIVE WESTLAKE, OHIO 44145

A BURNER INTERNATIONAL LTD. COMPANY

APPROVALS	DATE	TITLE
DRAWN P. HAYES	12-7-98	GREATER CLEVELAND AUTOMOBILE DEALER ASSOCIATES
CHECKED P. HAYES	12-7-98	10100 BRECKSVILLE RD., BRECKSVILLE OHIO
APPROVED		UPPER LEVEL-DEALERS AREA
		FIRE ALARM SYSTEM
CADFILE:	SIZE	JOB/DRAWING NO.
LAST UPDATE:	D	SK 120998PH-3
	SCALE	AS NOTED
	SHEET	3 OF 5

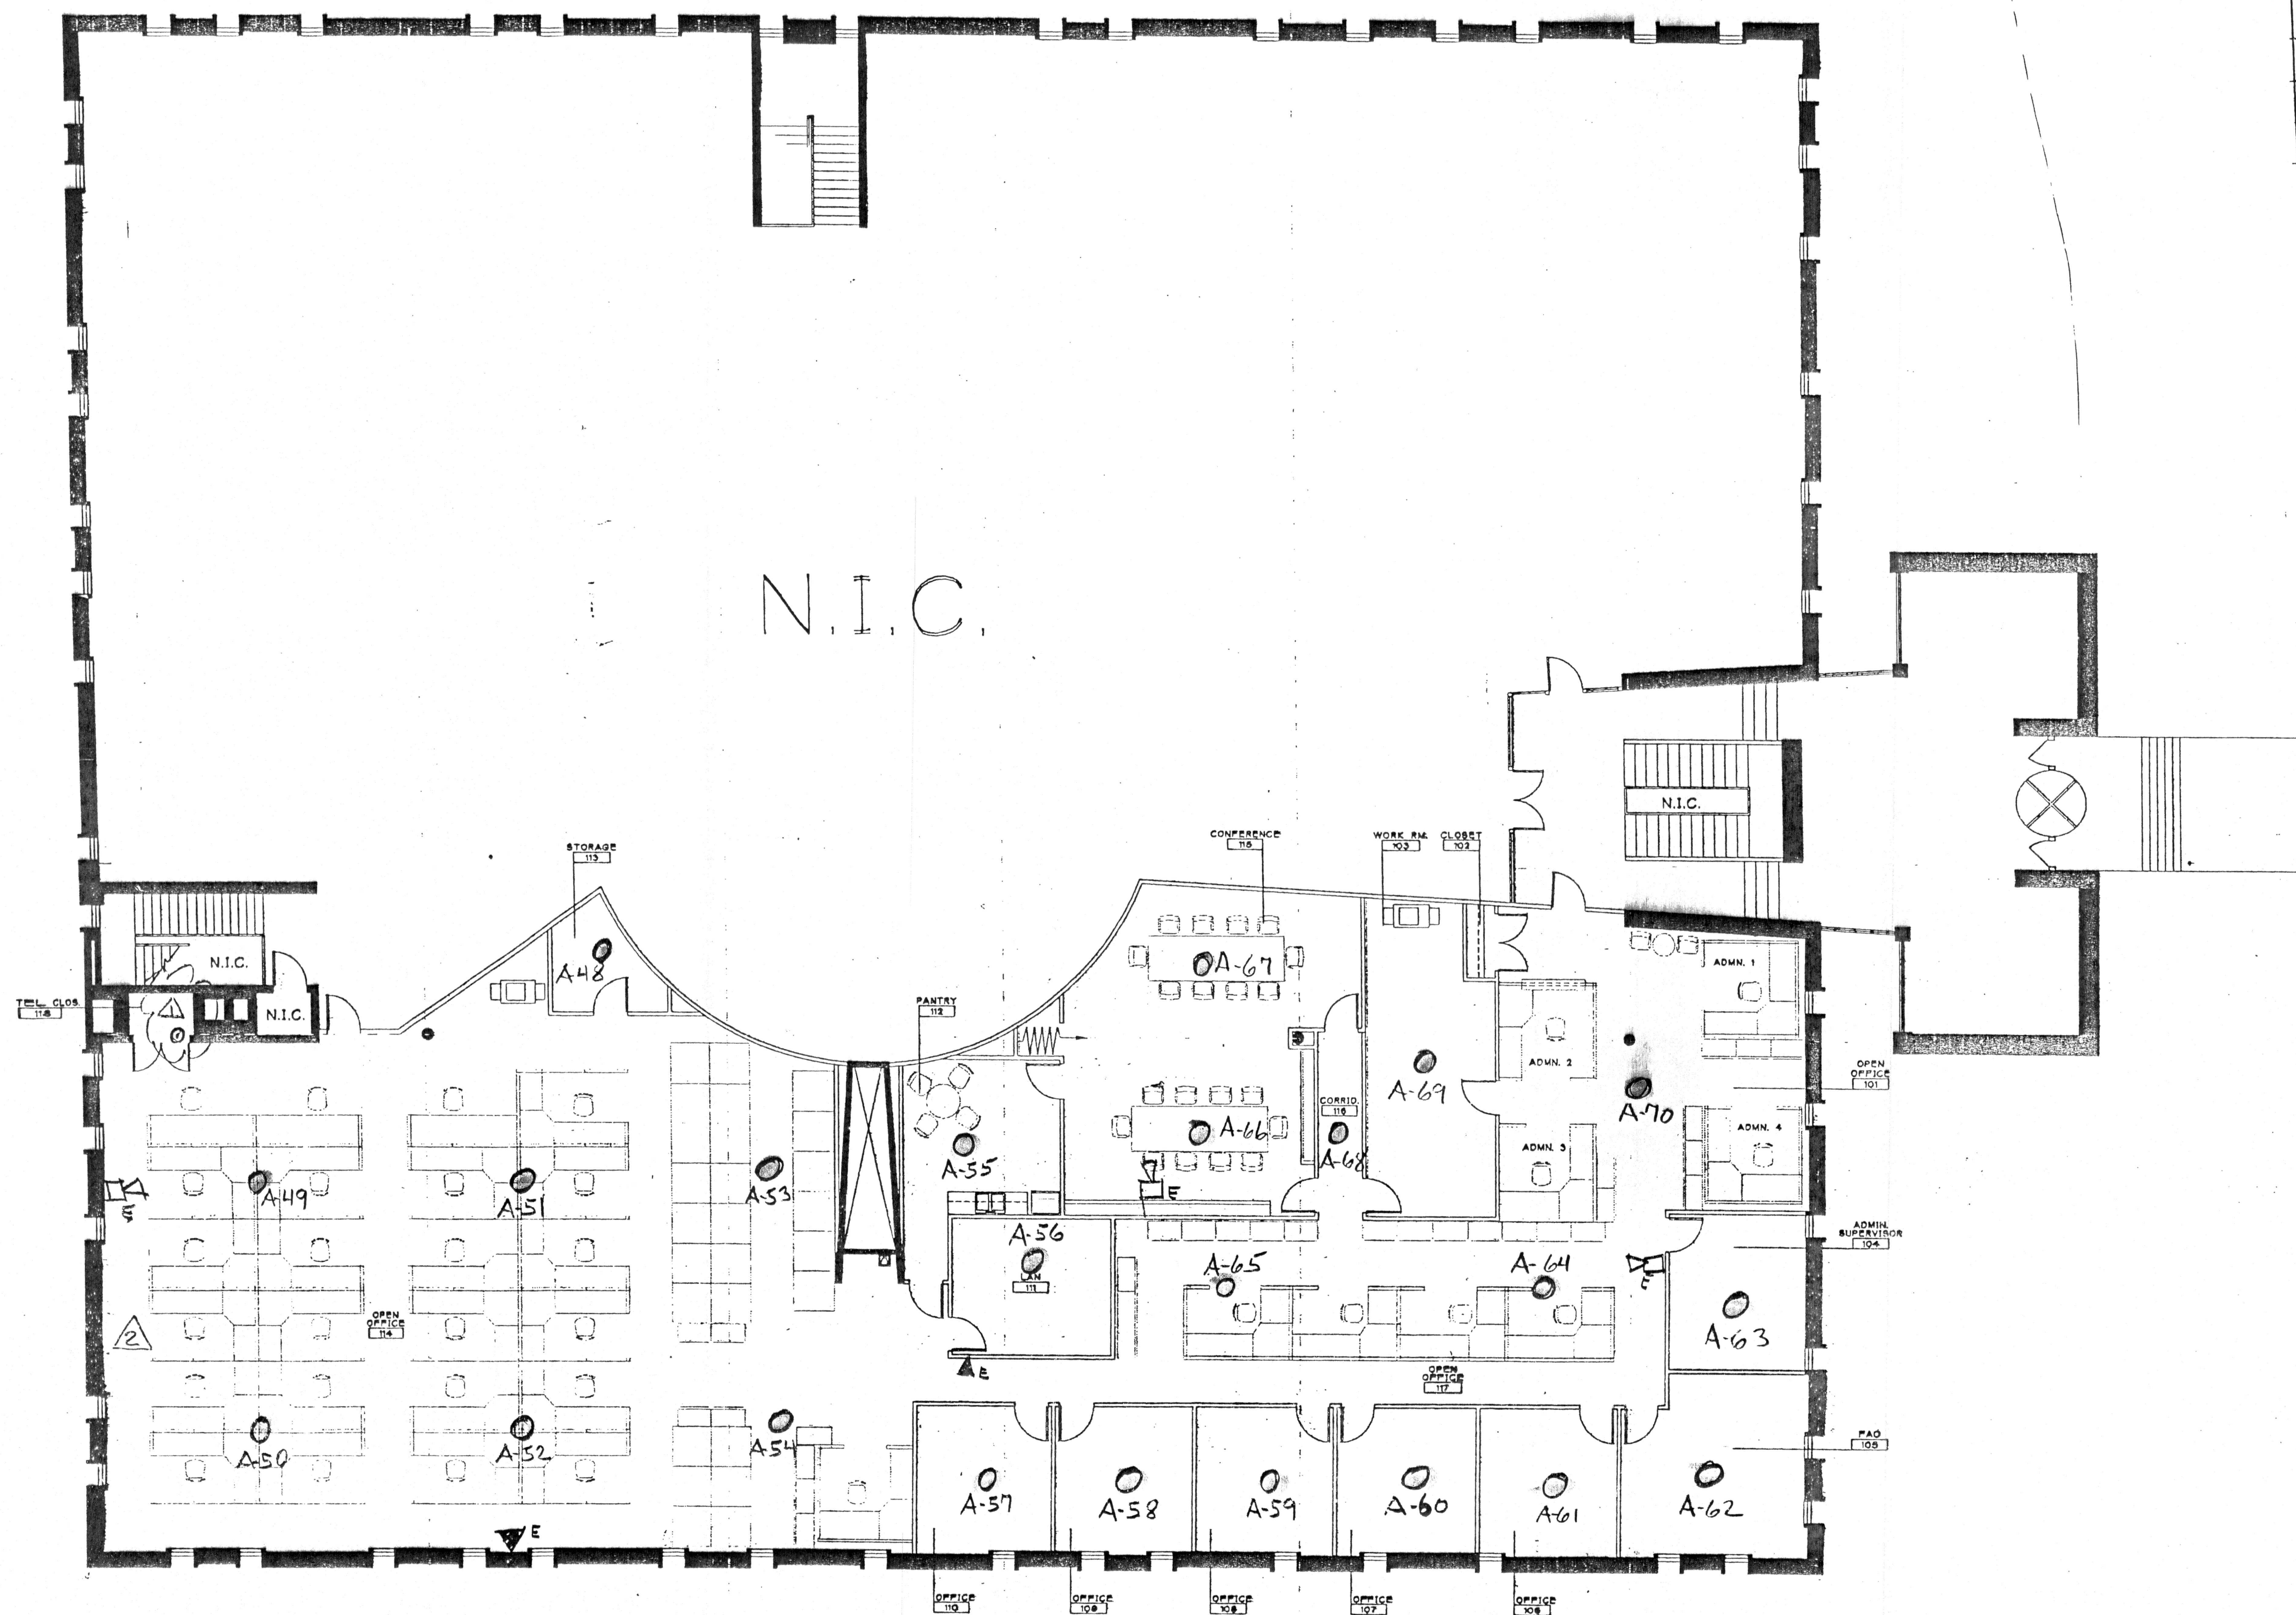

QTY	SYM	DESCRIPTION
23	Ⓢ	ADDRESSABLE SMOKE DET. - NEW
0	Ⓢ	PULL STATION - EXISTG
3	Ⓢ	EXISTG HORN STROBE
2	Ⓢ	EXISTG STROBE
1	Ⓢ	ADDRESSABLE DUCT SMOKE DET. RETURN AIR

Ⓢ - NOTE: EXISTG WIRING DOWN TO LOWER LEVEL

Ⓢ - NEW RETURN AIR DUCT DET. LOCATED ABOVE CEILING - FIELD LOCATE.

UPPER LEVEL-DCAA- AREA


APPROVED
CITY OF BRECKSVILLE
BUILDING DEPARTMENT

DEC 14 1998
BUILDING OFFICIAL
SUBJECT TO ALL BUILDING CODES


DRAWING REVIEWED
JOHN S. WETZEL
CERTIFIED FIRE ALARM
SYSTEM DESIGNER
STATE OF OHIO
CERTIFICATE
NO. F-507

Grinnell
FIRE PROTECTION SYSTEMS COMPANY
835 SHARON DRIVE WESTLAKE, OHIO 44145
A BURNER INTERNATIONAL LTD. COMPANY


APPROVALS	DATE	TITLE
DRAWN P. HAYES	12-7-98	GREATER CLEVELAND AUTOMOBILE
CHECKED P. HAYES	12-7-98	DEALERS ASSOCIATION
APPROVED		10100 BRECKSVILLE RD-BRECKSVILLE OHIO
		DCAA-UPPER LEVEL
		FIRE SYSTEM
CADFILE:	SIZE	JOB/DRAWING NO.
LAST UPDATE:	D	SK120998PH-4
	SCALE	AS NOTED
	SHEET	4 OF 5

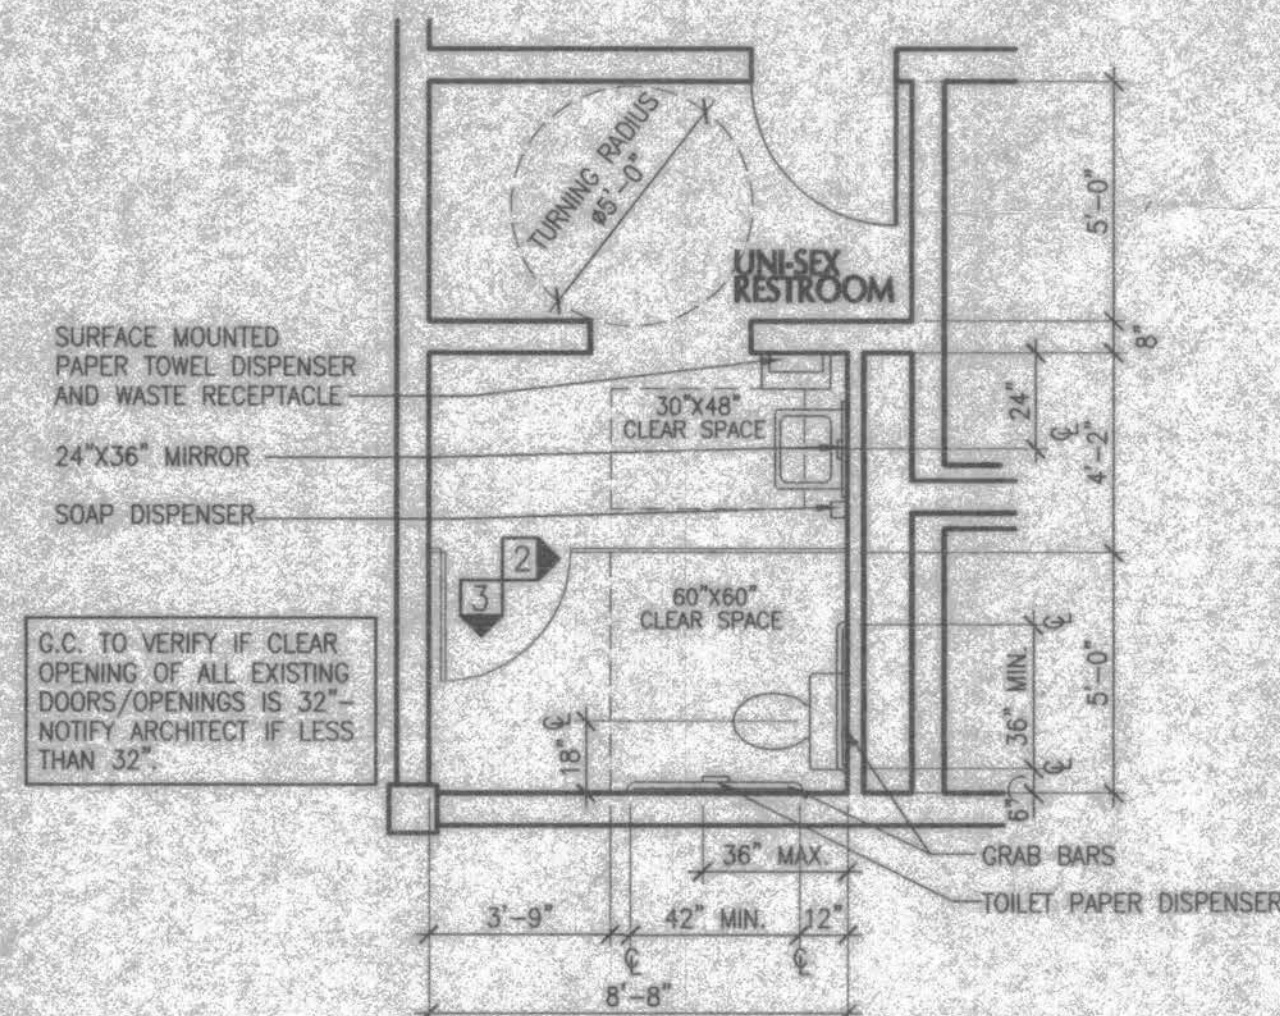


ENLARGED PLAN SCALE 1/4" = 1'-0" 1 A101

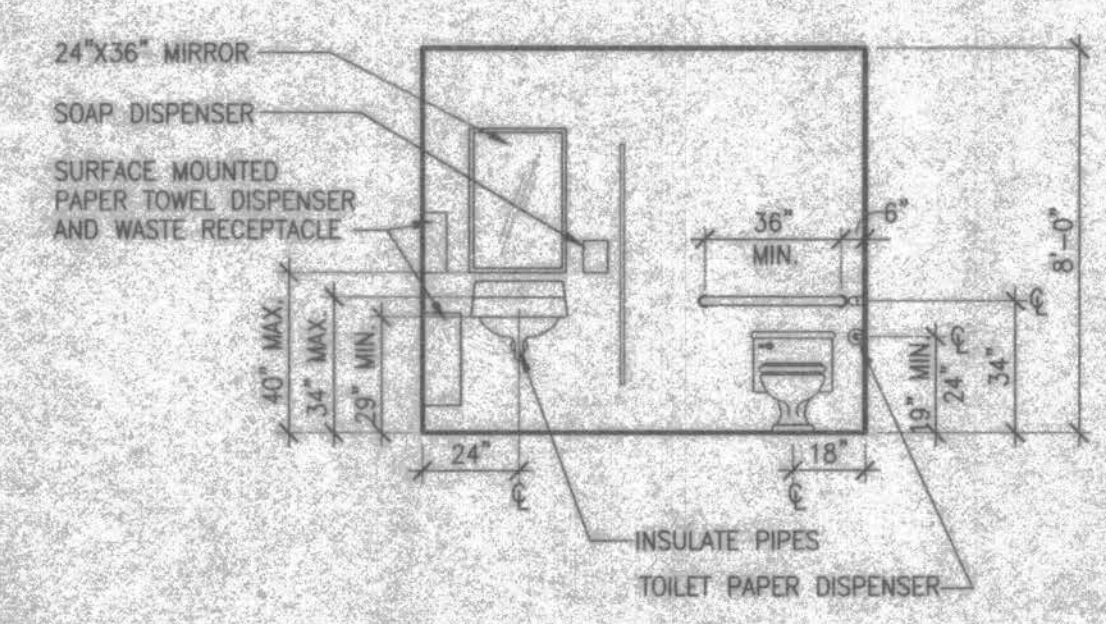

ELEVATION SCALE 1/4" = 1'-0" 2 A101

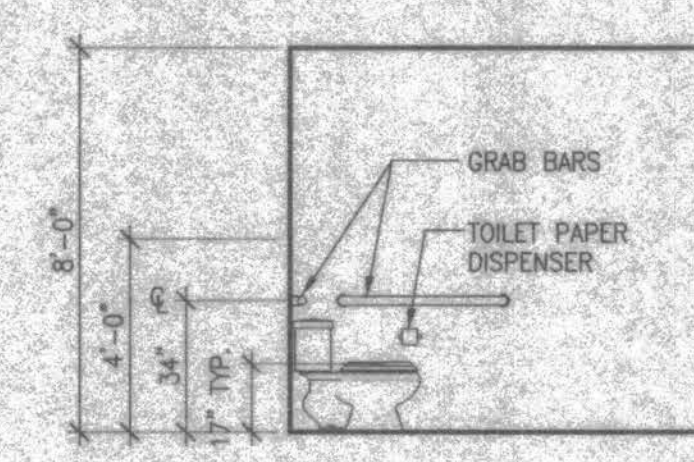

ELEVATION SCALE 1/4" = 1'-0" 3 A101

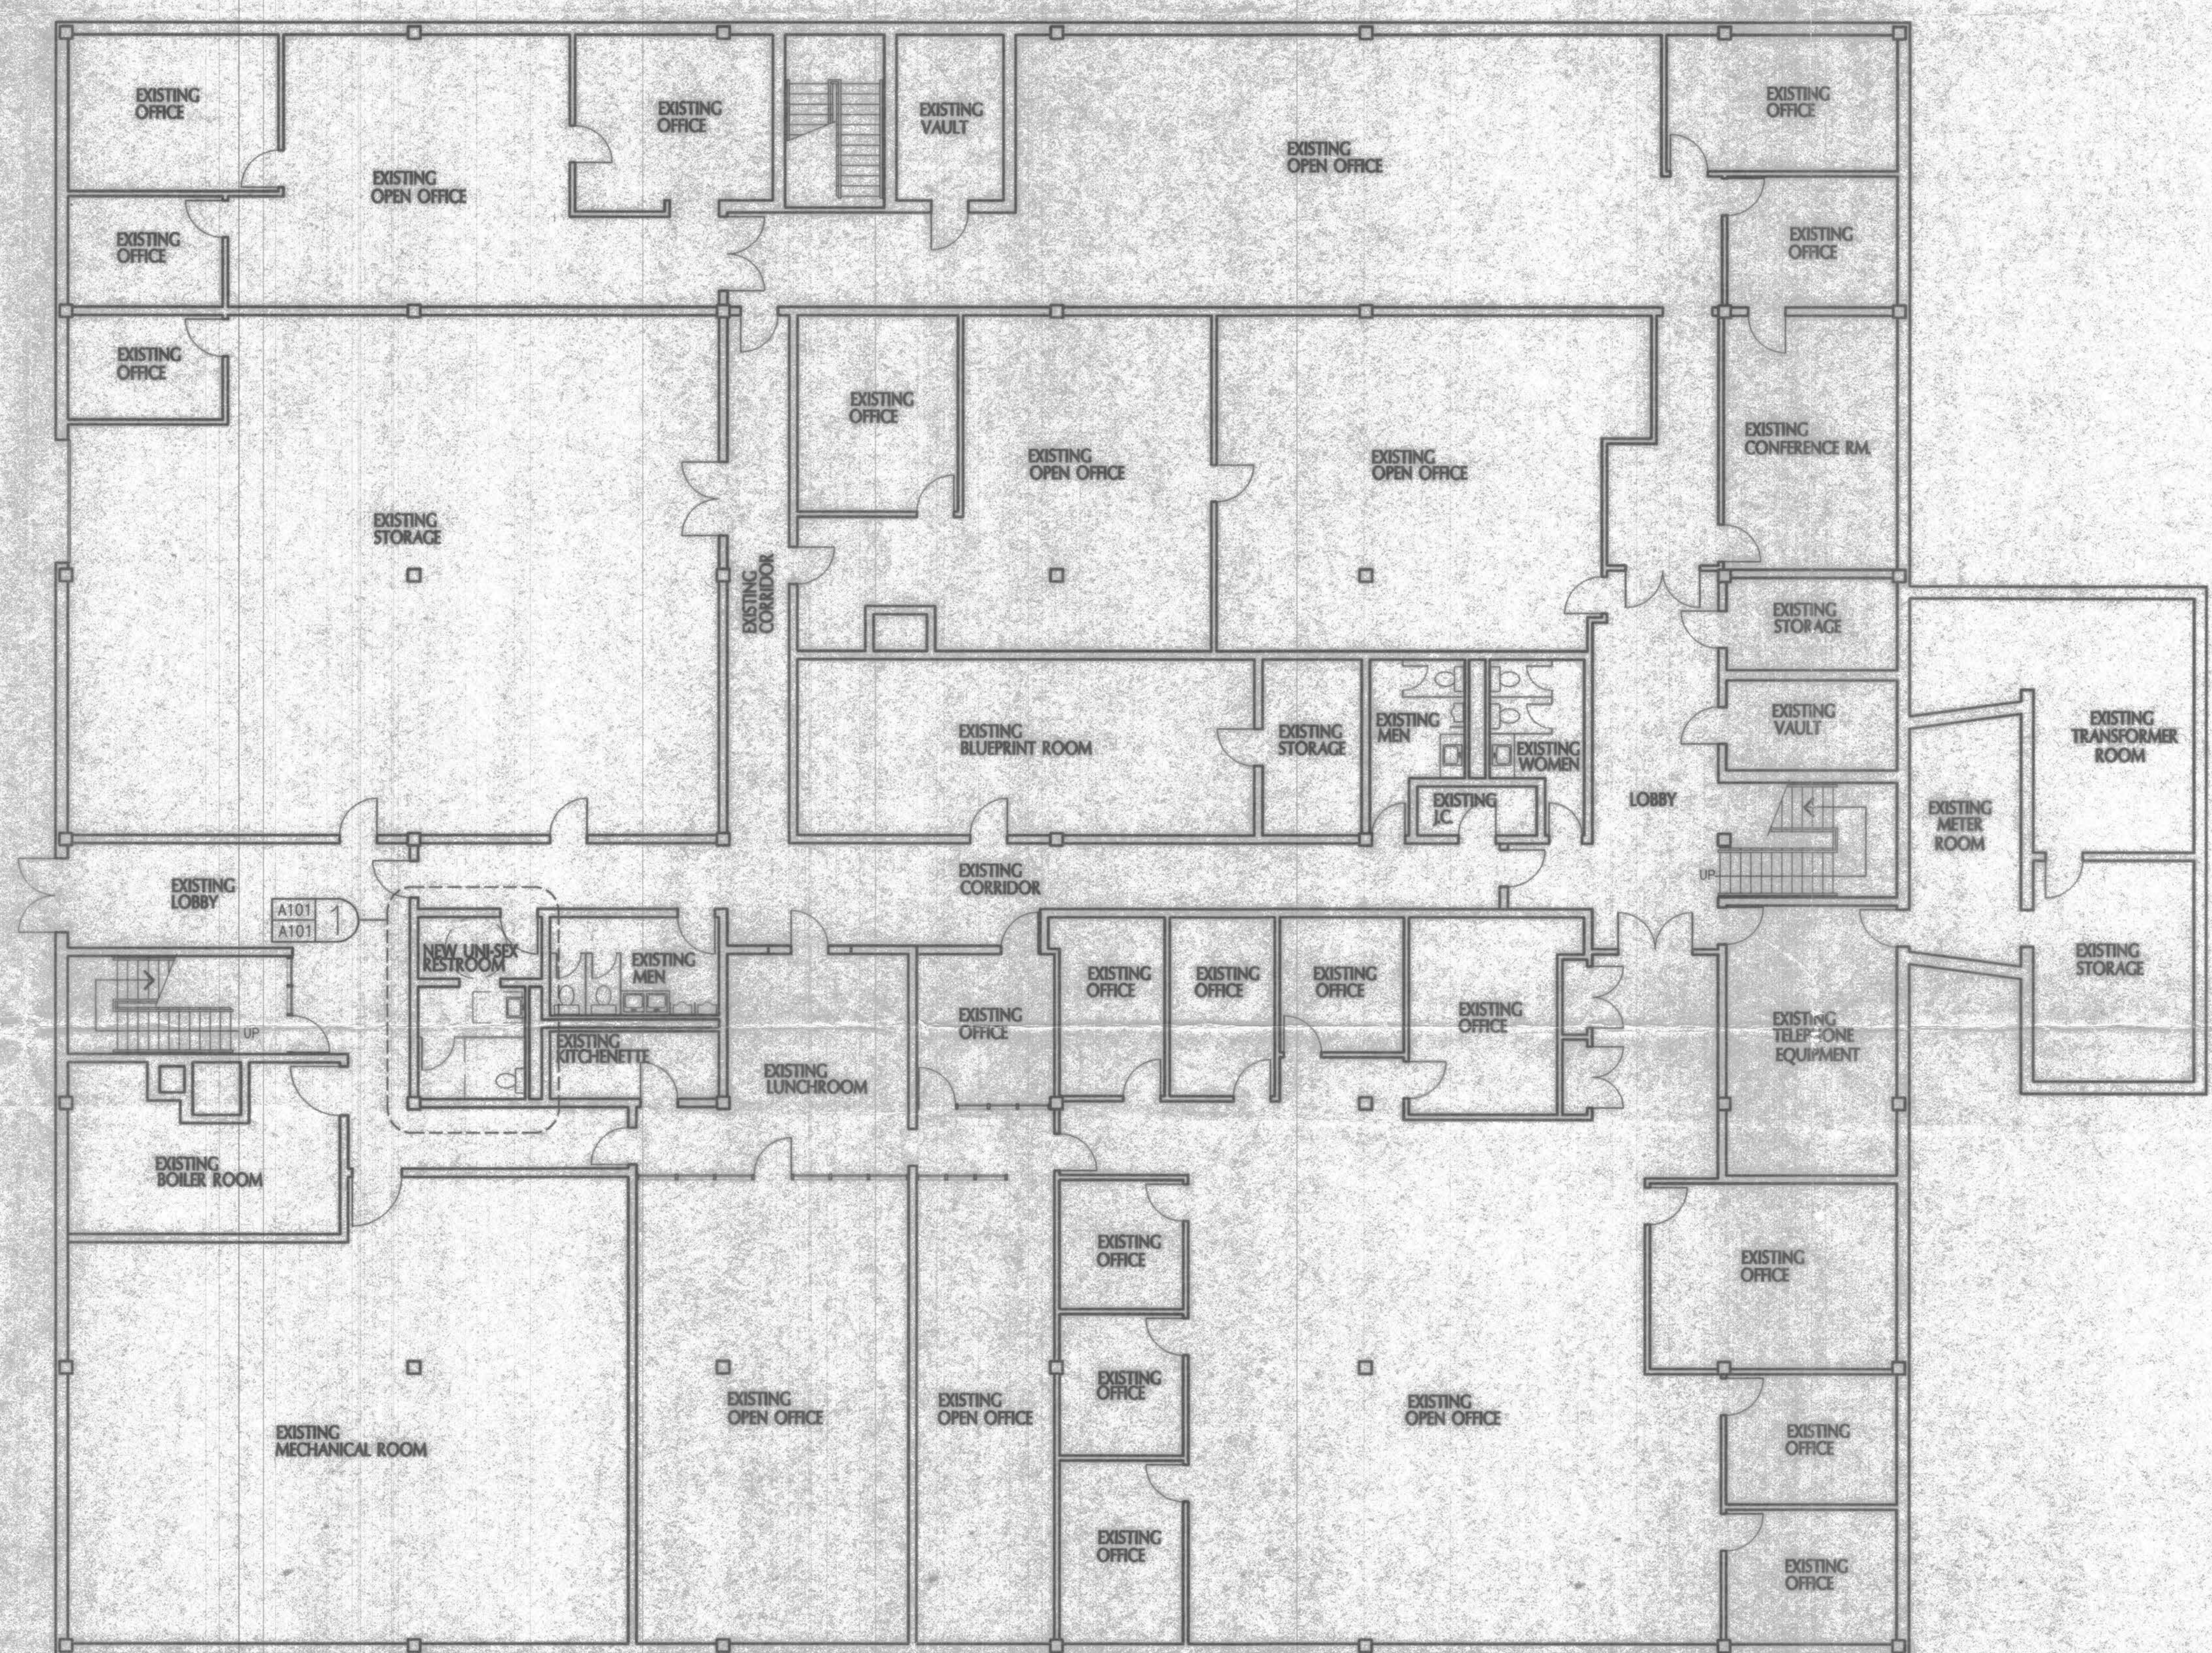

LOWER LEVEL FLOOR PLAN SCALE: 1/8" = 1'-0"

Client:
DMW
CONSTRUCTION
MANAGEMENT

575 WEDGEWOOD DR.
AVON LAKE, OHIO
44012

G.C.A.D.A.
OFFICE BUILDING
GRINNELL FIRE
PROTECTION
SYSTEMS

10100 BRECKSVILLE RD.
BRECKSVILLE, OHIO

	ISSUED FOR CONSTRUCTION
	ISSUED FOR PERMIT
	ISSUED FOR BID
	ISSUED FOR PLAN CHECK

Sheet Title

LOWER LEVEL
FLOOR PLAN

Project No.:	98.391.01
Drawn By:	KDM
Checked By:	
Current Date:	12/14/98
Filename:	

A101