


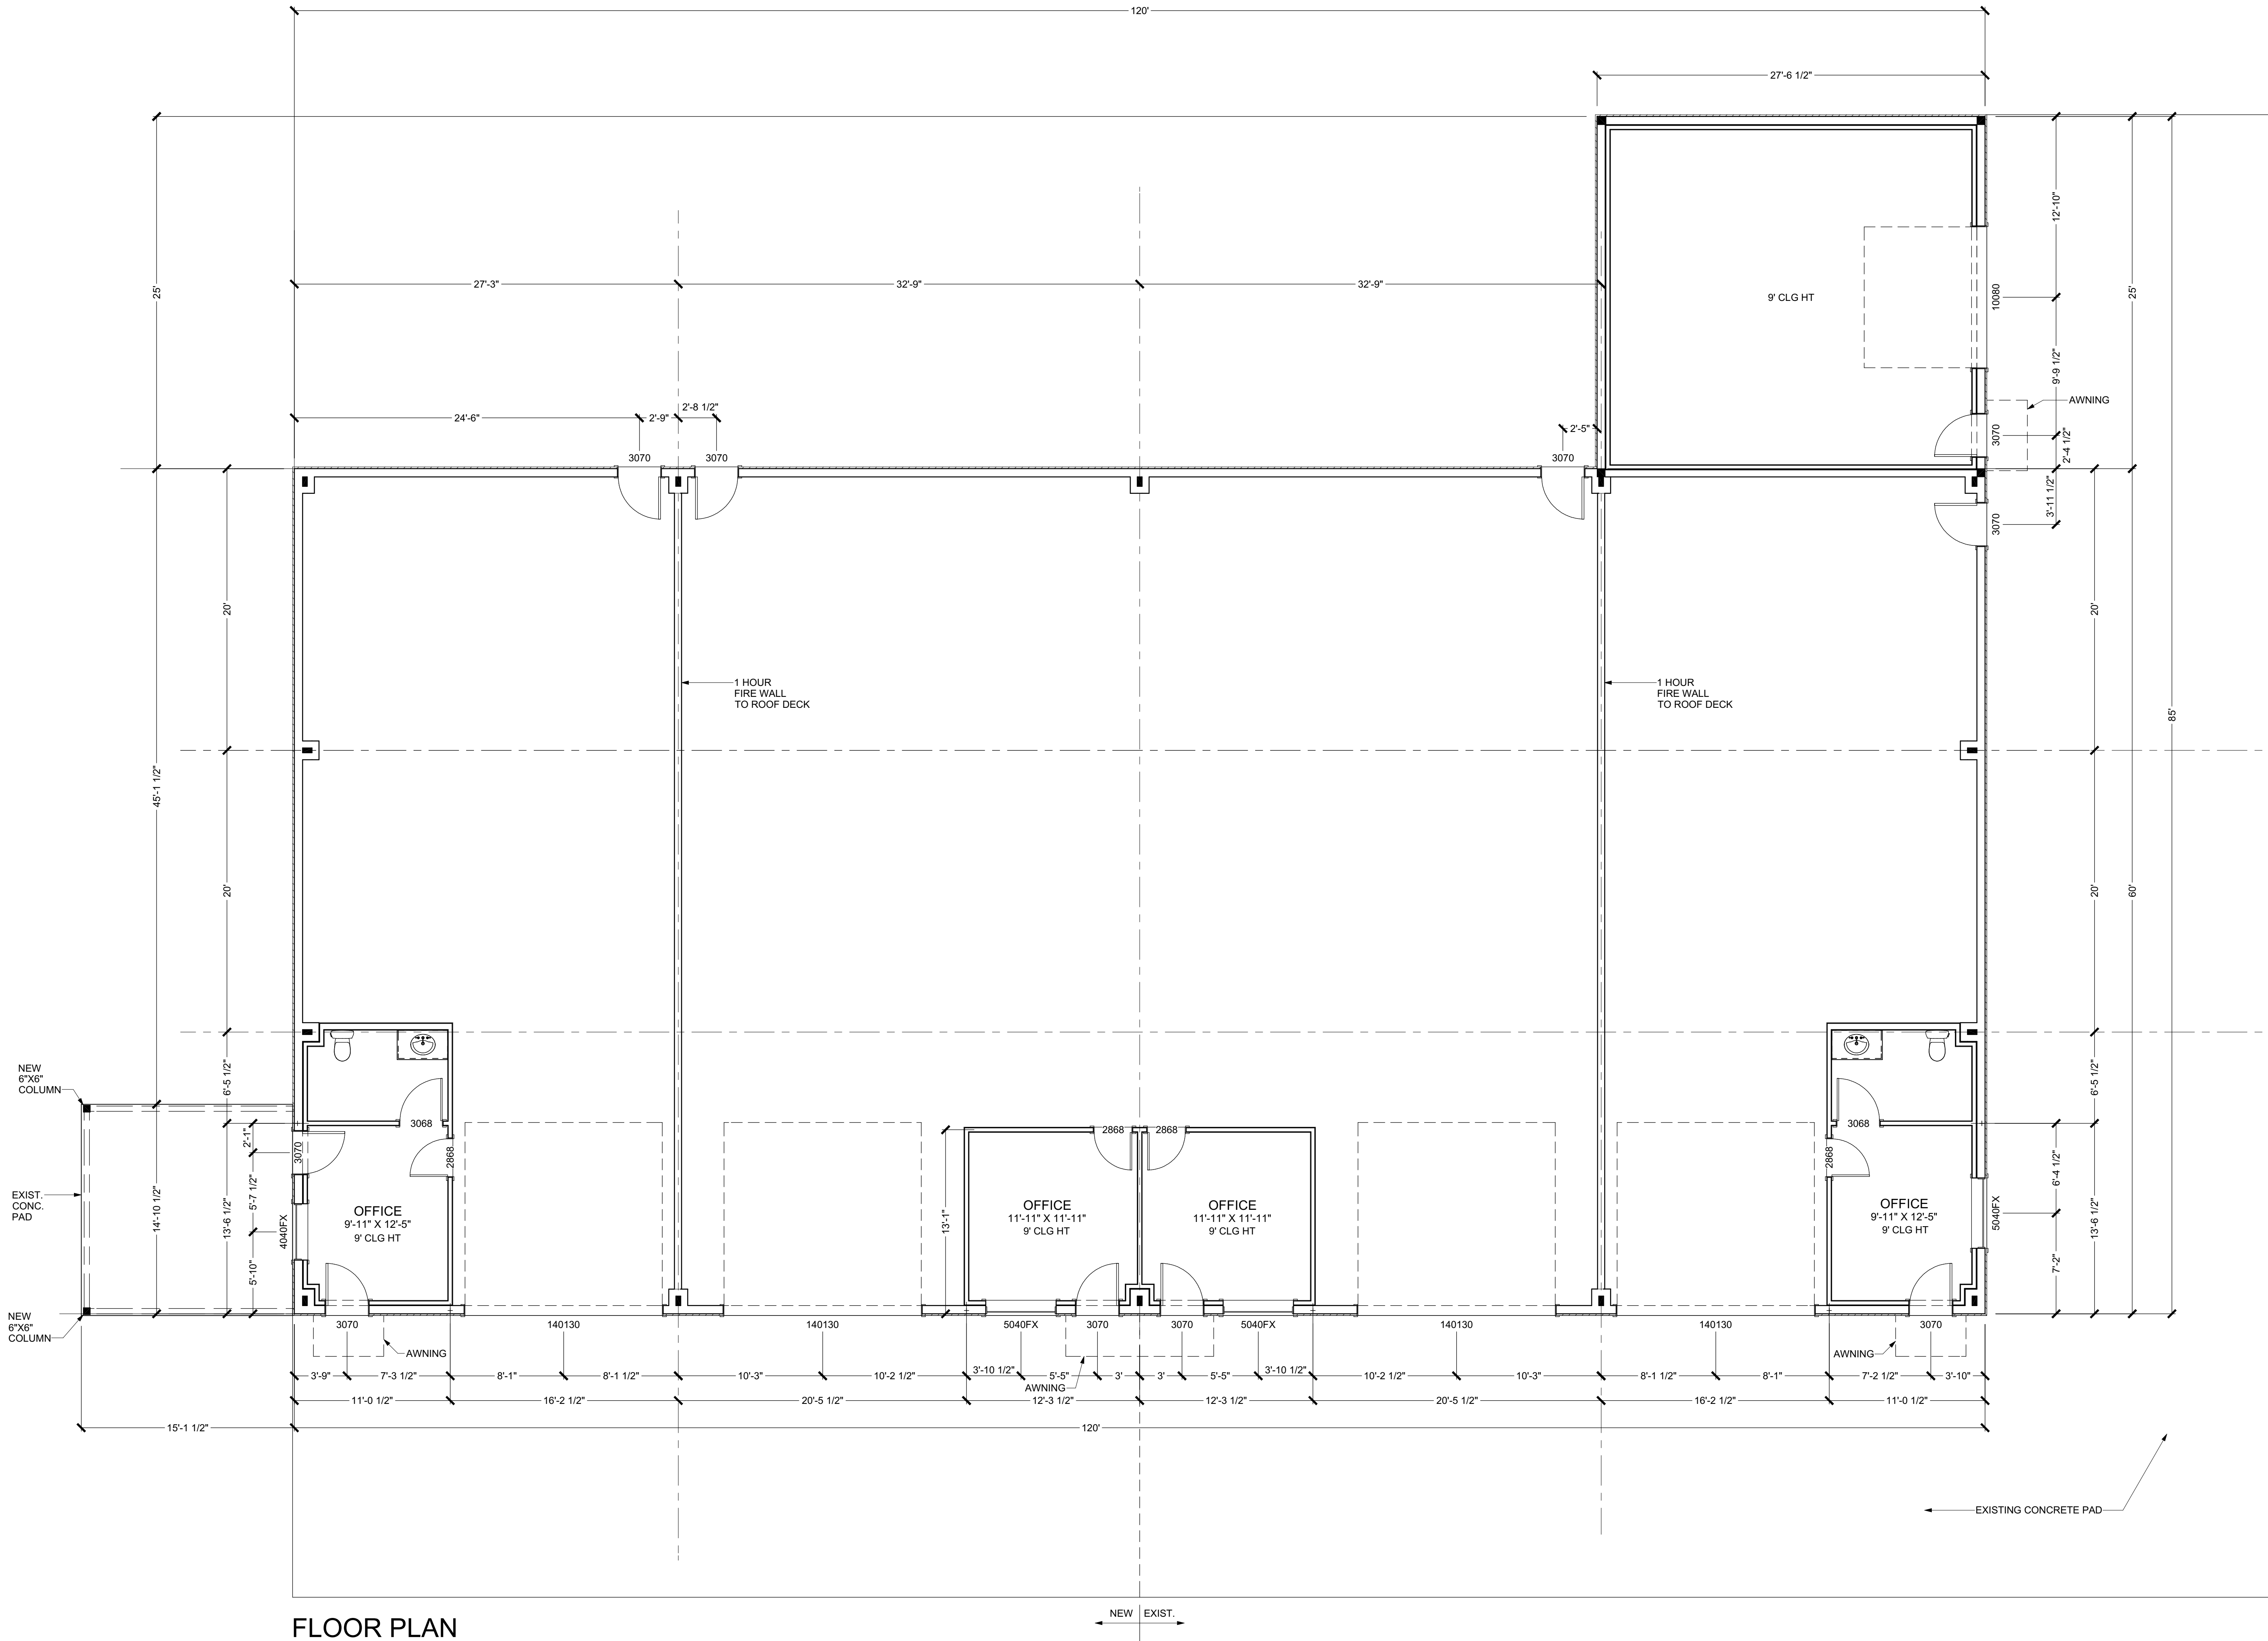

FLOOR PLAN
SCALE: 3/16"=1'-0"

REVISION TABLE		DESCRIPTION
NUMBER	DATE	REVISOR

PROJECT DESCRIPTION:
A New Remodel/Addition for
PANDU PALWAY
Wible Road
Sherman, Texas

DRAWINGS PROVIDED BY:
NBS DRAFTING AND DESIGN
303 W. HOUSTON
SHERMAN, TEXAS 75090
903.892.5620


DATE:

4/11/2025


SCALE:

SHEET:


A-1

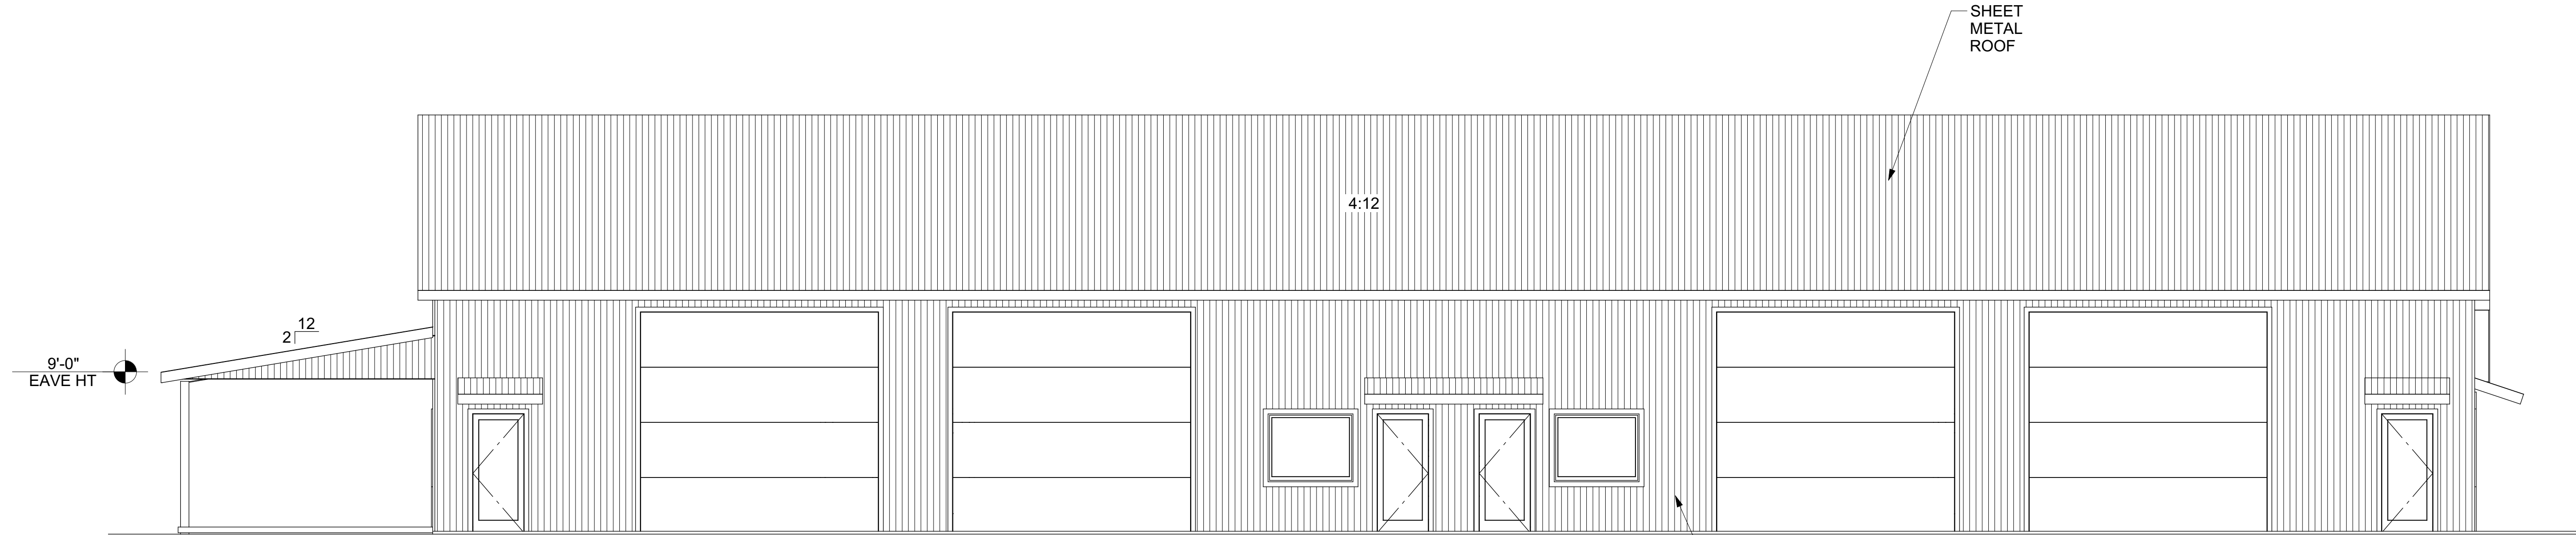


EAST ELEVATION
SCALE:3/16"=1'-0"

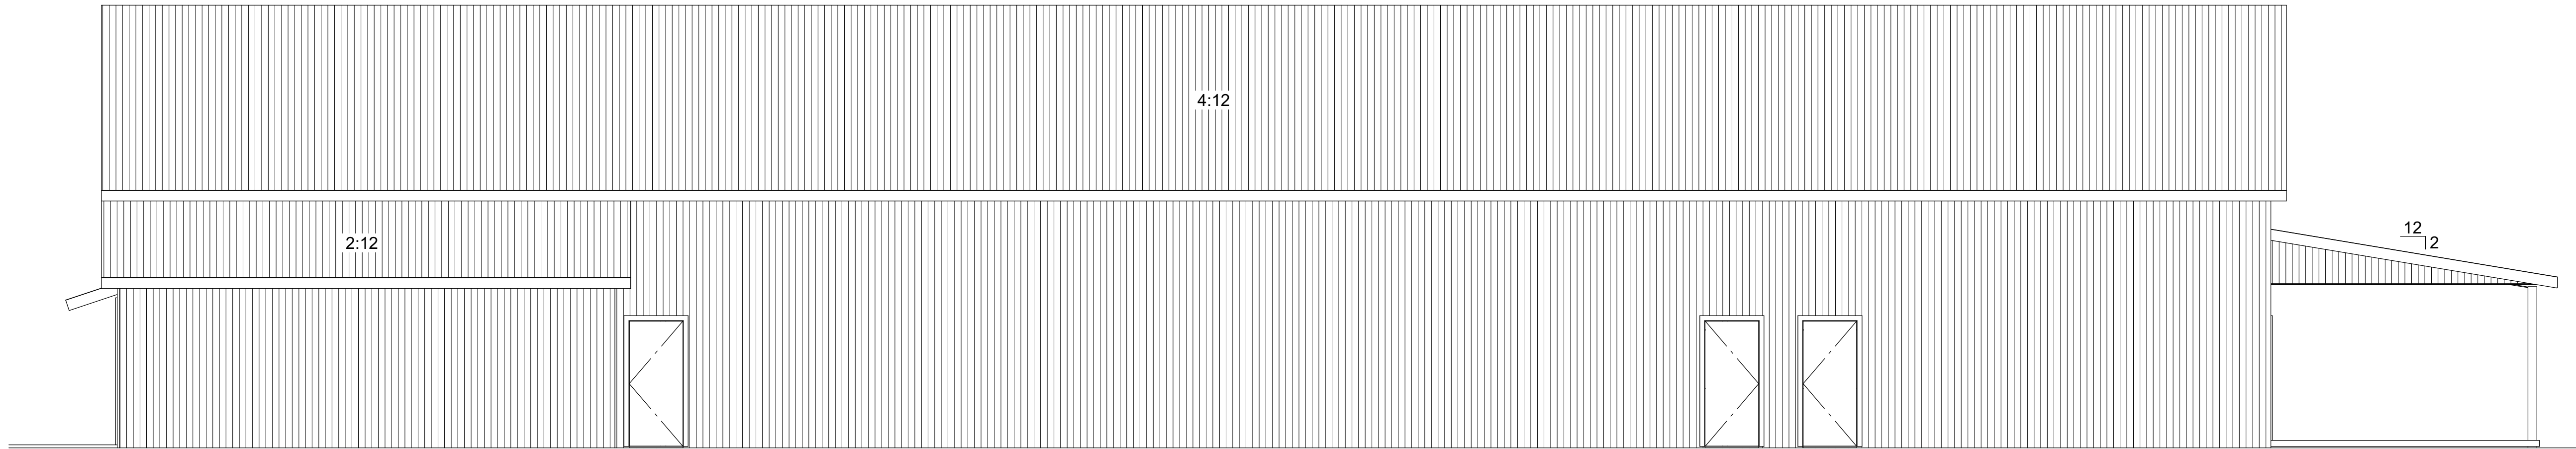

WEST ELEVATION
SCALE:3/16"=1'-0"

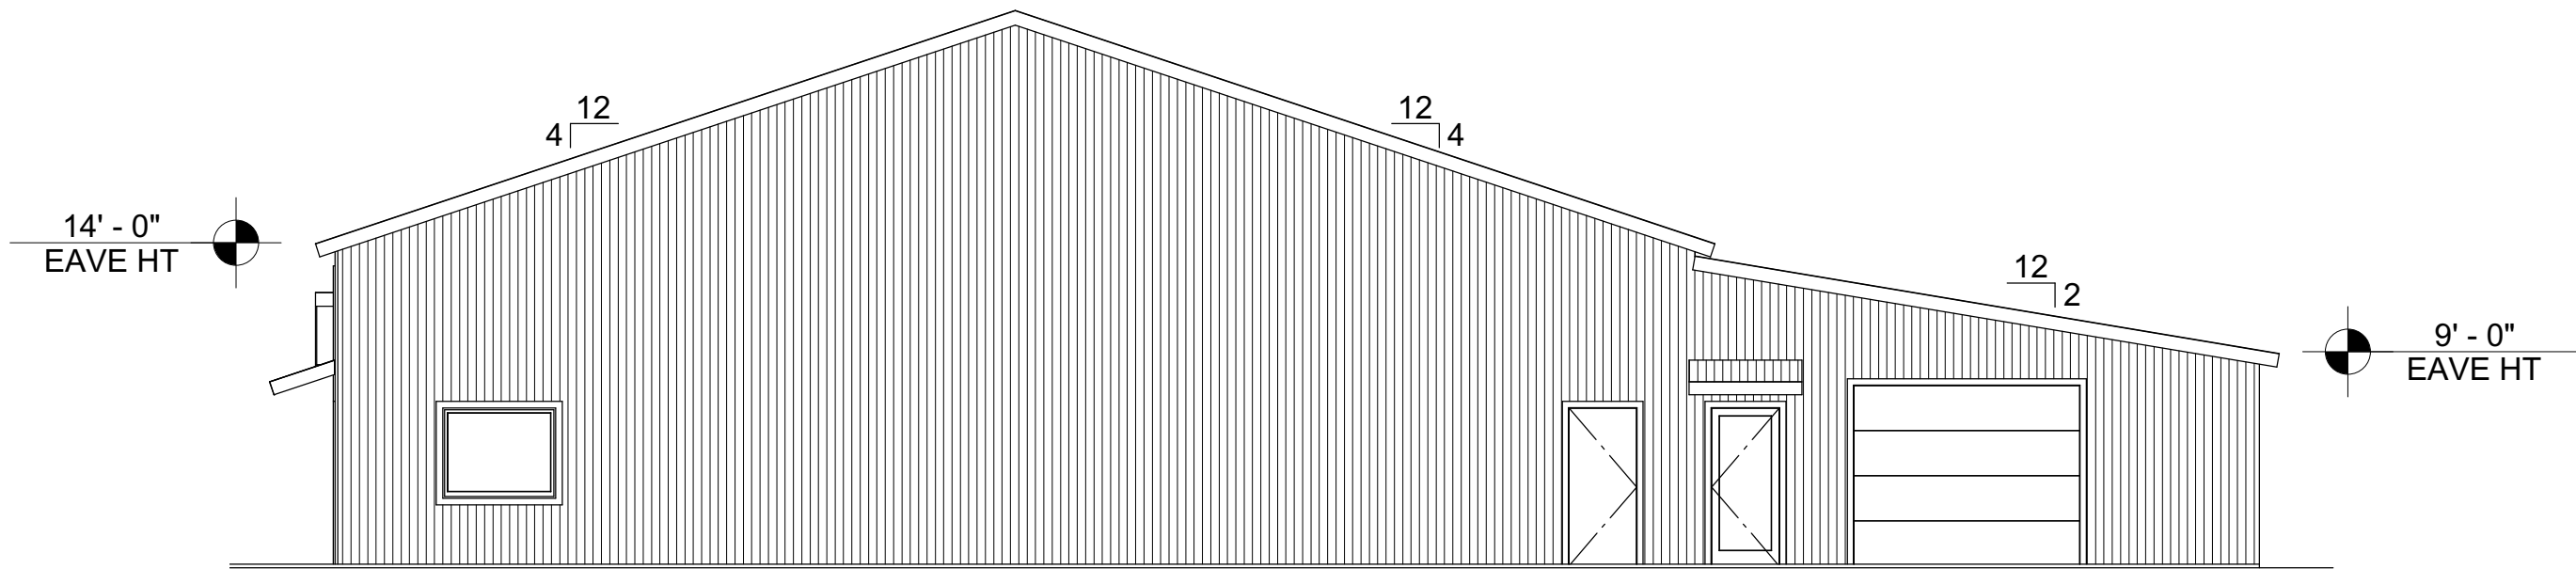

NORTH ELEVATION
SCALE:1/8"=1'-0"

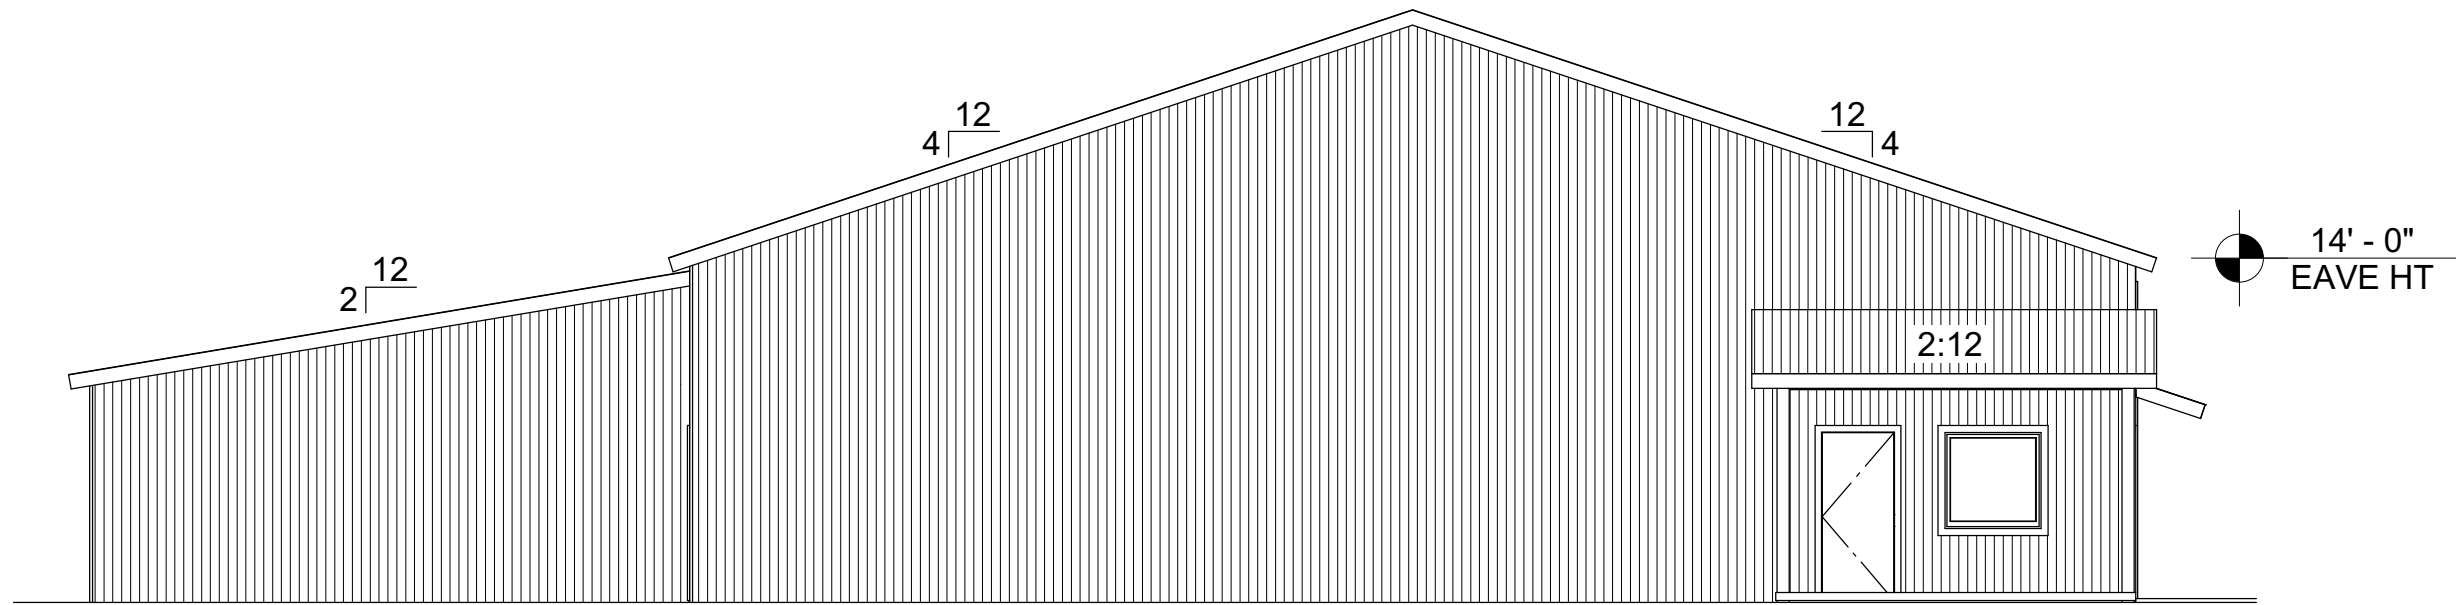

SOUTH ELEVATION
SCALE:1/8"=1'-0"

REVISION TABLE		DESCRIPTION
NUMBER	DATE	REVISOR

PROJECT DESCRIPTION:
A New Remodel/Addition for
PANDU PALWAY
Wible Road
Sherman, Texas

DRAWINGS PROVIDED BY:
NBS DRAFTING AND DESIGN
303 W. HOUSTON
SHERMAN, TEXAS 75090
903.892.5620


DATE:

4/11/2025

SCALE:

SHEET:

A-2

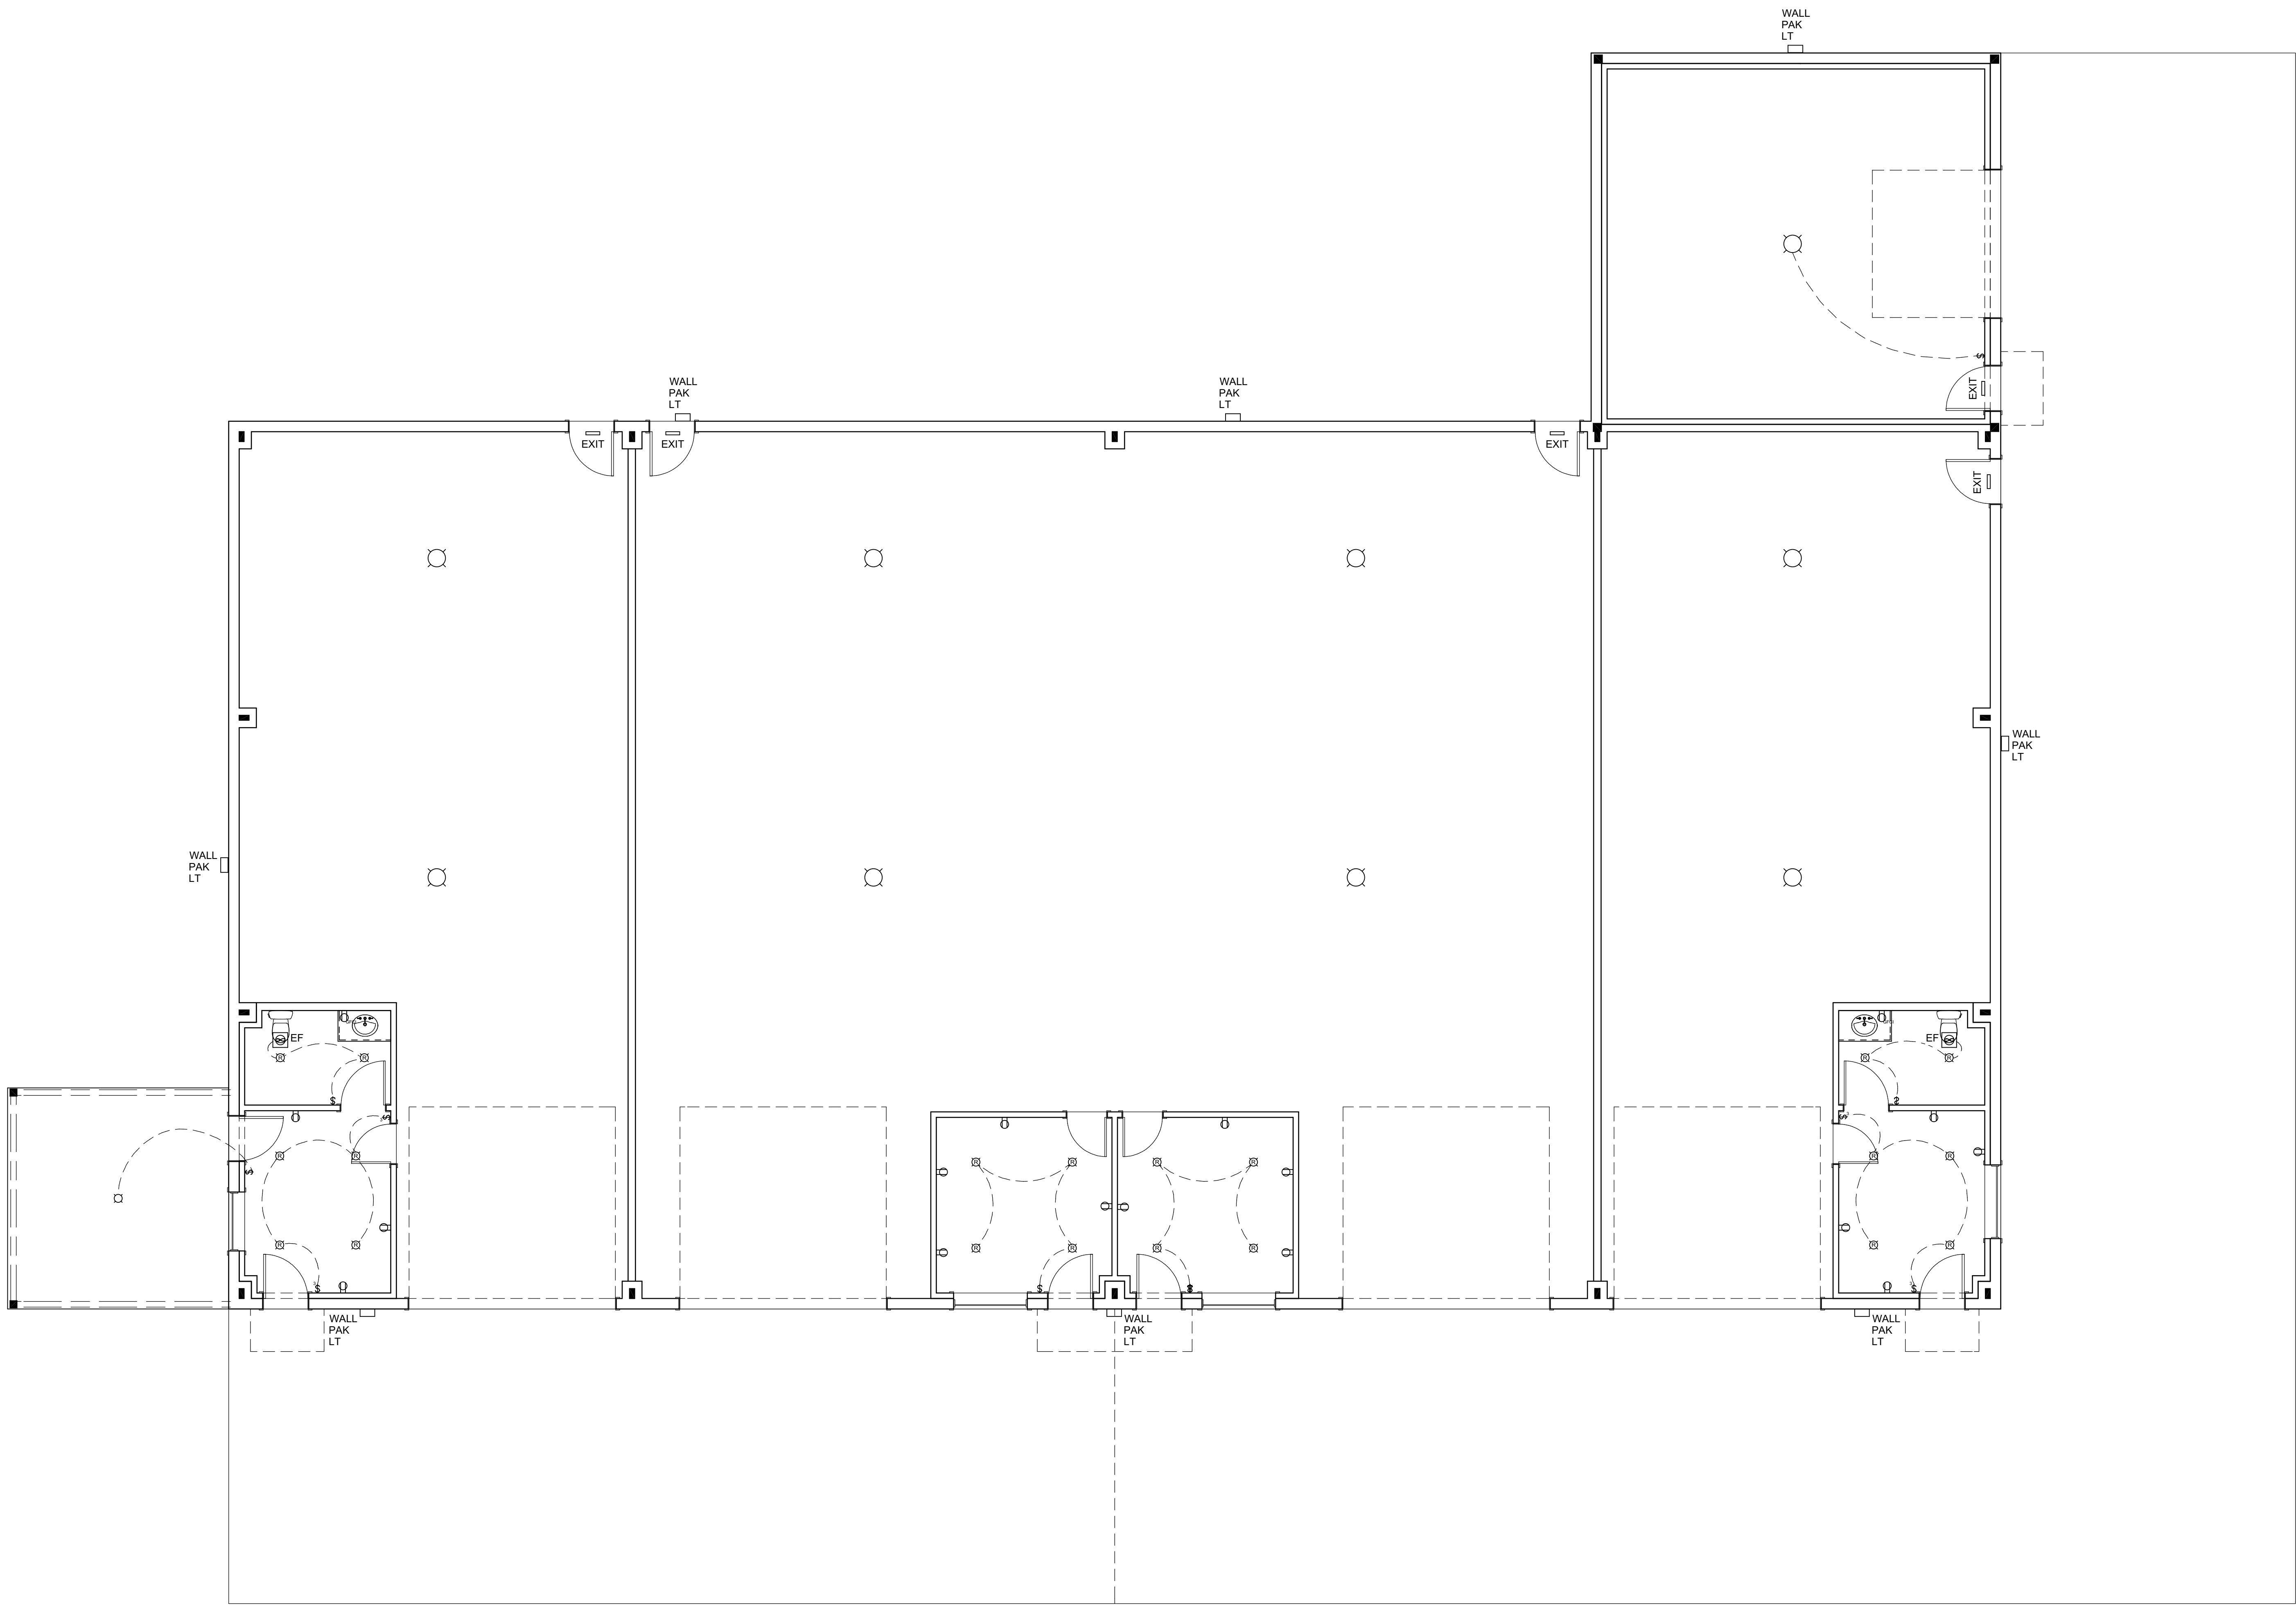

ELECTRICAL PLAN
SCALE:3/16"=1'-0"

REVISION TABLE		
NUMBER	DATE	DESCRIPTION

PROJECT DESCRIPTION:
A New Remodel/Addition for
PANDU PALWAY
Wible Road
Sherman, Texas

DRAWINGS PROVIDED BY:
NBS DRAFTING AND DESIGN
303 W. HOUSTON
SHERMAN, TEXAS 75090
903.892.5620


DATE:

4/11/2025

SCALE:

SHEET:

A-3

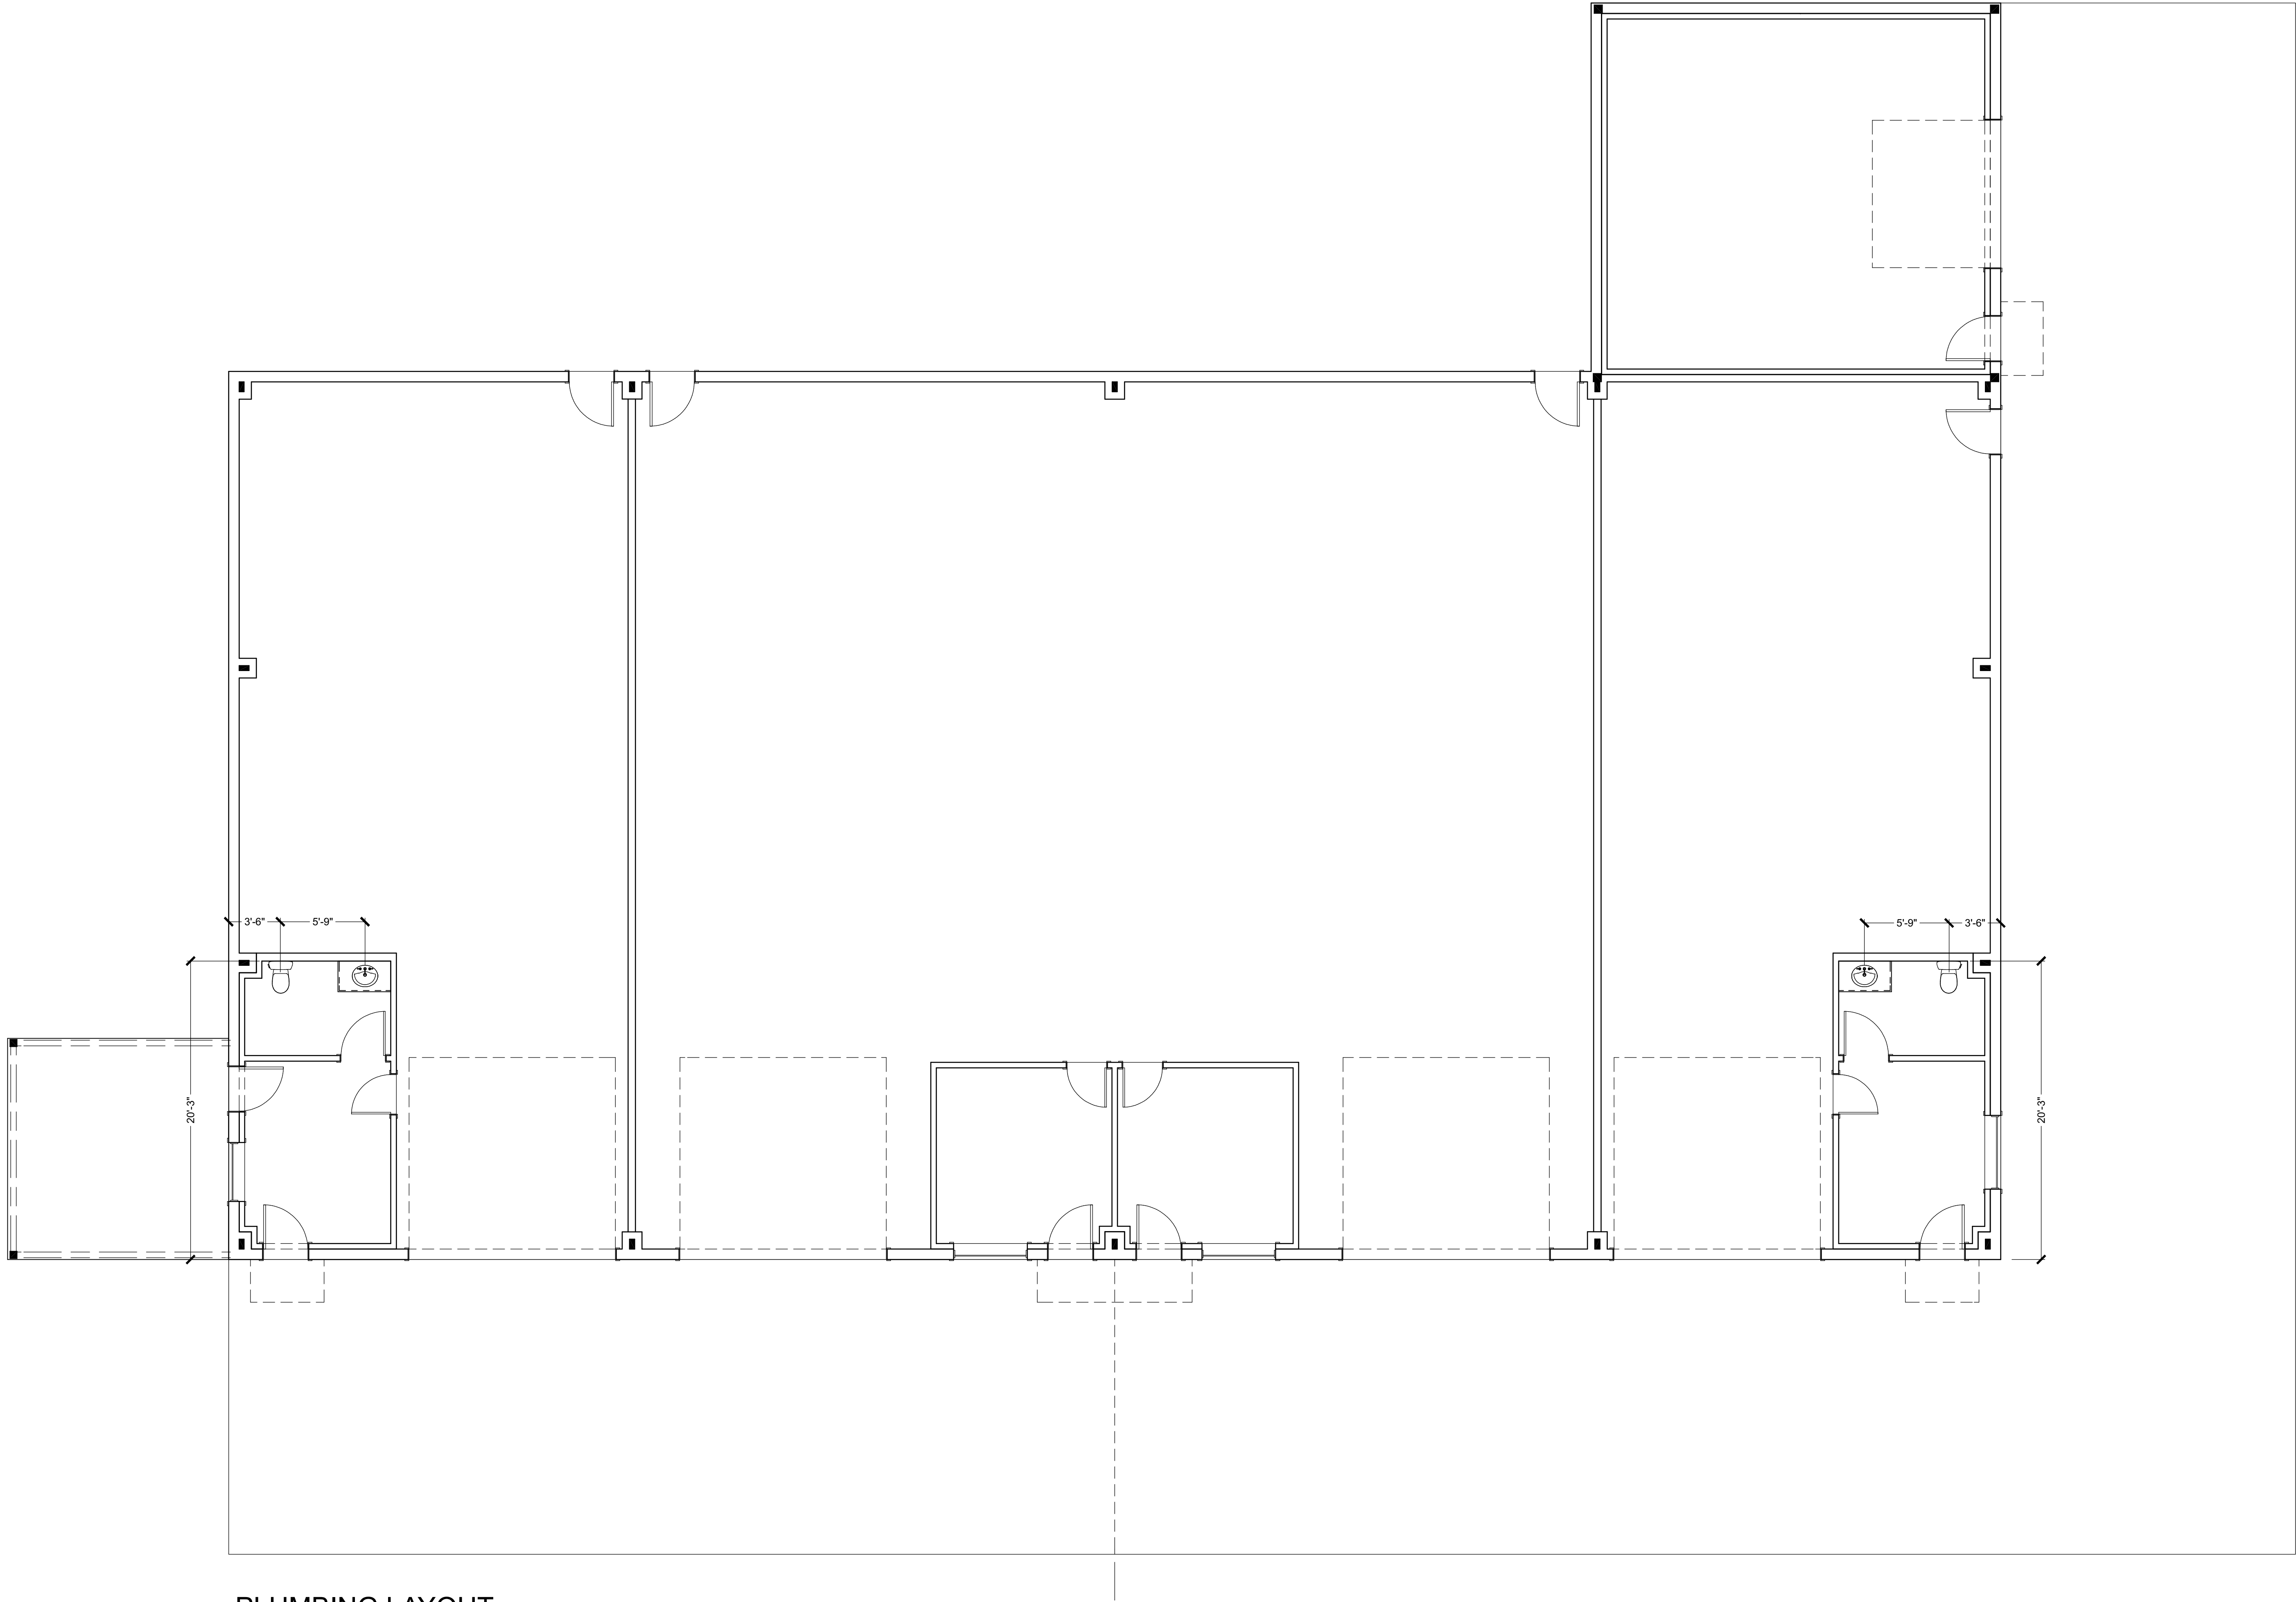

PLUMBING LAYOUT
SCALE:3/16"=1'-0"

--

REVISION TABLE		DESCRIPTION
NUMBER	DATE	

--

PROJECT DESCRIPTION:
A New Remodel/Addition for
PANDU PALWAY
Wible Road
Sherman, Texas

DRAWINGS PROVIDED BY:
NBS DRAFTING AND DESIGN
303 W. HOUSTON
SHERMAN, TEXAS 75090
903.892.5620


DATE:

4/11/2025

SCALE:

SHEET:

A-4

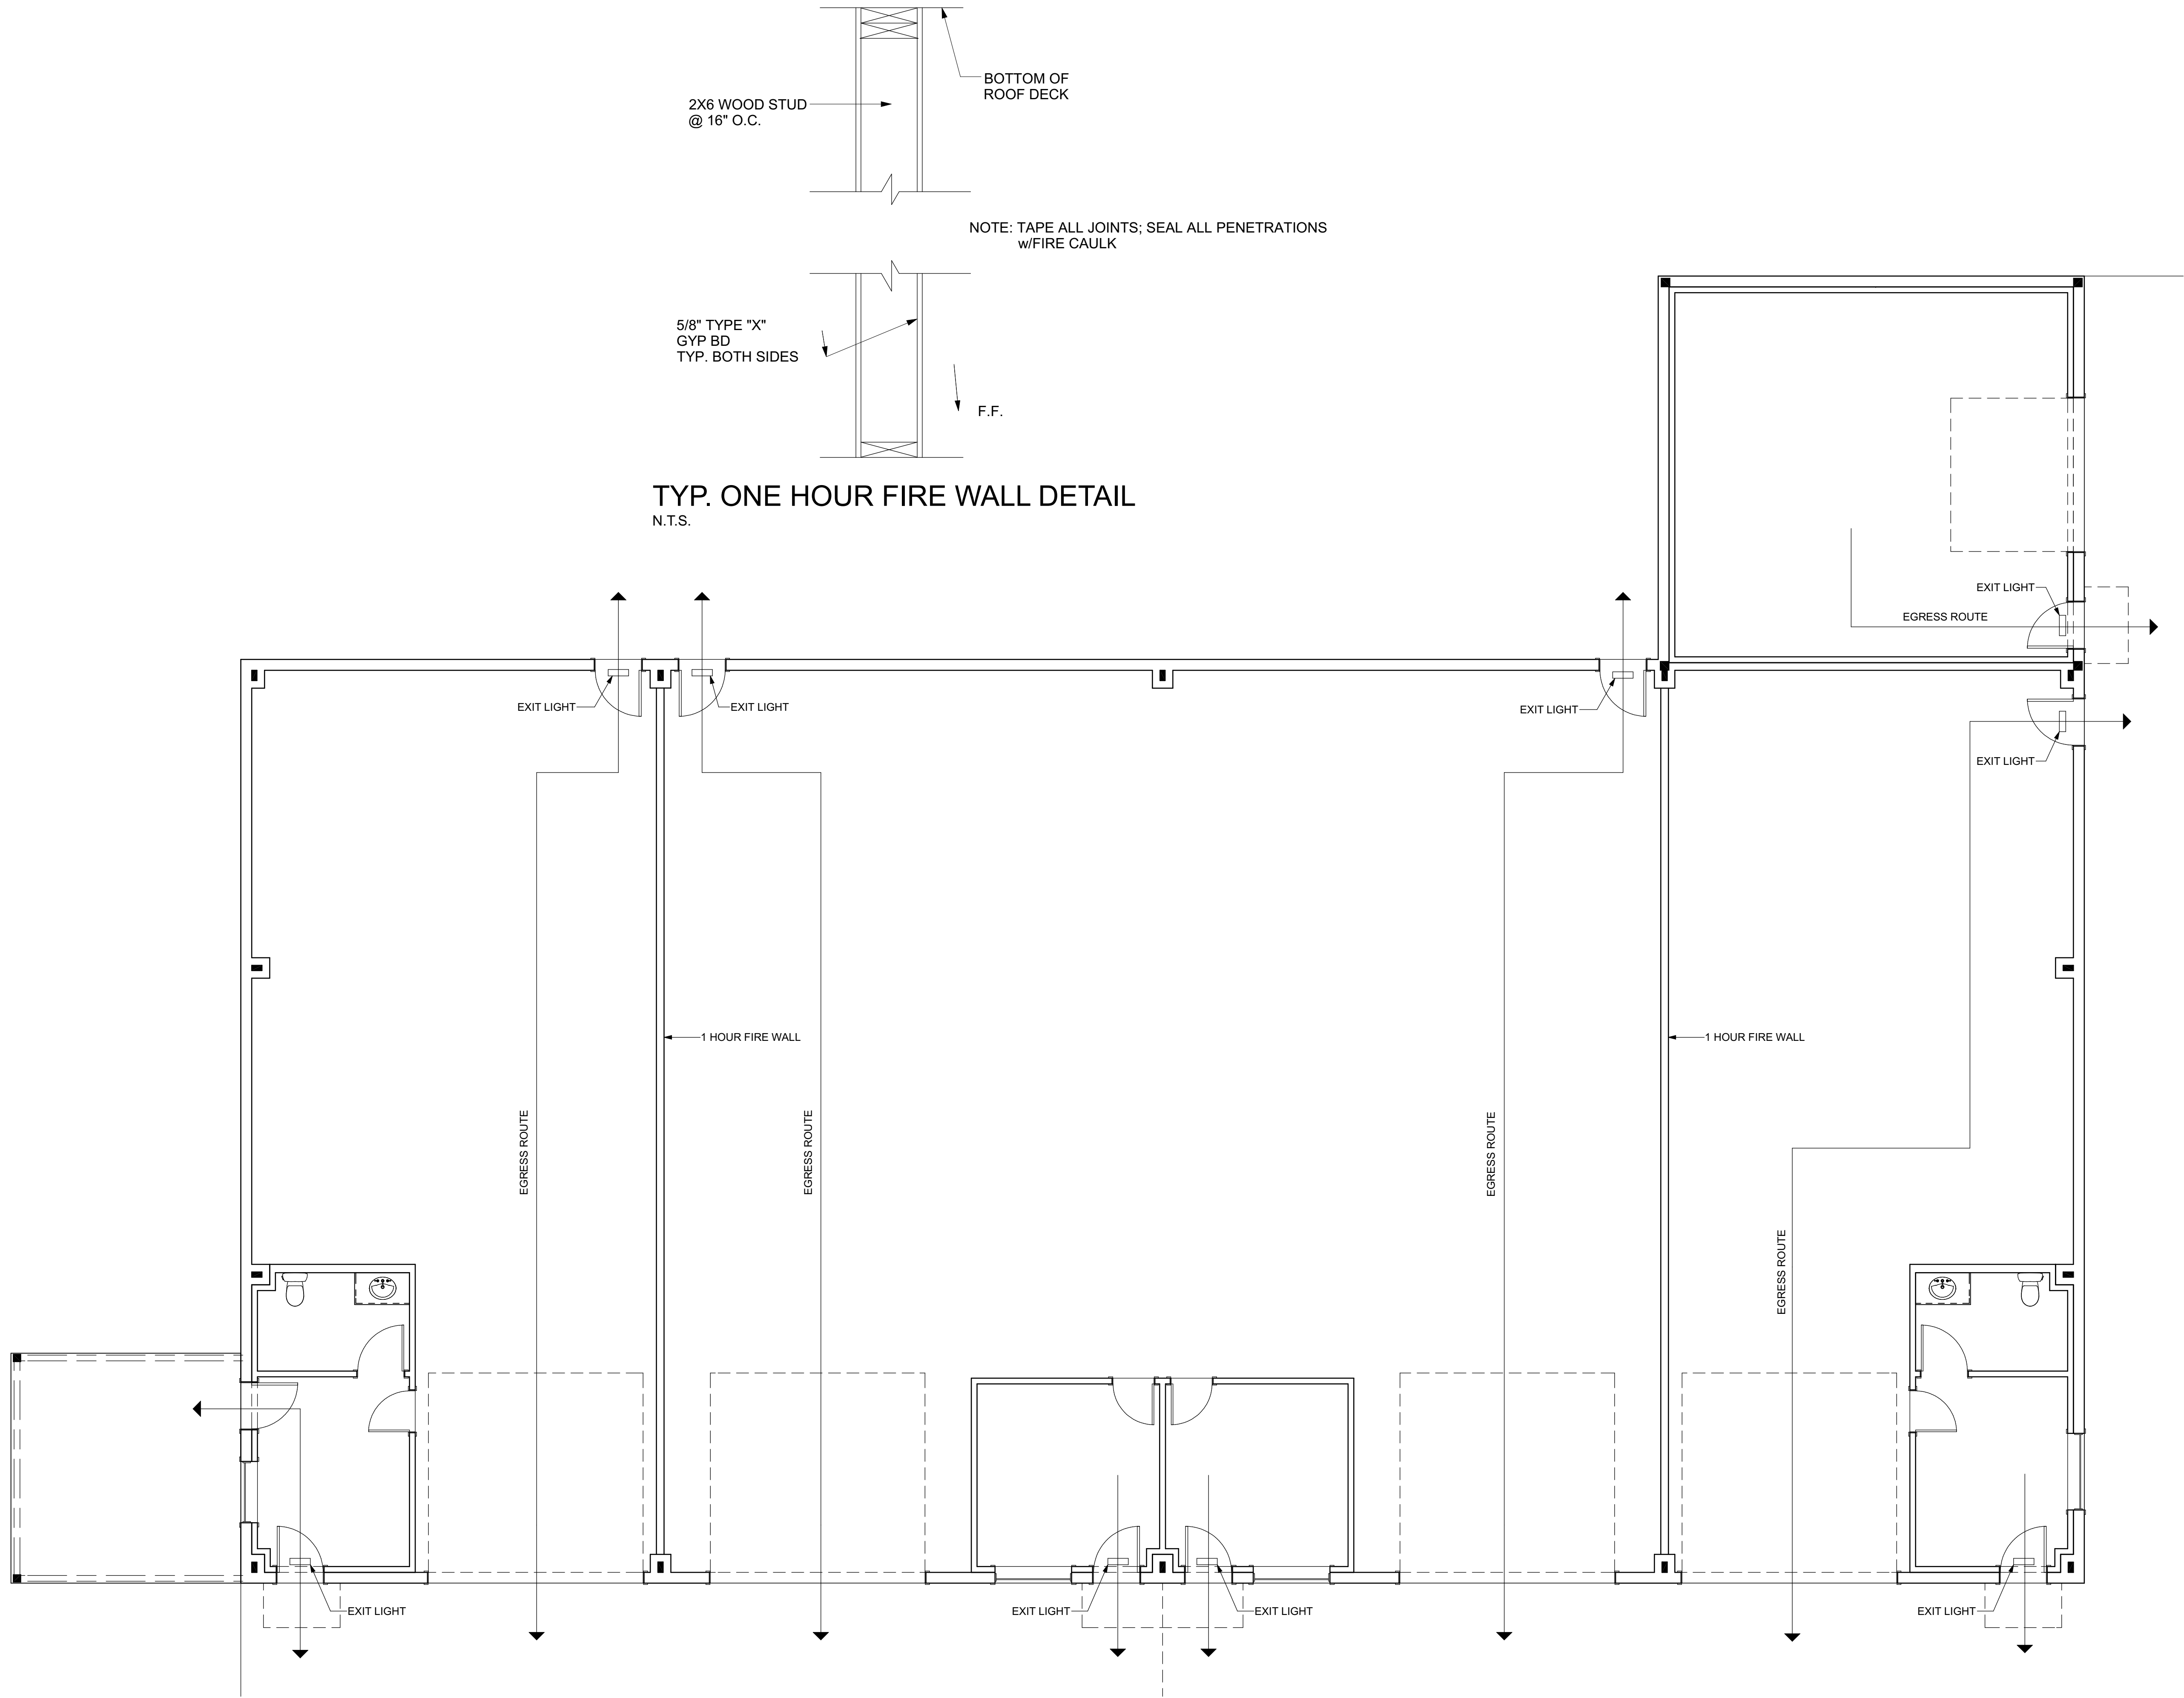

LIFE SAFETY PLAN
SCALE:3/16" = 1'-0"

--	--	--	--	--	--	--	--	--	--

REVISION TABLE		REVISION BY		DESCRIPTION	
NUMBER	DATE				

--	--	--	--	--	--	--	--	--	--

PROJECT DESCRIPTION:
A New Remodel/Addition for
PANDU PALWAY
Wible Road
Sherman, Texas

DRAWINGS PROVIDED BY:
NBS DRAFTING AND DESIGN
303 W. HOUSTON
SHERMAN, TEXAS 75090
903.892.5620

DATE:


4/11/2025

SCALE:


SHEET:

A-5

WIBLE ROAD

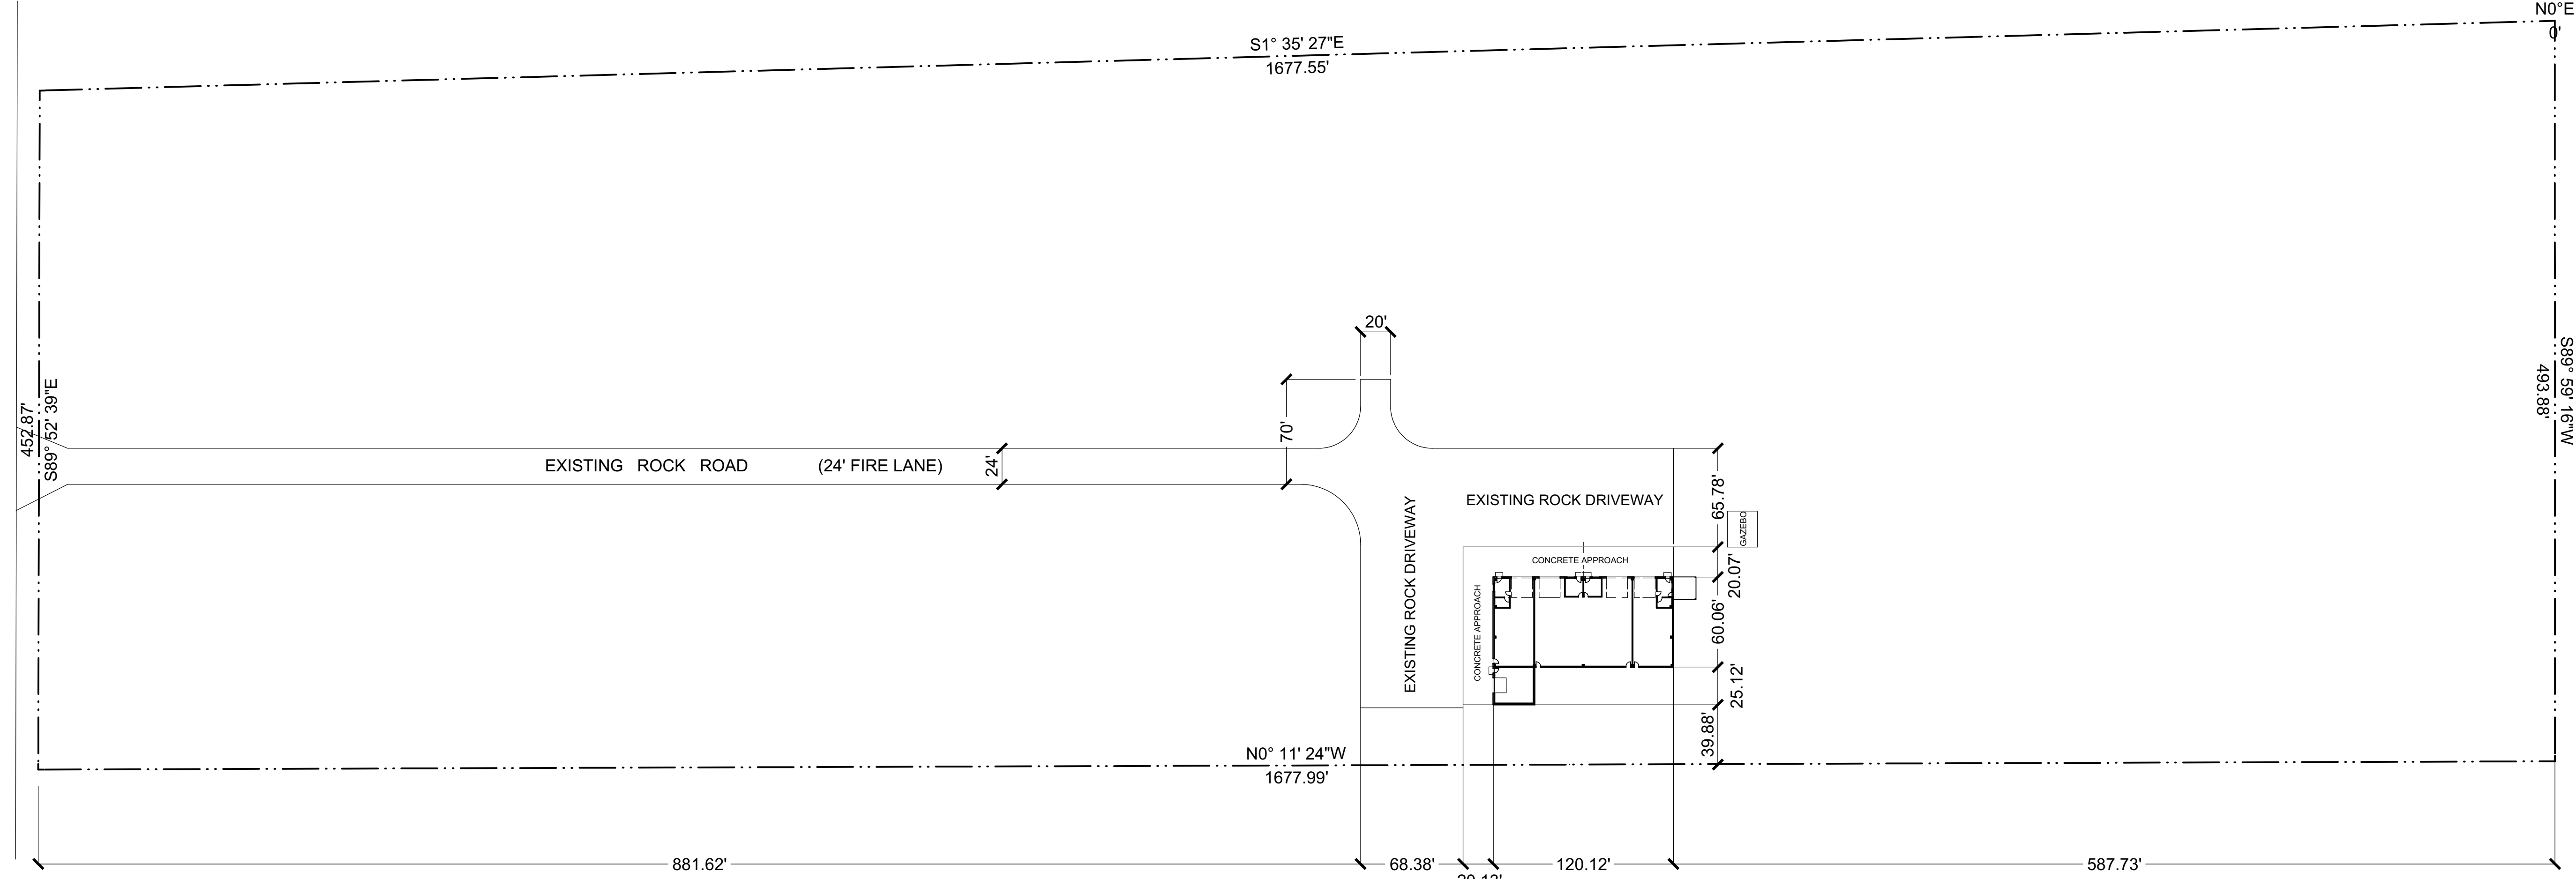

SITE PLAN
SCALE: 1" = 60'-0"

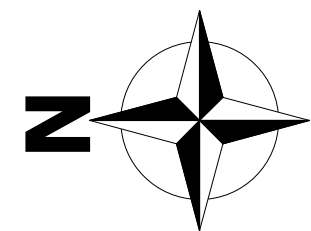

REVISION TABLE

NUMBER	DATE	REVISED BY	DESCRIPTION

PROJECT DESCRIPTION:

A New Remodel/Addition for
PANDU PALWAY
Wible Road
Sherman, Texas

DRAWINGS PROVIDED BY:

NBS DRAFTING AND DESIGN
303 W. HOUSTON
SHERMAN, TEXAS 75090
903.892.5620

DATE:

4/11/2025

SCALE:

SHEET:

A-6