


SITE PLANNING TRACT 8 OF THE STAMEY/ATKINS AREA GENERAL PLAN CHAMPAIGN, ILLINOIS

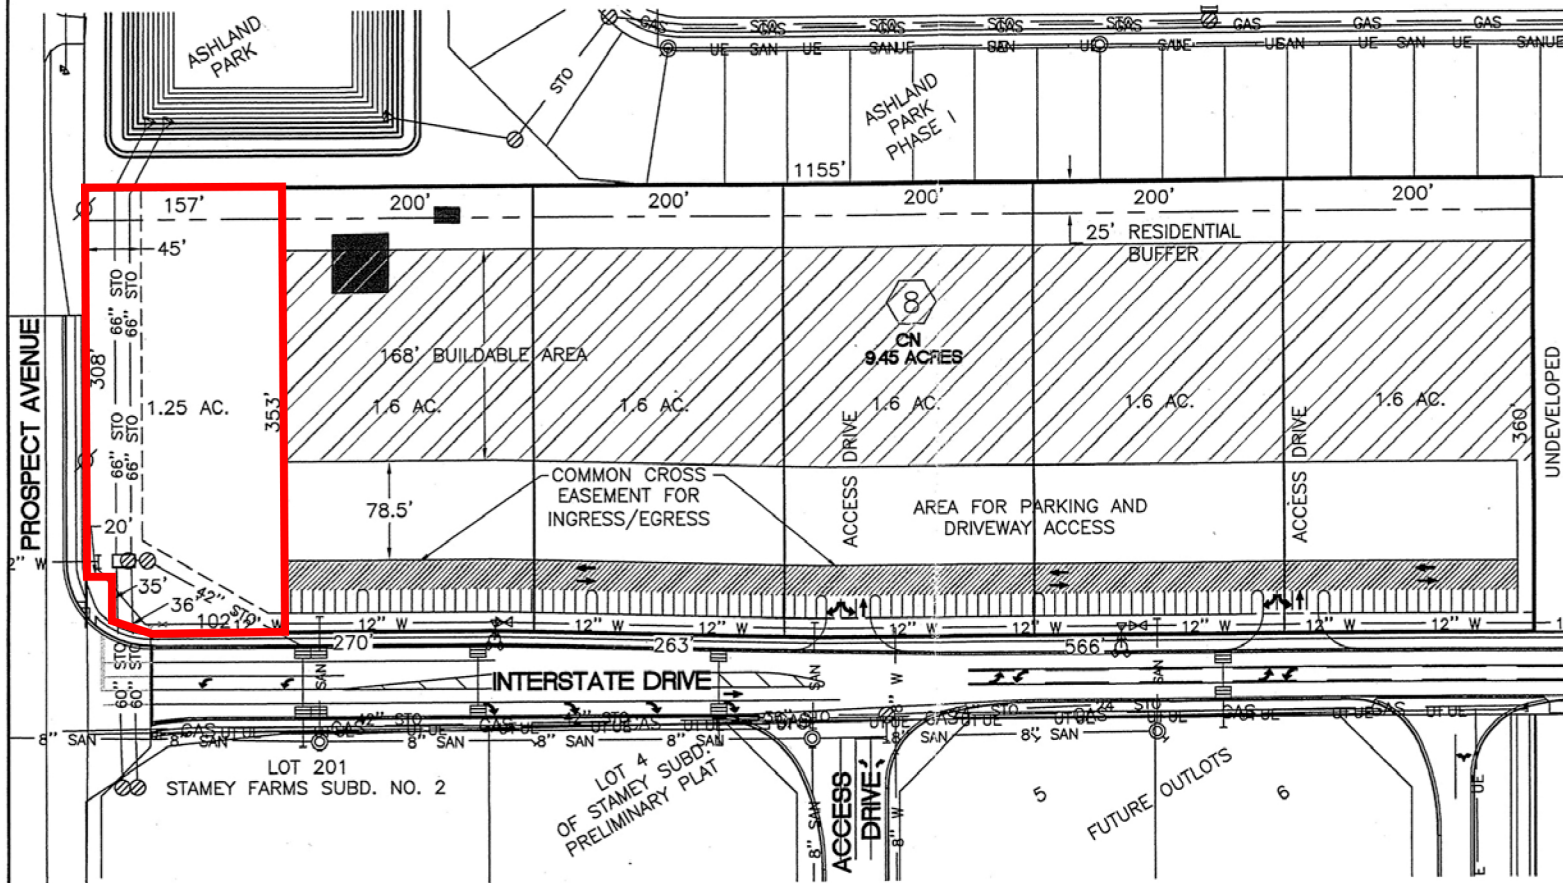

0 25' 50' 100'



LEGEND

- ⊙ SANITARY MANHOLE
- ⊗ STORM MANHOLE
- ≡ STORM INLET
- ▼ FLARED END SECTION
- ⊕ FIRE HYDRANT
- ⊗ WATER VALVE
- TRACT BOUNDARY
- GAS — GAS LINE
- SAN — SANITARY LINE
- STO — STORM LINE
- W — WATER LINE

Job # 05449
 Drawn By: ALP/ENC Date: 9/5/07 Revised: 9/11/07
HDC
 ENGINEERING
 Professional Design Firm License No. 184-003223
 Expires: 4/30/2009
 201 West Springfield, Suite 300,
 Champaign, Illinois 61824-0140
 Phone No. 217-352-6976

R:\2005\05449\05449\tract8.dwg, TRACT 8, 2/21/2008 3:42:09 PM, ENC