


Warehouse and Office Space



Remove walls, Add	REF:	PROJECT:
B		91 - 064 Kaomi
		Existing Fabric
		Plot Plan with I
		DATE: 11-27-15
		SCALE:

**Kila Construction, Inc.**  
A woman owned corporation

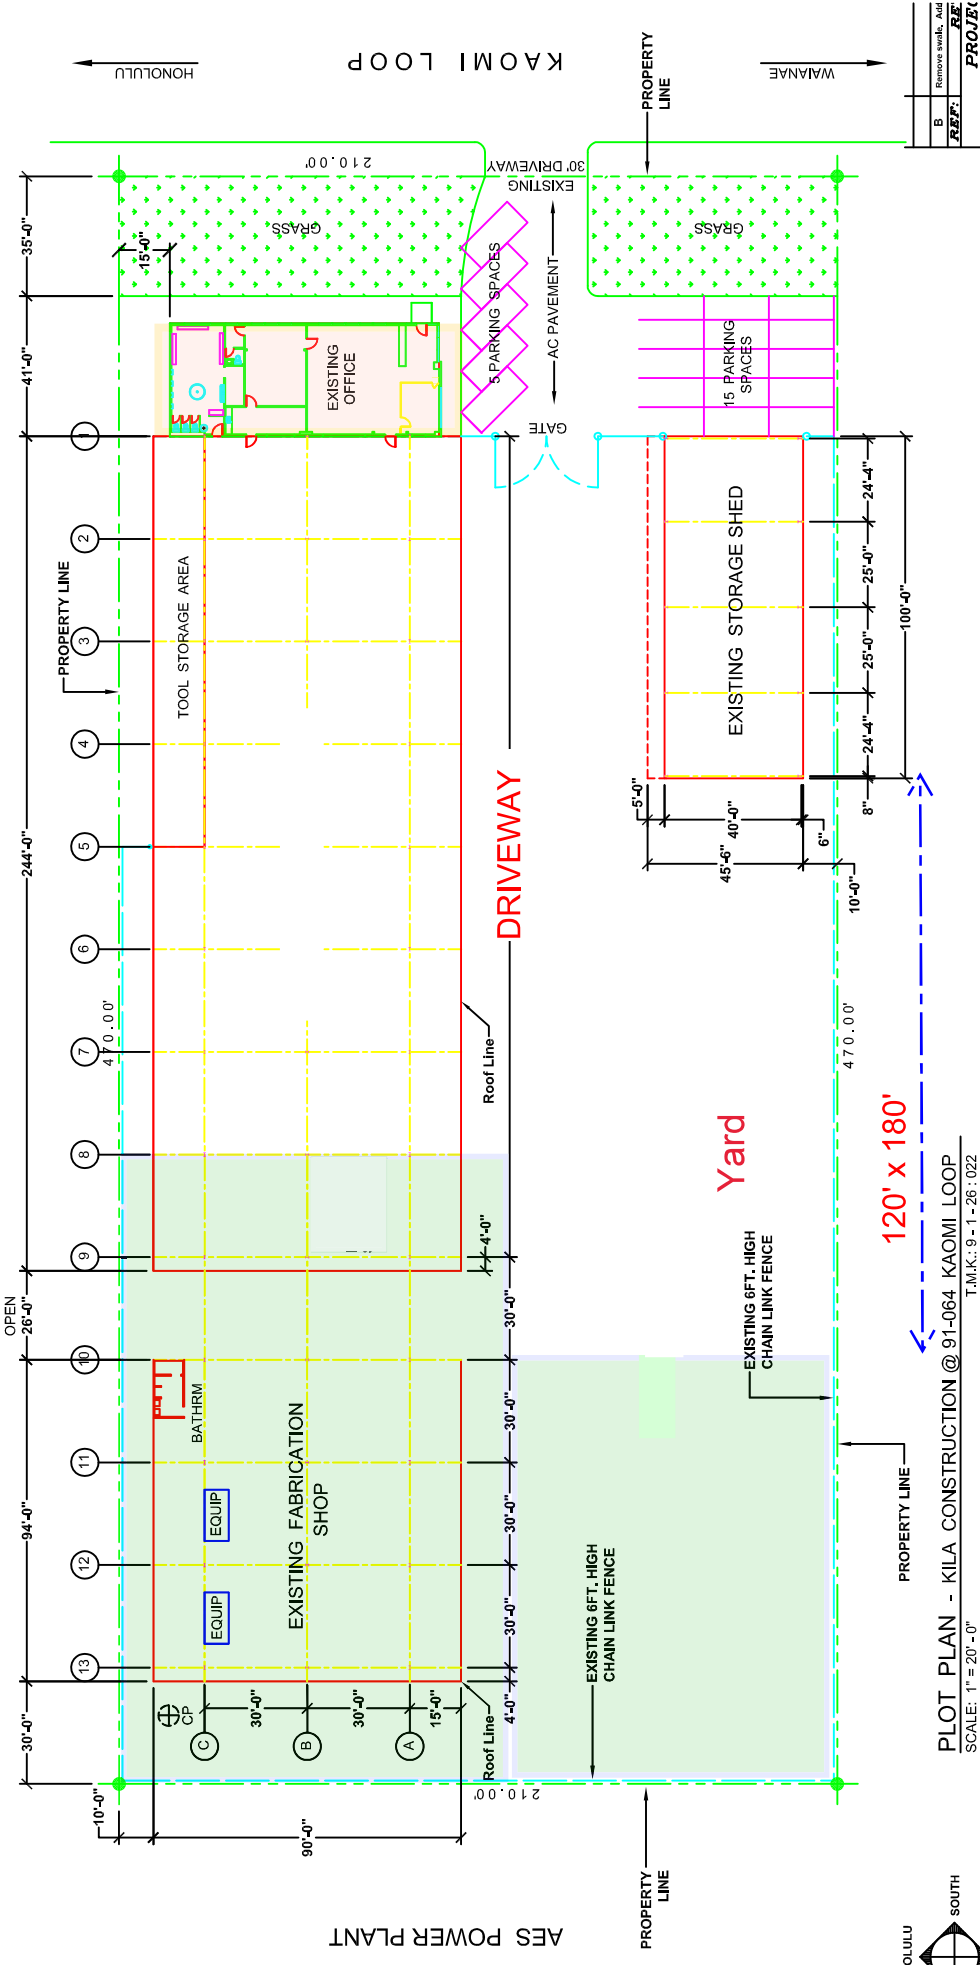


PLOT PLAN - KILA CONSTRUCTION @ 91-064 KAOMI LOOP  
SCALE: 1" = 20'-0"  
T.M.K.: 9-1-26:022

120' x 180'

DRIVEWAY

Yard

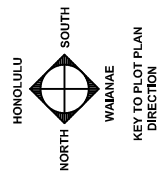

AES POWER PLANT

HONOLULU KAOMI LOOP

PROPERTY LINE WAIANA

PROPERTY LINE

PROPERTY LINE

PROPERTY LINE

EXISTING 6FT. HIGH CHAIN LINK FENCE

EXISTING 6FT. HIGH CHAIN LINK FENCE

210.00

10'-0"

30'-0"

94'-0"

OPEN 26'-0"

244'-0"

41'-0"

35'-0"

15'-0"

210.00

30'-0"

30'-0"

30'-0"

30'-0"

4'-0"

4'-0"

4'-0"

30' DRIVEWAY

30'-0"

30'-0"

30'-0"

30'-0"

25'-0"

25'-0"

24'-4"

24'-4"

10'-0"

8"

6"

45'-6"

40'-0"

5'-0"

100'-0"

EXISTING OFFICE

TOOL STORAGE AREA

EXISTING STORAGE SHED

EXISTING OFFICE

EXISTING OFFICE

EXISTING OFFICE

EXISTING OFFICE

EXISTING OFFICE

EXISTING OFFICE