


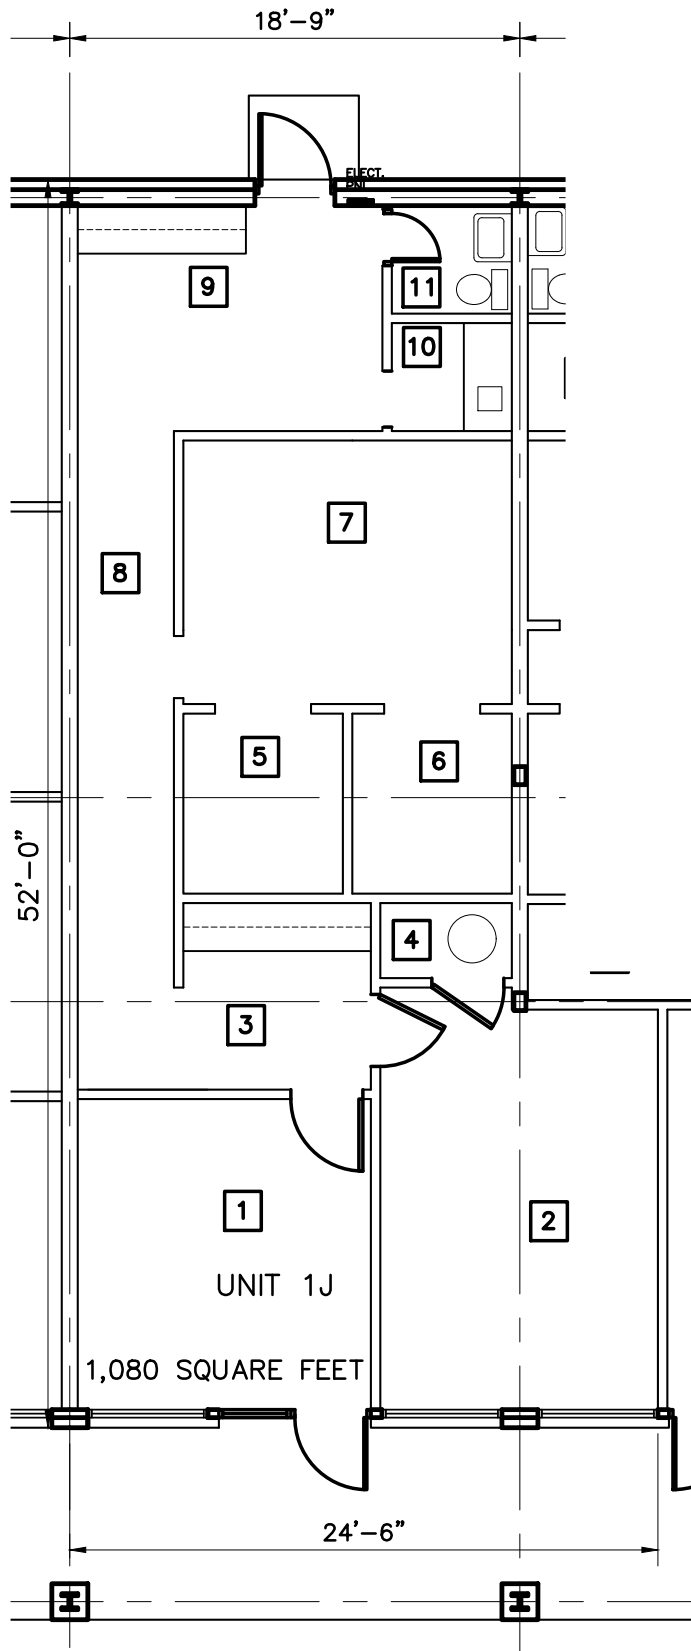

1  
A01/A01

# 1-J FLOOR PLAN

19-3002 HEARST PLAZA BASE.dwg

18'-9"

project no. 3002  
drawn EGA  
checked CEM  
date 09.12.2022  
revised



**Meyer Engineers, Ltd.**

4937 Hearst Street . Suite 1B . Metairie, Louisiana 70001  
2031 Claiborne Street . Mandeville, Louisiana 70448  
phone.504.885.9892 . fax.504.887.5056  
website.www.meyer-e-l.com

1-J FLOOR PLAN

UNIT 1-J  
HEARST PLAZA

sheet no.

**A01**

of 1 sheets