


# APRILE ASSOCIATES, L.P. AAIR OFFICE SPACE

2 RYAN DRIVE, GENESEO, NEW YORK 14454

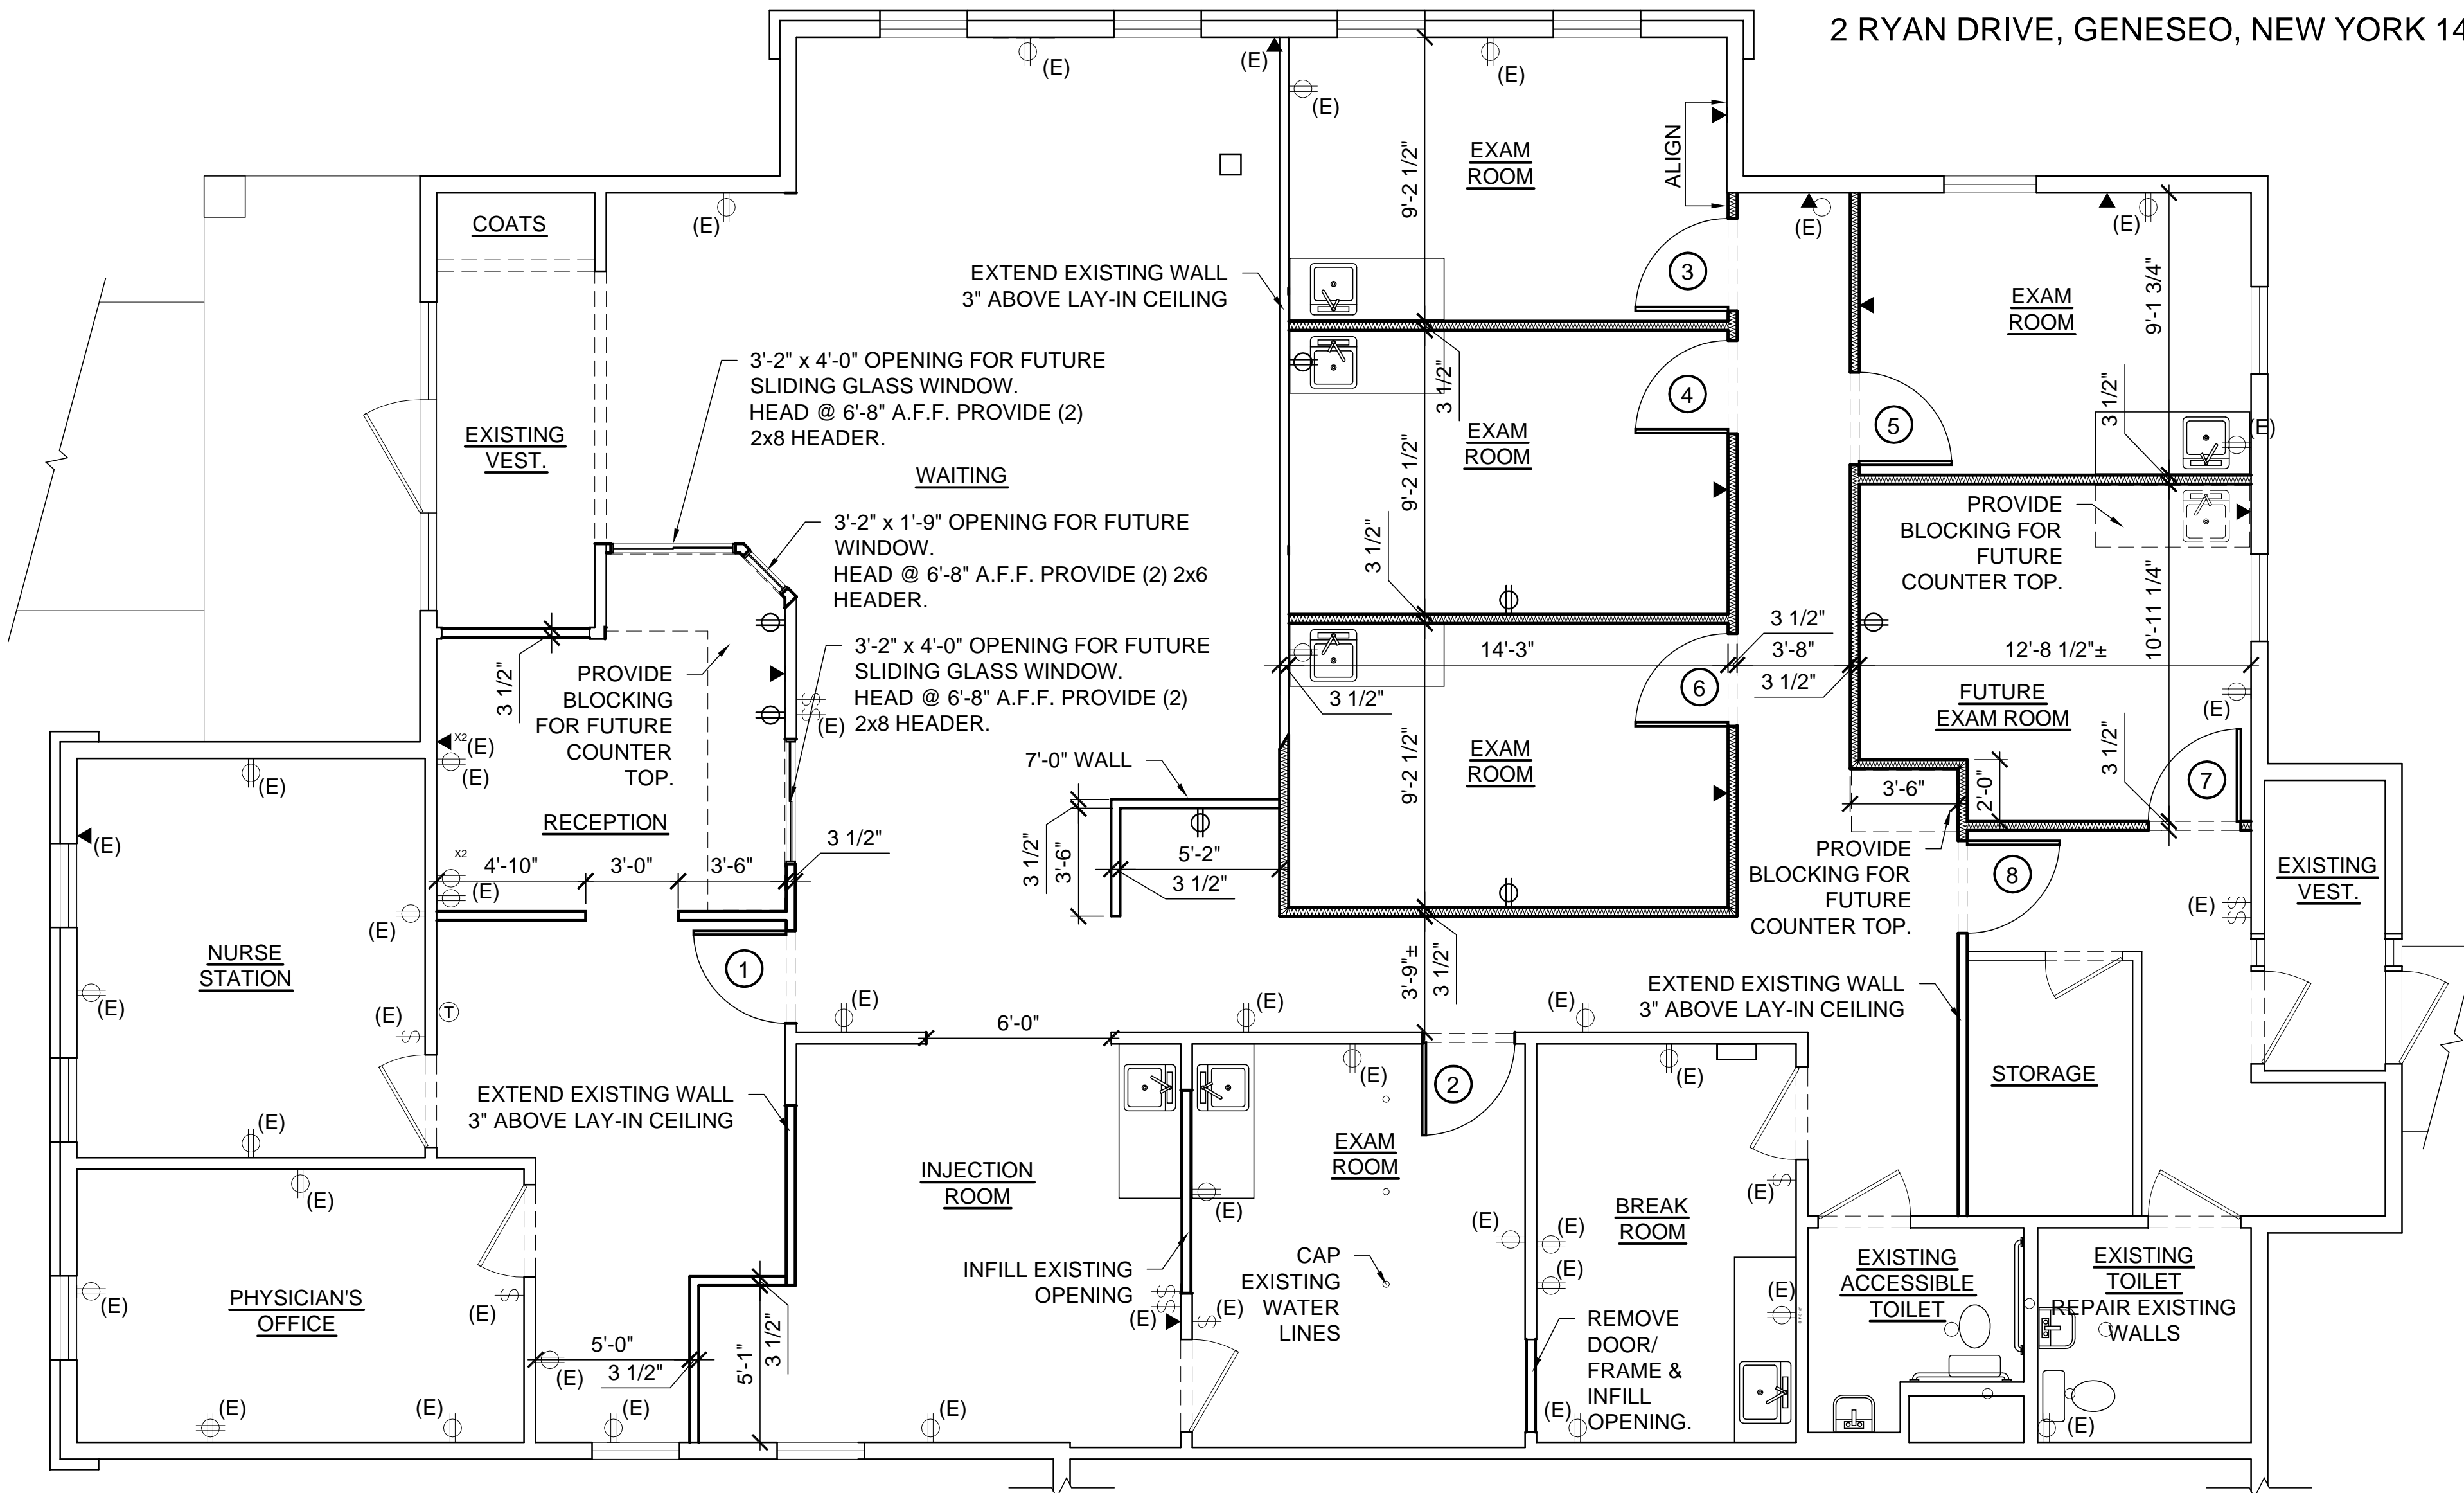


## FLOOR PLAN


SCALE: 1/4" = 1'-0"

### GENERAL NOTES:

1. VERIFY IN FIELD EXISTING DIMENSIONS & CONDITIONS.
2. ADJUST DIMENSIONS MARKED ±.
3. ALL GLAZING BY OTHERS.
4. ALL NEW DOORS TO BE 3'-0" x 6'-8" (OWNER SELECT)
5. PROVIDE (1) DIFFUSER & (1) LIGHT PER EXAM ROOM.

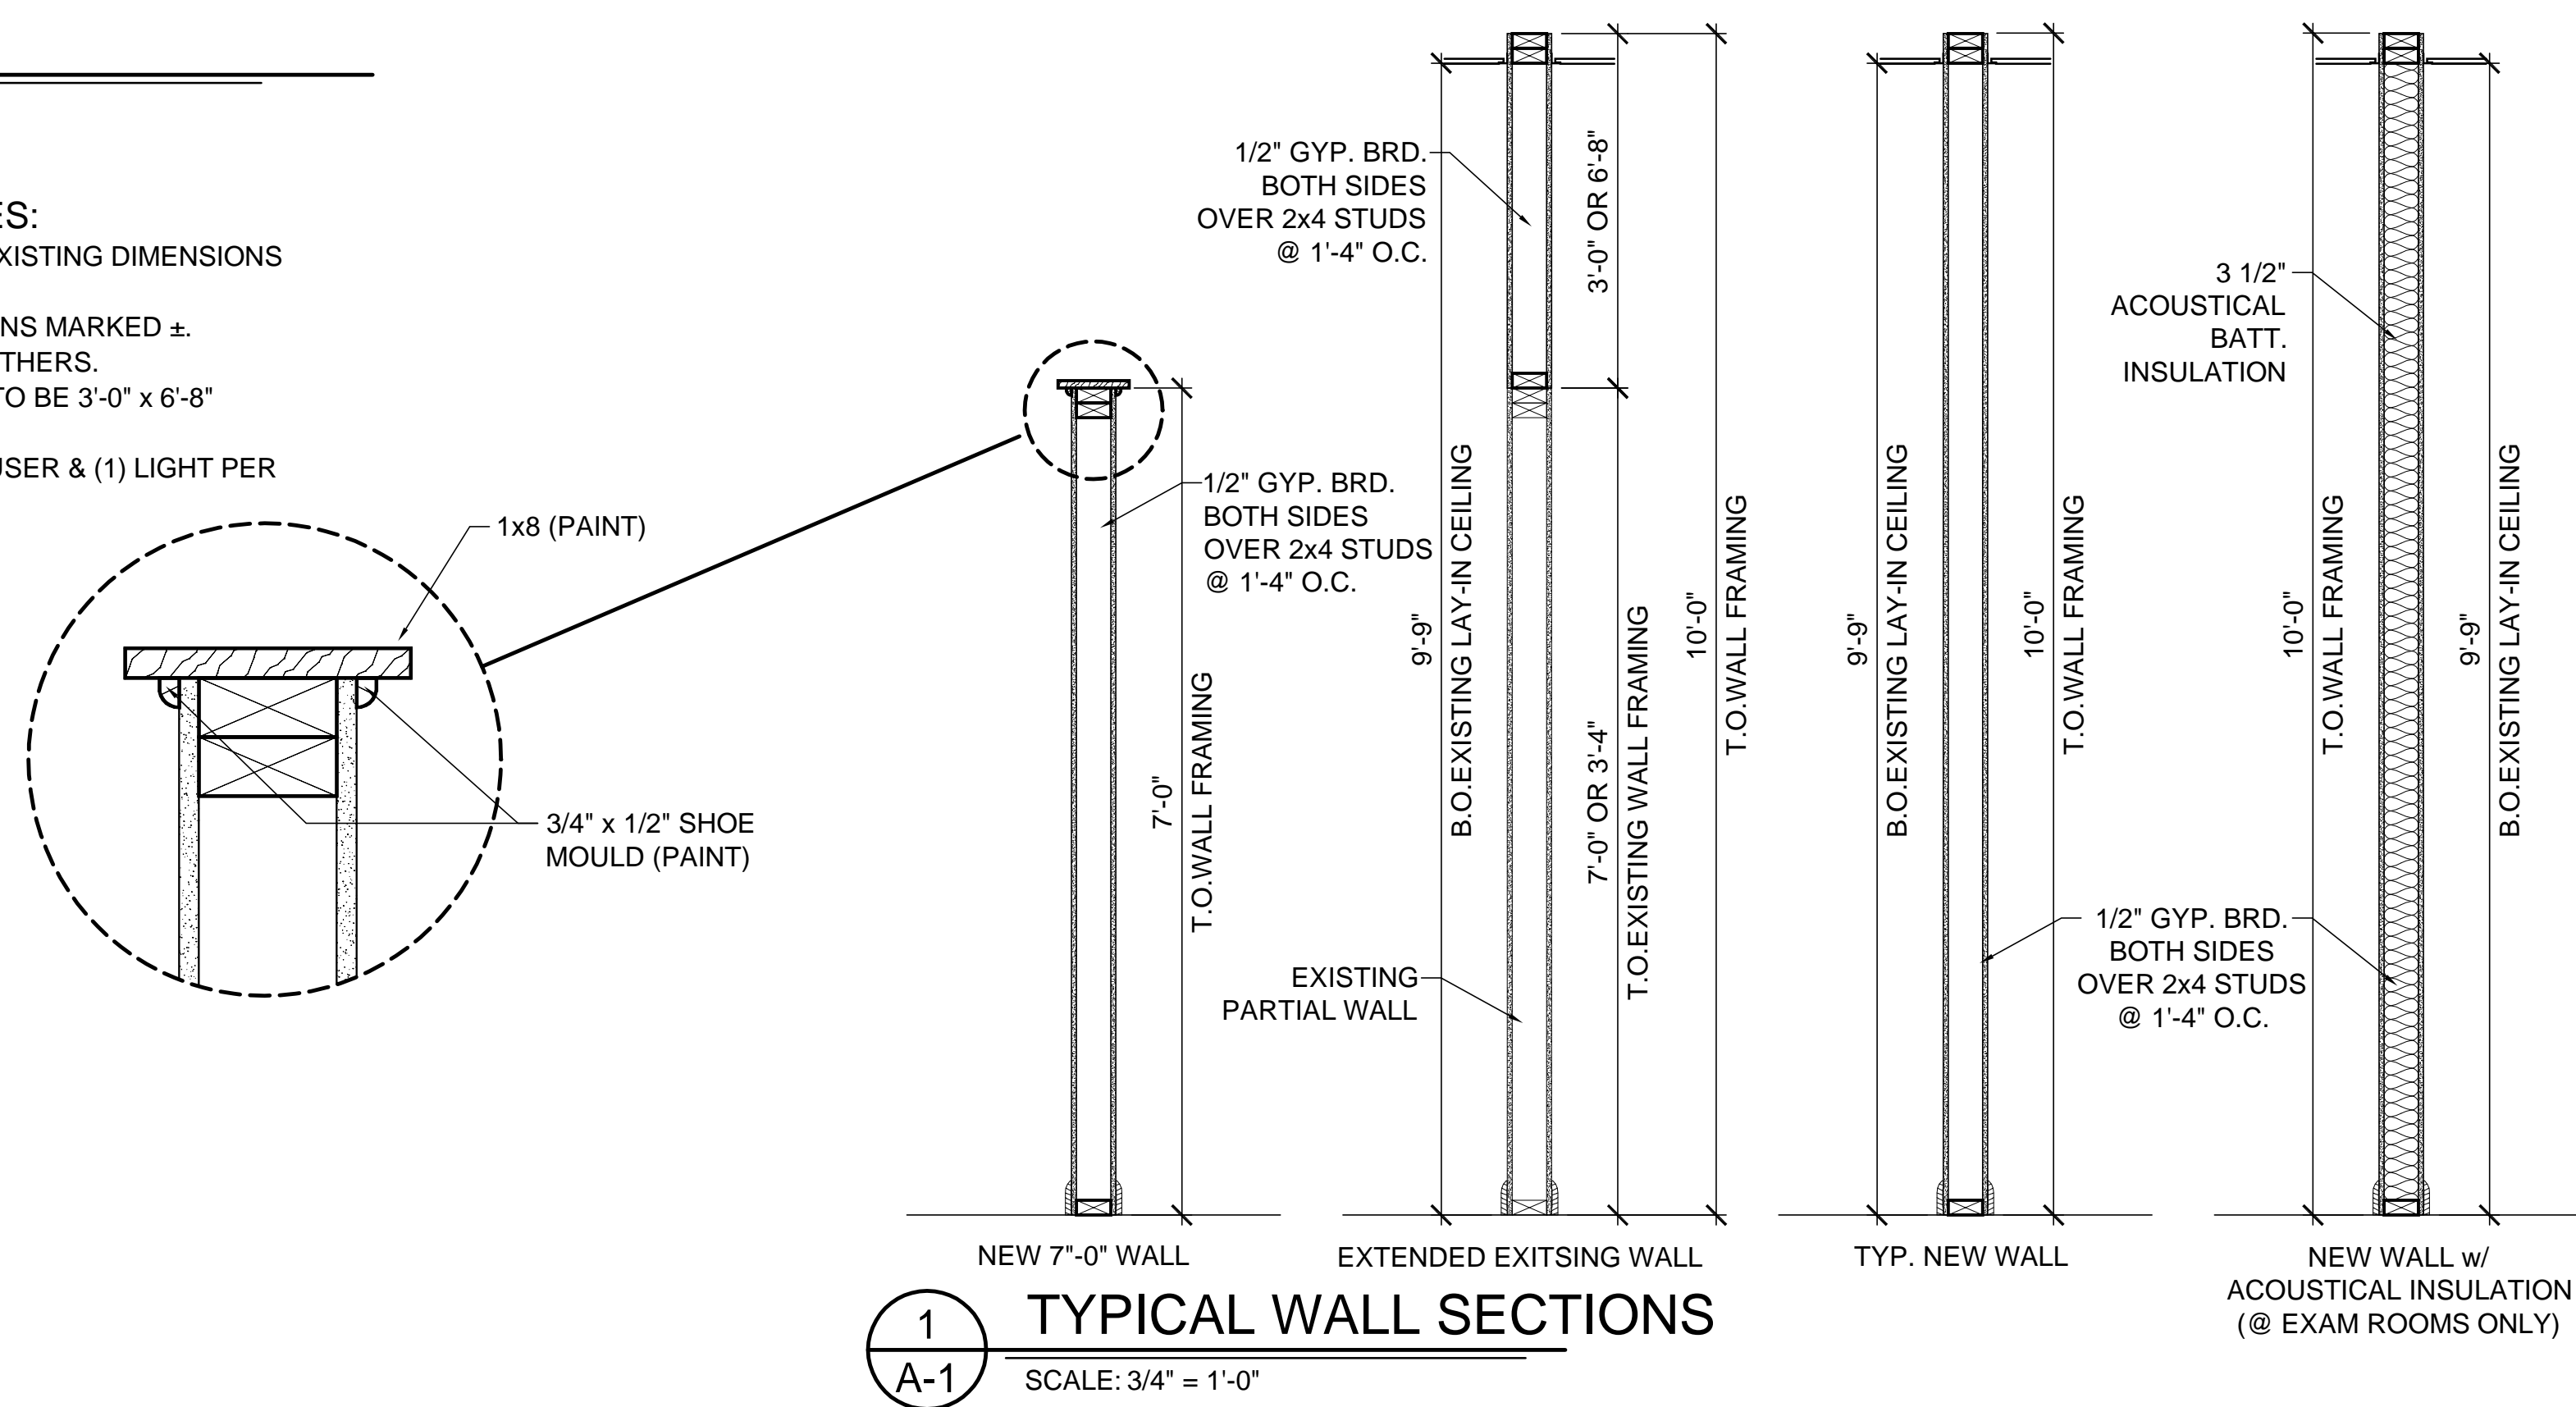

**1**  
**A-1** TYPICAL WALL SECTIONS  
SCALE: 3/4" = 1'-0"

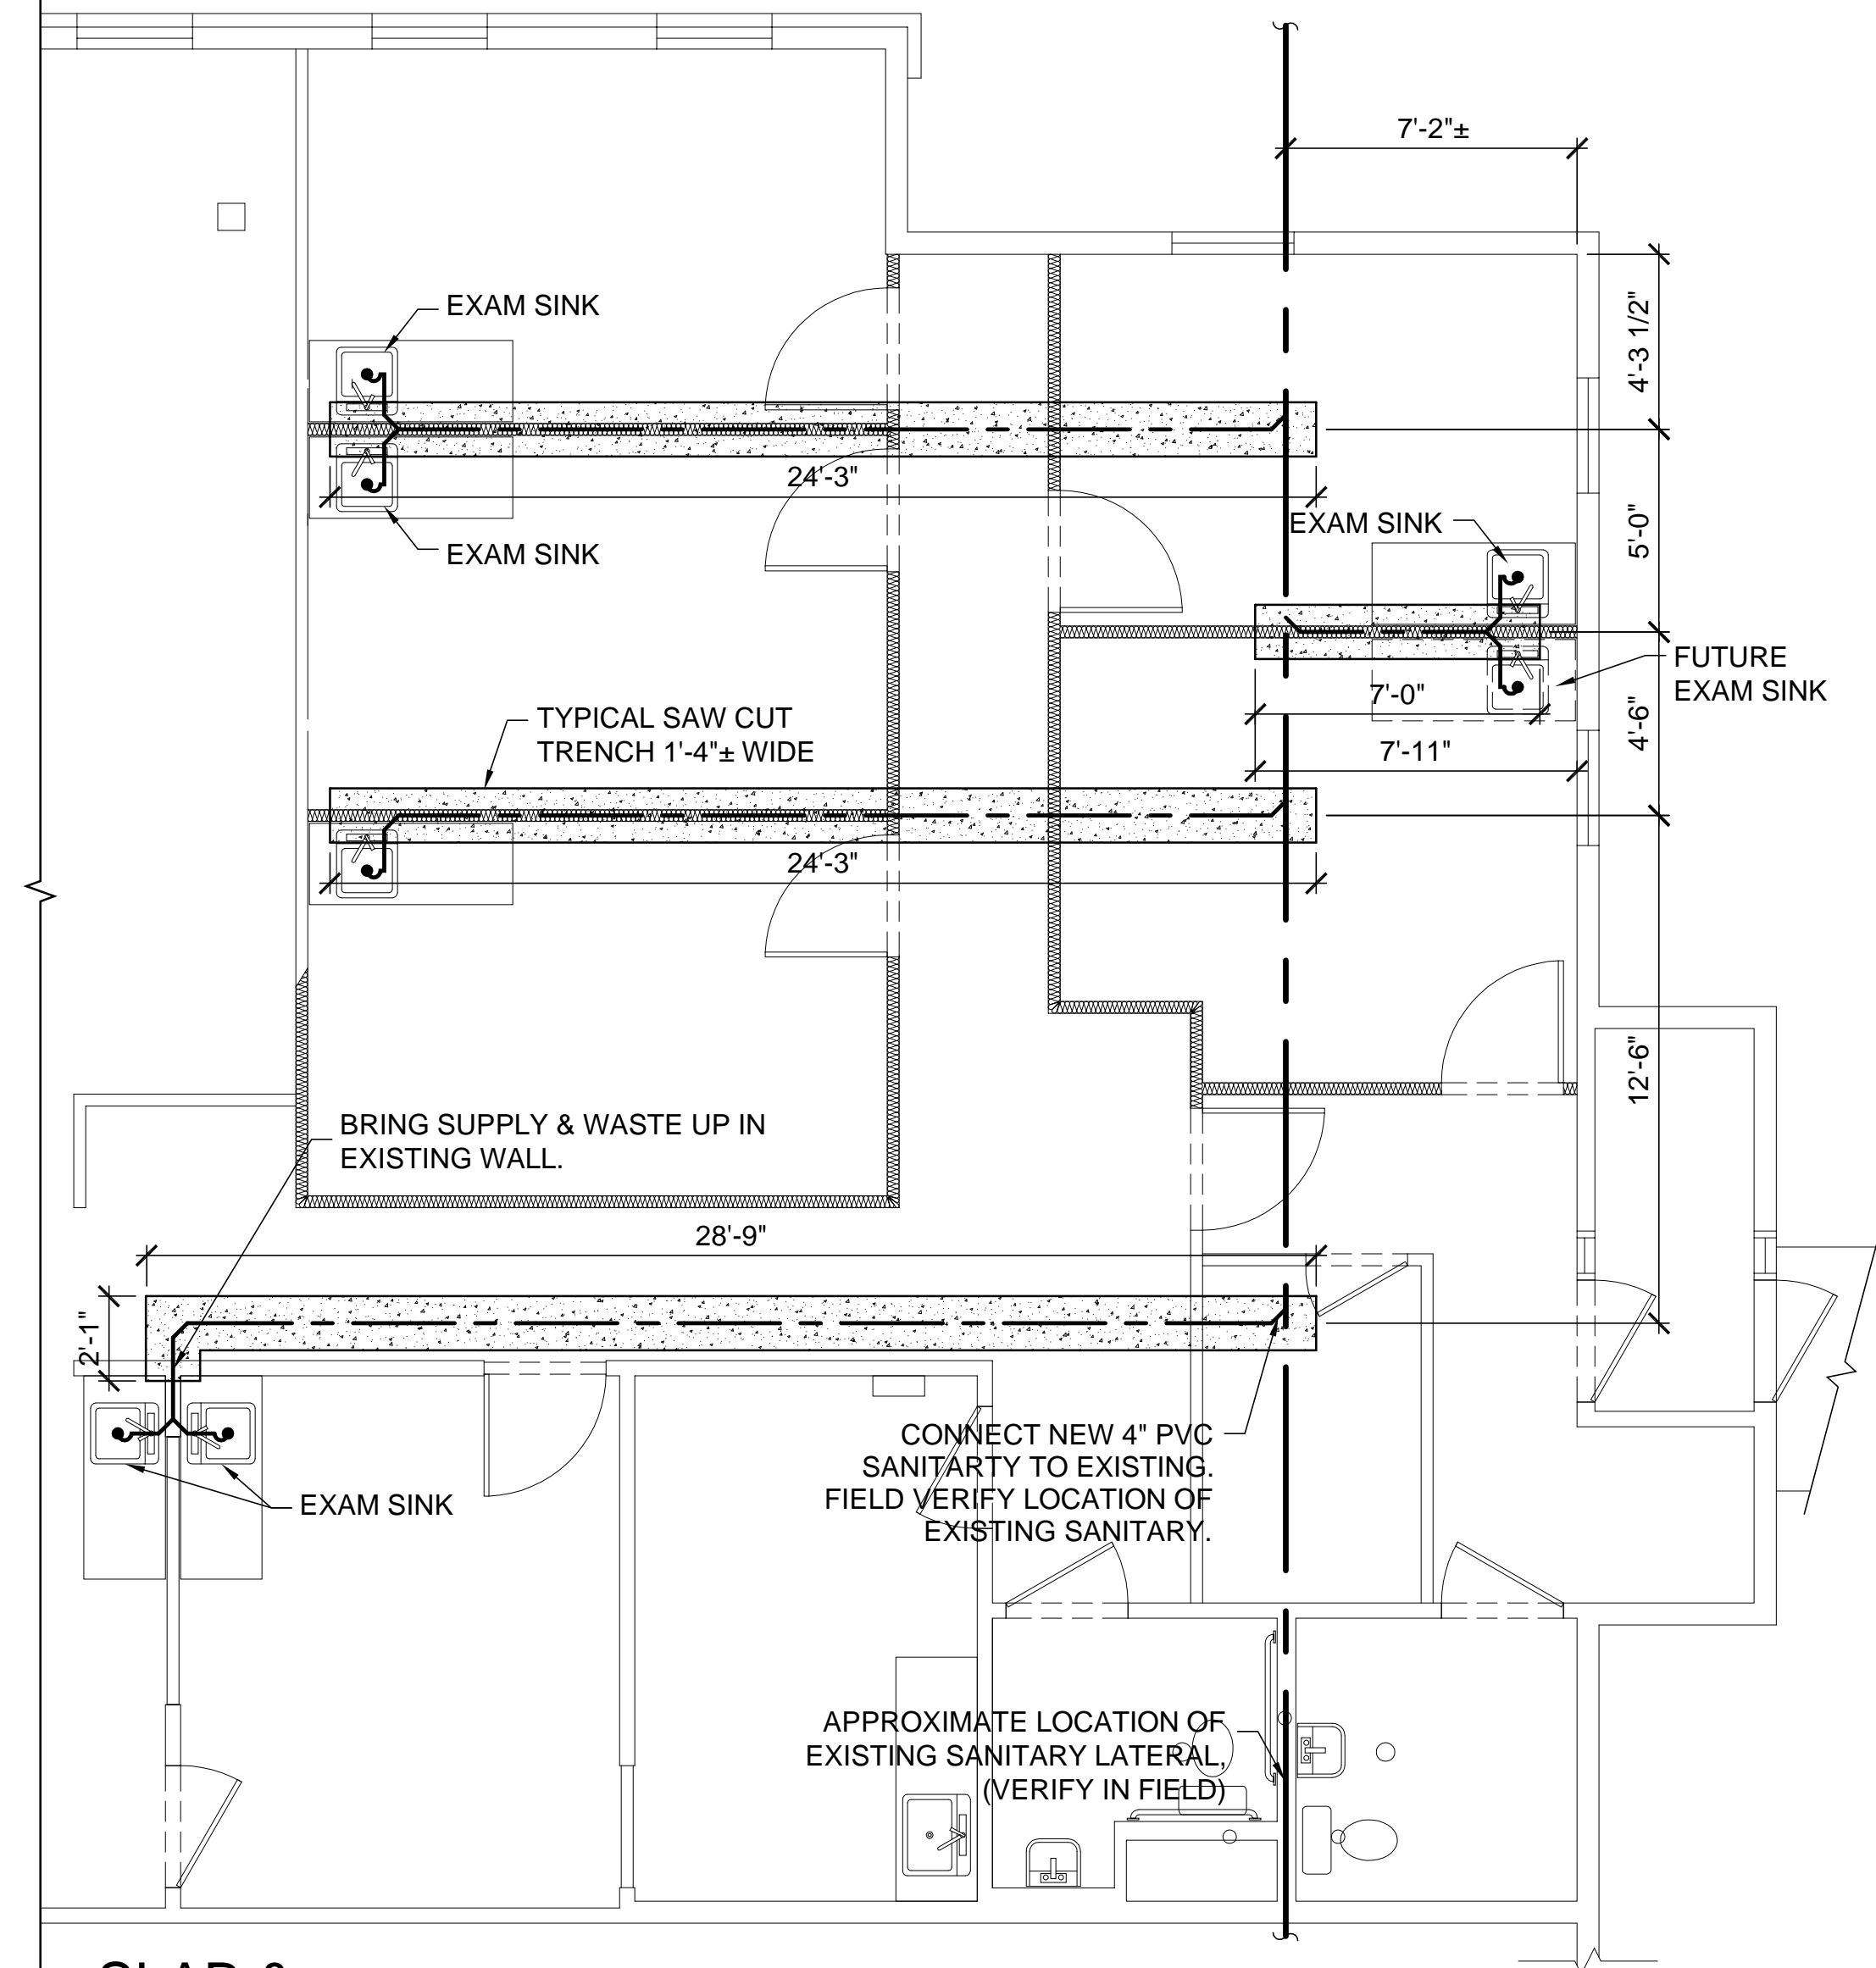


## SLAB & PLUMBING PLAN

SCALE: 1/4" = 1'-0"

APRILE ASSOCIATES, L.P.  
AAIR OFFICE SPACE

2 RYAN DRIVE  
GENESEO, NEW YORK 14454

T.A.B. DESIGN  
ARCHITECTS

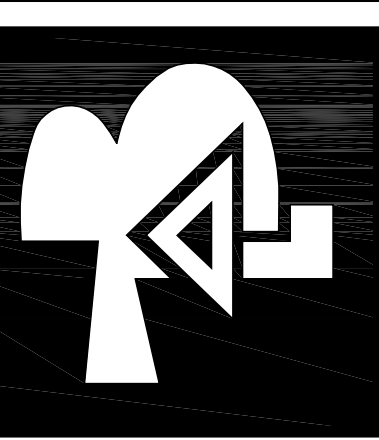

APRILE ASSOCIATES, L.P.  
AAIR OFFICE SPACE

FLOOR PLAN  
FILE: 1503  
DRAWN: AJH  
DESIGNED: TAB  
DATE: 02/13/2015

A-1