


The emergency power system shall provide power for a duration of not less than 90 minutes and shall consist of storage batteries, unit equipment or an on-site generator. The installation of the emergency power system shall be in accordance with Chapter 27.

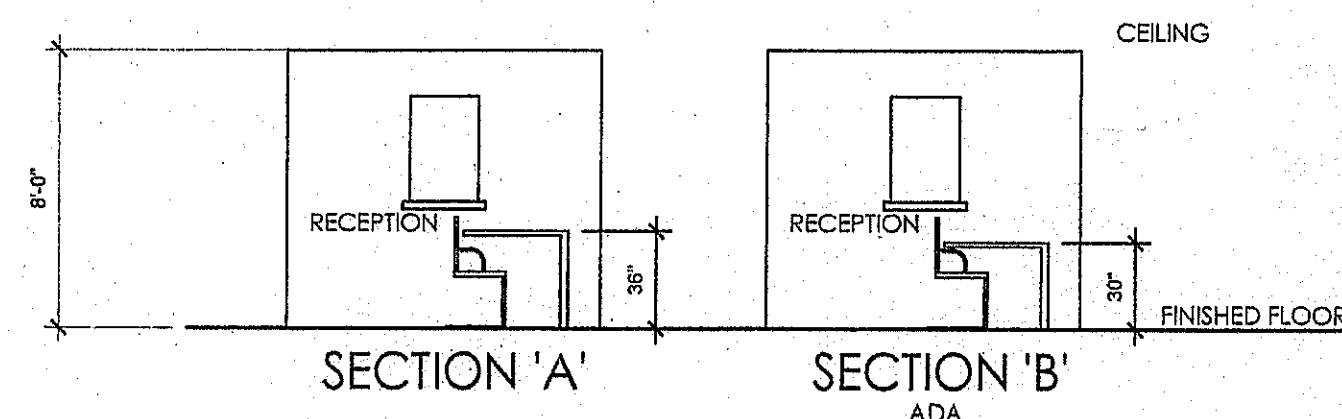

ROOM FINISH SCHEDULE								DOOR SCHEDULE:		WALL LEGEND:	
RM NO.	ROOM NAME	CEILING HEIGHT	FLOOR	BASE/WAINSCOT	WALLS	CEILING	REMARKS				
			SEALED CONCRETE CARPET	WOOD LAMINAT 12" SOL. STONE TILE 6" RUBBER CORED BASE 3/8" RADIUS 15" QUARRY TILE 4" WOOD BASE	STAINLESS STEEL ONE BASE 12" CERAMIC COVED BASE 3/8" RADIUS 15" RUBBER CORED BASE 3/8" RADIUS 4" STONE BASE 6" QUARRY ONE BASE 3/8" RADIUS	STAINLESS STEEL 5/8" GYP. BOARD (LIGHT COLOR) 9" GYP. BOARD- INSURABLE PAINT CERAMIC TILE 6" FLESHED HOOD SMOOTH TILE/TRP WAINSCOT 48" HT. PAINTED BLOCK WALL METAL / 4" INSULATION CORE EXPOSED FRAMING 5/8" GYP. BOARD (SMOOTH WHITE) ACUSTICAL T-BAR (SMOOTH WHITE) CORRUGATED METAL M.F. GYP. BOARD METAL / 4" INSULATION CORE EXPOSED WOOD PAINTED	FOR KITCHEN, RESTROOMS & JANITORS 1. 6" HT., 3/8" RADIUS, TOPSET BLUMFLOT CERAMIC BASE CORN. PRODUCT NO. 30619T 2. DRINKING B.C. AND WALLS TO BE PAINTED WITH ENAMEL PAINT (WHITE OR LIGHT COLOR) SHALL HAVE THE REFLECTIVE VALUE SHALL BE SMOOTH AND VISIBLE 3. SMOOTH, PAINTED CONCRETE FLOOR WITH SEALER : AMERSTONE 7101 4. VERY FLOOR DRAIN TO BE LOCATED IN	A) EXISTING 3'-0"x8'-0" ENTRY DOOR (SELF CLOSING)  NEW WALL B) NEW 3'-0" X 8'-0" TEMP WOOD / GLASS DOOR  EXISTING WALL C) NEW 6'-0" X 8'-0" TEMP WOOD / GLASS FRENCH DOOR  REMOVE WALL D) NEW 3'-0" X 8'-0" WOOD DOOR  1 HR. CORRIDOR PR SECTION 101B.1			
100	MAIN AREA / HALLS / CALL CENTER	13'-0" AFF.									
101	CONFERENCE ROOM	13'-0" AFF.									
102	BREAK ROOM	8'-0" AFF.									
103	OFFICE	13'-0" AFF.									
104	HANDICAP RESTROOMS	8'-0" AFF.									
105	EVAL. WAITING, GROOMING, READING	8'-0" AFF.									

KEY NOTES

 EMERGENCY LIGHT W/ BATTERY BACK-UP


 EXIT LIGHT W/ BATTERY BACK-UP

NOTE: ALL FLOURESCENT FIXTURES WITH DOUBLE ENDED LAMPS SHALL BE
EQUIPPED WITH DISCONNECT MEANS PER 410.73(G) CEC 2013

The emergency power system shall provide power for a duration of not less than 90 minutes and shall consist of storage batteries, unit equipment or an on-site generator. The installation of the emergency power system shall be in accordance with Chapter 27.

All fluorescent fixtures with double ended lamps shall be equipped with disconnect means per 410.73(G)

Return air plenums require non-combustible construction.

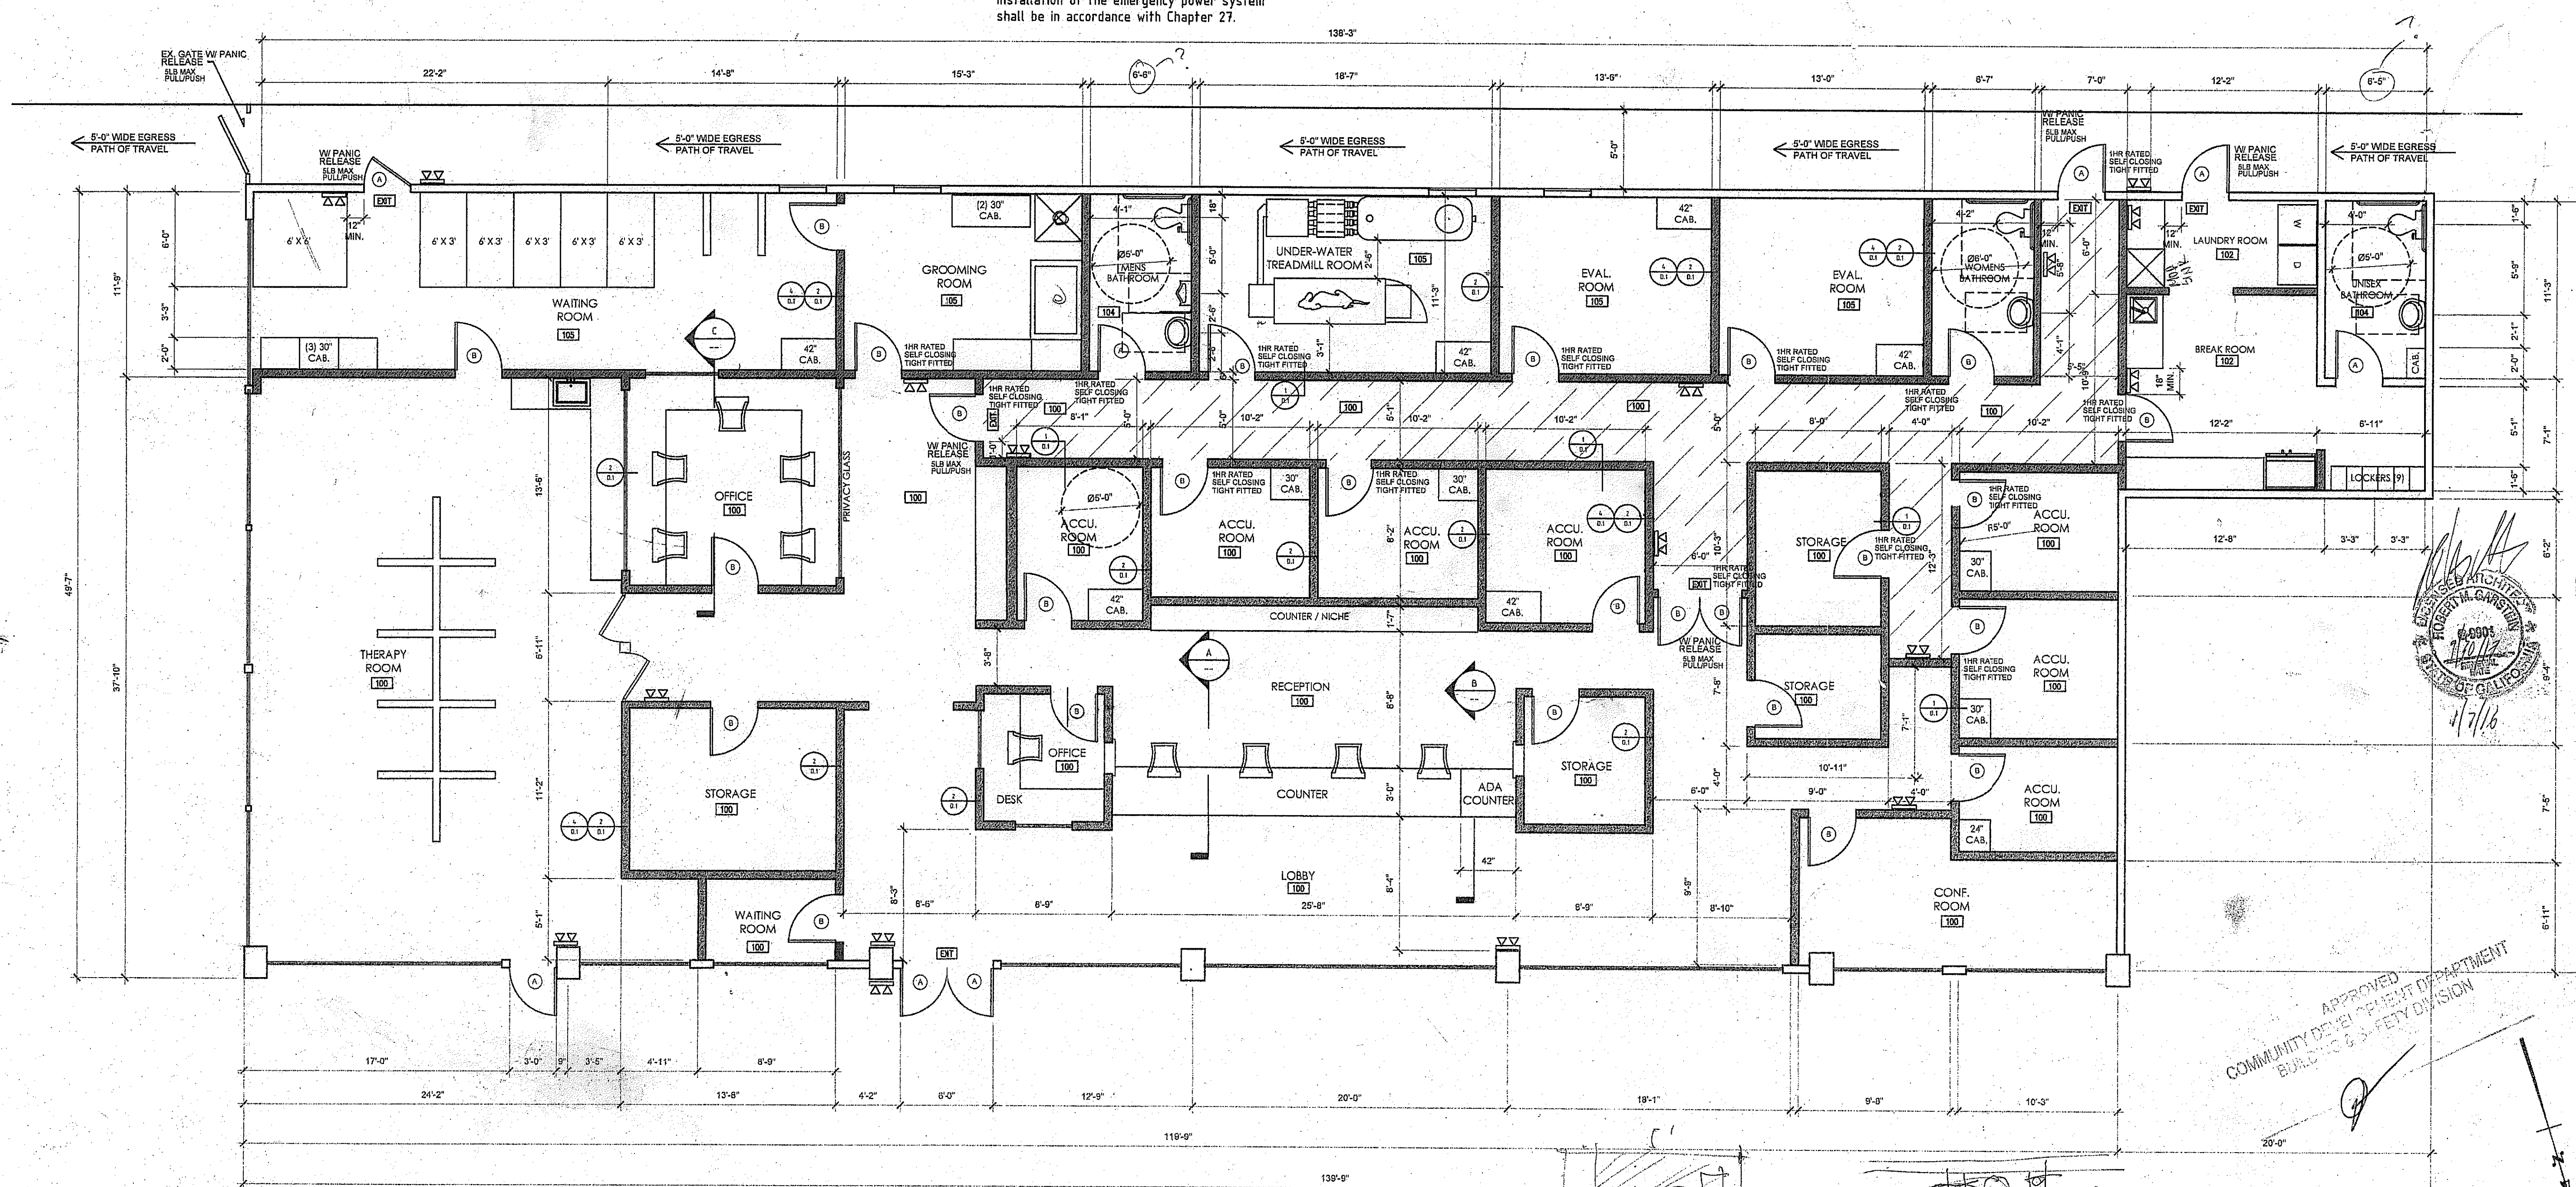

636 Cypress Avenue
Hermosa Beach, Ca. 90254

o 310.920.9995
e dg@dgaccociatesca.com
w dgaccociatesca.com

Amy Kramer

18837 Hawthorne Blvd
Torrance, Ca. 90505

BARC Academy

18837 Hawthorne Blvd.
Torrance, Ca. 90505

Atousa Yazdanfar
Energy Compliance Services
562.461.3749
www.title24services.com

AART ASSINK ASSOCIATES

1611 El Prado Avenue
Torrance, Ca. 90501
Phone (310) 618-0782

[illegible]

THESE DOCUMENTS ARE CONFIDENTIAL.
INCORPORATING PROPRIETARY RIGHTS. ALL PARTIES
ACCEPTING THESE DOCUMENTS AGREE THAT THEY
SHALL NOT BE DUPLICATED IN WHOLE OR PART, NOR
DISCLOSED TO OTHERS WITHOUT THE EXPRESS WRITTEN
CONSENT OF DG BUILDING DESIGN. WRITTEN
DIMENSIONS ON THESE DOCUMENTS TAKE PRECEDENCE
OVER SCALED DIMENSIONS. CONTRACTORS SHALL
VERIFY AND BE RESPONSIBLE FOR ALL DIMENSIONS AND
CONDITIONS ON THE JOB AND SHALL STOP WORK AND
NOTIFY THIS OFFICE IMMEDIATELY IF DISCREPANCIES
OCCUR. SHOP DRAWINGS SHALL BE SUBMITTED TO THE
OFFICE FOR REVIEW PRIOR TO FABRICATION.

DRAWN BY: D.GREGG

PROPOSED FLOOR PLAN

A.2

DATE: 06/12/15 SCALE: 3/16"=1'-0"