



Sanitary Sewer							
Inlet	Type	Top	Pipe Length	North	South	Inlet East	West
S-1	SMH						
S-2	SMH						
S-3	SMH						
S-4	SMH						
S-5	SMH						
S-6	SMH						
S-7	SMH						
S-8	SMH						
S-9	SMH						
S-10	SMH						
S-11	SMH						
S-12	SMH						
S-13	SMH						
S-14	SMH						

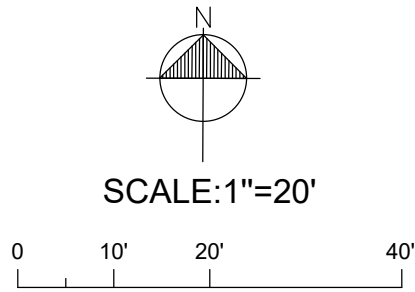

MATCH LINE B-B (SHEET C-3B)

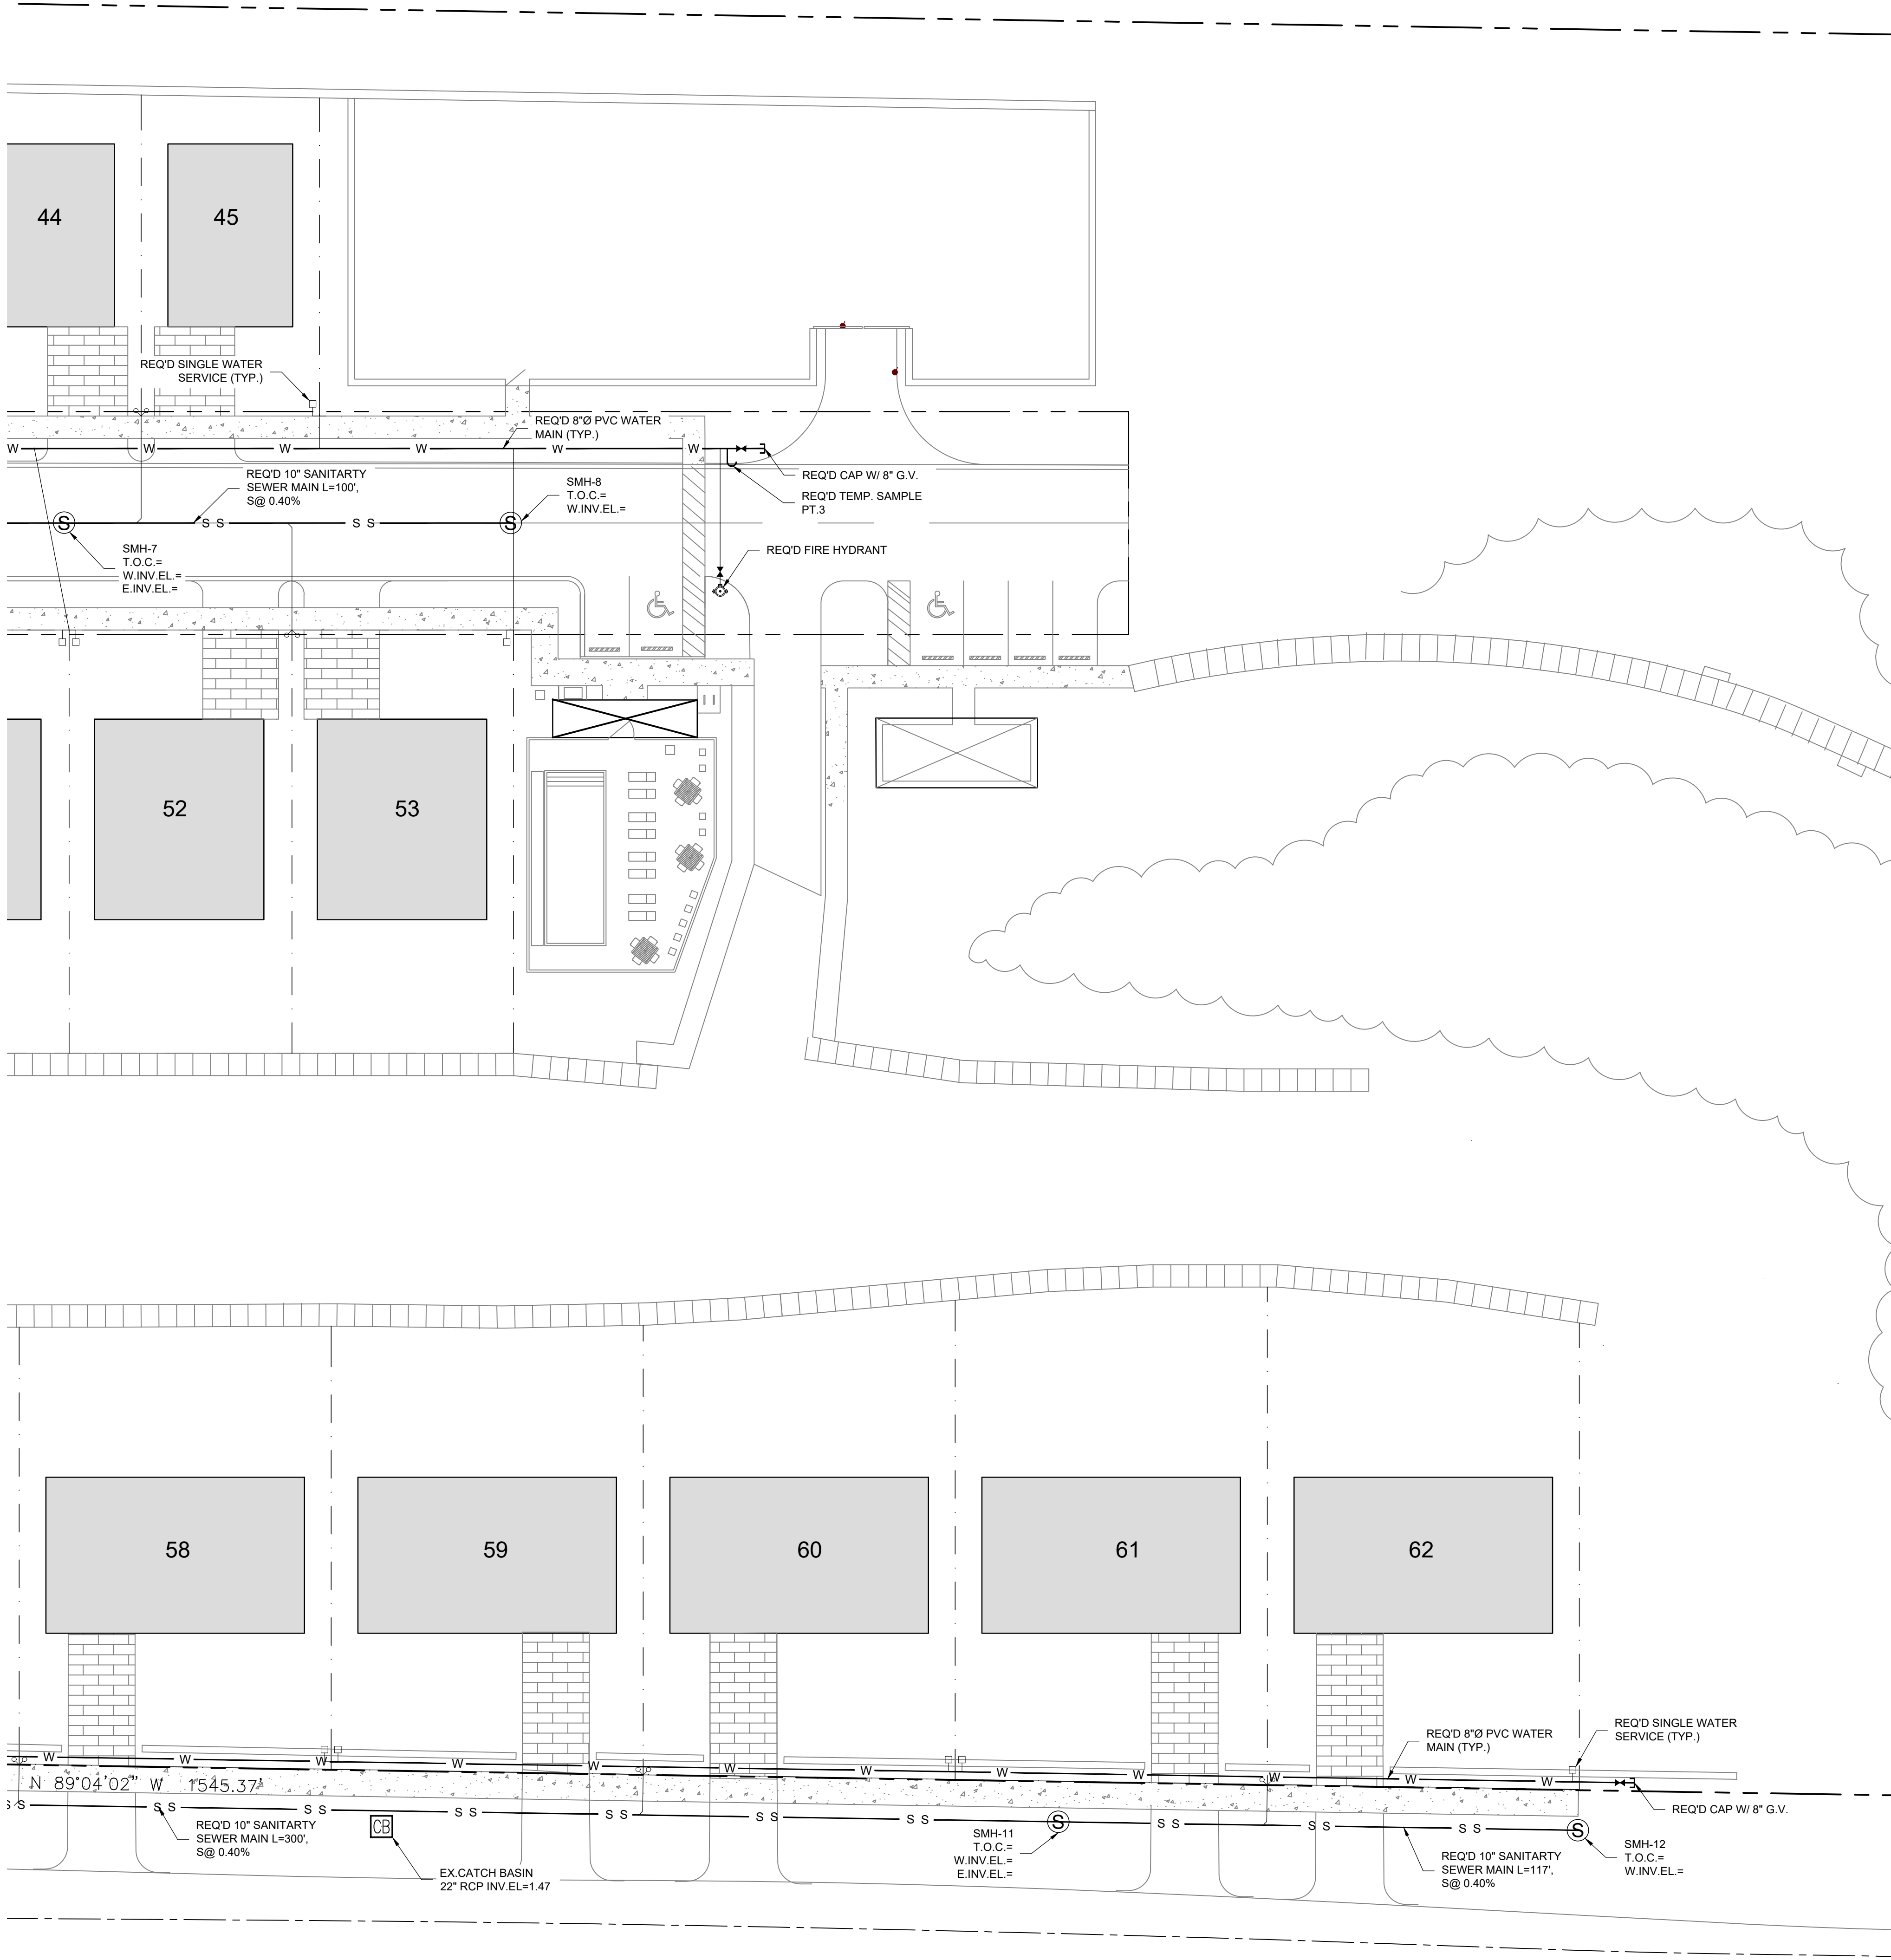

SANCTUARY COVE

250 ROUSE
FORT PIERCE, FL 34946

THIS SHEET
UTILITY PLAN

DRAWN BY
WBD

CHECKED BY
JWM

APPROVED BY
JWM

SCALE
SEE SHEET

SEE SHEET

ISSUE	DATE	COMMENTS

SEAL

Mills, Short & Associates

PHONE: 772.226.7282
C.A. #: 30698

WEBSITE:
www.MillsShortAssociates.com

700 22nd Place, Suite 202D
Vero Beach, Florida 32960

PROJ. NO.	21-XXXX
DATE	04-21-2023

SHEET NO.

C-3C