



**NOTE: DEVELOPER SHALL
BE RESPONSIBLE FOR
ANY CONFLICTS WITH
EXISTING UTILITIES.**

TEXT LEGEND

[illegible]

SEWER LEGEND

⑤ SANITARY SEWER MANHOLE

 CLEANOUT

—SS— SANITARY SEWER LINE

UTILITY NOTES

1. SANITARY SEWER SERVICE PROVIDER: CITY OF BUFORD.
2. SANITARY SEWER SERVICE LATERALS SHOULD BE NO LESS THAN 6" DIA PVC AND HAVE A MINIMUM SLOPE OF 1.0%.
3. ALL SANITARY SEWER SYSTEMS ARE DESIGNED AND SHALL BE INSTALLED IN ACCORDANCE WITH THE CITY'S DEVELOPMENT REGULATIONS AND WATER AND SEWER STANDARD SPECIFICATIONS.

SEWER ALLOCATION

SEWER ALLOCATION APPLICATION IS
CURRENTLY UNDER CITY OF BUFORD REVIEW.

PROPOSED USAGE


ANNUAL AVERAGE DAILY UNIT FLOW (GPD) = 175 GPD PER 1,000 SF + 25 GPD PER EMPLOYEE
 $(13,500 \text{ SF} / 1,000 \text{ SF}) * 175 \text{ GPD} + (25 \text{ GPD} * 45 \text{ EMPLOYEES}) \sim 3,500 \text{ GPD}$

PROFILE LEGEND



EXISTING GRADE — — — — —

PROPOSED GRADE _____

PROFILE VIEW

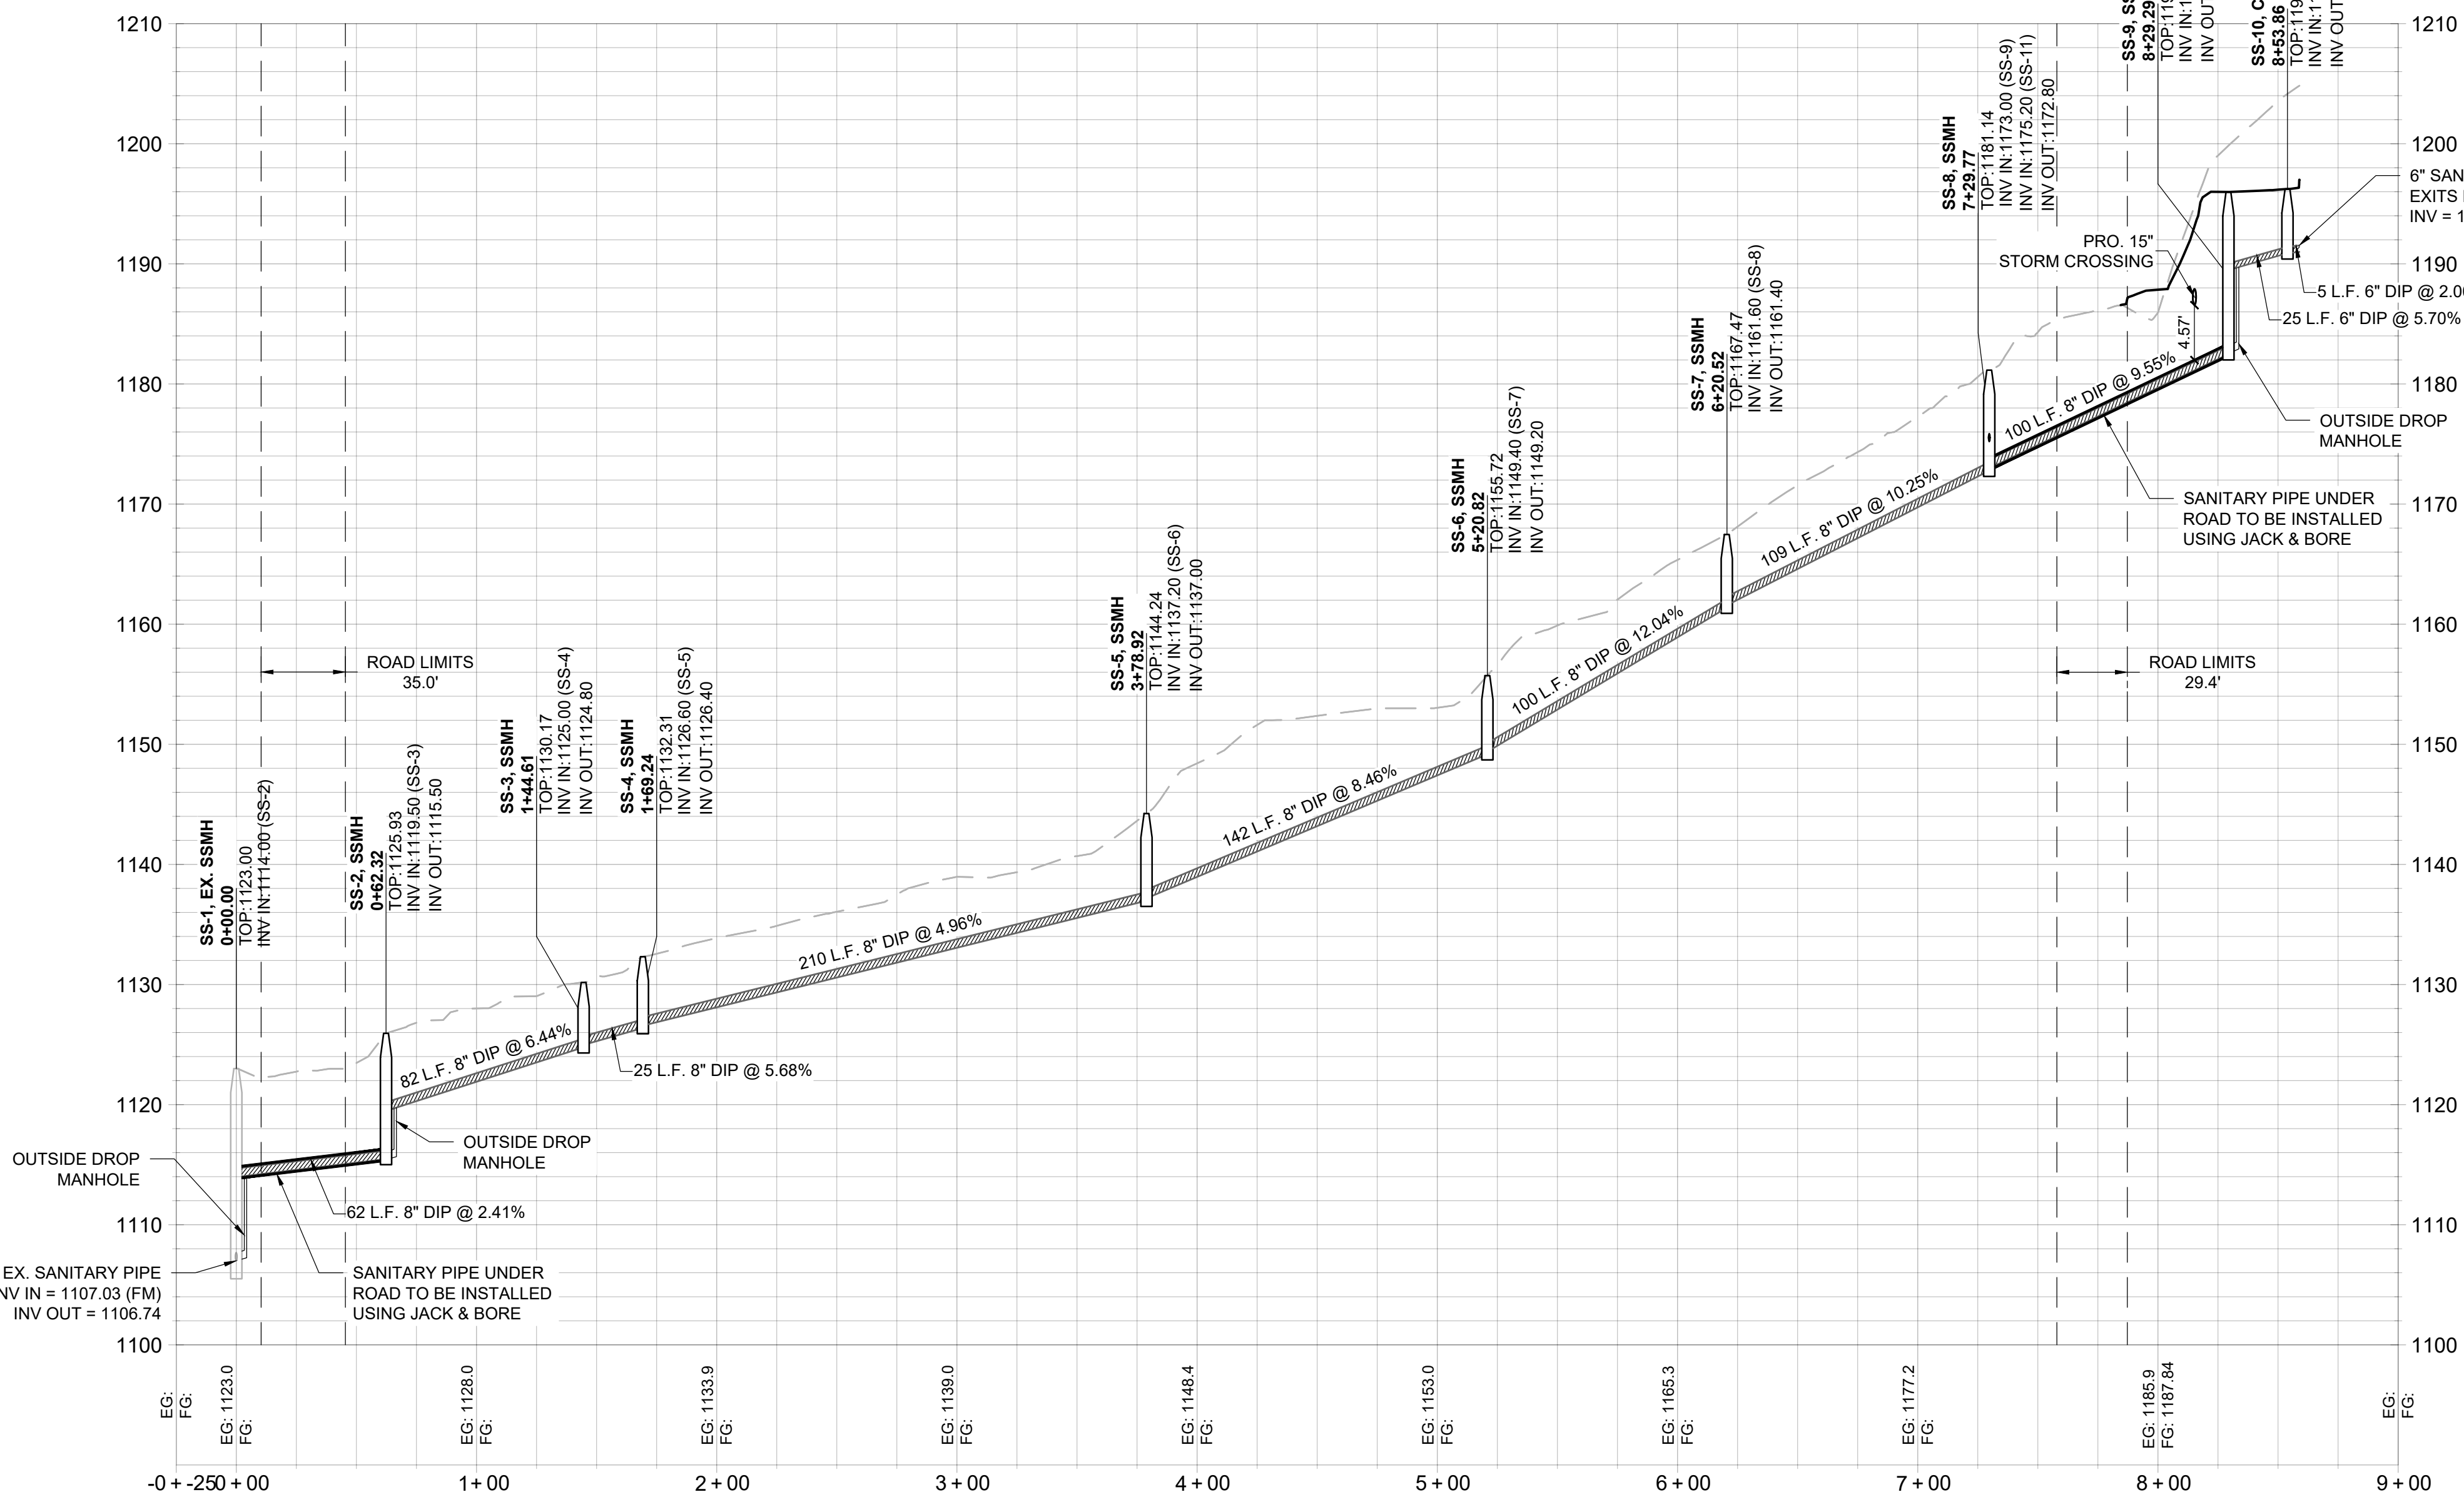

PLAN VIEW

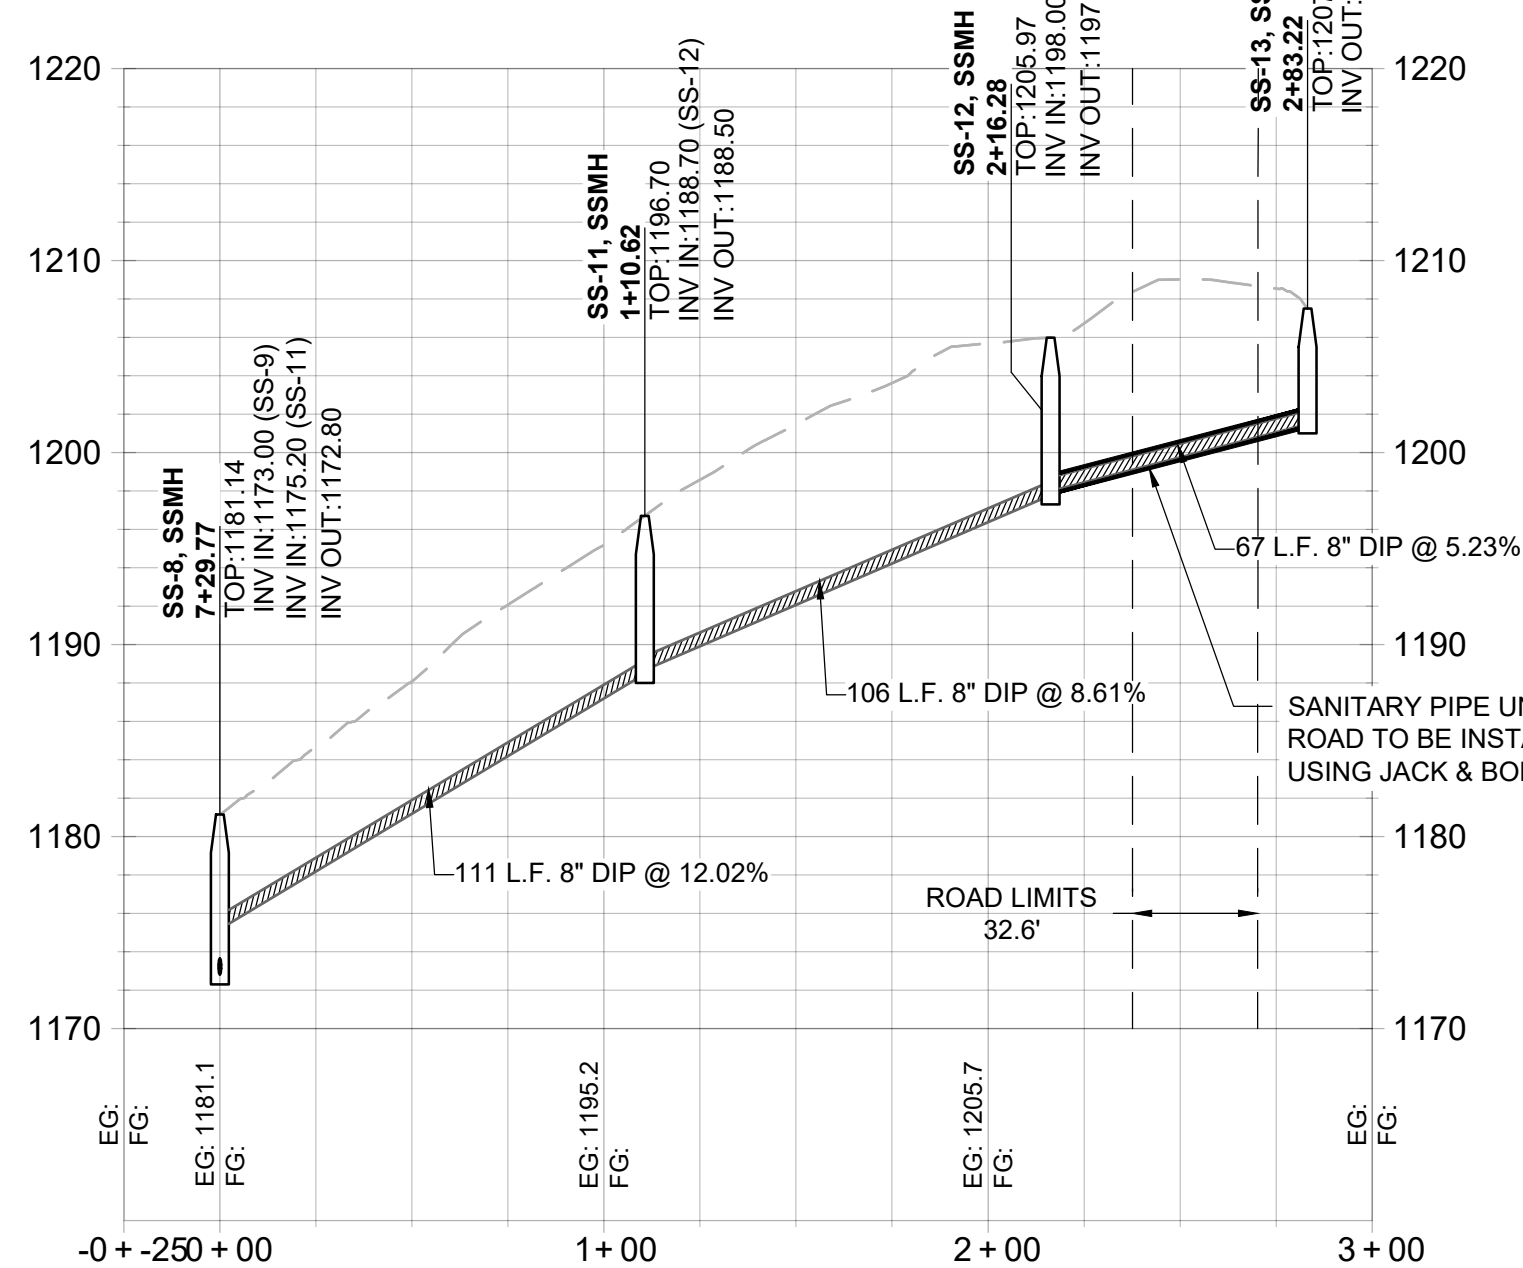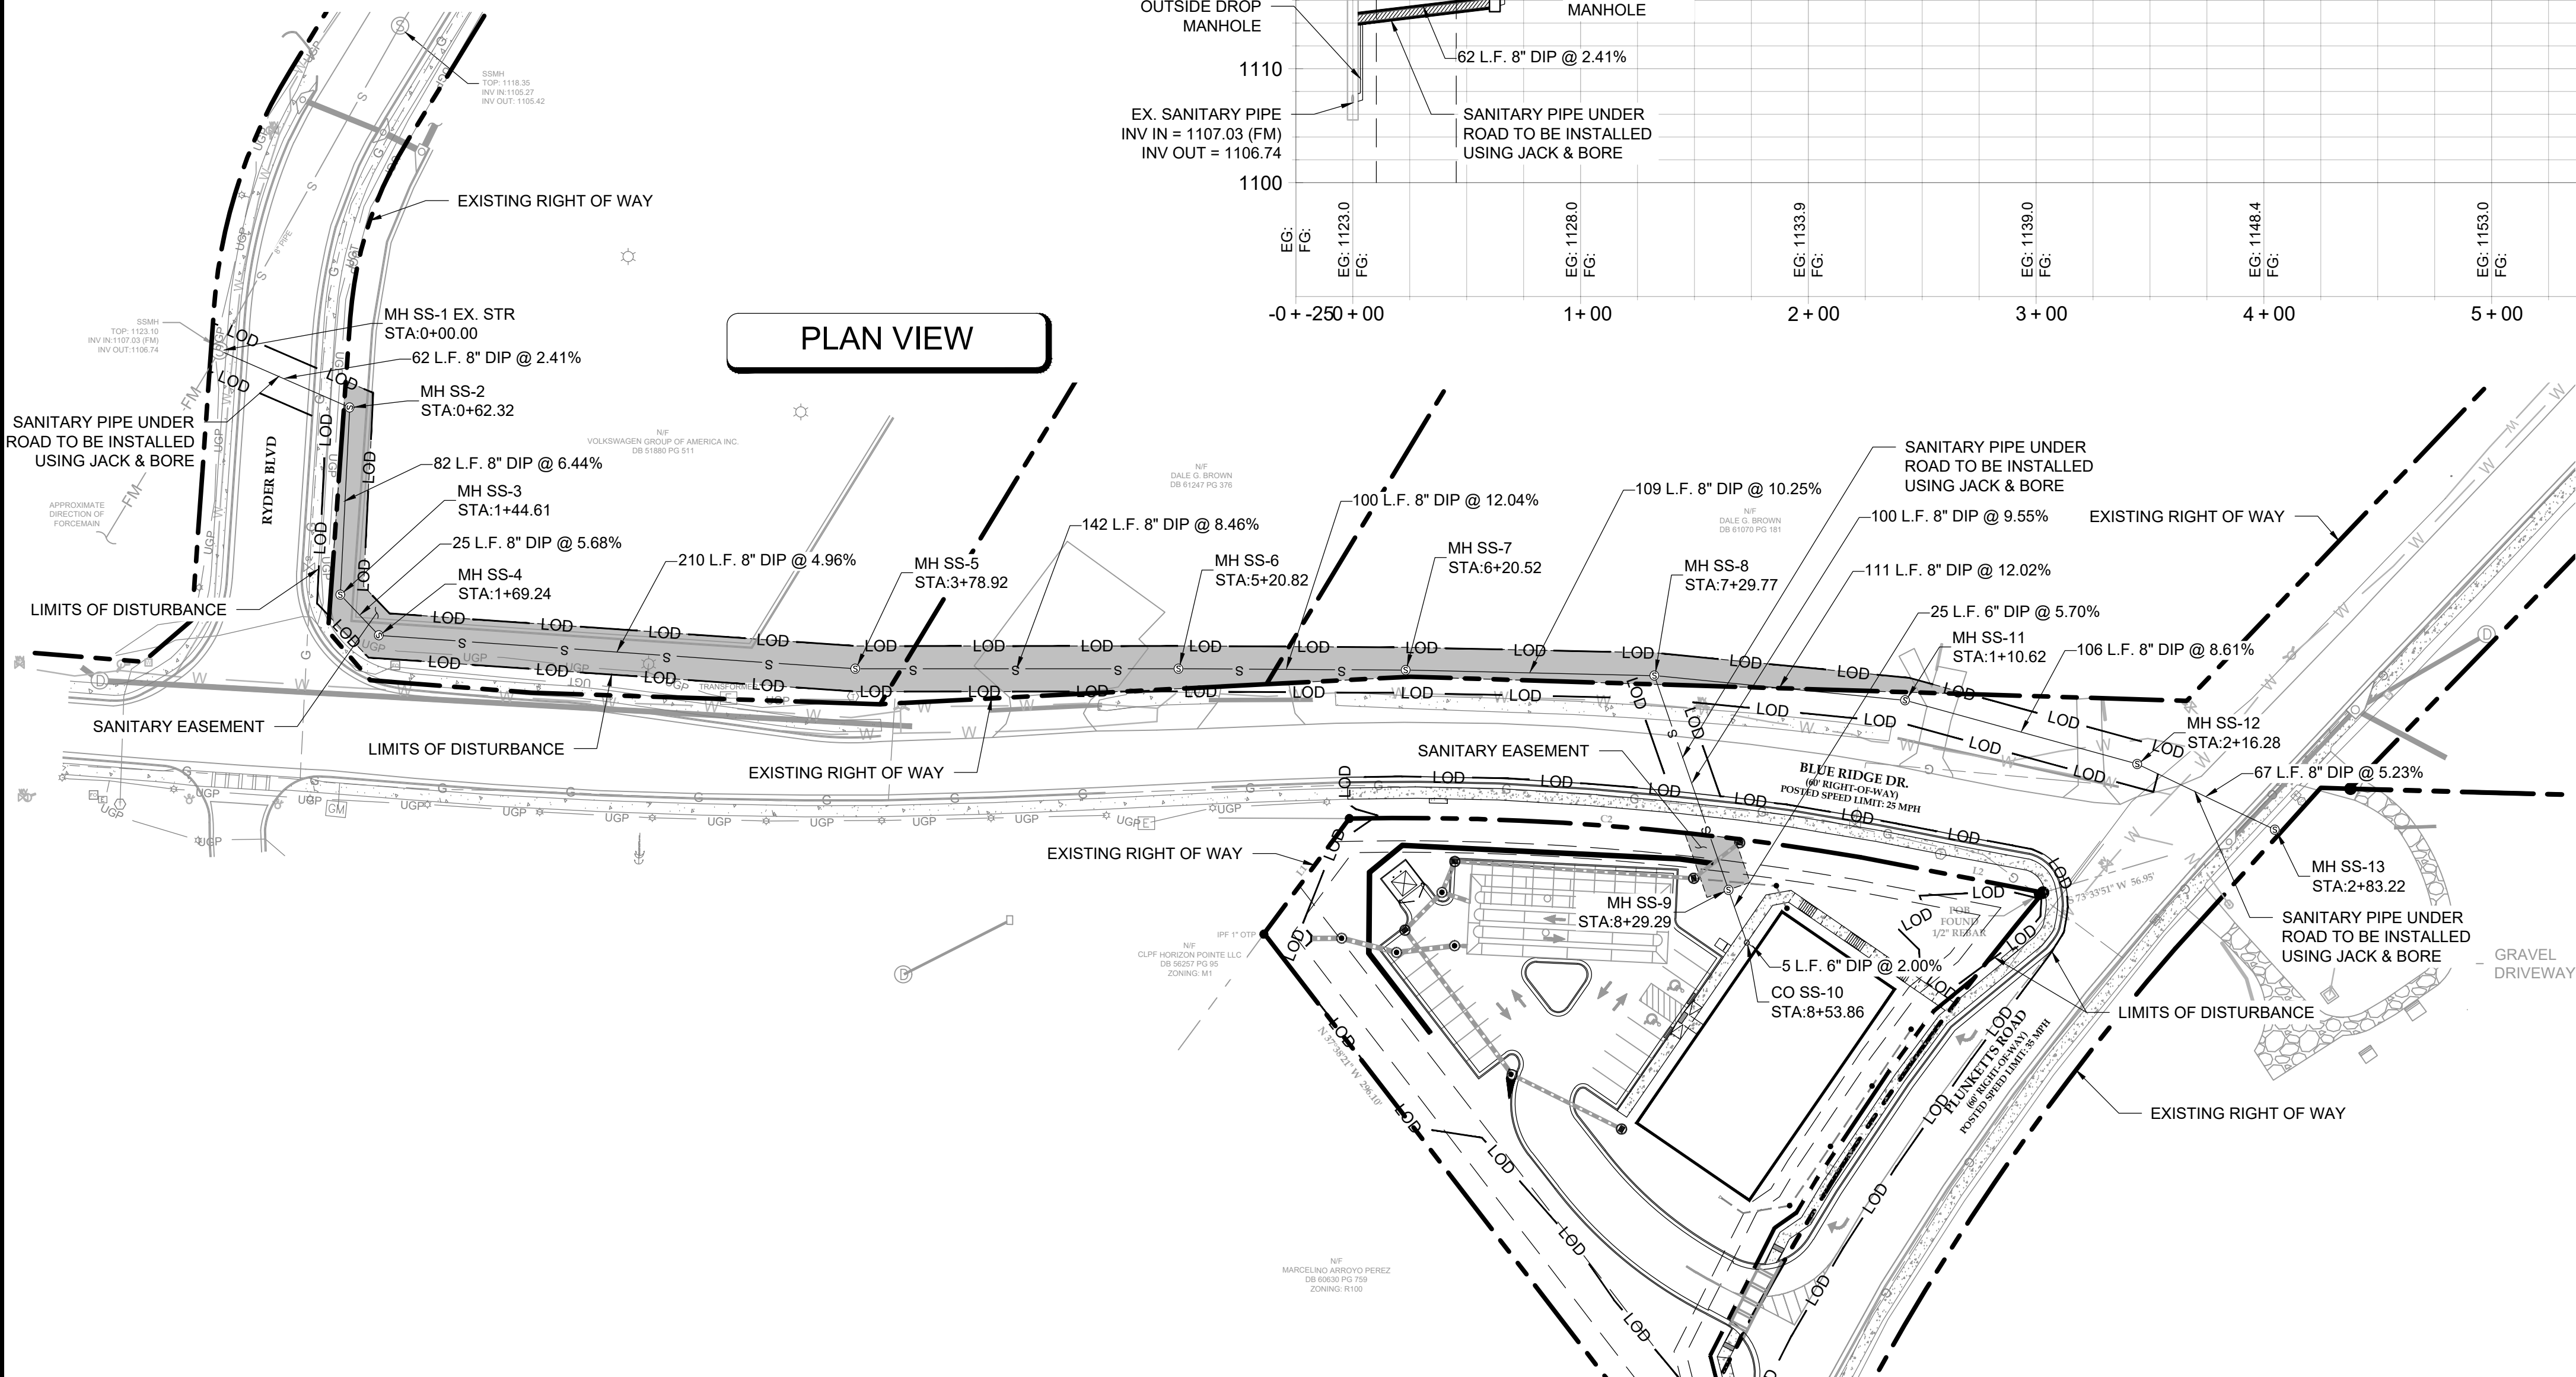

Civil Engineering By LJA:
Tyler Marchman, GA PE04098
Cell: 770-855-2430
tmarchman@lja.com




GASWCC LEVEL II
CERTIFICATION #59016
EXPIRATION DATE: 11/17/20

299 S. MAIN STREET
ALPHARETTA, GA 30009
770-225-4730

**BOGAN
ENTERPRISES, LLC**
11555 MEDLOCK BRIDGE RD.
SUITE #190
JOHNS CREEK, GA 30097
paulkhansari@gmail.com

**SITE CONSTRUCTION PLANS FOR
BOGAN ENTERPRISES, LLC**

LOAD
30519
7TH
00

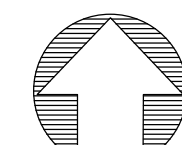

NORT

SCALE: 1" = 50'

PROJECT NUMBER
GA3934-2401

OVERALL SANITARY PLAN & PROFILES

SHEET NUMBER

C-400

C-400