


**FLOOR PLAN**  
SCALE: 1/8"=1'-0"

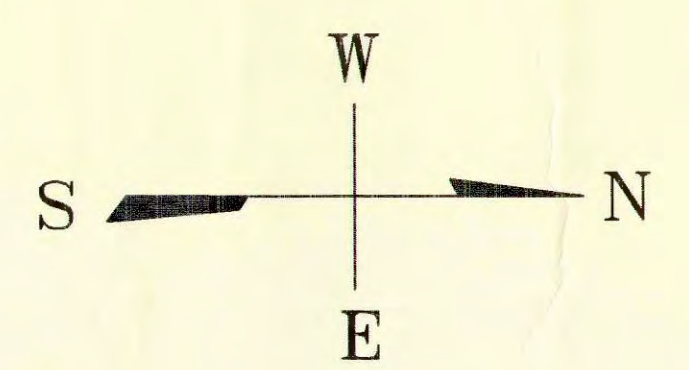

**SYMBOL LEGEND**

MARK	DESCRIPTION
[V]	FIRE ALARM HORN W/ STROBE
[V]	FIRE ALARM VISUAL
[M]	FIRE ALARM PULL STATION
[S]	SMOKE ALARM
[H]	HEAT ALARM
[BPS]	BOOSTER POWER SUPPLY
[FAA]	FIRE ALARM ANNOC. (KEY PAD)
[FACP]	FIRE ALARM CONTROL PANEL
[>]	SECURITY MOTION DETECTOR
[K]	KNOX BOX

REVISIONS				
NO.	DATE	DESCRIPTION	BY	CK'D
XXX	XXX	PRELIMINARY	XXX	XXX

**RTA SYSTEMS, INC.** PHONE: (217) 347-0321  
**FIRE ALARM LAYOUT** FAX: (217) 636-8741  
 305 W. PROFESSIONAL PARK AVE.  
 EFFINGHAM, IL 62401

PROJECT: AGRACEL-NETWORK CENTER  
 Date: 10/13/04 DRAWN BY: JKB  
 Scale: 1/8"=1'-0" Drawing No. \_\_\_\_\_ **FP-1**