

KEYNOTE LEGEND	
1*	MARKETING POSTERS AND 6 SLOT CARD HOLDER
2*	WALL MOUNTED TV ABOVE
3*	IPAD KIOSK, NEED POWER ONLY
6*	EXAM BEDS BY OWNER
9*	WALL MOUNTED IT RACK, PROVIDE 4'x WIDTH OF ROOM 3/4" PLYWOOD BLOCKING SURFACE MOUNT PAINT TO MATCH WALL
17*	36"x24" CORK BOARD
18*	WALL-MOUNTED PHONE IN XRAY FOR SAFE ROOM
19*	SLIDE DEADBOLT MOUNTED 48" AFF ON XRAY SIDE OF DOOR FOR SAFE ROOM
20*	WARDROBE CABINETS LOCKABLE
21*	PADLOCK ON EXTERIOR ROOF LADDER
22*	UTILITY SHELVES
23*	PAINT THE INSIDE FACE OF CASE OPENING TO MATCH DOOR FRAME COLOR
24	DOWNSPOUT - TIE TO STORM SEWER SYSTEM
24*	PROVIDE POWER AND DATA FOR FUTURE TV
25*	LEAD APRON MOUNTING PLATE, CENTER PLATE 5 FT AFF, PROVIDE 2x WOOD BLOCKING FOR MOUNTING PLATE
26	PAINTED STEEL VERTICAL LADDER W/ LOCKABLE GATE
28	TYPICAL SHARPS CONTAINER AND GLOVE BOX (STACKEC) OWNER PROVIDED CONTRACTOR INSTALLED. WALL BRACKET MOUNTED AT 53" A.F.F.
30	HI/LO ADA COMPLIANT DRINKING FOUNTAIN W BOTTLE FOLLER - SEE PLUMBING DRAWINGS FOR MORE INFO.
31	KEY LOCKBOX
35	STRUCTURAL POST - SEE "S" SHEETS FOR DETAILS
38	GAS SERVICE - SEE MEP & CIVIL SHEETS
39	INSTALL CONDUIT AND 2 PULL STRINGS FROM ABOVE CEILING TO LATCH SIDE TO ASSIST WITH INSTALLATION OF ACCESS CONTROL
41	SOLID PLYWOOD WALL PAINTED
43	REAR SERVICE HM DOOR & FRAME - PAINT TO MATCH MASONRY WALL
45	ELECTRICAL SERVICE - SEE ELEC. & CIVIL SHEETS

MISC. EQUIPMENT SCHEDULE							
MARK	COUNT	DESCRIPTION	FURN.	INST.	MANUFACTURER	MODEL #	COMMENTS
E100	1	PRINTER/COPIER	OW	OW	TBD	TBD	
E110	1	WIIFI TABLET STAND	OW	OW	TBD	TBD	
E120	1	TELEVISION	OW	GC	TBD	TBD	
E130	1	UNCERCOUNTER REFRIGERATOR ABS	OW	OW	ABT-HC-UCFS-0504W	1020949	MCKESSON MEDICAL SURGICAL
E140	1	Whirlpool® 33-inch Wide Side-by-Side Refrigerator - 21 cu. ft.	GC	GC	WHIRLPOOL	WRS321SDH	BREAKROOM
E220	1	LAB REFRIGERATOR	OW	OW	ABT-RFC-3M	974834	MCKESSON MEDICAL SURGICAL

NOTE: SEE SHEET A1-11 FOR PLUMBING FIXTURE AND ACCESSORY SCHEDULE

INSULATION SCHEDULE	
LOCATION	INSULATION TYPE
CEILINGS	NO INSULATION
CONC. SLAB	R10, RIGID PERIMETER INSULATION 2 FEET WIDE HORIZONTAL, 2 FEET MIN. VERTICAL
EXTERIOR WALLS	R21, HIGH DENSITY BATTS
INTERIOR WALLS	R13, FIBERGLASS, BATTS (RESTROOM PARTITIONS ONLY)
ROOF	R30 MIN. DOUBLE LAYER OF 2.2 RIGID FOAM POLY-ISO

GENERAL NOTES


- CONTACT OWNER TO MATERIALS AND EQUIPMENT TO BE PROVIDED BY OWNER AND INSTALLED BY CONTRACTOR
- ALL FINISH COLORS TO BE DETERMINED BY OWNER/TENANT
- ALL FLOORING TO BE LUXURY VINYL TILE - STYLE AND COLOR TBD
- REFER TO SHEET A8-20 FOR DOOR DETAILS
- ALL DIMENSIONS TO BE FIELD VERIFIED BY CONTRACTOR
- STRUCTURAL OBSERVATIONS WILL BE PROVIDED AS REQUIRED
- ENSURE OUTSIDE PLYWOOD SHEATHING IS FLUSH WITH OUTSIDE OF SLAB
- SEE INTERIOR ELEVATIONS FOR TV LOCATIONS IN LOBBY/WAITING. MOUNT 81" TO BOTTOM OF BRACKET.
- SEE ROOM FINISH SCHEDULE AT SHEET A1-41 FOR ROOMS WITH CHAIR RAIL

PARTITION LEGEND


- A40 SHEAR WALL - SEE STRU. DWGS.
- A20 PARTITION - NOT FULL HEIGHT
- B20 PARTITION - FULL HEIGHT
- P110 MISC. EQUIPMENT TAG

NOTES

- SEE A1-31 FOR ENLARGED RESTROOM PLANS
- SEE A8-20 FOR DOOR SCHEDULE

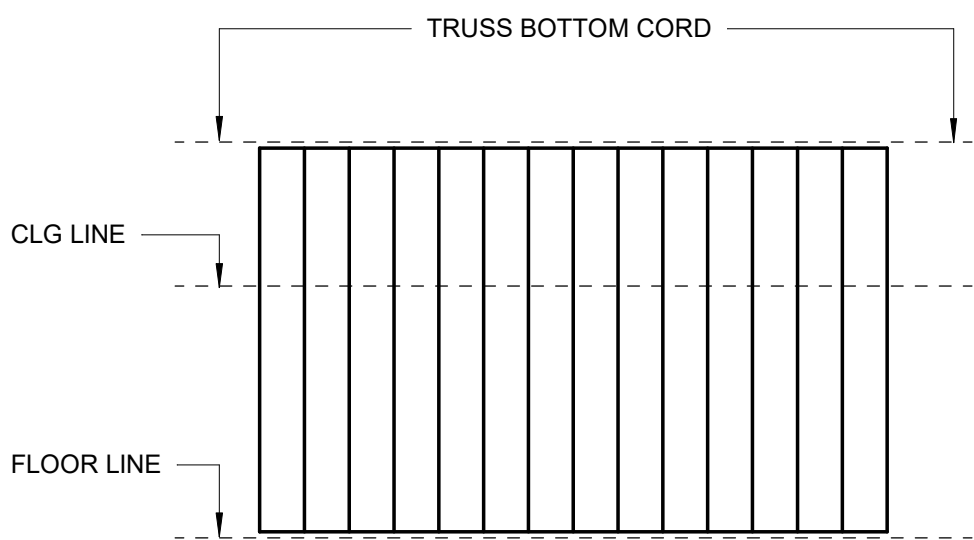

PARTITION "B" DIAGRAM


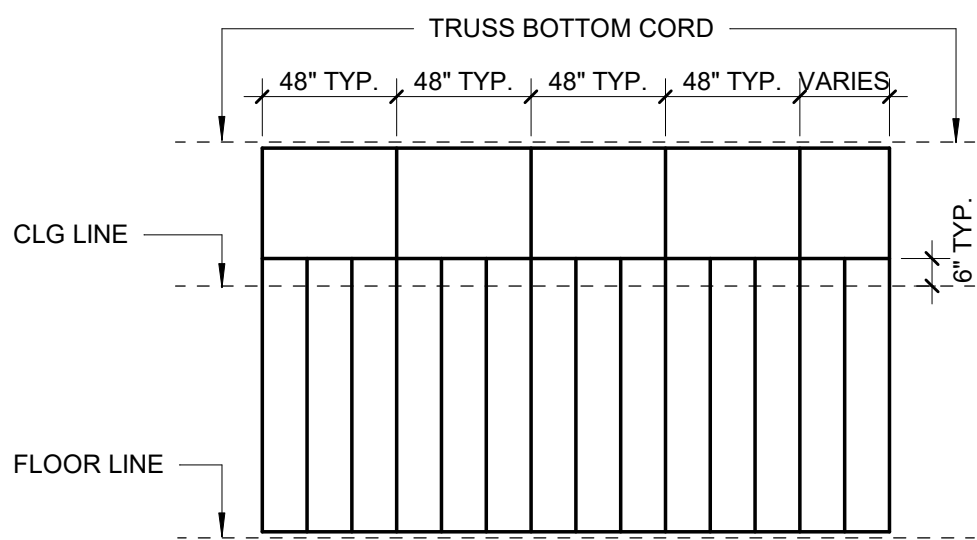


PARTITION "A" DIAGRAM

PARTITION F – FURRING						
MARK	WALL THICKNESS	STUD SIZE	INSULATION TYPE	WALL RATING STC/R	FIRE RATING/ UL DESIGN No	REMARKS
F20	4 1/8"	3 1/2"	N/A	N/A	N/A	

PARTITION B – FULL HEIGHT						
MARK	WALL THICKNESS	STUD SIZE	INSULATION TYPE	WALL RATING STC/R	FIRE RATING/ UL DESIGN No	REMARKS
B20	4 3/4"	3 1/2"	R13	36	N/A	
B40	6 3/4"	5 1/2"	R13	49	N/A	

PARTITION A – NOT FULL HEIGHT						
MARK	WALL THICKNESS	STUD SIZE	INSULATION TYPE	WALL RATING STC/R	FIRE RATING/ UL DESIGN No	REMARKS
A20	4 3/4"	3 1/2"	N/A	N/A	N/A	
A40	6 3/4"	5 1/2"	N/A	N/A	N/A	

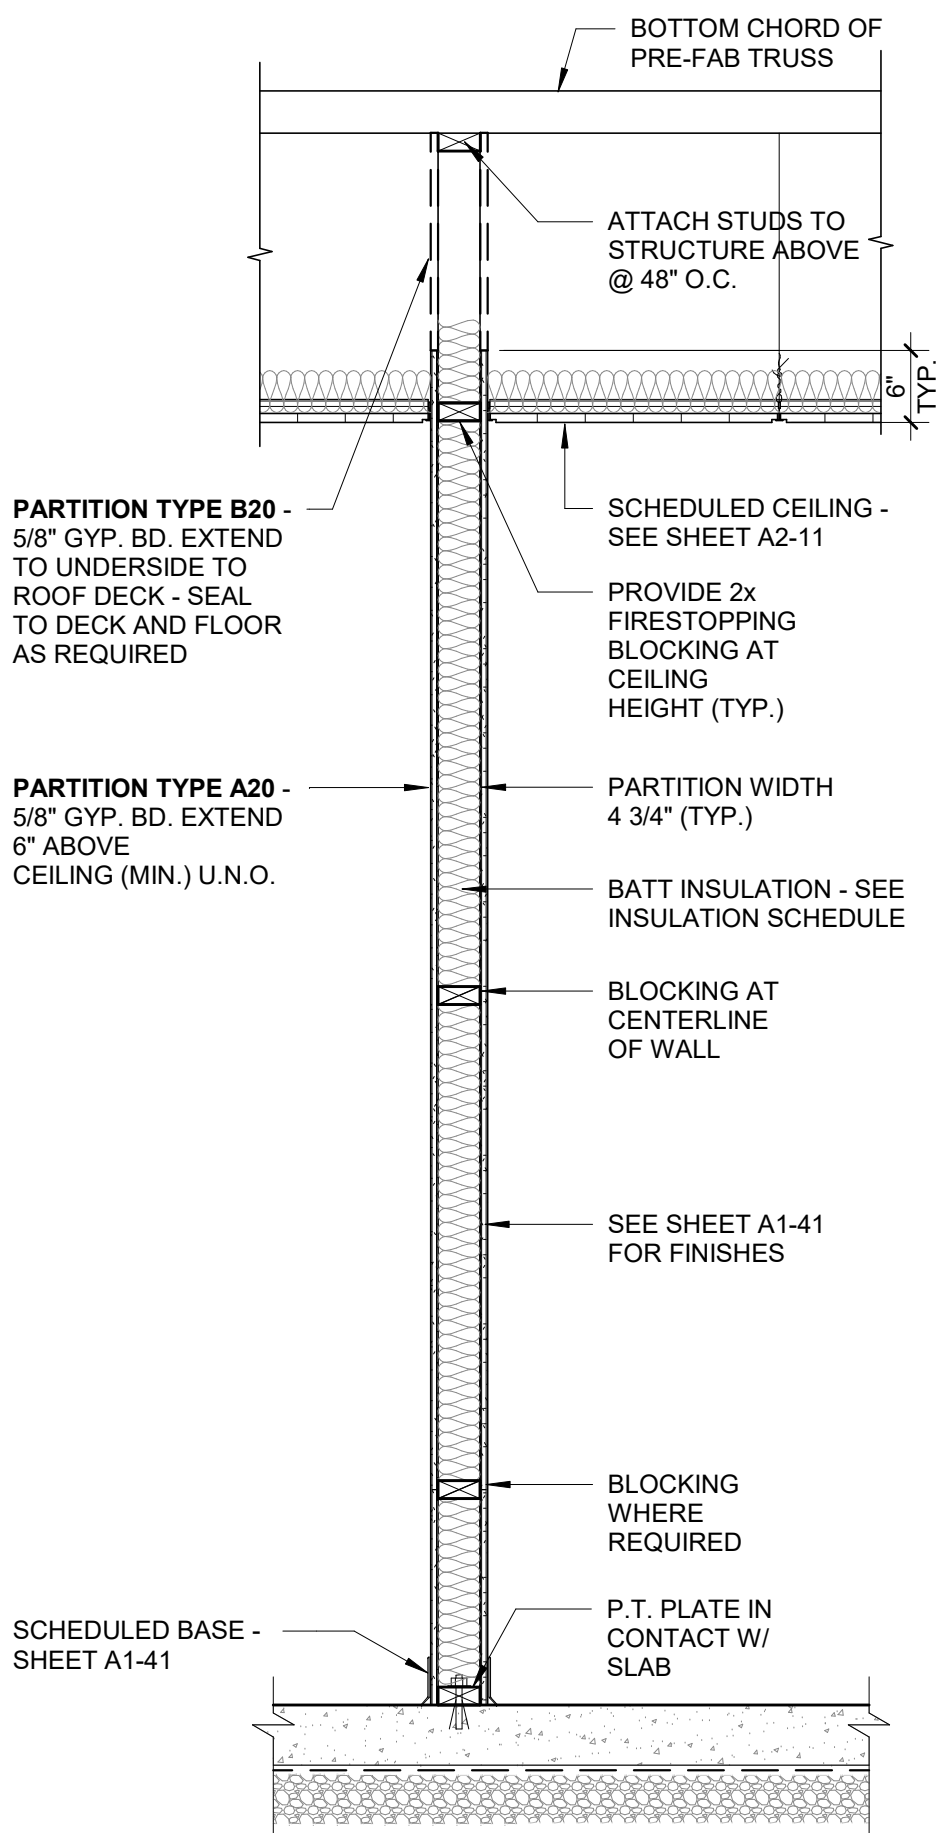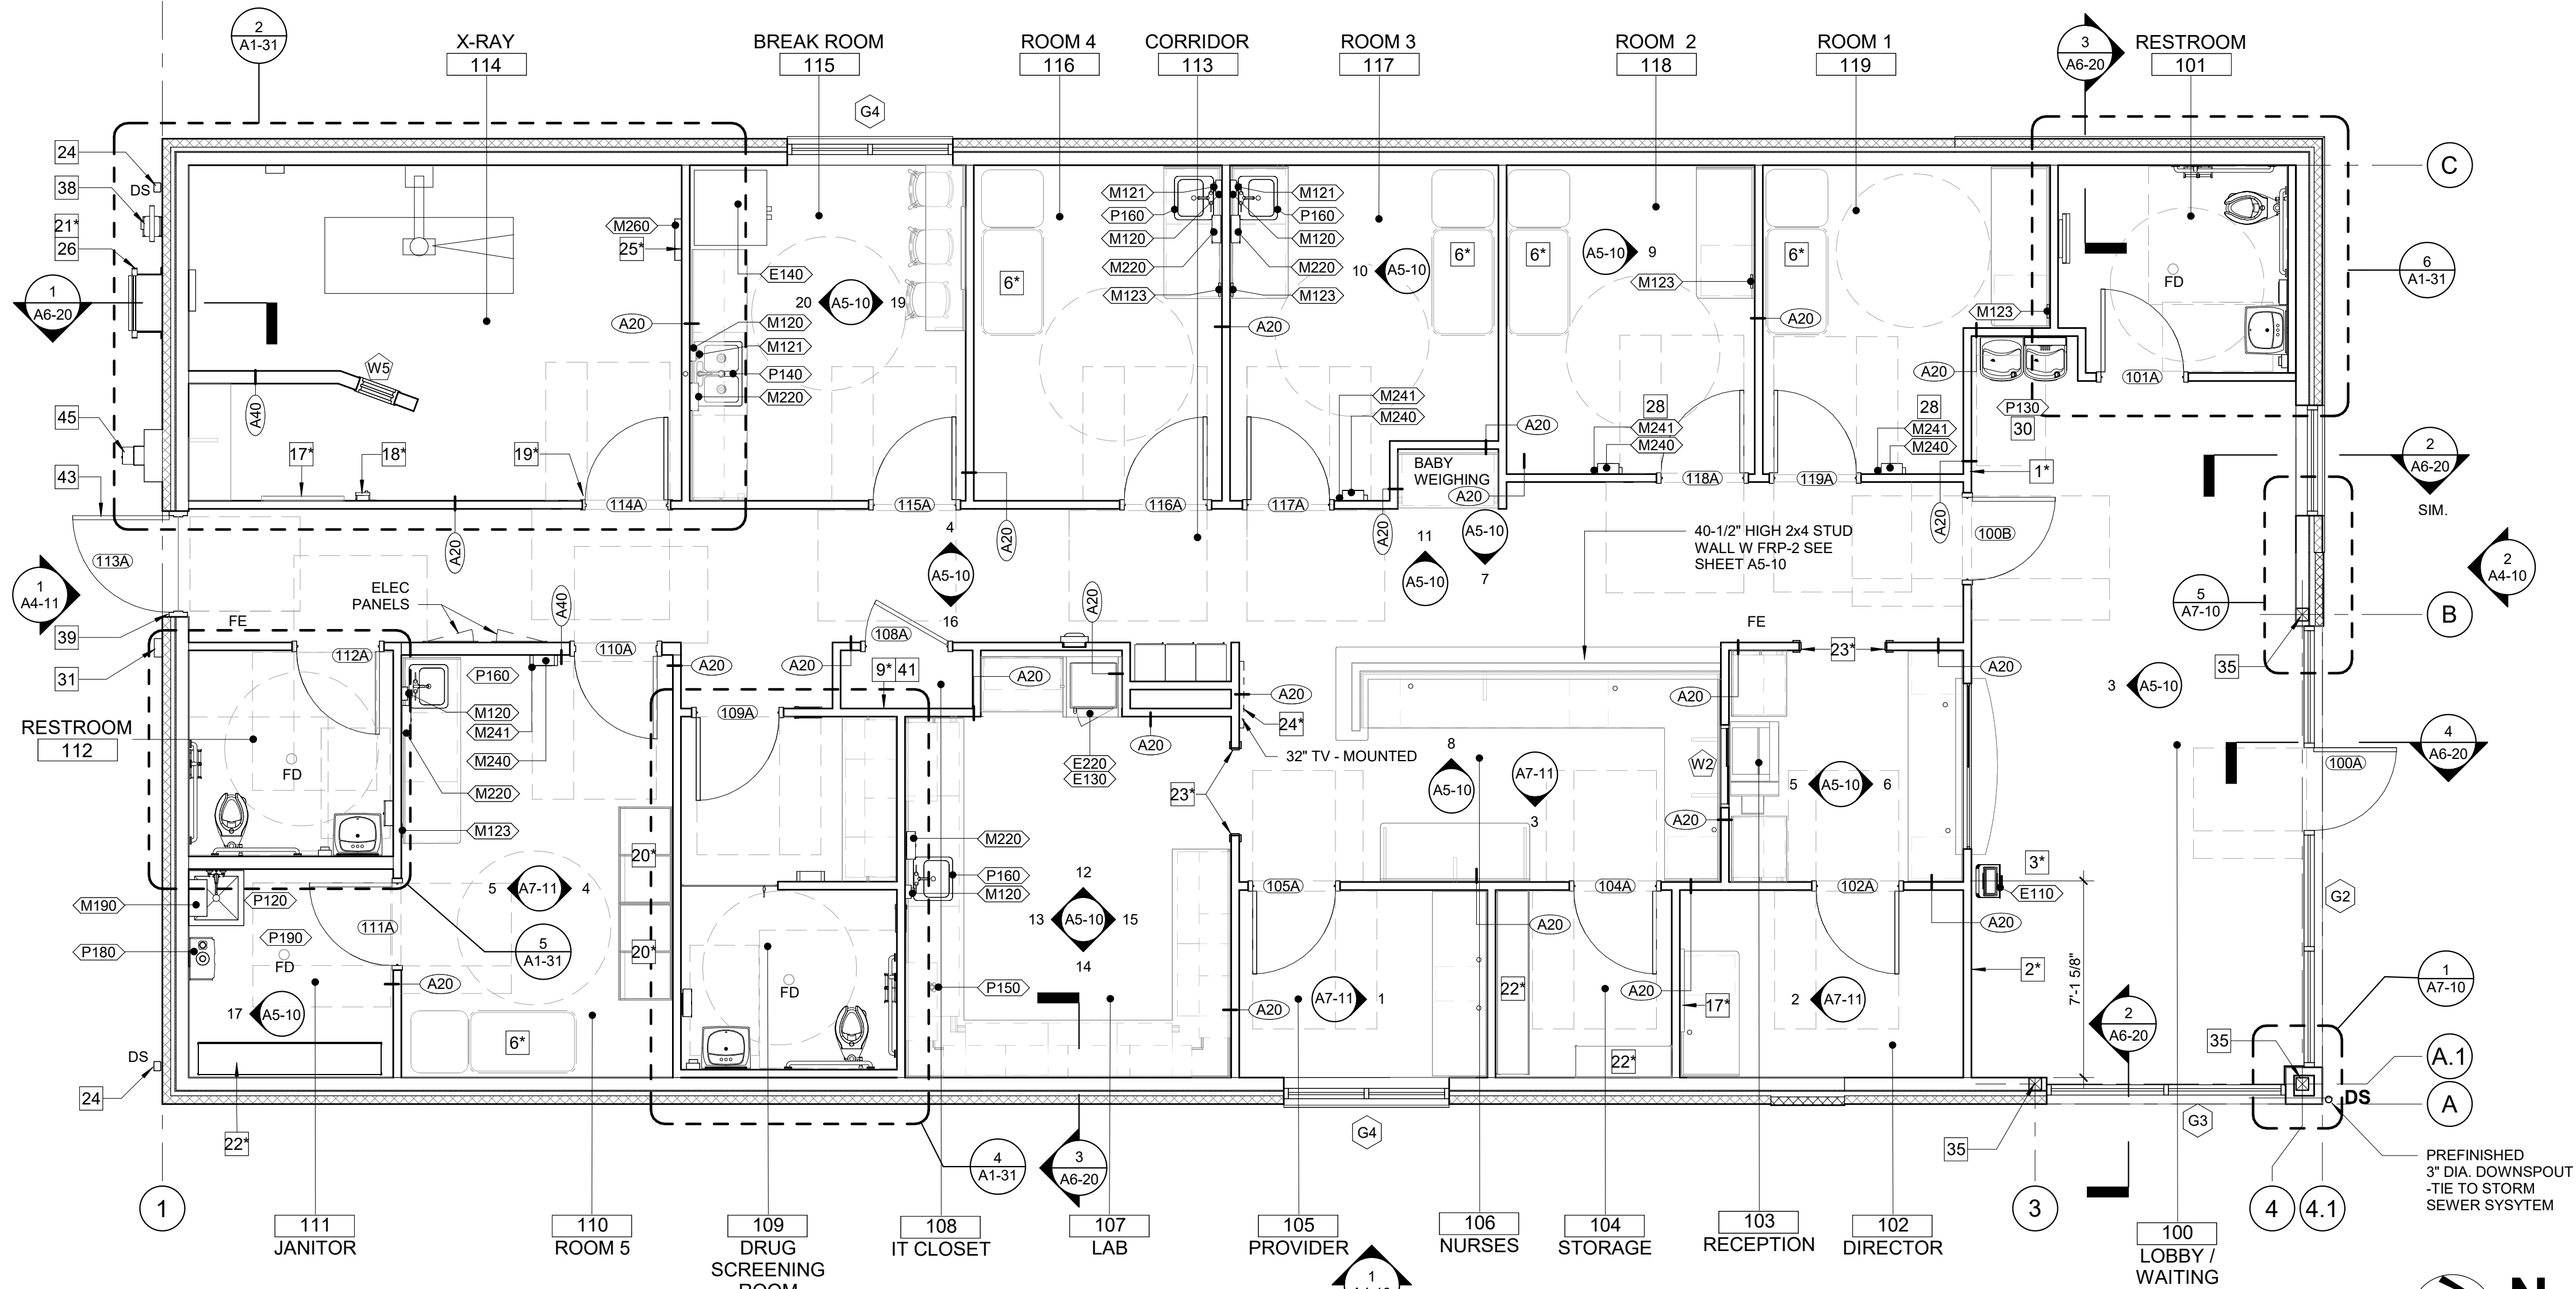

PARTITION TYPE B20 - 5/8" GYP. BD. EXTEND TO UNDERSIDE OF ROOF DECK - SEAL TO DECK AND FLOOR AS REQUIRED

PARTITION TYPE A20 - 5/8" GYP. BD. EXTEND 6" ABOVE CEILING (MIN.) U.N.O.

BOTTOM CHORD OF PRE-FAB TRUSS

ATTACH STUDS TO STRUCTURE ABOVE @ 48" O.C.

SCHEDULED CEILING - SEE SHEET A2-11

PROVIDE 2x FIRESTOPPING BLOCKING AT CEILING HEIGHT (TYP.)

PARTITION WIDTH 4 3/4" (TYP.)

BATT INSULATION - SEE INSULATION SCHEDULE

BLOCKING AT CENTERLINE OF WALL

SEE SHEET A1-41 FOR FINISHES

BLOCKING WHERE REQUIRED

P.T. PLATE IN CONTACT W/ SLAB

SCHEDULED BASE - SHEET A1-41

1 FLOOR PLAN
SCALE: 1/4" = 1'-0"

2 TYP. INTERIOR PARTITION
SCALE: 3/4" = 1'-0"


MUNICIPAL APPROVAL STAMP

FAST PAGE HEALTH
URGENT CARE

MEDICAL CLINIC DEVELOPMENT_LH
US HWY 278 & INTERSTATE 30
HOPE, AR 71801

CLIENT

PROJECT

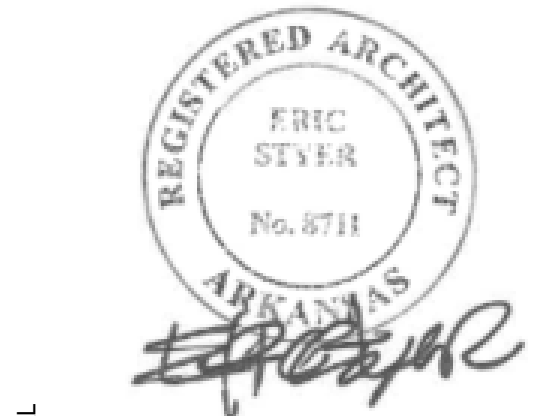

SEAL

DXU
ARCHITECTS
P3139580324 • darchi.com

ARCHITECT

CONSULTANT

BID / PERMIT

PROJECT NUMBER: 24-178
DRAWN BY: APPROVED BY:
NO. DATE ISSUE
1 05/13/2024 BID / PERMIT

1ST FLOOR PLAN

A1-21

THESE DRAWINGS ARE CONFIDENTIAL AND SHALL BE IN THE POSSESSION OF AUTHORIZED INDIVIDUALS ONLY. THESE DOCUMENTS ARE THE EXCLUSIVE PROPERTY OF DXU ARCHITECTS AND SHALL NOT BE COPIED OR REPRODUCED WITHOUT WRITTEN AUTHORIZATION.

© 2020 DXU STUDIO, LLC. All rights reserved.