


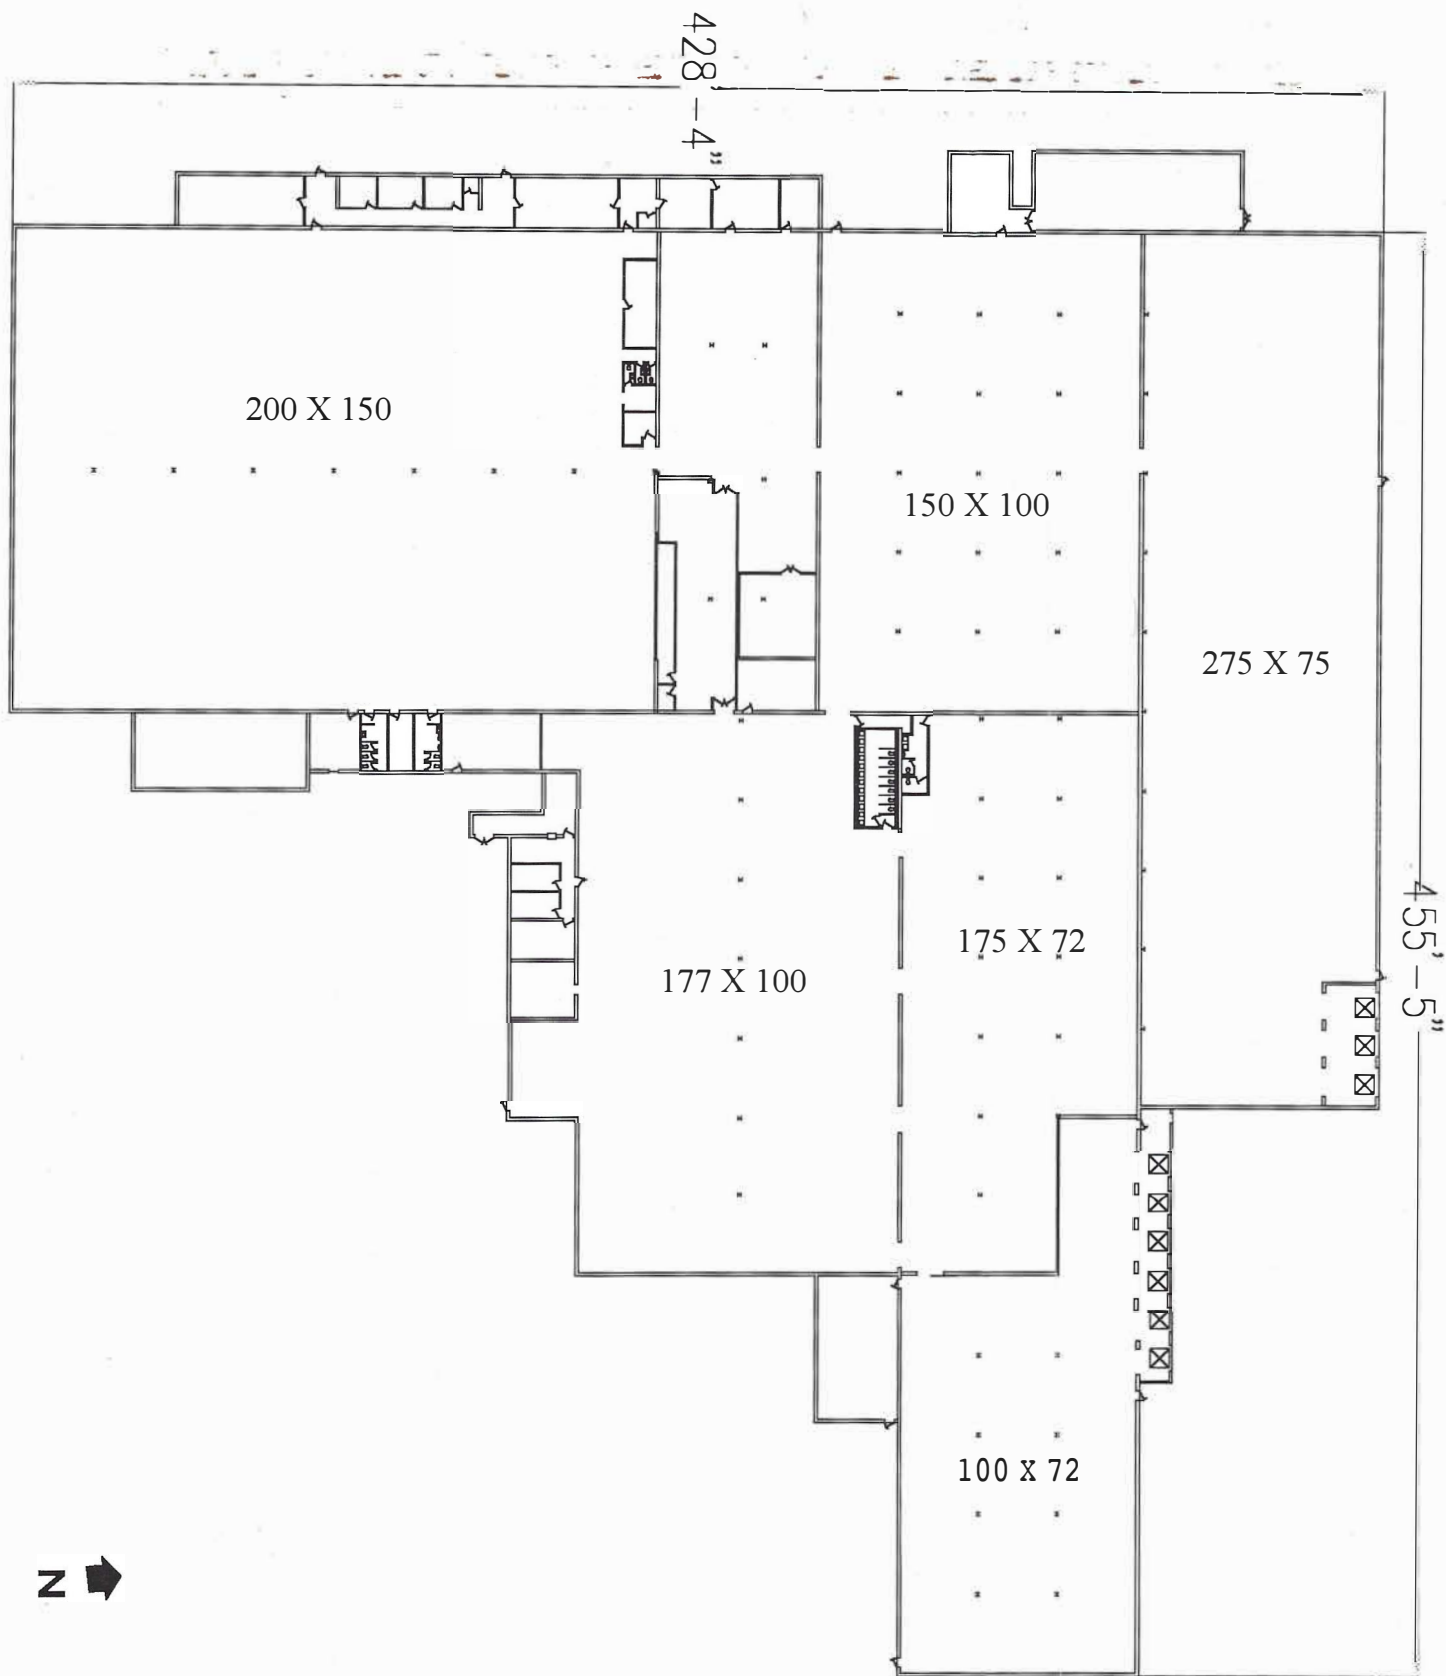

This drawing to be used only
by persons authorized by
VF Jeanswear, Inc.; Facilities Engineering;
1421 S. Elm St.; Greensboro, NC 27406
ph.: 336-332-3577 fx.: 336-332-3770
All rights of design reserved.
Drawing must be returned upon request.



JEANSWEAR

A VF COMPANY

TITLE:

MASTER FLOOR PLAN

PROJ. MGR:

DRAWN BY:

LOCATION:

REV:

RTW

LURAY, VA - SEWING SUPP CTR

SCALE:

DATE:

FILE No.:

DWG. No.:

1" = 60'

14 JUN, 2001

131\MFP131

MFP131