




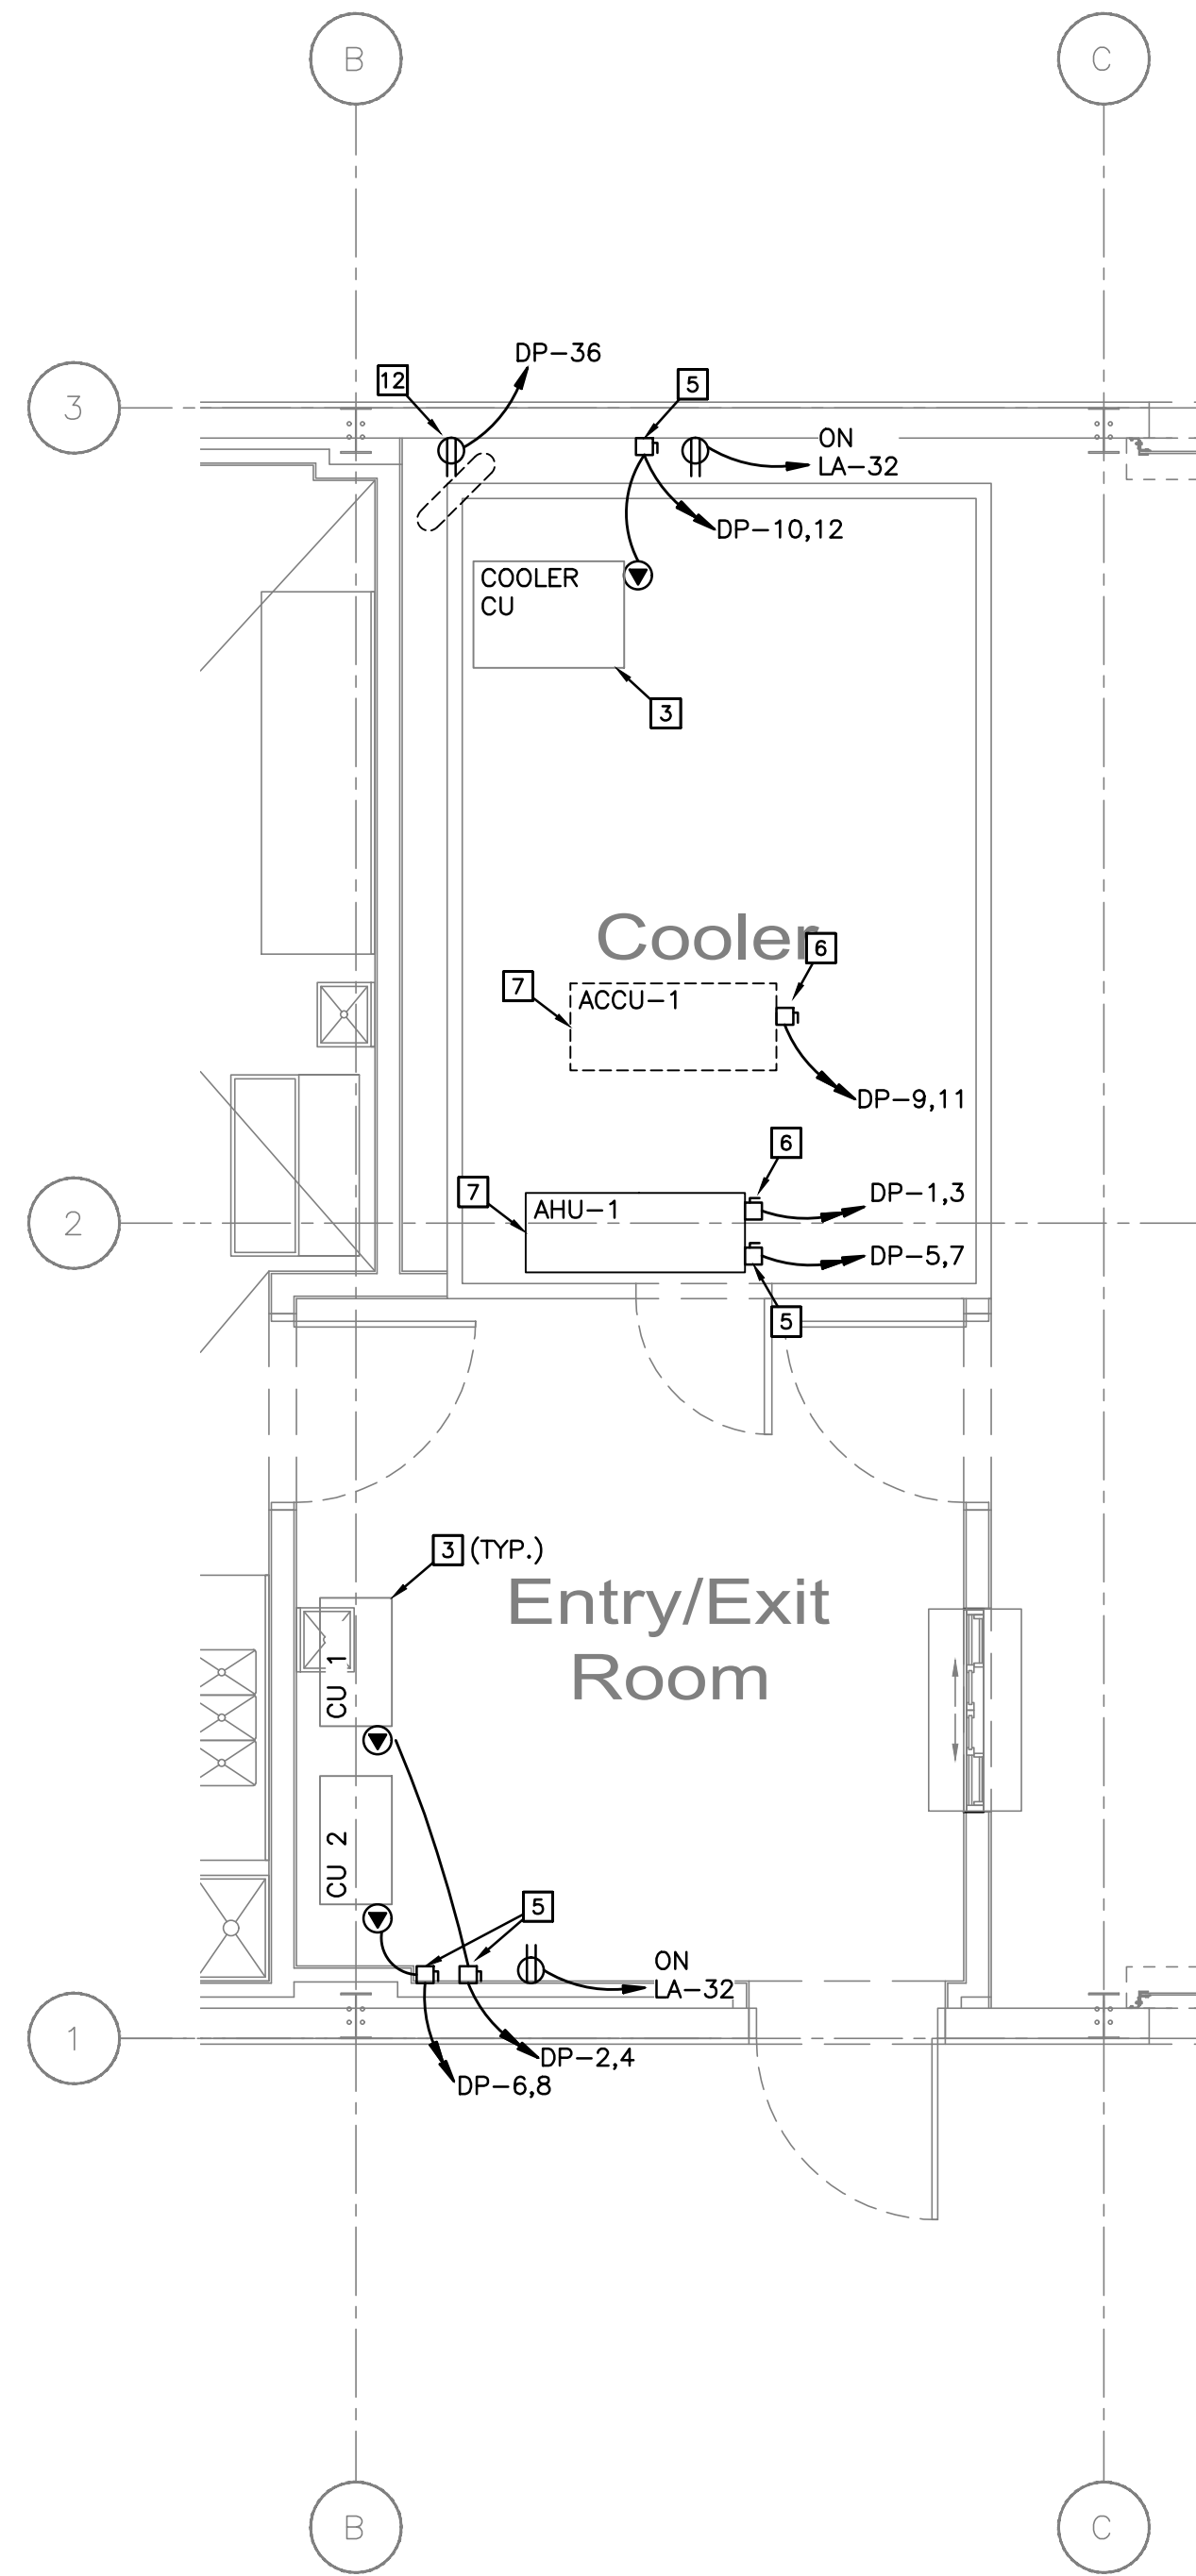

2 MEZZANINE POWER PLAN
SCALE: 1/4"=1'-0"

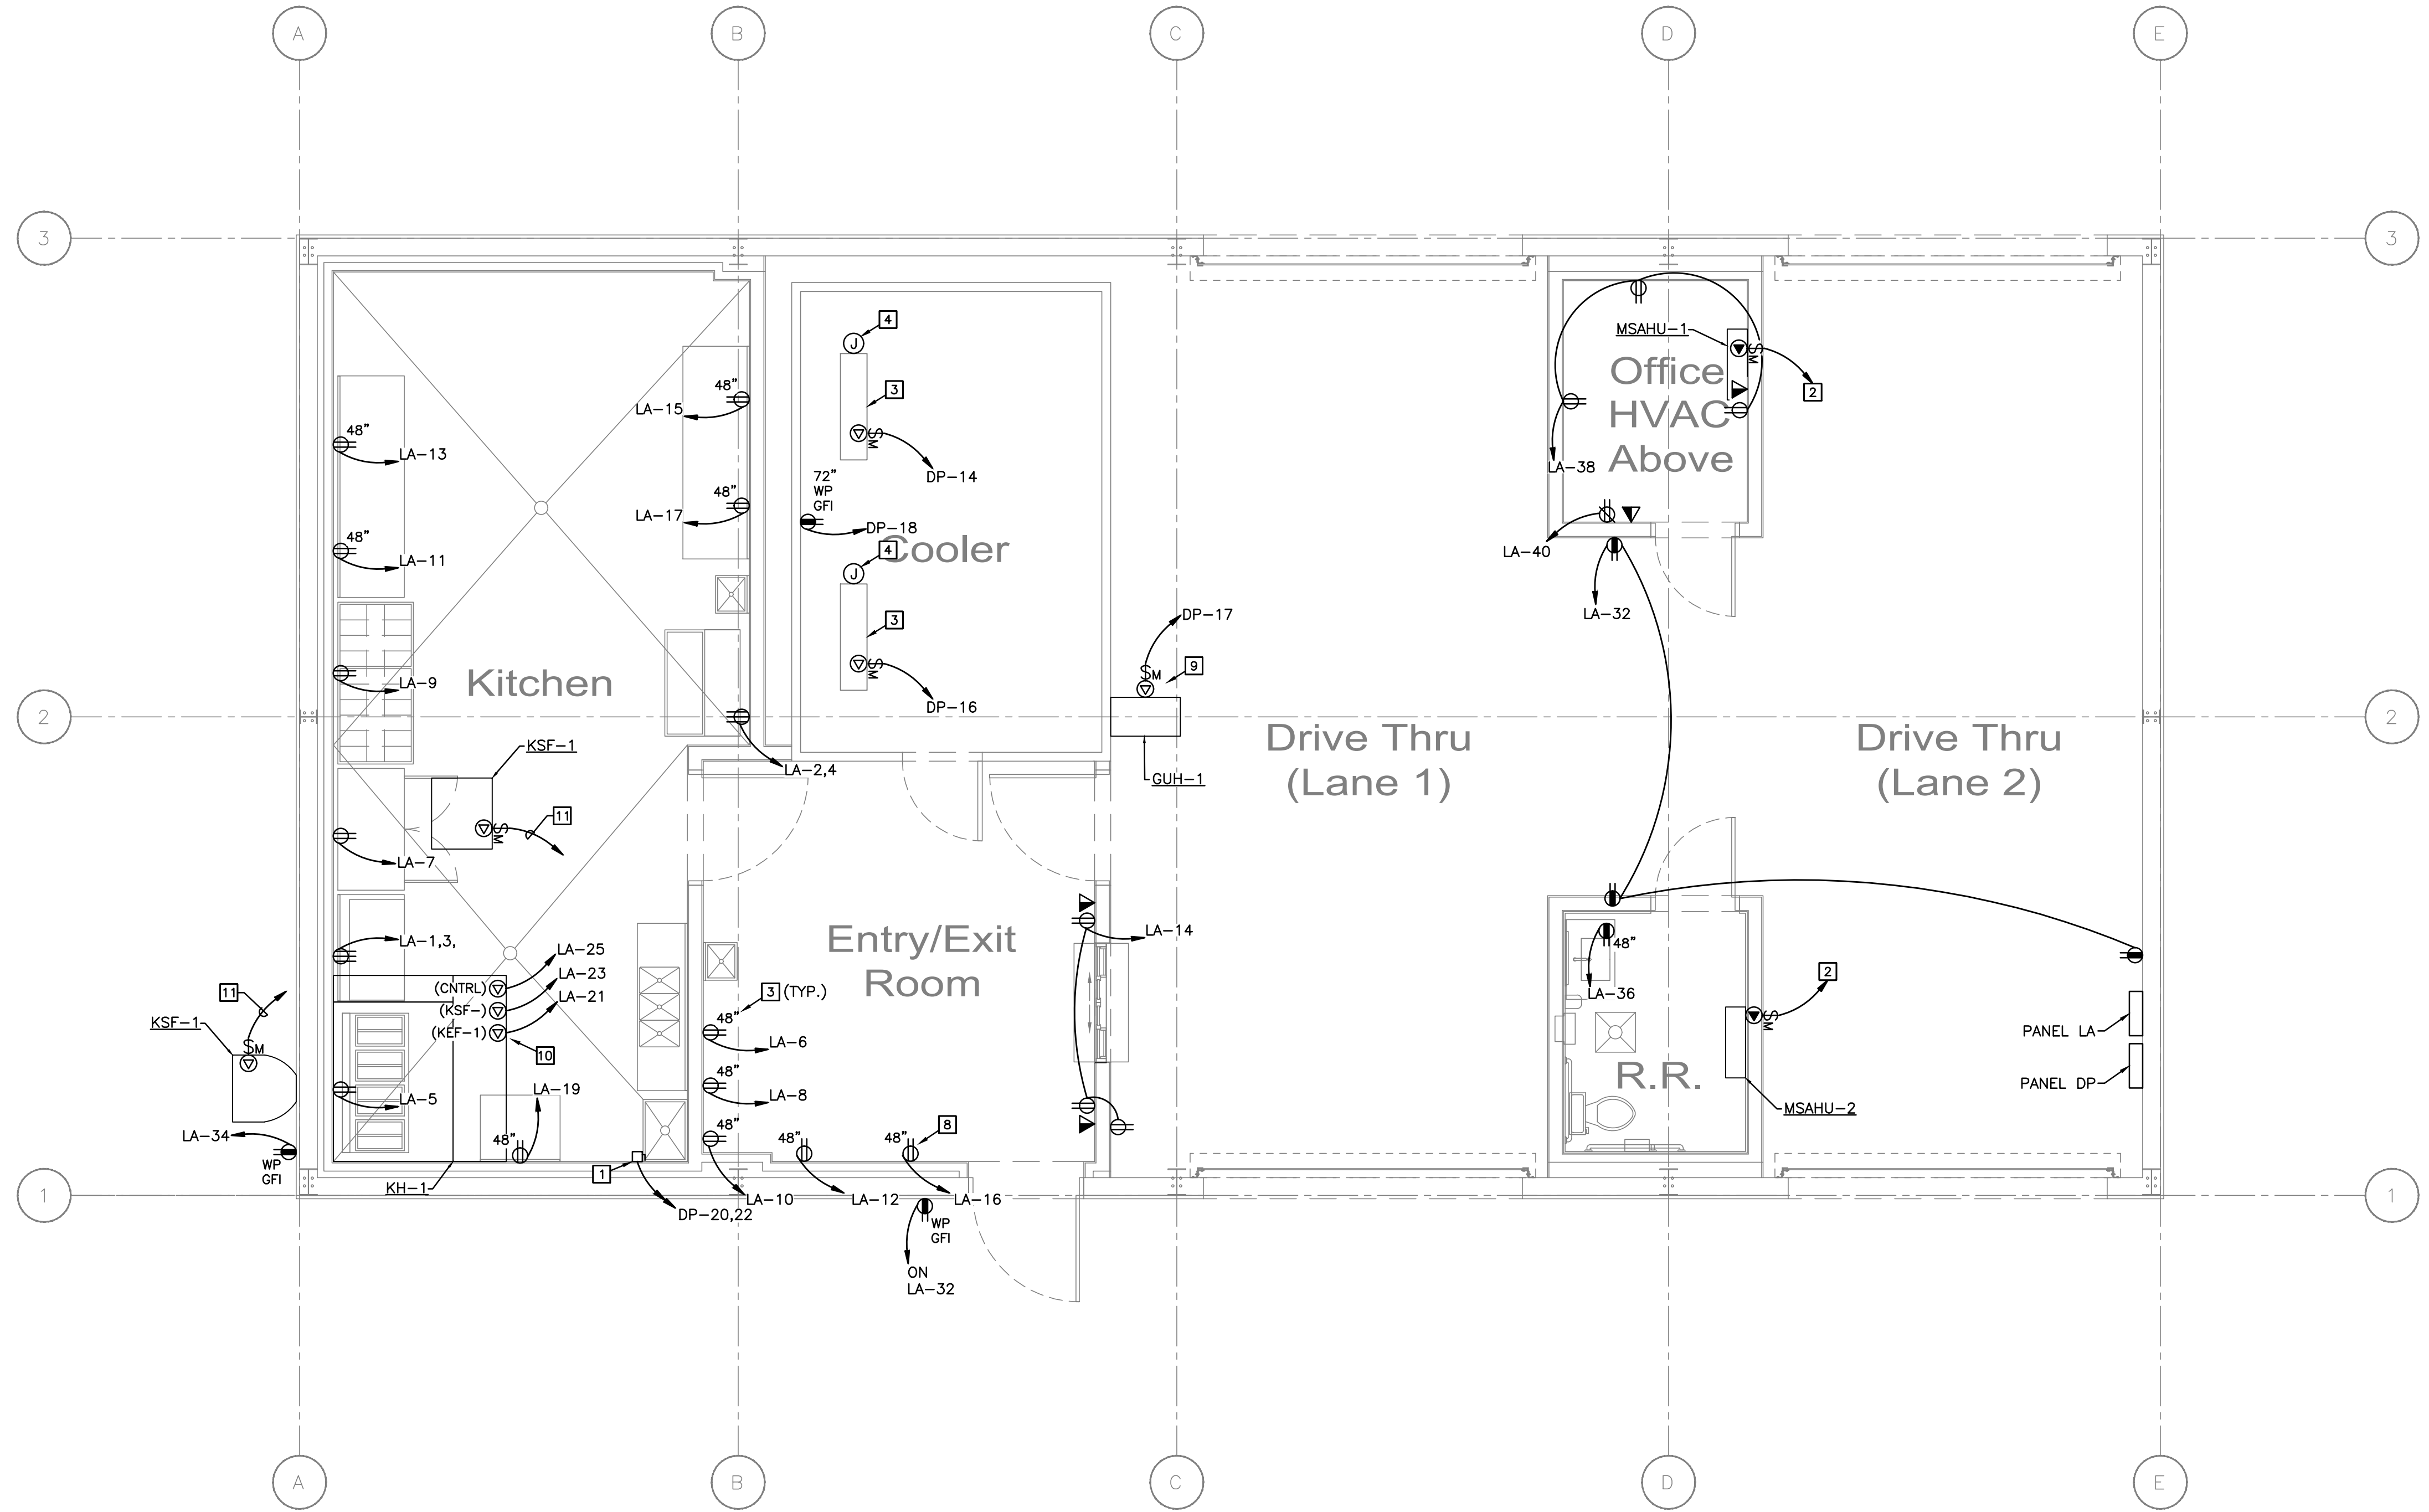

1 POWER PLAN
SCALE: 1/4"=1'-0"

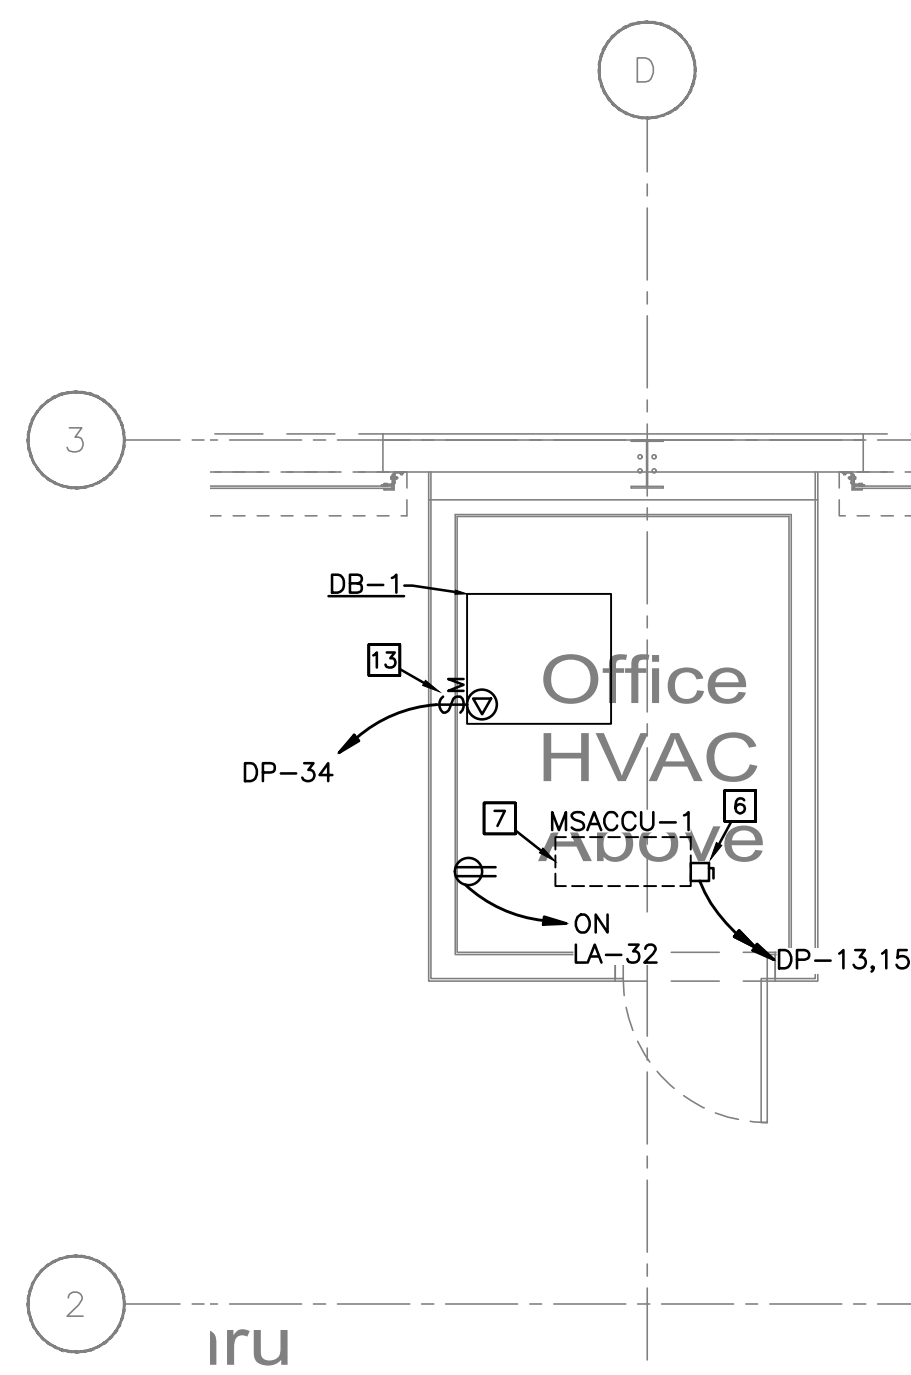

3 MEZZANINE POWER PLAN
SCALE: 1/4"=1'-0"

GENERAL NOTES:

- 1. VERIFY ALL EQUIPMENT LOCATIONS AND POWER REQUIREMENTS WITH OWNER AND OTHER CONTRACTORS PRIOR TO THE COMMENCEMENT OF WORK.
- 2. ELECTRICAL CONTRACTOR SHALL PROVIDE ALL NECESSARY CONDUIT FOR COMMUNICATIONS, FIRE ALARM, AND SECURITY. FIELD COORDINATE EXACT REQUIREMENT PRIOR TO THE COMMENCEMENT OF WORK.
- 3. ALL CONDUIT SHALL BE NEATLY ROUTED PARALLEL AND PERPENDICULAR TO BUILDING LINES.
- 4. ALL DATA DROP SHALL BE PROVIDED WITH 1" CONDUIT WITH PULL STRING.

POWER KEY NOTES:

- 1. PROVIDE AND INSTALL 30A/2P/NF NEMA-1 DISCONNECT SWITCH FOR WATER HEATER IN ACCESSIBLE LOCATION ABOVE.
- 2. PROVIDE 2#12, 1#12G, IN 1/2" CONDUIT FROM AIR HANDLING UNIT TO CONDENSER. COORDINATE WITH HVAC CONTRACTOR FOR EXACT LOCATION AND REQUIREMENT PRIOR TO THE COMMENCEMENT OF WORK.
- 3. COORDINATE EXACT FINAL LOCATION AND REQUIREMENTS OF EQUIPMENT WITH REFRIGERATION CONTRACTOR PRIOR TO THE COMMENCEMENT OF WORK.
- 4. PROVIDE 4#12 IN 1/2" CONDUIT FROM REFRIGERATION WALK-IN COILS TO CONDENSING UNIT. COORDINATE EXACT LOCATION AND REQUIREMENT WITH REFRIGERATION CONTRACTOR PRIOR TO THE COMMENCEMENT OF WORK.
- 5. PROVIDE 30A/2P/NF NEMA-1 DISCONNECT SWITCH MOUNTED IN ACCESSIBLE LOCATION ABOVE CEILING.
- 6. PROVIDE 60A/2P/NF NEMA-1 DISCONNECT SWITCH MOUNTED IN ACCESSIBLE LOCATION ABOVE CEILING.
- 7. COORDINATE EXACT FINAL LOCATION AND REQUIREMENTS OF EQUIPMENT WITH HVAC CONTRACTOR PRIOR TO THE COMMENCEMENT OF WORK.
- 8. SODA FOUNTAIN EQUIPMENT. COORDINATE EXACT LOCATION AND REQUIREMENTS WITH OWNER/VENDOR PRIOR TO THE COMMENCEMENT OF WORK.
- 9. PROVIDE CIRCUIT FOR GAS HEATER AS REQUIRED. COORDINATE EXACT LOCATION AND REQUIREMENT WITH HVAC CONTRACTOR AS REQUIRED.
- 10. PROVIDE NEW CIRCUITS TO KITCHEN HOOD CONTROL PANEL FOR HOOD CONTROLS, EXHAUST FAN, AND SUPPLY FAN. COORDINATE EXACT FINAL LOCATION AND REQUIREMENTS WITH HVAC CONTRACTOR PRIOR TO THE COMMENCEMENT OF WORK.
- 11. PROVIDE 2#10, 1#10G IN 1/2" CONDUIT TO KITCHEN HOOD CONTROL PANEL. COORDINATE EXACT LOCATION AND REQUIREMENT WITH HVAC CONTRACTOR PRIOR TO THE COMMENCEMENT OF WORK.
- 12. RECEPTACLE FOR FAN. COORDINATE EXACT LOCATION AND REQUIREMENTS WITH HVAC CONTRACTOR PRIOR TO THE COMMENCEMENT OF WORK.

IN PRELIMINARY REVIEW
RELEASED FOR PERMIT
RELEASED FOR CONSTRUCTION

DATE	DESCRIPTION	BY	CHKD
08/27/20	1 PERMIT SET		

THE
FRIENDLY
SPOT



L. J. G. Inc.
Electrical and
Mechanical Engineering
4444 Corona Dr., Suite 202
San Antonio, TX 78241
281.882.2543 Fax

absolute design
P A R T N E R S
• 32000 U.S. Highway 281 N. Balverde Texas 78143 •

ELECTRICAL POWER PLAN

FRIENDLY SPOT #2 (DRIVE-THRU)
2041 SOUTH WW WHITE ROAD
SAN ANTONIO, TX 78222

Job #:20147
Date: 08/27/2020
Drawn By: RS

E2.0