



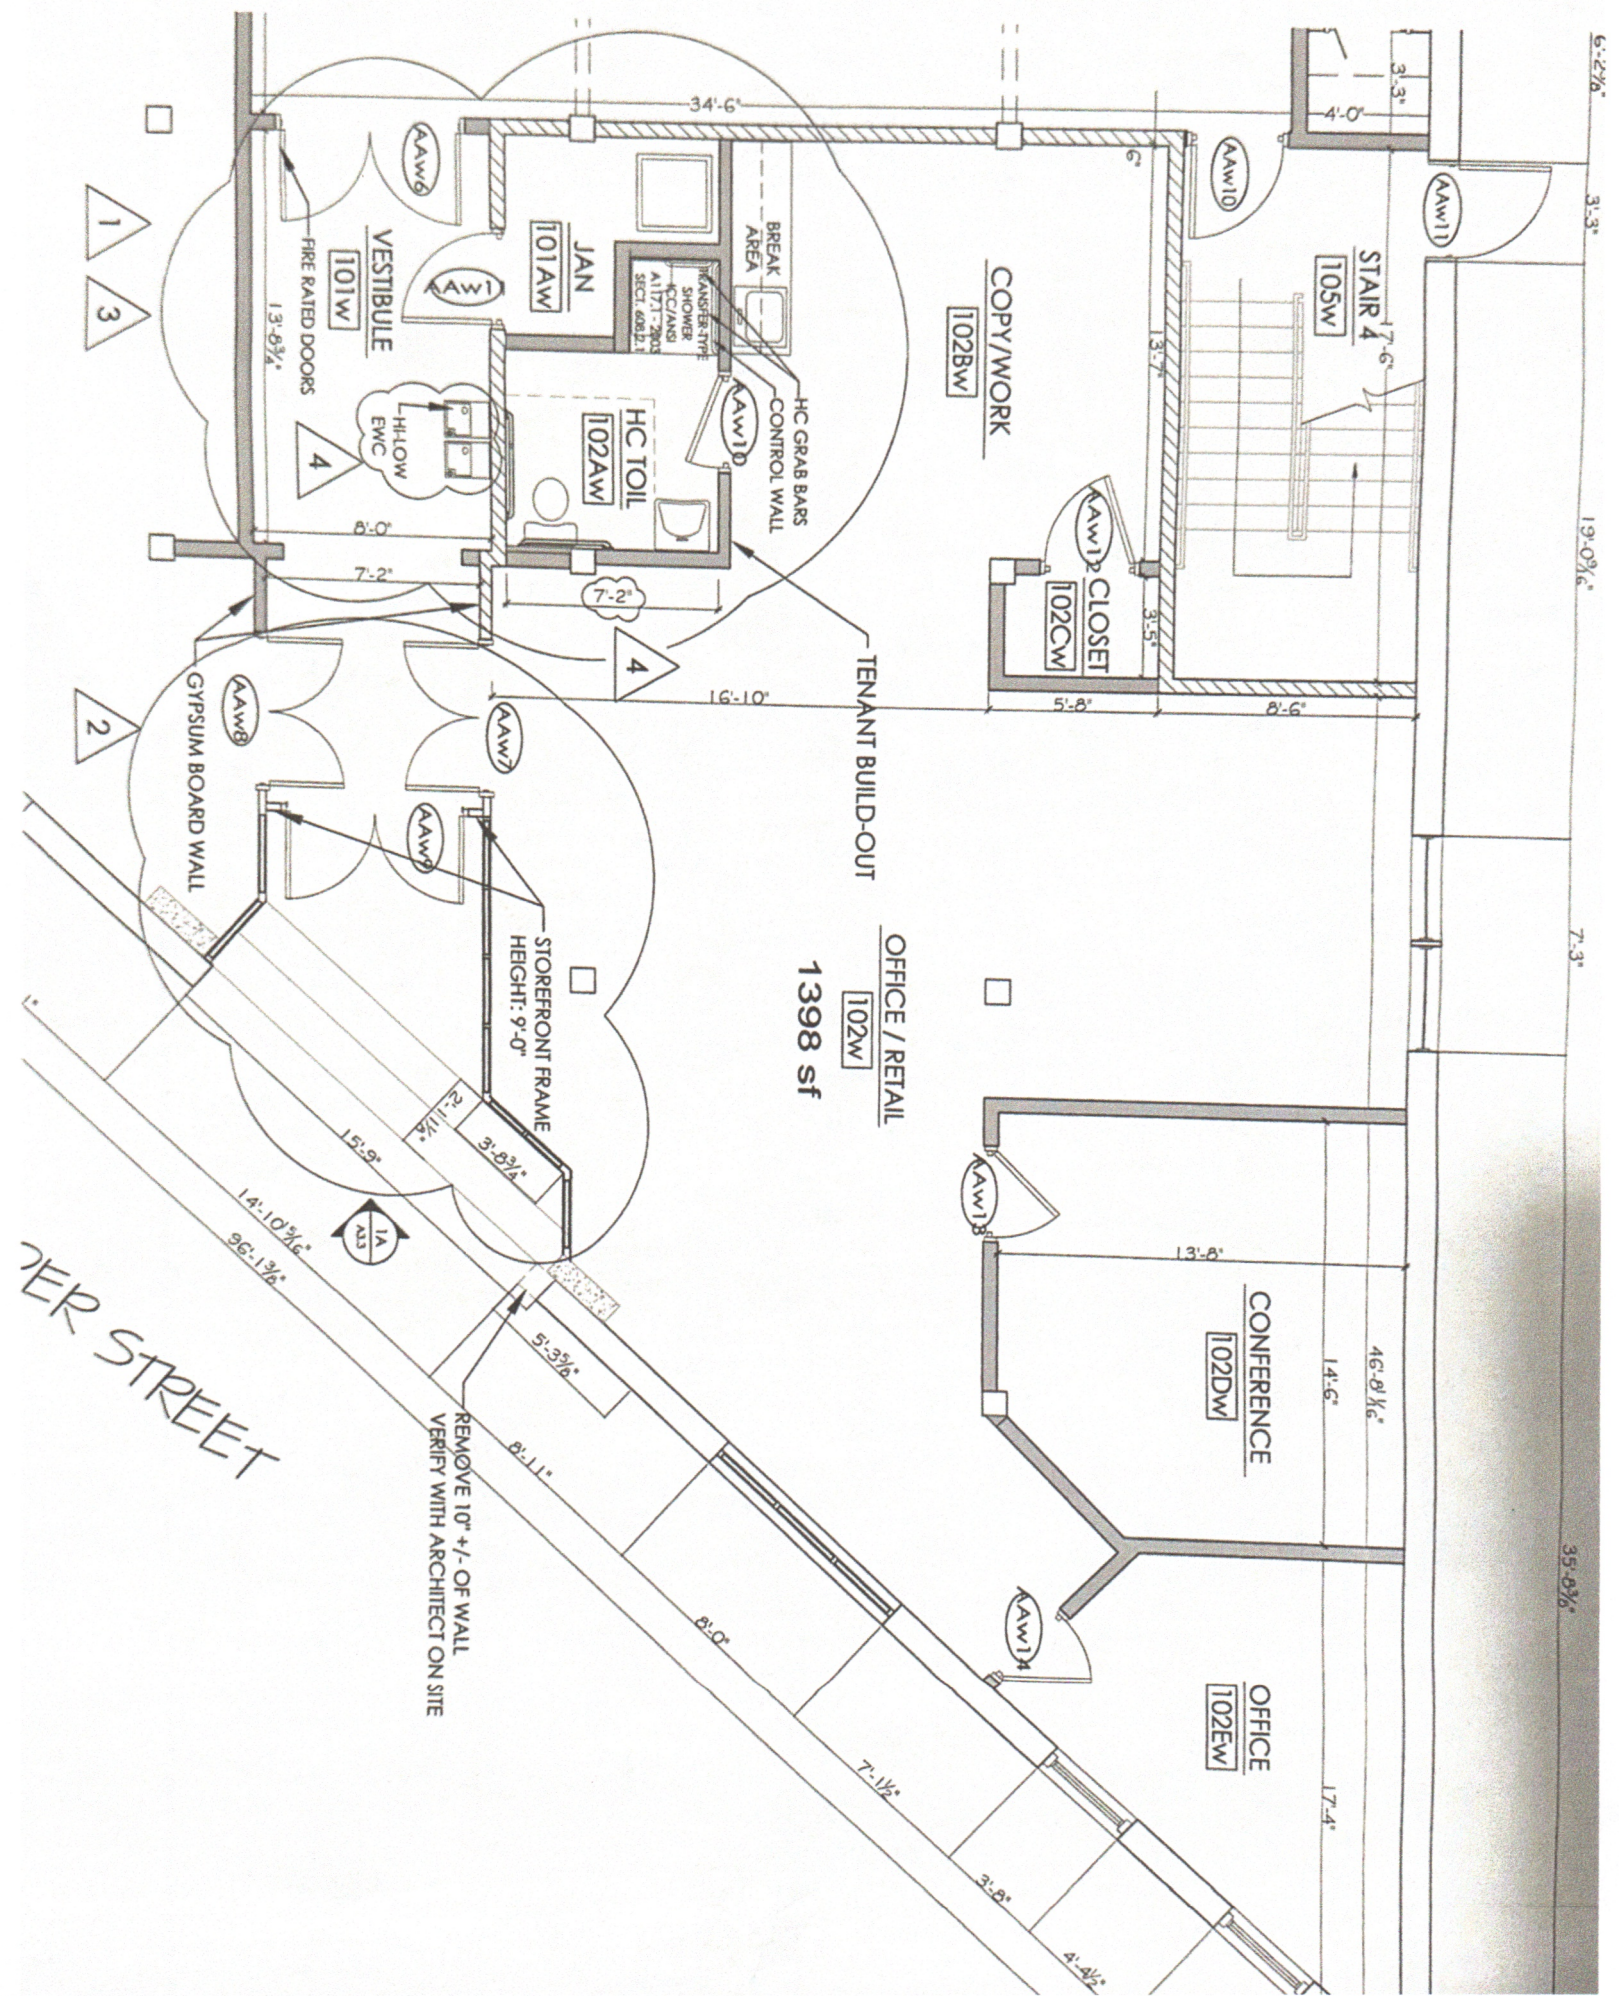

203 HULL STREET - KEY PLAN

- SCALE: 1/16" = 1' - 0"
- ELECTRICAL LEGEND**
- S LIGHT SWITCH AT 48" AFF
 - ⊕ DUPLEX RECEPTACLE AT 18" AFF UNLESS ABV COUNTER SURFACE
 - ▽ DATA / PHONE
 - ⊕ GROUND FAULT CIRCUIT INTERRUPTER
 - GFCI

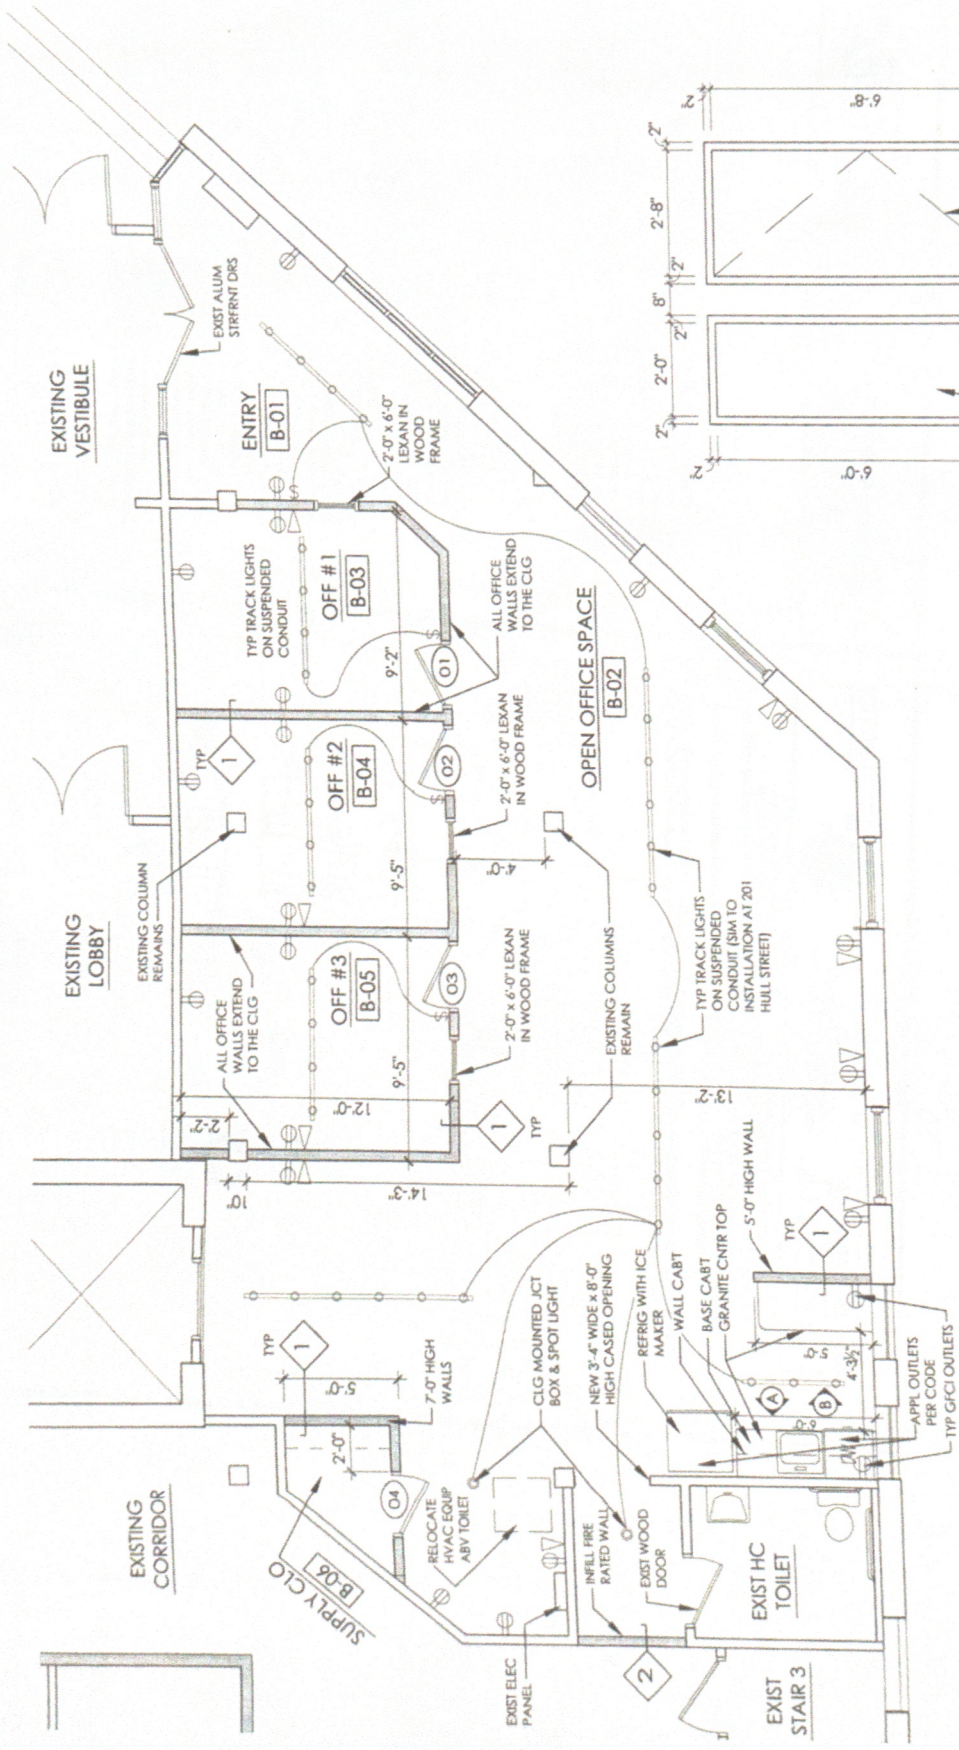


THIS DRAWING INDICATES LOCATION FOR OUTLETS AND LIGHTS IN SUITE 'B'. ELECTRICAL DESIGN DONE BY OTHERS

- GENERAL NOTES**
1. ACID WASH & SEAL CONCRETE FLOORS WITH (2) COATS OF REXTHANE
 2. PAINT ALL GYPSUM BOARD WALLS, CEILINGS, & TRIM WITH COLOR SELECTION BY TENANT - MAXIMUM (3) COLORS INCLUDING TRIM
 3. PROVIDE GRANITE COUNTER TOPS AT BREAK AREA



Door & Sidelite Elev

SCALE: 1/2" = 1' - 0"

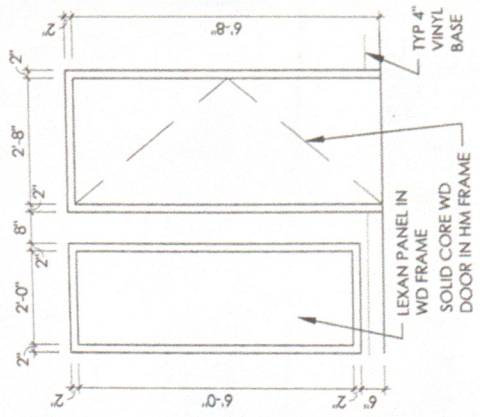

First Floor - Suite B

SCALE: 1/4" = 1' - 0"