


NO.	DATE	DESCRIPTION	BY
1	10/23/99	REVISED WATERLINE	abb
2	9/3/99	REVISED WATERLINE	abb
1	10/23/99	REVISED BUILDING NUMBER	abb
1	10/23/99	REVISED DESCRIPTION	abb
1	10/23/99	REVISED	abb

HOGGARD/EURE ASSOCIATES P.C.
 Surveyors/Planners/Engineers
 6006 CHARLTON BLVD, SUITE 200
 PORTSMOUTH, VIRGINIA 23703
 APPROVAL DATE: _____

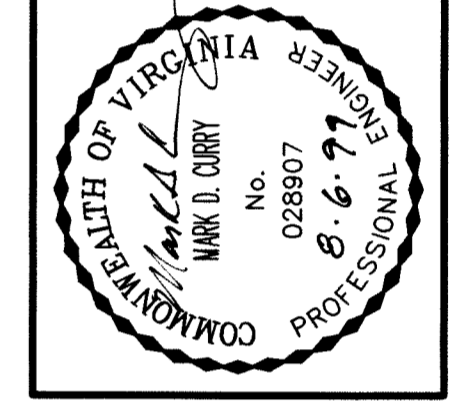

SITE PLAN (PHASE 1)
AIRLINE BUSINESS CENTER, PHASE I
 PORTSMOUTH, VIRGINIA
 TAX MAP NO. 0572 0010-0040, 0572 0090-0120, 0572 0140-0200, 0572 0210-0270, 0572 0211, 0572 0340-0380, 0573 0610-0640

PROJ. NO: 1656-98
 DATE: 9/9/98
 SCALE: 1" = 30'
 DESIGN: TAH
 DRAWN: berm

SHEET NO. **3**
 OF 7

305ITE-1.DWG 09/03/99
 STRPLAN-1.SCP PLOT DATE
 1656-98

MATCHLINE THIS SHEET

MATCHLINE THIS SHEET

Approximate location of 46x46 addition


Area to survey

NOTE: A1
 6"x6" COMBINATION METER TO BE INSTALLED BY CITY AT DEVELOPERS EXPENSE.

NOTE: PAVEMENT CUT AND PATCH, TRAFFIC CONTROL AND 6" DUCTILE IRON WATER PIPE TO METER SHALL BE DONE BY CONTRACTOR.

CONTRACTOR TO VERIFY LOCATION OF EXIST. WATER MAIN PRIOR TO CONSTRUCTION

THE CITY ENGINEER INSPECTOR MAY ADJUST THE LOCATION OF THE PROPOSED CURB & GUTTER ALONG AIRLINE BOULEVARD, 1'±, TO ENSURE PROPER ALIGNMENT WITH EXISTING/PROPOSED CURBING AND DRIVE LANES.

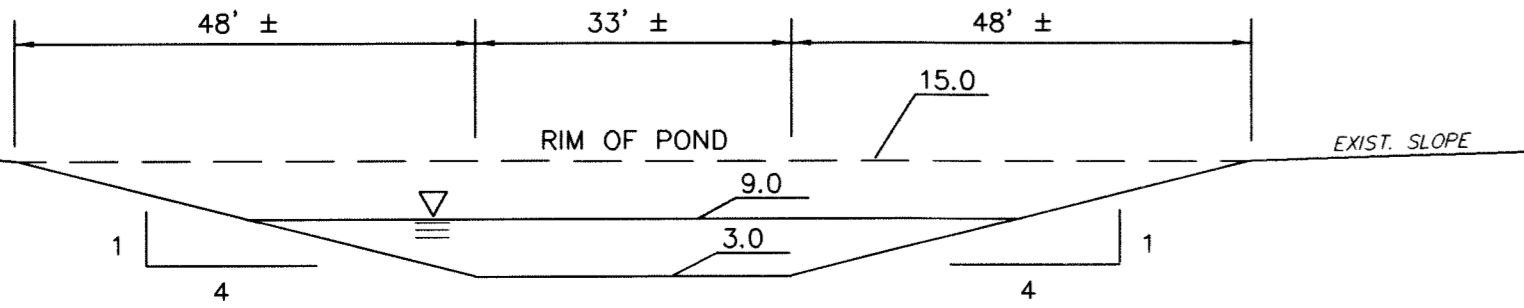

SECTION A-A
 NOT TO SCALE

BROAD CRESTED WEIR
 NOT TO SCALE