

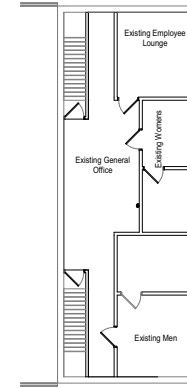


1 LEVEL 1 FLOOR PLAN
SCALE: 1/8" = 1'-0"

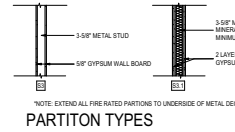


2 EXISTING 2nd FLOOR PLAN - NO WORK
SCALE: 1/8" = 1'-0"

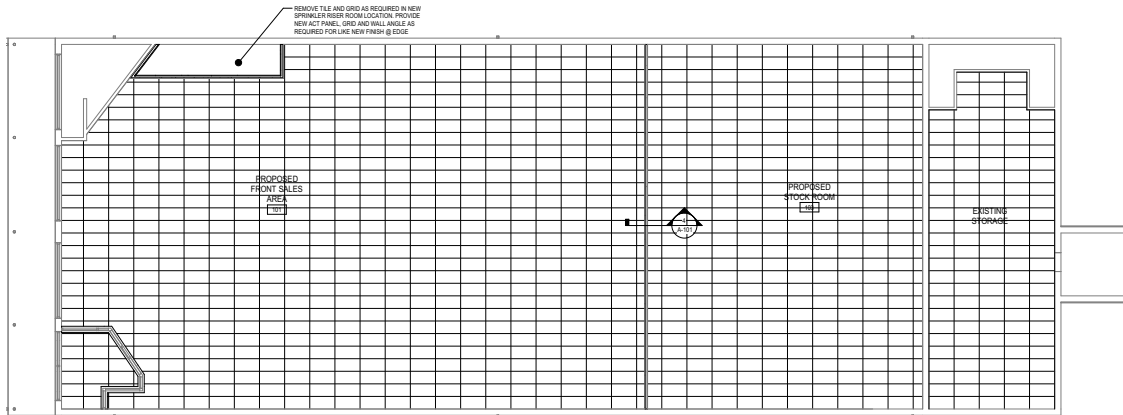

3 FIRST FLOOR REFLECTED CEILING PLAN
SCALE: 1/8" = 1'-0"

GENERAL NOTES:
1. EXISTING CEILING TO REMAIN - MODIFY AS REQUIRED TO ACCOMMODATE NEW CONSTRUCTION (TYP)
2. EXISTING LIGHT FIXTURES TO REMAIN

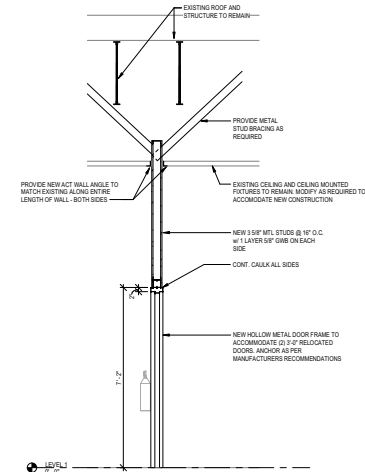

4 WALL SECTION
SCALE: 1/2" = 1'-0"

BUCHART HORN ARCHITECTS

Project Name: Existing Building Renovation for KeyStone Fireworks

Location: 651 Carey Avenue, Warrington, PA, 18980, Lancaster County

Project Number: 77249-00

Drawing Title: LEVEL 1 FLOOR PLAN

Sheet No: A-101

NOT FOR CONSTRUCTION