


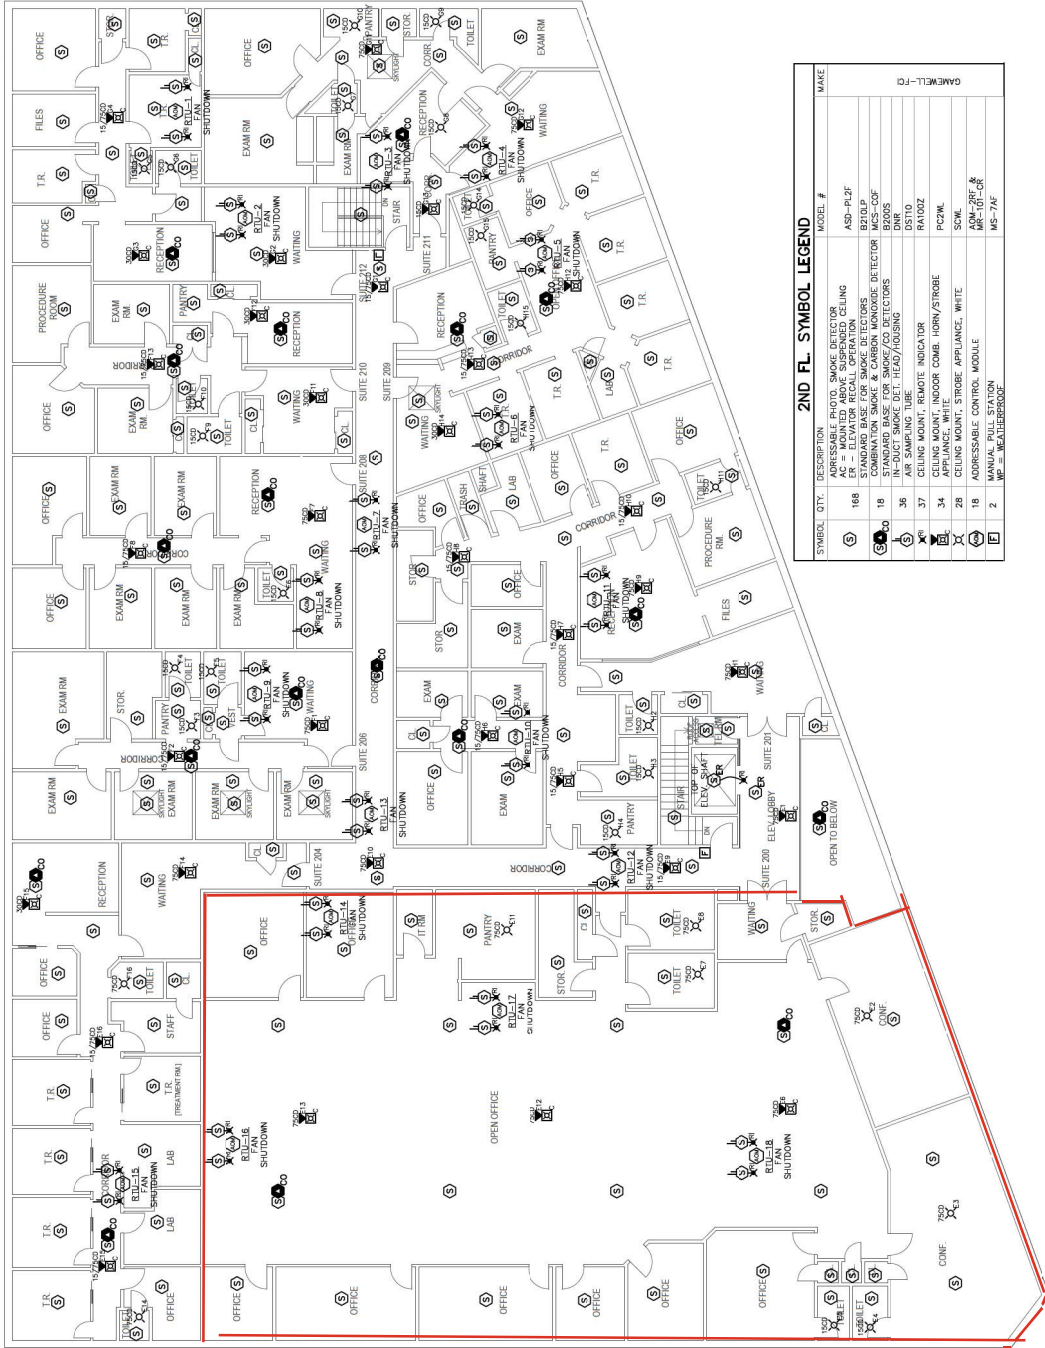

2ND FLOOR PLAN
SCALE: 1/8"=1'-0"

2ND FL SYMBOL LEGEND

SYMBOL	QTY.	DESCRIPTION	MODEL #	MAKE
(S)	168	ADDRESSABLE PHOTO SMOKE DETECTOR	ASD-PL2F	GAMMELL-FC
(E)	18	PR - ELEVATOR RECALL OPERATION	PR-PL2F	GAMMELL-FC
(D)	18	STANDARD BASE FOR SMOKE DETECTOR	BD-PL2F	GAMMELL-FC
(B)	18	STANDARD BASE FOR SMOKE DETECTOR	BD-PL2F	GAMMELL-FC
(I)	36	STANDARD BASE FOR SMOKE DETECTOR	BD-PL2F	GAMMELL-FC
(H)	36	IN-DUCT SMOKE DET. HEAD/HOUSING	DNK	GAMMELL-FC
(C)	37	CEILING MOUNT, REMOTE INDICATOR	RAI02Z	GAMMELL-FC
(M)	34	CEILING MOUNT, INDOOR COMB. HORN/STROBE	PC2ML	GAMMELL-FC
(A)	28	APPLIANCE, WHITE	APPL-PL2F	GAMMELL-FC
(S)	18	ADDRESSABLE CONTROL MODULE	MS-7AF	GAMMELL-FC
(F)	2	MANUAL FIRE ALARM PULL STATION	MP-101-OR	GAMMELL-FC

PROGRESSIVE MANAGEMENT OF NY CORP
1044 NORTHERN BLVD., 2ND FLOOR
ROSLYN, NEW YORK 11576

Advance
Design Group, Inc.
3375 PARK AVE.
SUITE 3004A
WANTAGH, N.Y. 11073
Tel: 718-761-1234
Fax: 718-761-1235
Email: info@advance.com

1800 ROCKAWAY AVE
HEWLETT, NY 11557

SECTION: 39 BLOCK: 86 LOT: 11

SECOND FLOOR
FIRE ALARM PLAN

DATE: 05.01.18
DRAWN BY: 18018
CHECKED BY: 18018
SCALE: AS SHOWN
SHEET NO: 5 OF 5

THIS PLAN IS APPROVED ONLY FOR WORK INDICATED ON THE APPLICATION
SPECIFICATION SHEET. ALL OTHER MATTERS SHOWN ARE NOT TO BE
CONSIDERED AS PART OF THE DESIGN. THE DESIGNER ASSUMES NO
RESPONSIBILITY FOR THE ACCURACY OF THE INFORMATION PROVIDED
HEREIN. THIS DESIGN IS PRELIMINARY AND MAY CHANGE DUE TO FIELD CONDITIONS.