


PARKCHESTER UNIT No. 1  
PLAT BOOK 18, PAGE 114

- LEGEND:  
 -EXISTING GRADE  
 -NEW FINISHED GRADE  
 -INDICATES DRAINAGE FLOW  
 -INDICATES FINISHED GRADE

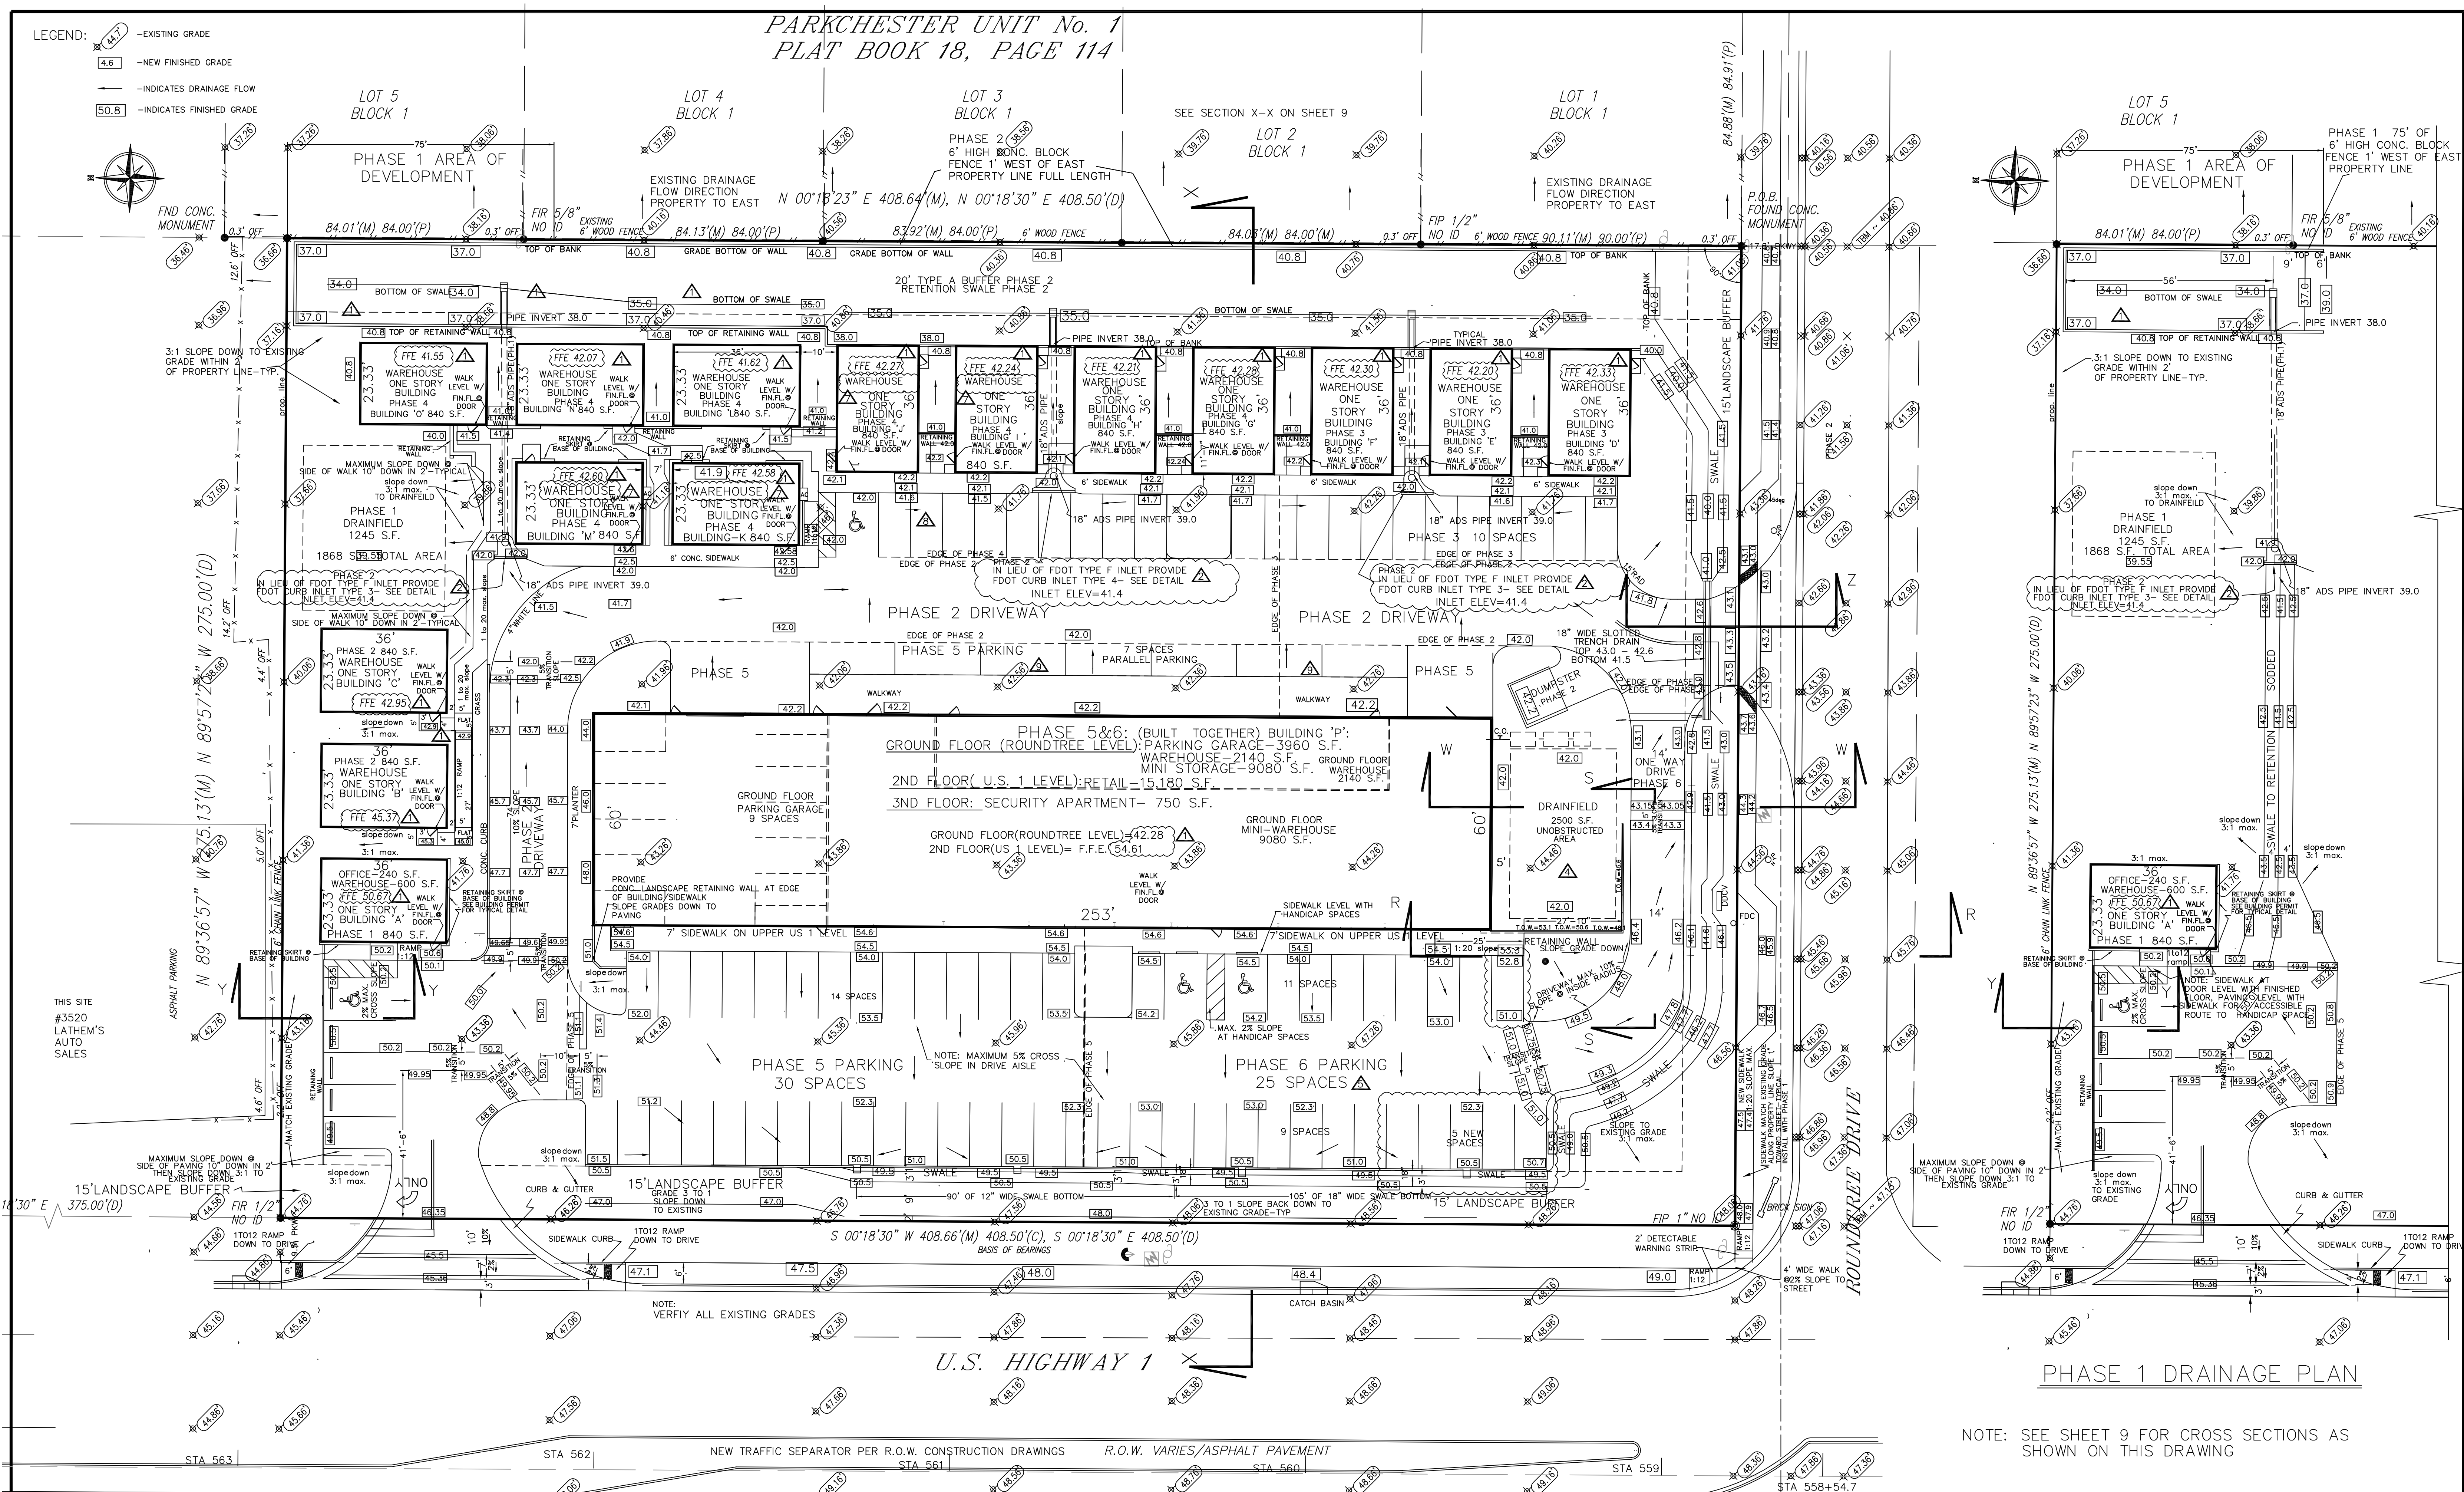

REVISIONS		
10-20-14 COMMENTS	6-24-15 ENGINEERING REVISION NO.1	10-22-18 ENGINEERING REVISION NO.3
12-26-14	7-20-15 FDOT	12-28-16 ENGINEERING REVISION 2 COMMENTS
1-22-15	9-15-15 FDOT	11-23-16 ENGINEERING REVISION 2
2-16-15	10-13-15 FDOT	12-5-18 ENGINEERING REVISION 3 COMMENTS
		12-28-18 ENGINEERING REVISION 3 COMMENTS BLD 'A' RETAINING SKIRT WALL NOTE

SCALE 1"=20'

JOB NUMBER:1406

DATE:4-14-14

DRAINAGE PLAN FOR  
 US 1 BUSINESS CENTER  
 COCOA, FLORIDA

WILLIAM H. STEPHENSON P.E.  
 1207 WINDING MEADOW ROAD, ROCKLEDGE, FL 32955  
 (321) 961-6182 P.E. NO. 21639