



DATE: 01/02/23

REVISIONS:		
NO.	DESCRIPTION	DATE
1	CITY REV.	02/14/23

REVIEWED BY: Checker

DRAWN BY: Author

DATE: 01/02/23

PROJECT NO. 22-089

SHEET TITLE


LEVEL 2 RCP

SHEET:

A2.7

LIGHTING LEGEND	
DESCRIPTION	
<div>WALL SCANCE (A)</div>	WALL SCANCE
<div>ACCENT LIGHT (O)</div>	YARD ACCENT LIGHT
<div>RECESS CAN (C)</div>	RECESS CAN LIGHT
<div>(O)</div>	PENDANT LIGHT
<div>(2x4)</div>	2'X4' FLUORESCENT
<div>(EF)</div>	EXHAUST FAN
<div>(2x2)</div>	2'X2' FLUORESCENT
<div>(EXIT)</div>	EXIT SIGN
<div>(H)</div>	EMERGENCY EGRESS
<div>(DRYWALL)</div>	DRYWALL CEILING
<div>(6x48)</div>	6'X48" WALL LIGHT
<div>(K)</div>	400 WATT HALIDE LAMP
<div>(E)</div>	EMERGENCY LIGHT
<div>(E)</div>	1'X4' LED SURFACE MOUNTED
<div>(VL)</div>	VANITY LIGHT
<div>(P)</div>	PENDANT LIGHT

LIGHTING LEGEND
1/4" = 1'-0"

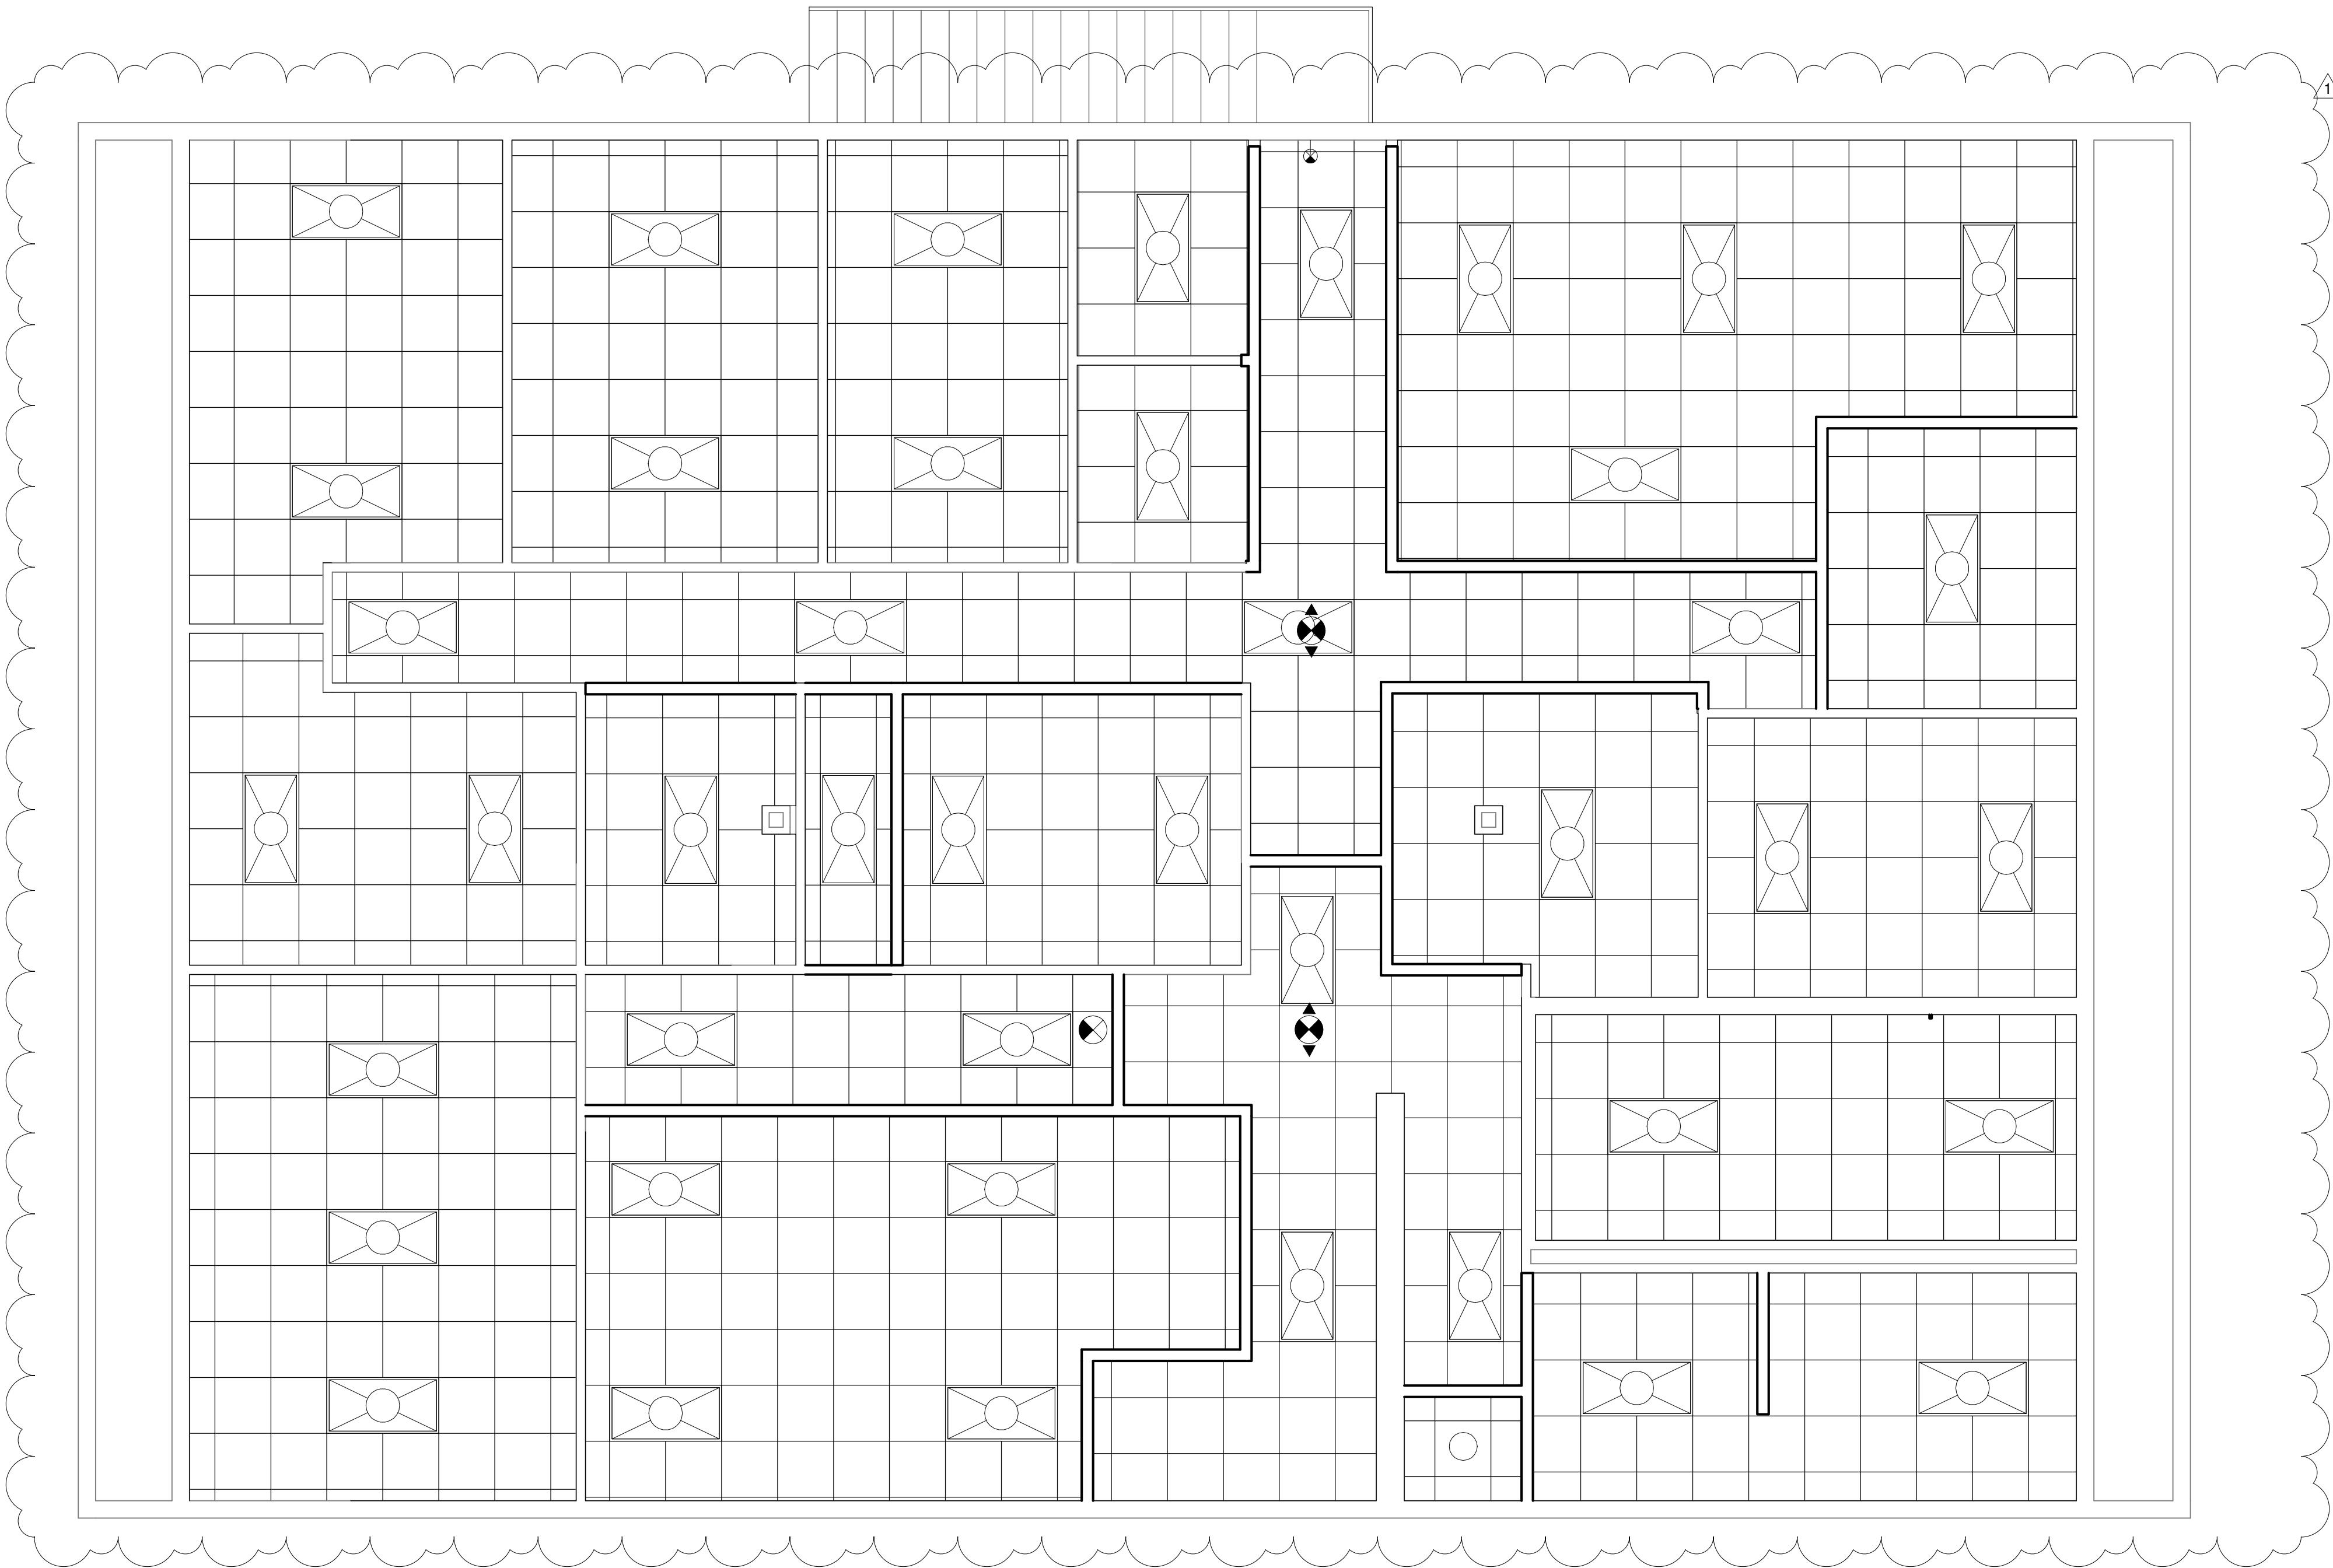

1 LEVEL 2 NEW PLAN
1/4" = 1'-0"

Lighting Fixture Schedule			
Type	Model	Elevation from Level	Count
2'x4'(2 Lamp) - 120V			87
4' 1 Lamp - 120		9'- 0"	2
6" Incandescent - 120V		9'- 0"	3
150W - 277V		9'- 0"	3
LED15FM12-W120			2