

LOWER BUILT-IN CAB	AA ATTIC ACCESS	GFF GARAGE FINISH FLOOR
UPPER BUILT-IN CAB	AC ASPHALT CONCRETE	H HEIGHT
FULL HEIGHT BUILT-IN CAB	BOJ BOTTOM OF BEAM	HDR HEADER
CEILING SOFFIT LINE	CAB CABINETS	HH HEADER HEIGHT
BEAM	CLG CABINETS	OC ON CENTER
THOROUGH SURVEY BOUNDARY	CONC CONCRETE	MECH MECHANICAL
EXISTING FULL HEIGHT WALL	CLG CABINETS	MISC MISCELLANEOUS
EXISTING LOW WALL	DW DISH WASHER	REF REFRIGERATOR
INFERRED WALL LOCATION	DN DOWN	RUD ROLL-UP DOOR
NO DATA / OUT OF SCOPE	ELEV ELEVATION	SD SLIDING DOOR
	EQ EQUIPMENT	TC TRASH COMPACTOR
	EW EYE WASH	TH THRESHOLD
	FRZ FINISH FLOOR	TYP TYPICAL
		WH WATER HEATER
		WF WATER FEATURE



ELECTRICAL METER	CD CARBON MONOXIDE DETECTOR	SPRINKLER
ELECTRICAL PANEL (FLUSH)	CD CARBON MONOXIDE DETECTOR - WALL	SPRINKLER - WALL
ELECTRICAL PANEL (SURFACE)	EL EMERGENCY LIGHT	SMOKE DETECTOR
FLOOR DRAIN	FA FIRE ALARM CONTROL	SMOKE DETECTOR - WALL
FLOOR RETURN VENT	FA FIRE ALARM UNIT	PULL SWITCH
FLOOR SUPPLY VENT	FE FIRE EXTINGUISHER	WINDOW MARK
GAS METER	FE FIRE EXTINGUISHER (RECESSED)	DOOR MARK
WATER FOUNTAIN	HD HEAT DETECTOR	
WALL HEATER	HD HEAT DETECTOR - WALL	

CD CARBON MONOXIDE DETECTOR	SPRINKLER
CD CARBON MONOXIDE DETECTOR - WALL	SPRINKLER - WALL
EL EMERGENCY LIGHT	SMOKE DETECTOR
FA FIRE ALARM CONTROL	SMOKE DETECTOR - WALL
FA FIRE ALARM UNIT	PULL SWITCH
FE FIRE EXTINGUISHER	WINDOW MARK
FE FIRE EXTINGUISHER (RECESSED)	DOOR MARK
HD HEAT DETECTOR	
HD HEAT DETECTOR - WALL	

SPRINKLER	SPRINKLER - WALL
SMOKE DETECTOR	SMOKE DETECTOR - WALL
PULL SWITCH	WINDOW MARK
WINDOW MARK	DOOR MARK

WINDOW NOTE	HEADER HEIGHT(##") AS MEASURED FROM EXISTING INTERIOR WINDOW FRAME RELATIVE TO NEAREST FINISHED FLOOR.
HH: ##	WIDTH(XX") x HEIGHT(YY") AS MEASURED FROM EXISTING INTERIOR WINDOW FRAME.
XXxYY	

*LIMITED DATA ACQUIRED, DIMENSIONS INFERRED.

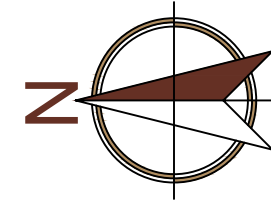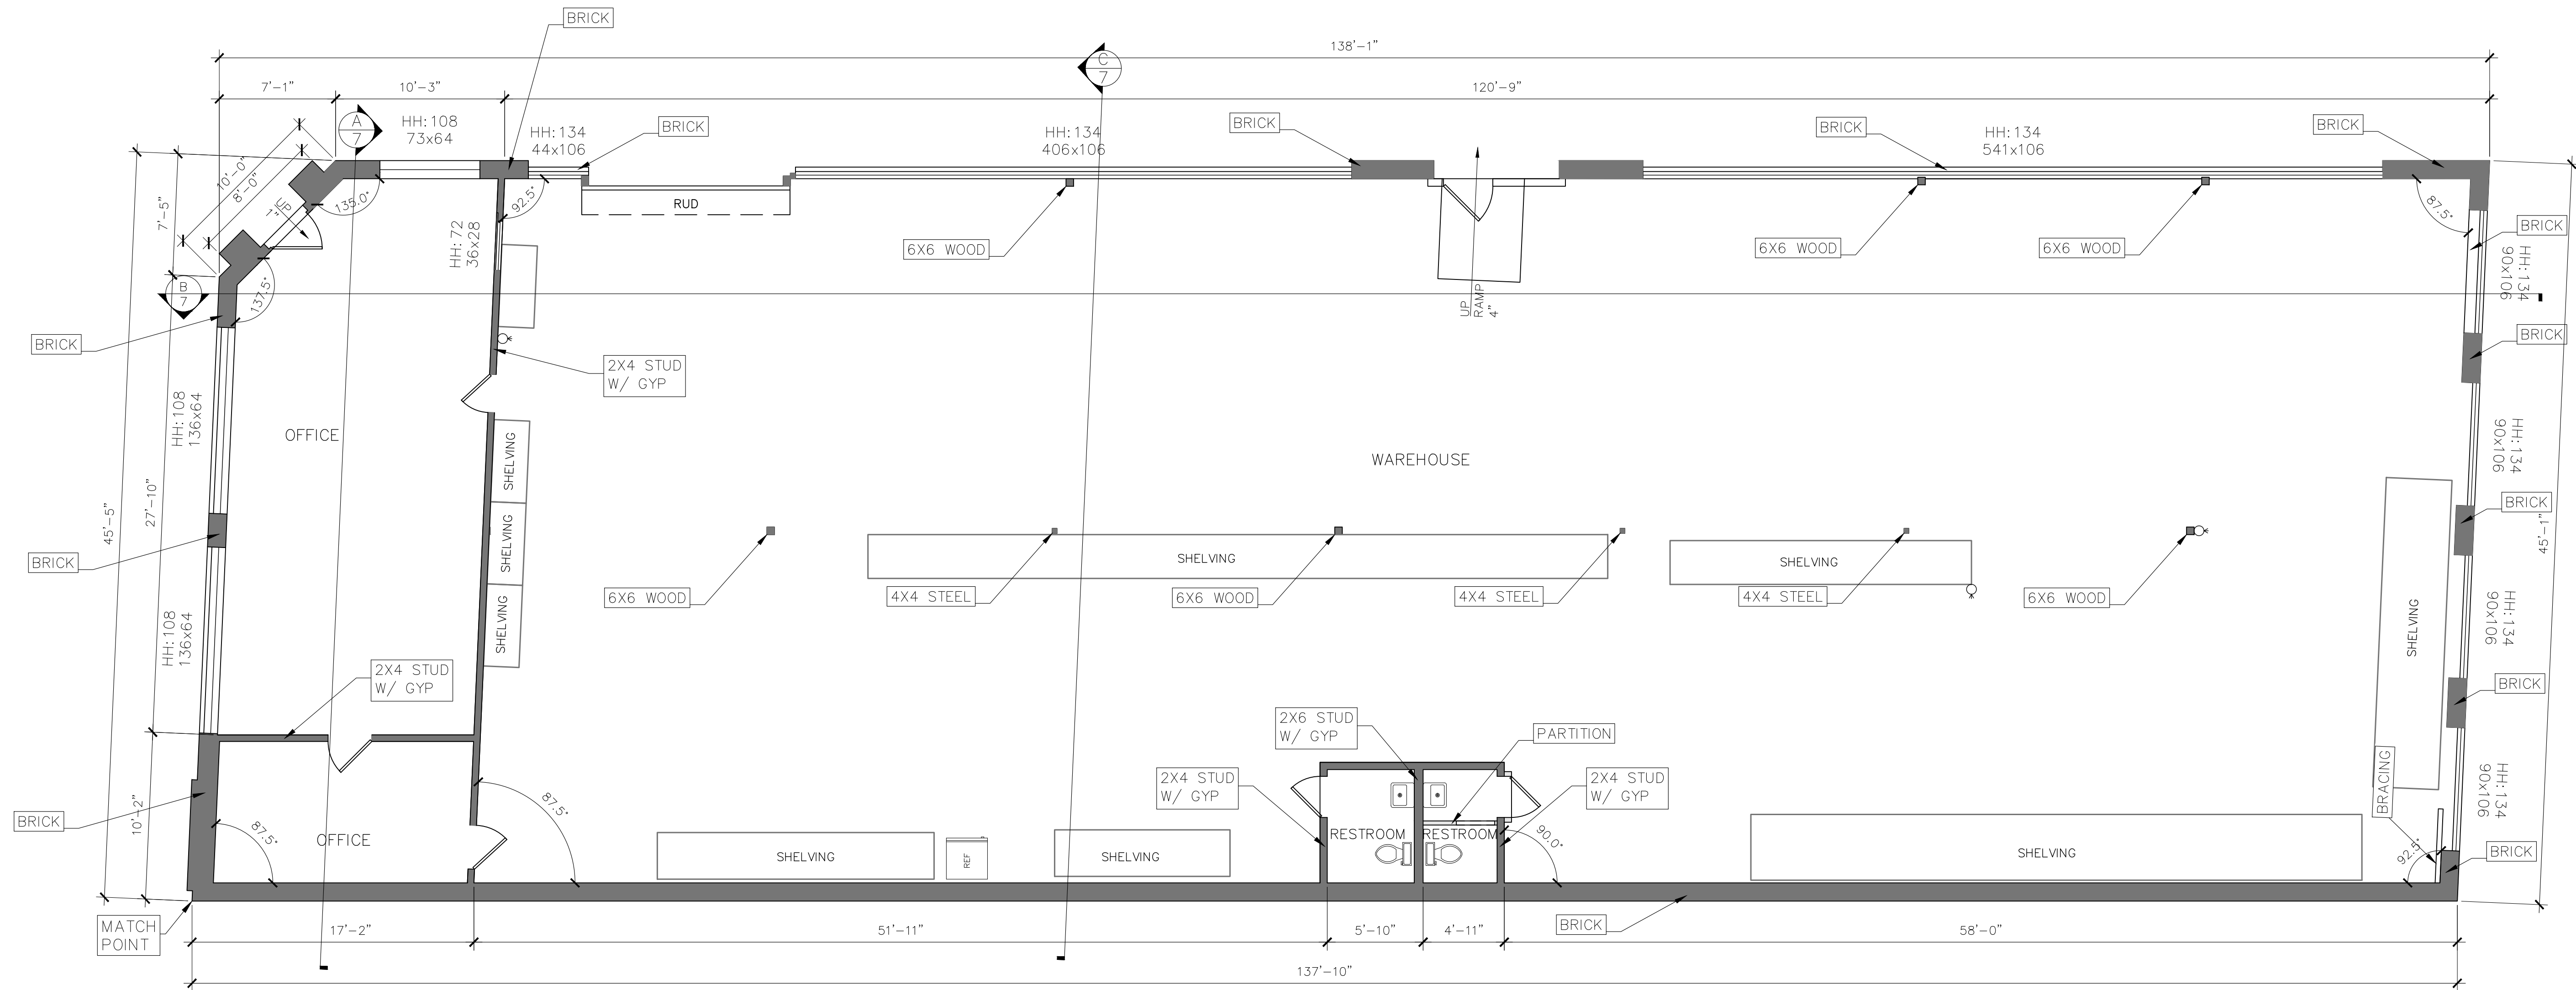

NO.	REVISION	DATE
1		
2		
3		
4		

CLIENT PROJECT NO.	22368
REVIEWED BY	S.M.
FIELD DATE	1/21/2023
SCALE	3/16" = 1'-0"
SHEET	2 / 8

2266 E 38TH ST RESIDENCE

2266 E 38TH ST
VERNON, CA 90058



PREPARED FOR

HOWARD HAMLIN
562-537-5840
HOWARD@HAMLINGOODING.COM

No plans produced by Apex As-Built "AAB" involve the determination of any property line, nor do they constitute a survey. They are not to be used for any purpose other than the specific purpose for which they were prepared. All plans created by Apex As-Built "AAB" are to be used as a guide only and should not be considered a substitute for the services of a professional structural engineer or licensed architect.

LEGEND

- BUILDING FOOTPRINT
- CHIMNEY
- PLATFORM
- DUCT
- CONDUIT
- PIPE
- GUTTER
- DRAIN
- PLUMBING VENT
- SKYLIGHT
- VENT
- ELECTRICAL PANEL
- MISC EQUIPMENT
- CONDUIT CONNECTION

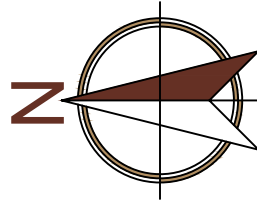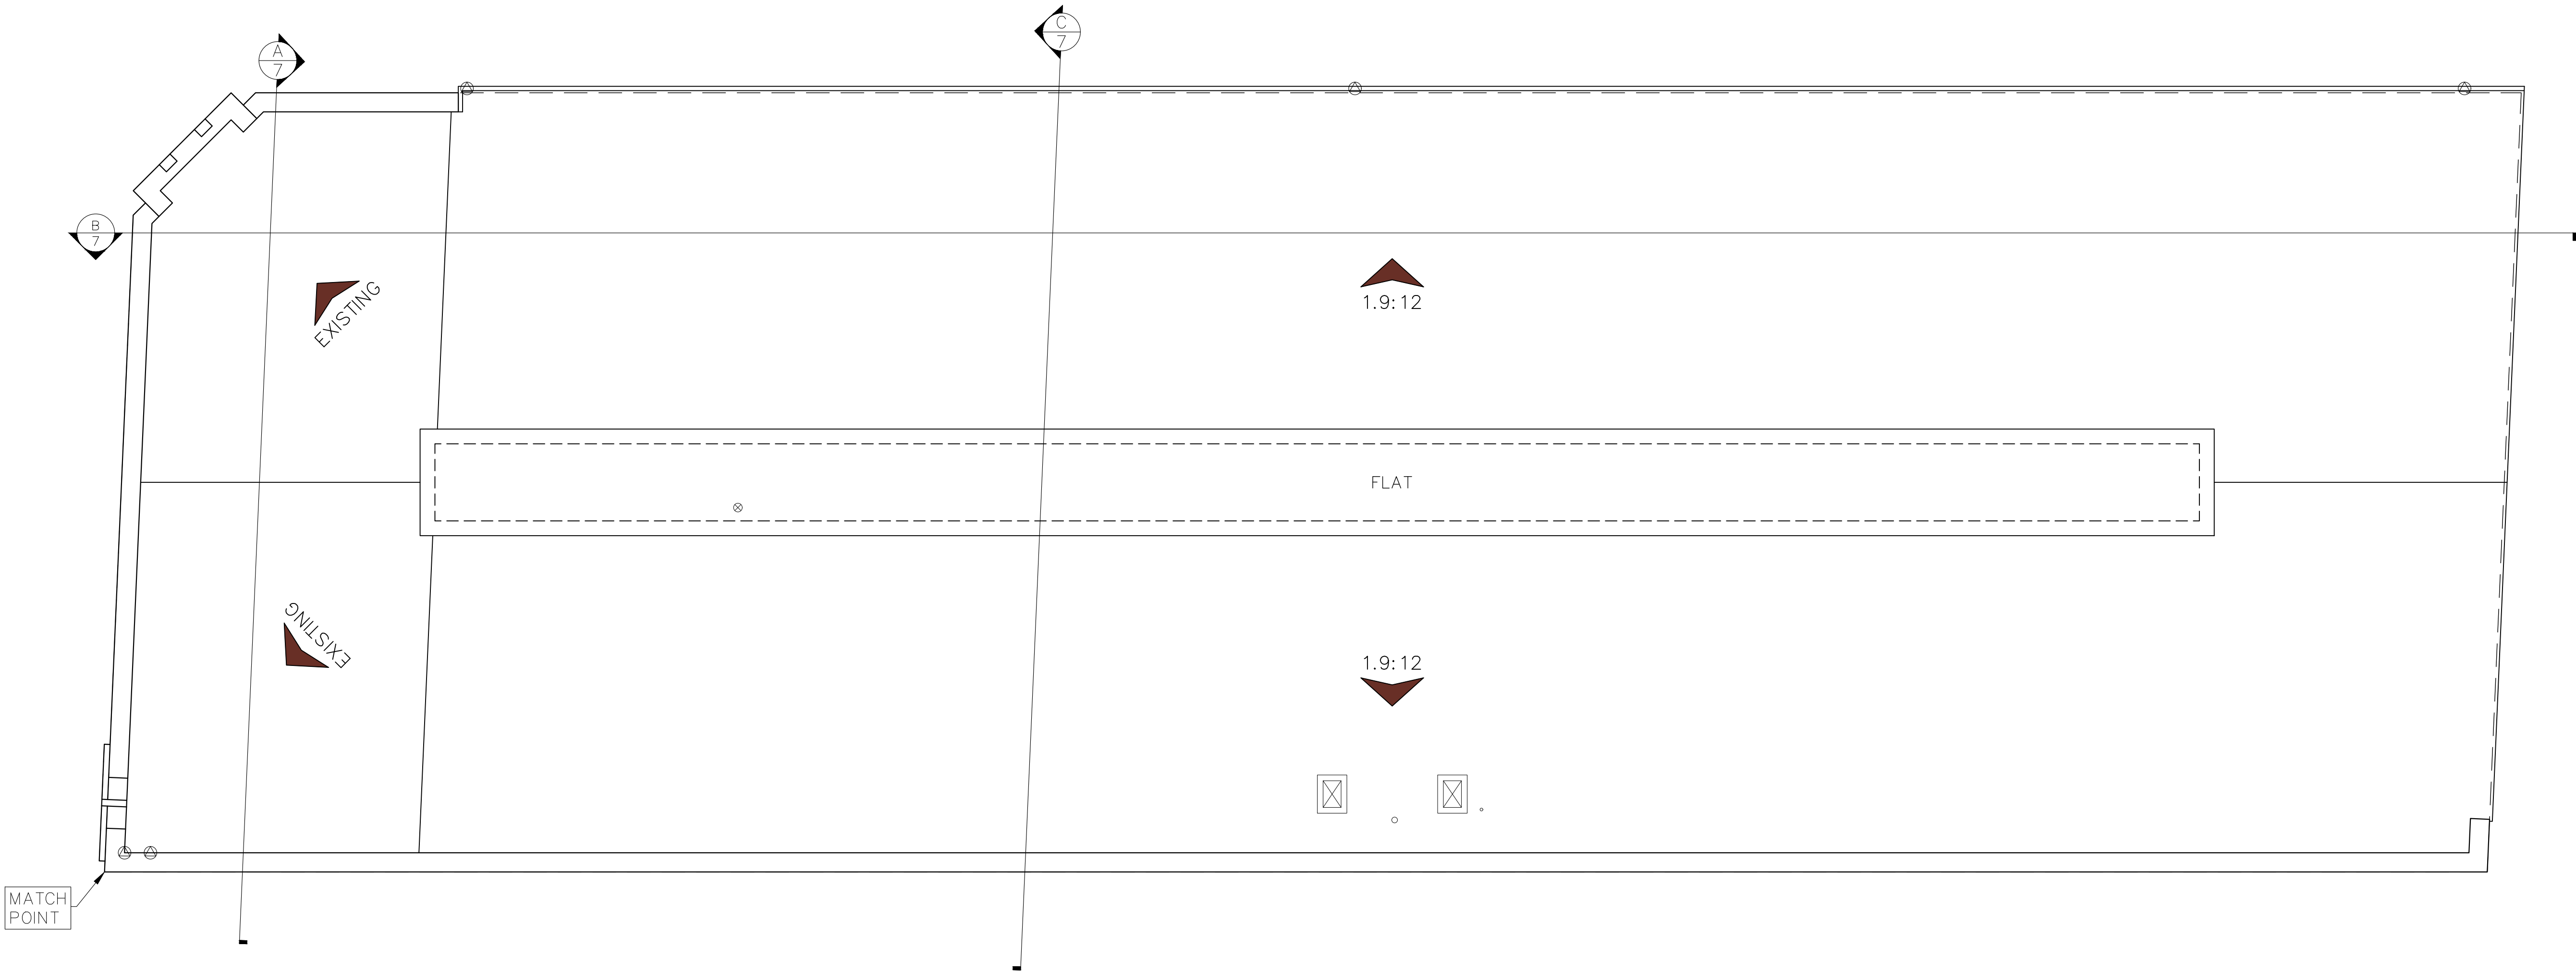

2266 E 38TH ST RESIDENCE

ROOF PLAN

PROJECT ADDRESS
2266 E 38TH ST
VERNON, CA 90058

PREPARED FOR
HOWARD HAMLIN
562-537-5840
HOWARD@HAMLINGOODING.COM

NO.	REVISION	DATE
1		
2		
3		
4		

CLIENT PROJECT NO.
22368

REVIEWED BY
S.M.

FIELD DATE
1/21/2023


SCALE
3/16" = 1'-0"

SHEET
3 / 8



No plans produced by Apex As-Builtz "AAB" involve the determination of any property line, nor do they constitute a survey. They are not to be used for any purpose other than the intended purpose of the project. All plans created by AAB are to be used as a guide only and should not be considered a substitute for the services of a licensed structural engineer or licensed architect.



235 E BROADWAY, SUITE 1040
VERNON, CA 90058
TEL: 562-537-5840
FAX: 562-537-5841
WEB: OFFICE@APEXAB.COM
PHONE: 562-443-7337

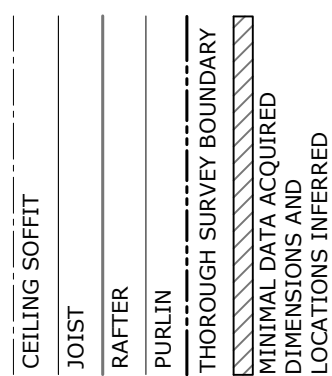

*NOTE: FRAMING SHOWN FOR VISUAL REFERENCE ONLY

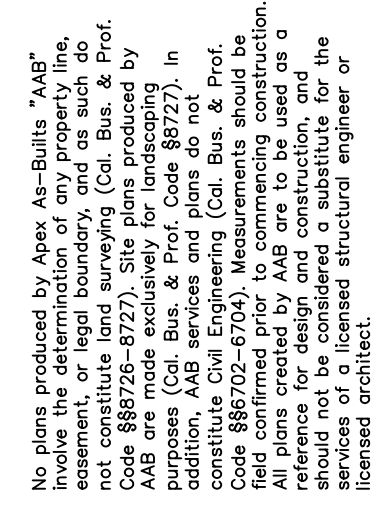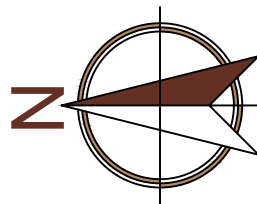

PROJECT ADDRESS

2266 E 38TH ST
VERNON, CA 90058

2266 E 38TH ST RESIDENCE

ROOF FRAMING PLAN

NO.	REVISION	DATE
1		
2		
3		
4		

CLIENT PROJECT NO.
22368

REVIEWED BY
S.M.

FIELD DATE
1/21/2023

SCALE
3/16" = 1'-0"

SHEET

4 / 8



No plans produced by Apex As-Built's "AAB" involve the determination of any property line, easement, or legal boundary, and as such do not constitute land surveying (Col. Bus. & Prof. Code §88726-8727). The plans produced by AAB are made exclusively for landscaping purposes (Col. Bus. & Prof. Code §8727). In addition, AAB services and plans do not constitute Civil Engineering (Col. Bus. & Prof. Code §86702-6704). Measurements should be field confirmed prior to commencing construction. All plans created by AAB are to be used as a reference for design and construction, and should not be considered a substitute for the services of a licensed structural engineer or

PREPARED FOR
HOWARD HAMLIN
562-537-5840
HOWARD@HAMLINGOODING.COM

PROJECT ADDRESS

2266 E 38TH ST
VERNON, CA 90058

REFLECTED CEILING PLAN

NO.	REVISION	DATE
1		
2		
3		
4		

CLIENT PROJECT NO. 22368

REVIEWED BY


S.M.

FIELD DATE
1/21/2023

SCALE
 $3/16" = 1'-0"$


SHEET

5 / 8

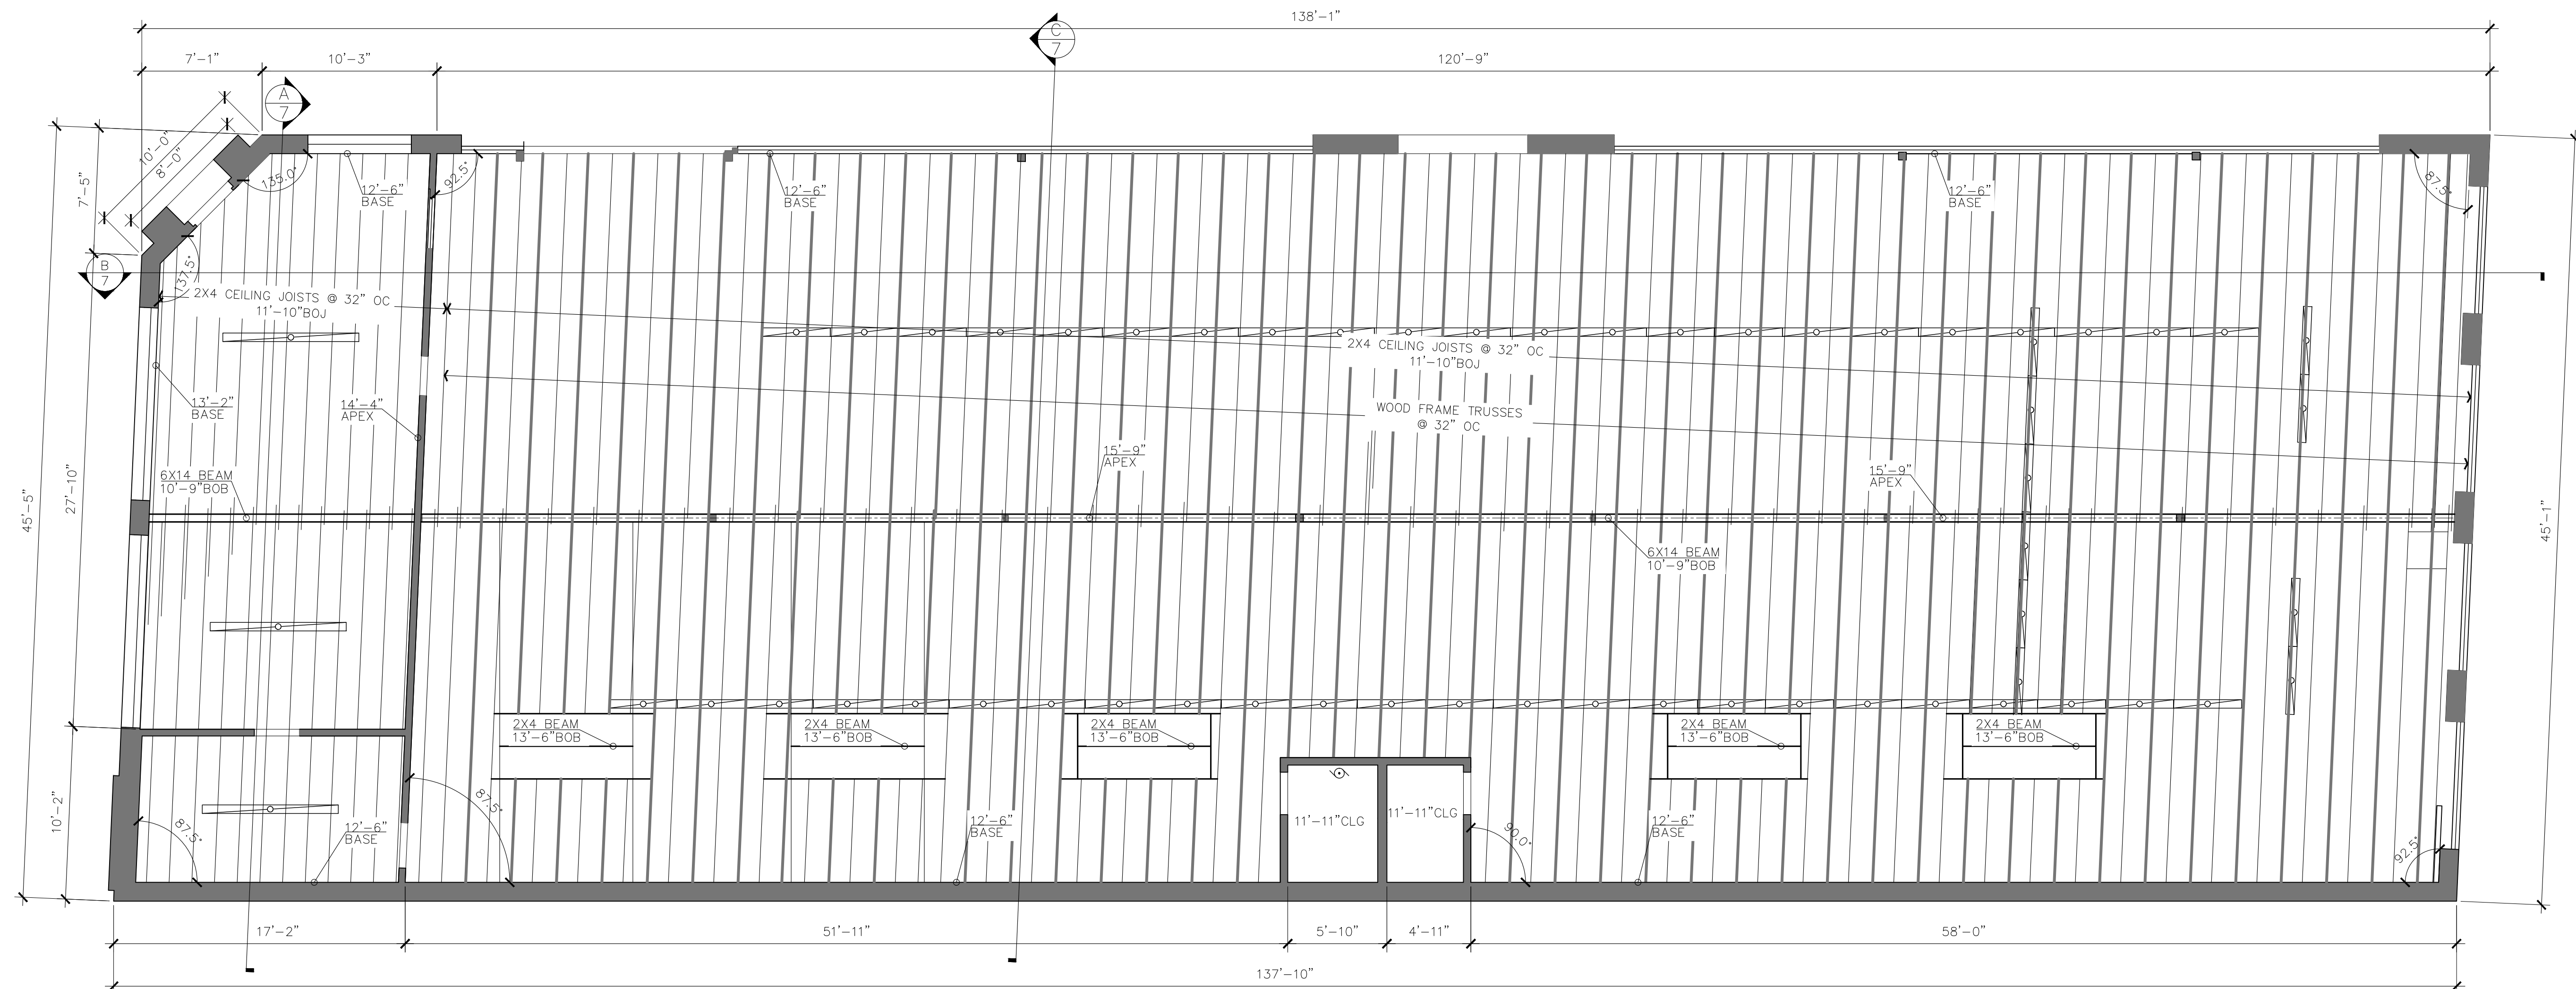[illegible]

LEGEND

AD	AUTOMATIC DOOR	⊕	SINGLE OUTLET	⊕	WALL MOUNTED FIXTURE	◁	TELEPHONE	⊕	CARBON MONOXIDE DETECTOR
D	DIM	⊕	DUPLEX OUTLET	⊕	FLUORESCENT LIGHT - WALL	▲	ETHERNET/INTERNET	⊕	EMERGENCY LIGHT
EQ	EQUIPMENT	⊕	QUADRAPLEX OUTLET	⊕	TRACK LIGHT - WALL	⊕	TV/CABLE AUX	⊕	FIRE ALARM CONTROL
G	GARAGE DOOR	⊕	FLOOR DUPLEX	⊕	WALL MOUNTED SPEAKER	⊕	KEYPAD	⊕	FIRE ALARM UNIT
KS	KEY SWITCH	⊕	FLOOR QUADRAPLEX	⊕	EXTERIOR WALL MOUNTED LIGHT	⊕	COVER PLATE	⊕	FIRE EXTINGUISHER
P	PILOT LIGHT	⊕	SWITCH W/ ATTRIBUTE	⊕	DOME SECURITY CAMERA	⊕	THERMOSTAT SENSOR	⊕	PULL SWITCH
M	MOTION SENSOR	⊕	ELECTRICAL PANEL (SURFACE)	⊕	WALL MOUNTED SECURITY CAMERA	⊕	MOTION SENSOR	⊕	SMOKE DETECTOR - WALL
SS	SAFETY SWITCH	⊕	ELECTRICAL PANEL (FLUSH)	⊕	WALL MOUNTED SECURITY CAMERA	⊕	INTERCOM	⊕	
XFMR	TRANSFORMER	⊕	ALARM CONTROL PANEL	⊕	ELECTRICAL PANEL (FLUSH)	⊕	EQUIPMENT MISC.	⊕	
		⊕		⊕		⊕	AUDIO VOLUME CONTROL	⊕	

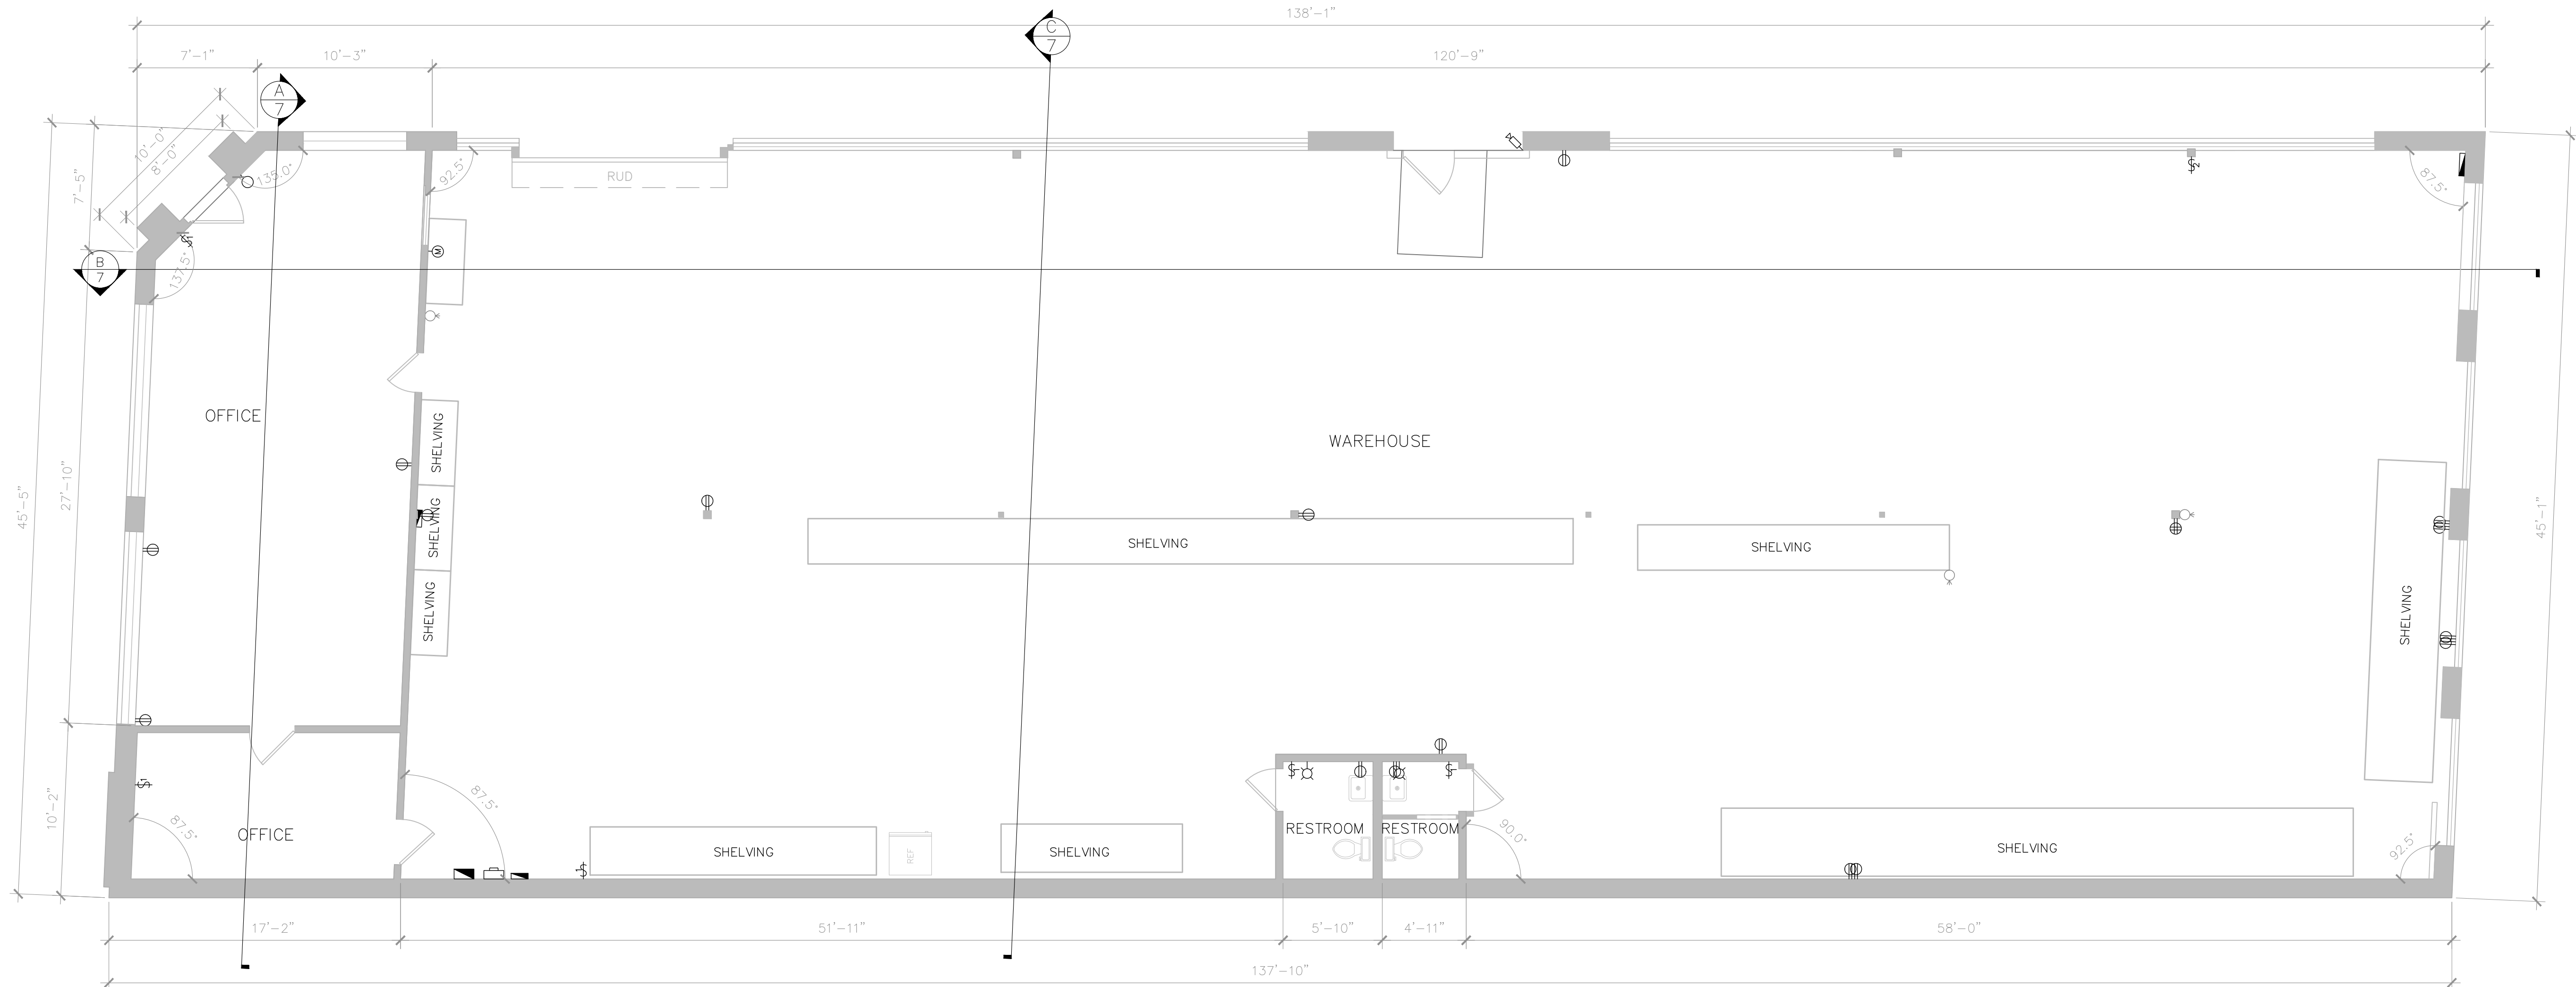

3/16"=1'-0"

NO.	REVISION	DATE
1		
2		
3		
4		

CLIENT PROJECT NO.	22368
REVIEWED BY	S.M.
FIELD DATE	1/21/2023
SCALE	3/16" = 1'-0"
SHEET	6 / 8

2266 E 38TH ST RESIDENCE
ELECTRICAL PLAN

PROJECT ADDRESS
2266 E 38TH ST
VERNON, CA 90058

PREPARED FOR
HOWARD HAMLIN
562-537-5840
HOWARD@HAMLINGOODING.COM


No plans produced by Apex As-Builtz "AAB" involve the determination of any property line, nor do they constitute a survey. They are not to be used for any purpose other than the specific purpose for which they were prepared. All plans created by Apex As-Builtz "AAB" are to be used as a guide only and should not be considered a substitute for the services of a licensed structural engineer or licensed architect.

LEGEND


- FINISHED FLOOR
FINISHED CEILING
FC FINISHED CEILING
FF FINISHED FLOOR
FG FINISHED GRADE
GFF FINISHED GRADE
TO TOP OF
GLASS/ACRYLIC
12 ROOF PITCH (RISE/RUN)




NORTH

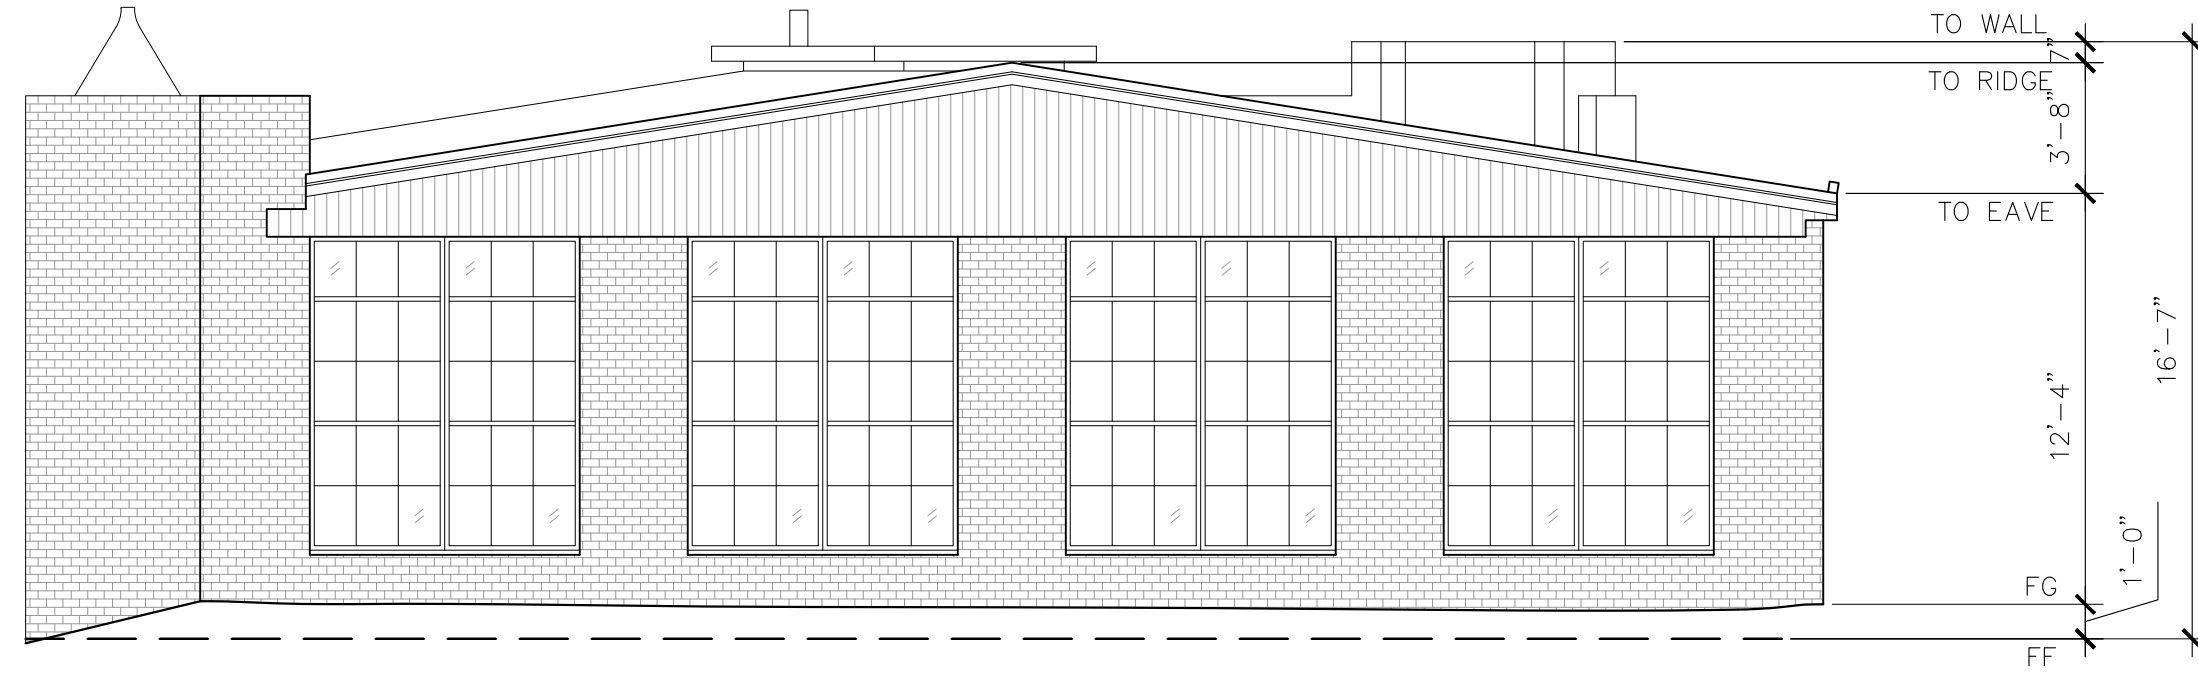


SOUTH

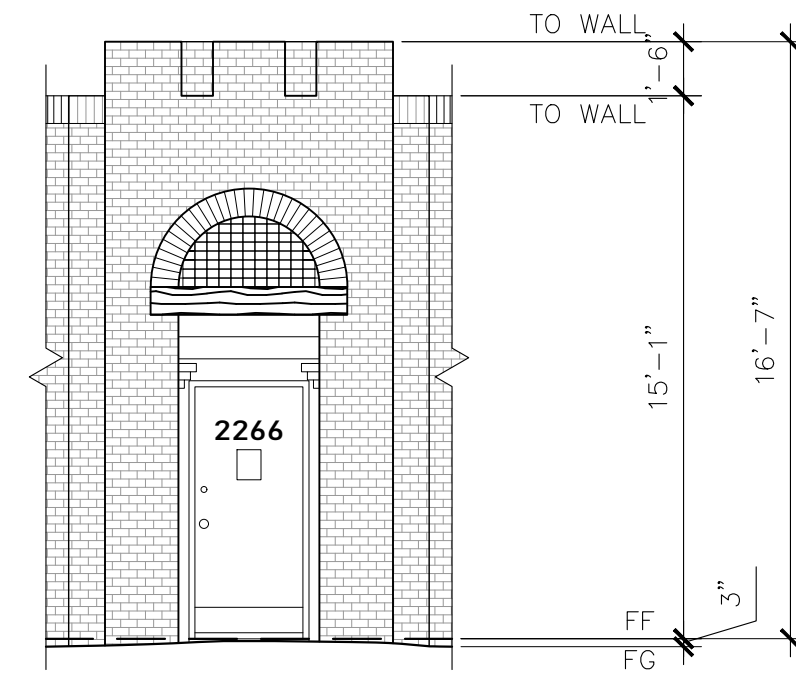

NORTHEAST

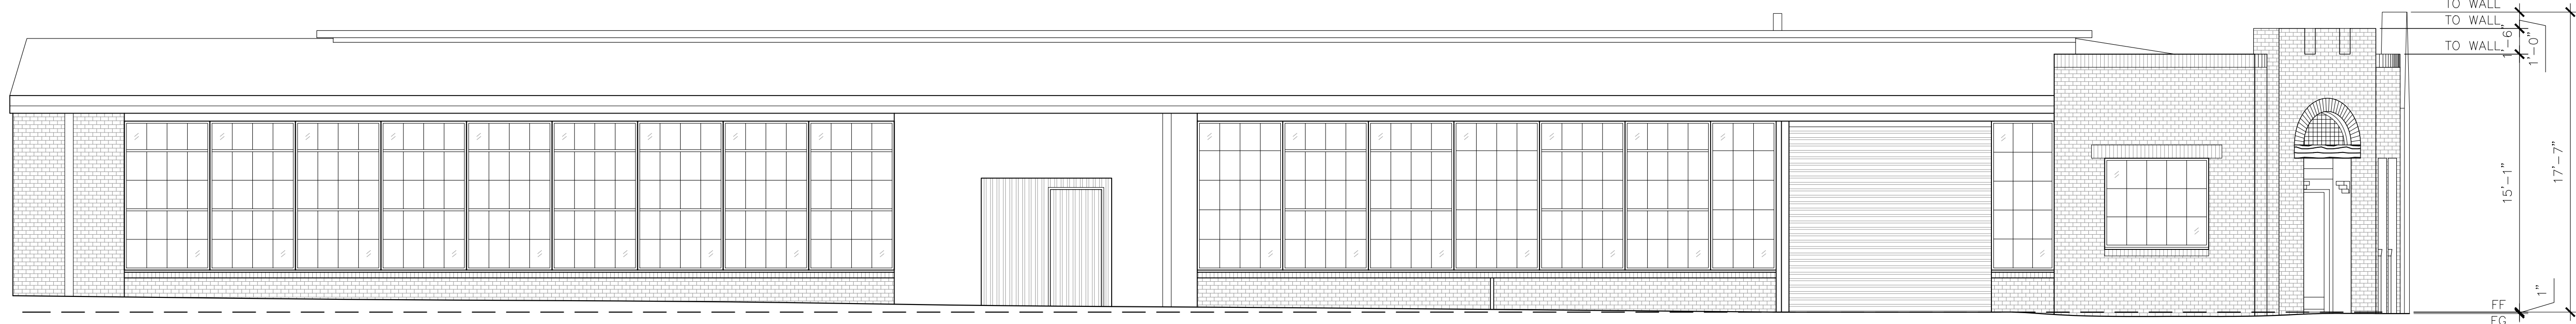

EAST

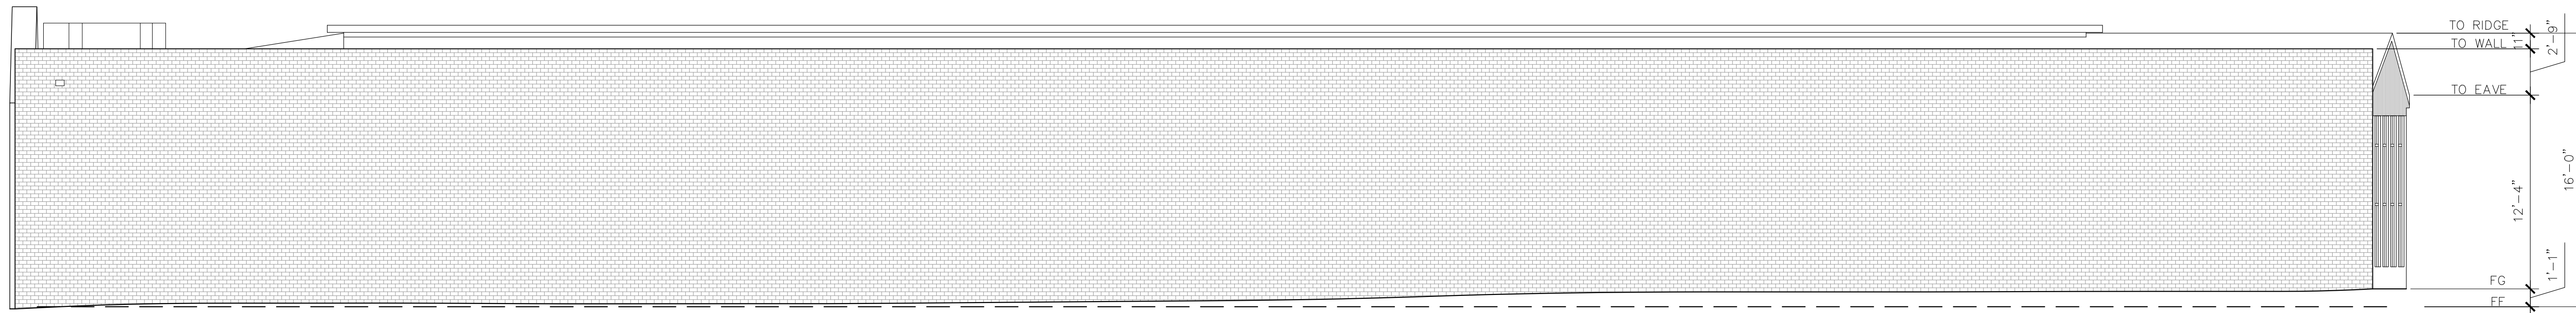

WEST

NO.	REVISION	DATE
1		
2		
3		
4		




CLIENT PROJECT NO.	22368
REVIEWED BY	S.M.
FIELD DATE	1/21/2023
SCALE	3/16" = 1'-0"
SHEET	7 / 8

2266 E 38TH ST RESIDENCE
EXTERIOR ELEVATIONS

PROJECT ADDRESS
2266 E 38TH ST
VERNON, CA 90058

PREPARED FOR
HOWARD HAMLIN
562-537-5840
HOWARD@HAMLINGOODING.COM

No plans produced by Apex As-Builtz "AAB" involve the determination of any property line, nor do they constitute a survey. They are not to be used for any purpose other than the specific purpose for which they were prepared by Apex As-Builtz "AAB". All plans created by Apex As-Builtz "AAB" are to be used as a guide only and should not be considered a substitute for the services of a licensed structural engineer or licensed architect.

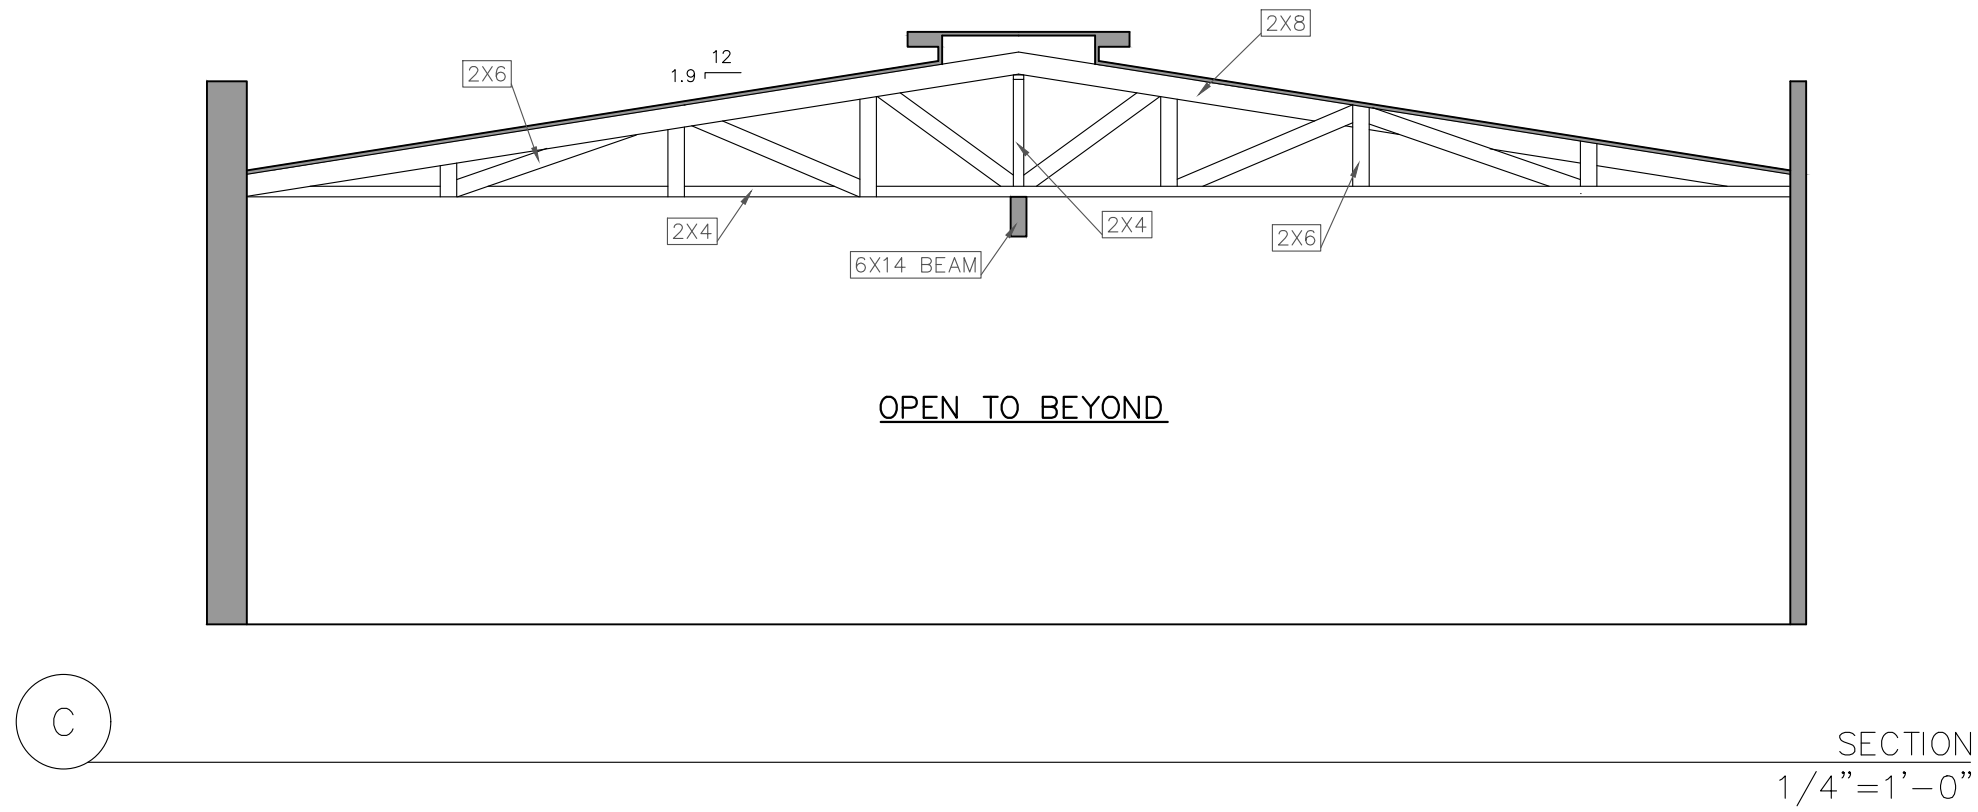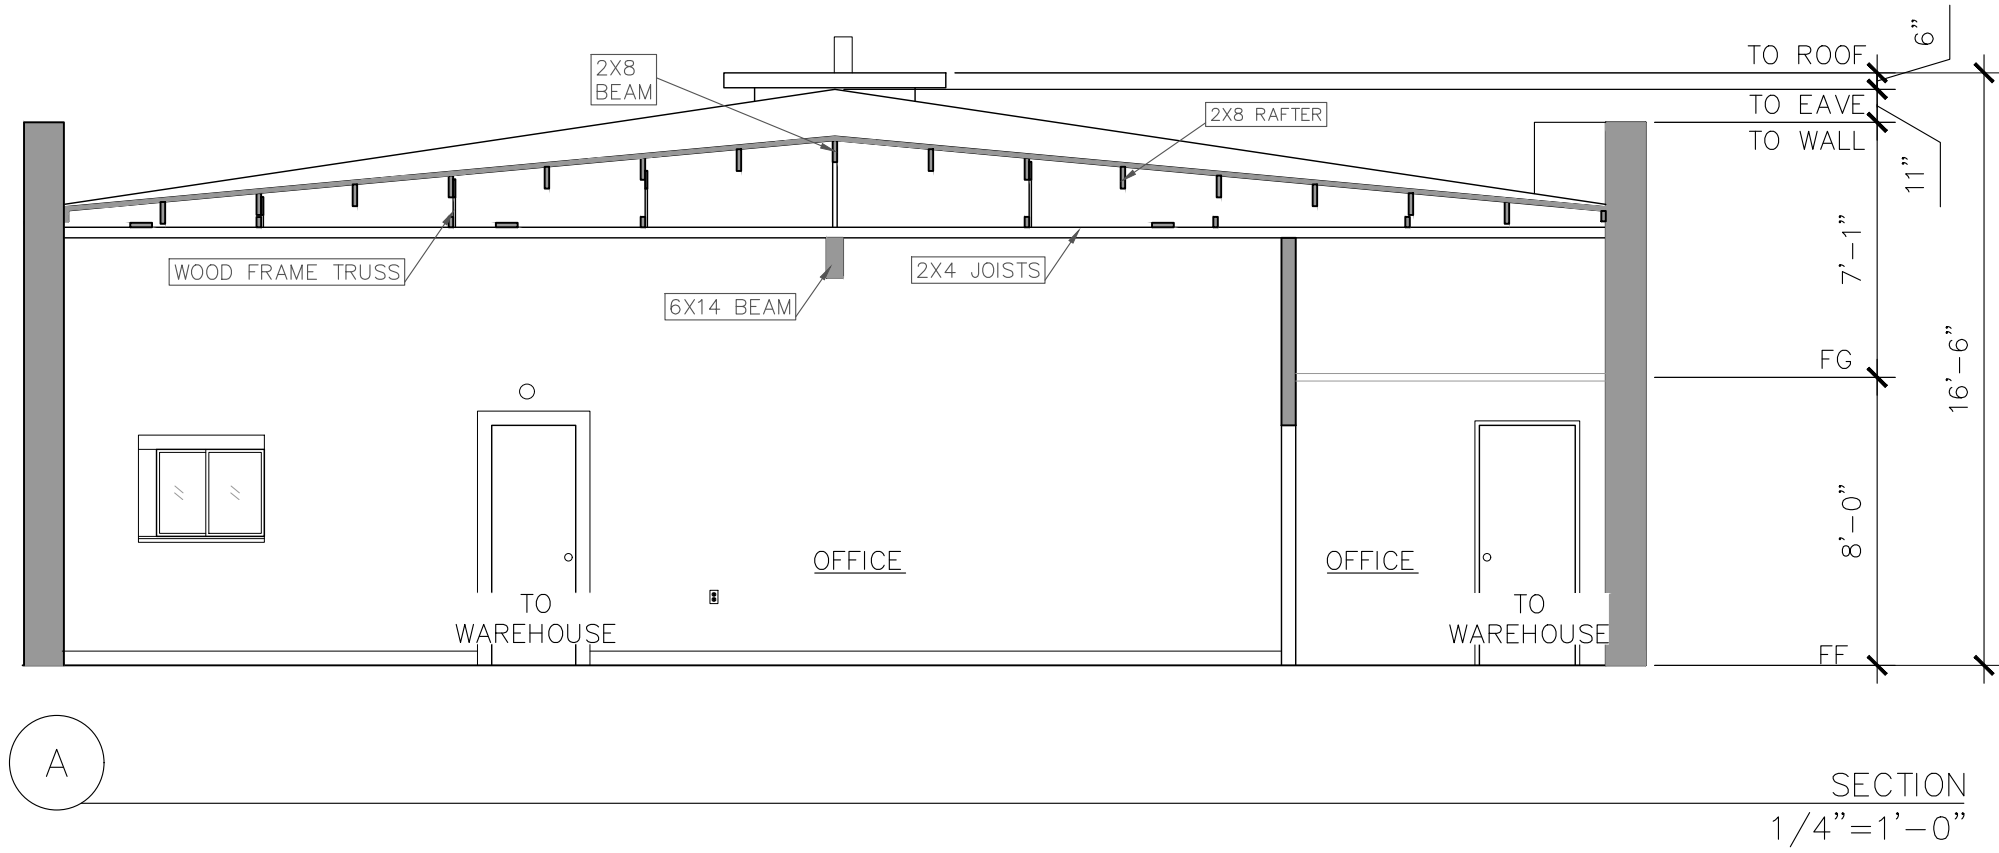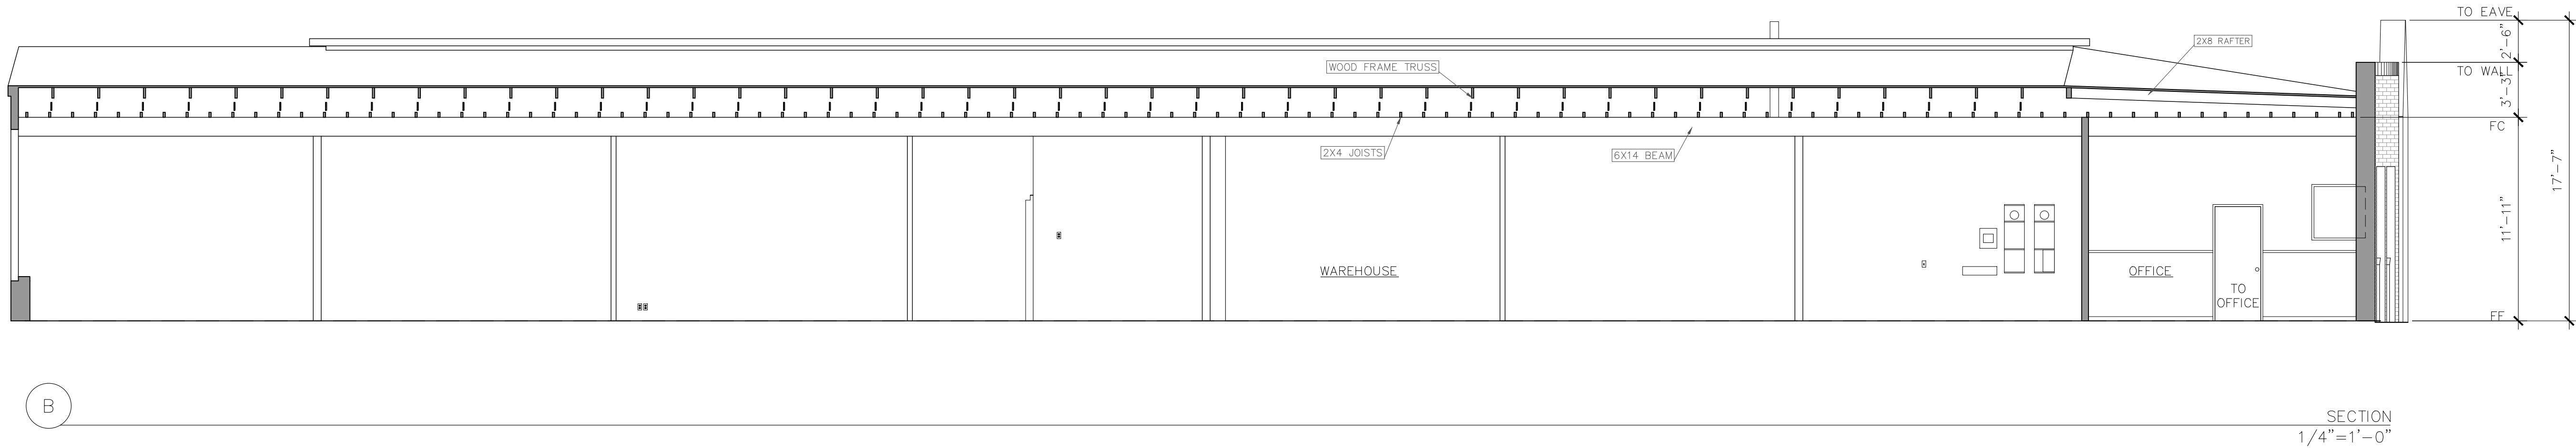

NO.	REVISION	DATE
1		
2		
3		
4		

CLIENT PROJECT NO.	22368
REVIEWED BY	S.M.
FIELD DATE	1/21/2023
SCALE	3/16" = 1'-0"
SHEET	8 / 8

2266 E 38TH ST RESIDENCE
BUILDING SECTIONS

PROJECT ADDRESS
2266 E 38TH ST
VERNON, CA 90058

PREPARED FOR
HOWARD HAMLIN
562-537-5840
HOWARD@HAMLINGOODING.COM

No plans produced by Apex As-Builtz "AAB" involve the determination of any property line, nor do they constitute a survey. They are not to be used for any purpose other than the intended purpose. All plans created by AAB are to be used as a guide only and should not be considered a substitute for the services of a licensed structural engineer or architect.