


**75 EXECUTIVE OFFICE PARK  
 BLDG. 6**  
 2525 NORTH FRAZIER  
 CONROE, TX. 77303

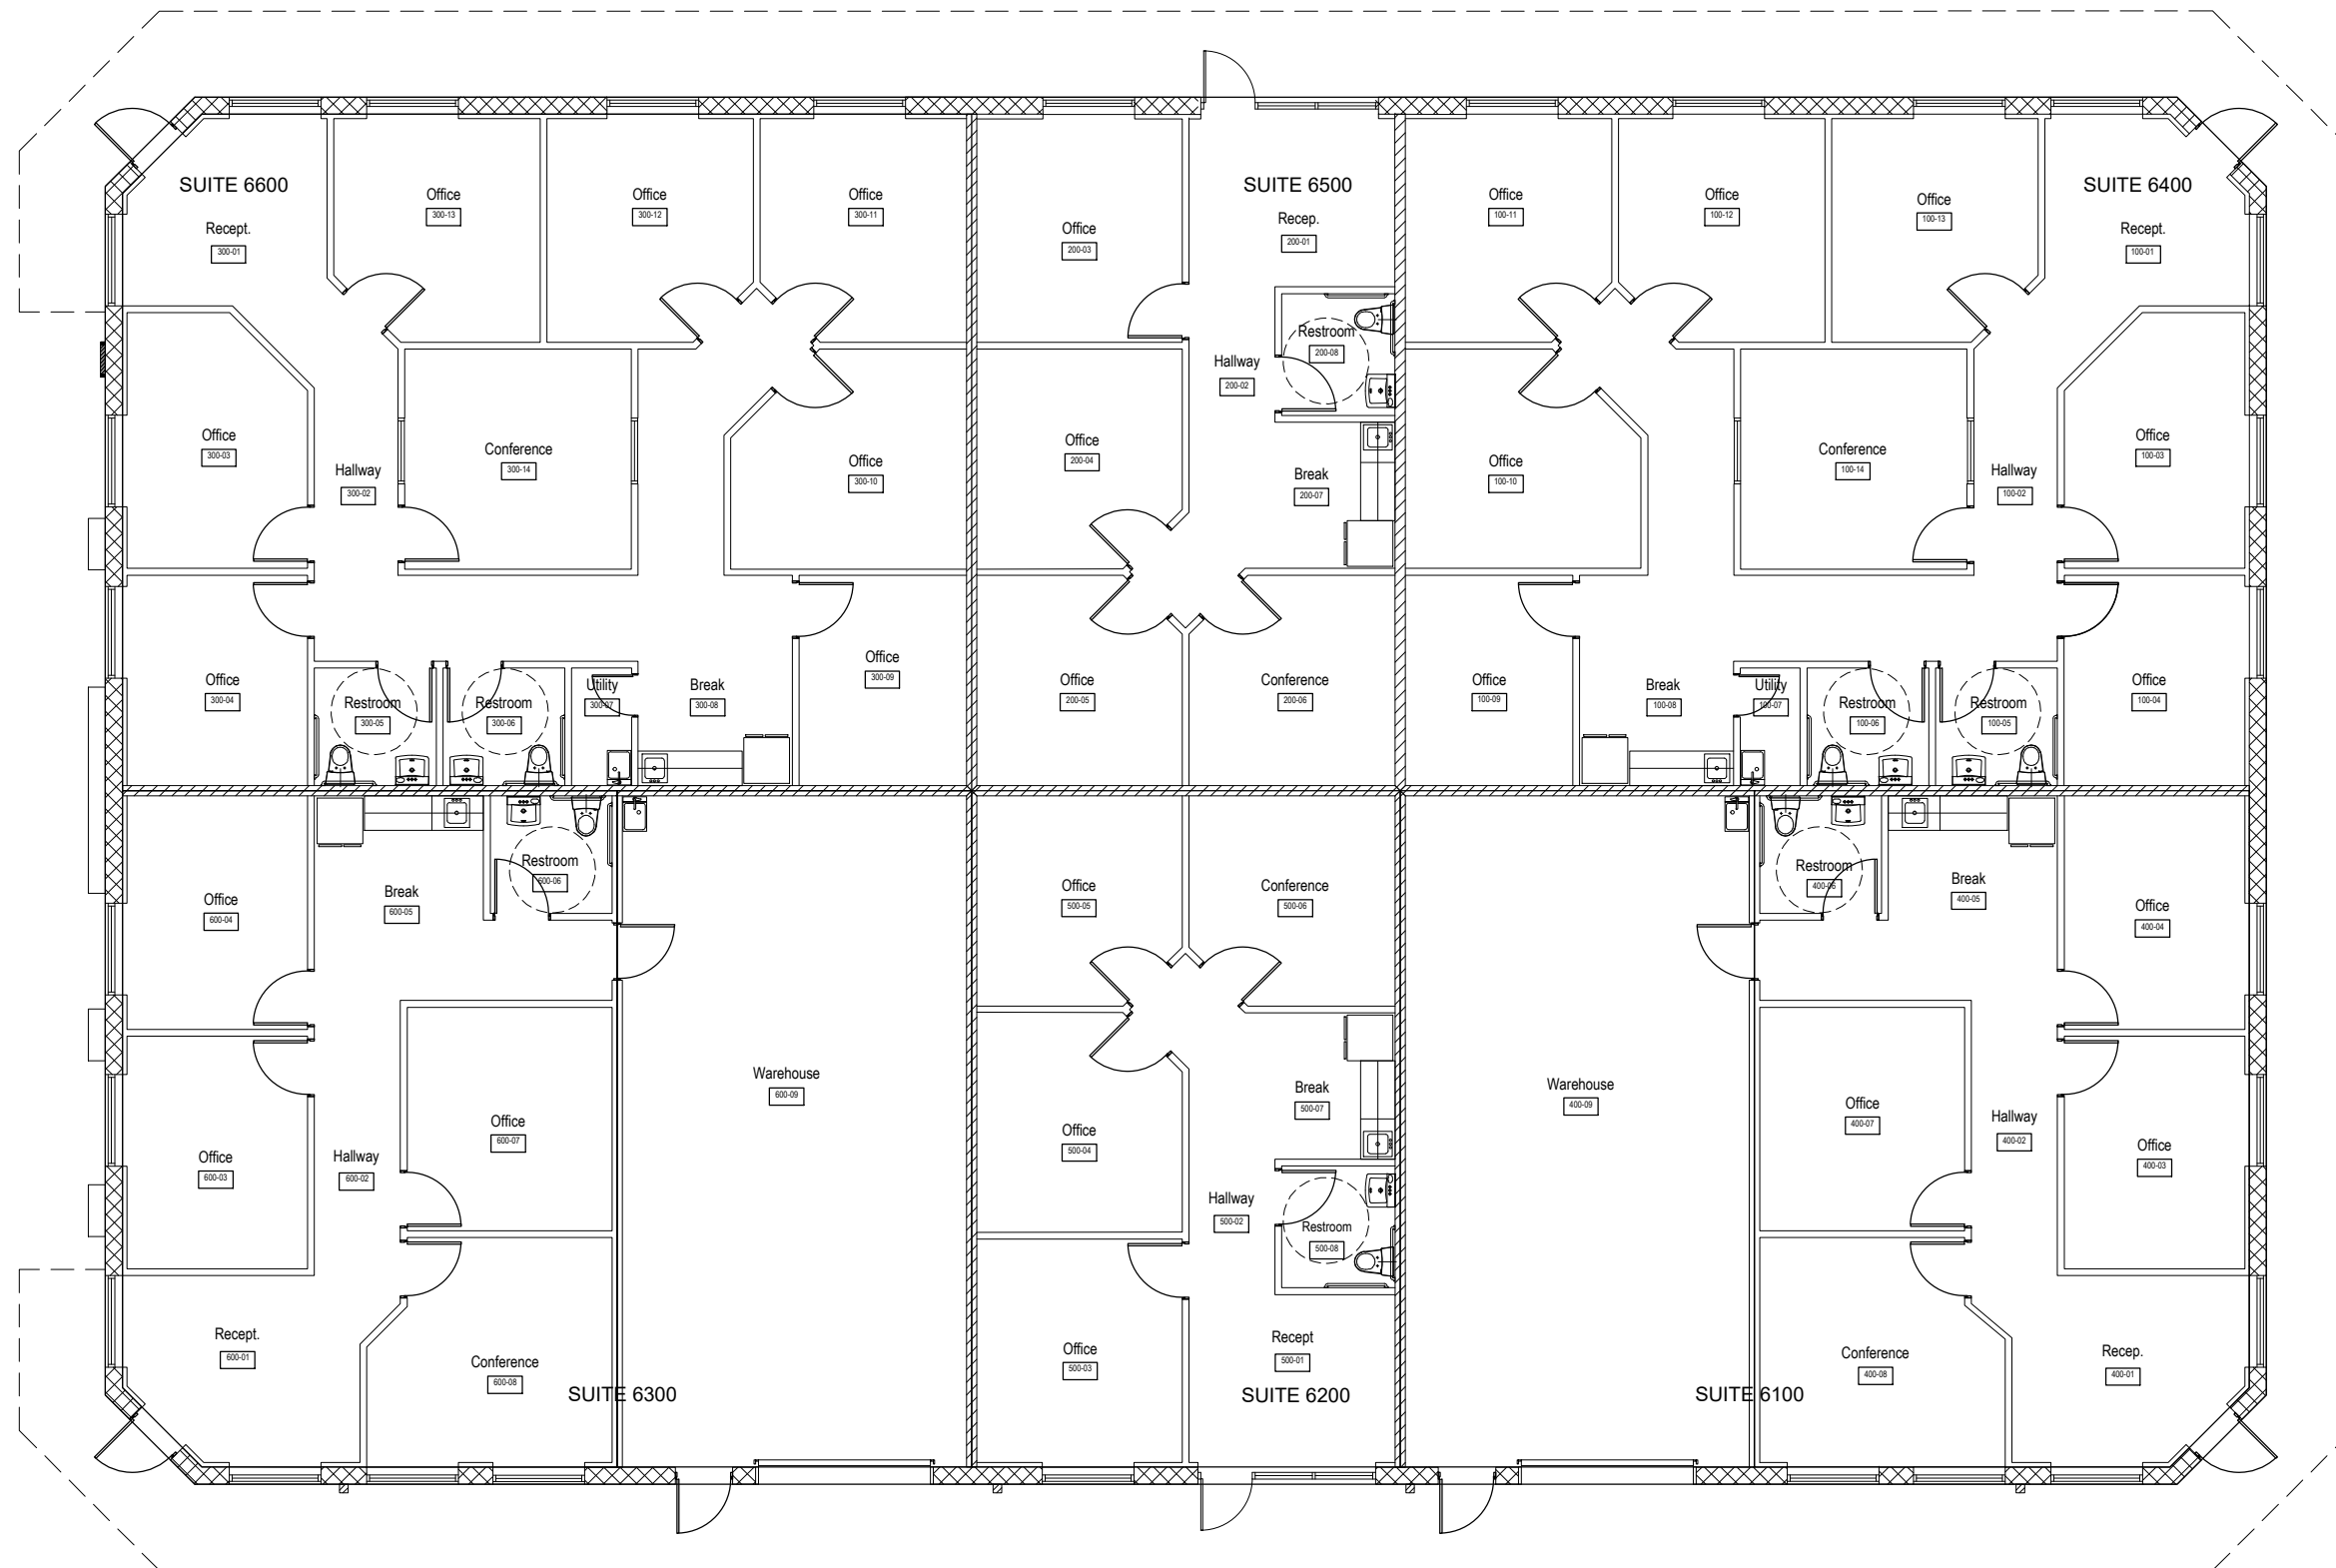

ENGINEERING BY:  
**QUEST ENGINEERING**  
 304 North Main Street #1  
 Conroe, Texas 77301  
 Phone: (713) 252-3729  
 raskowski@consolidated.net  
 Ronald A Salkowski PE LEED AP 2018  
 TEXAS REGISTRATION No. FOR ENGINEERING FIRM IS F-10574



I, RON A. SALKOWSKI, P.E., AUTHORIZED THE PLACEMENT OF THIS SEAL ON THIS DRAWING FOR THE PURPOSE OF ISSUING THIS DOCUMENT AS SPECIFIED BELOW

<input type="checkbox"/>	Not For Construction
<input type="checkbox"/>	For Background Use Only
<input type="checkbox"/>	Preliminary
<input type="checkbox"/>	For Concept Approval
<input type="checkbox"/>	Preliminary Bid Set
<input type="checkbox"/>	For Preliminary Approval
<input type="checkbox"/>	Check Set
<input checked="" type="checkbox"/>	Permit
<input checked="" type="checkbox"/>	For Final Approval
<input checked="" type="checkbox"/>	For Construction

NOTE:  
 CONSTRUCTION SHALL NOT PROCEED UNTIL CONTRACTOR HAS OBTAINED ALL PERMITS AND INCORPORATED COMMENTS FROM TEXAS ACCESSIBILITY STANDARDS REVIEW AND PERMITTING ENTITIES IN WORK.

REVISIONS		
NO.	ISSUE	DATE
0	ISSUE FOR CONSTRUCTION	11/25/2019
1	ISSUE FOR CONSTRUCTION	01/12/2020

DRAWING TITLE:

**FLOOR PLAN**

SCALE: 3/16" = 1'-0"      DATE: 10/15/2019

SHEET #:

**A-1.2**

PROJECT NUMBER:  
 2019178

NOTES:

- PROVIDE HORIZONTAL WALL BRACING FOR UPPER CABINETS AND HC RAILS. (TYP)
- ● FE FIRE EXTINGUISHER PER CITY REQUIREMENTS

