


**EMERGENCY LIGHTING LEGEND**

 ILLUMINATED EXIT SIGN/EMERGENCY LIGHT

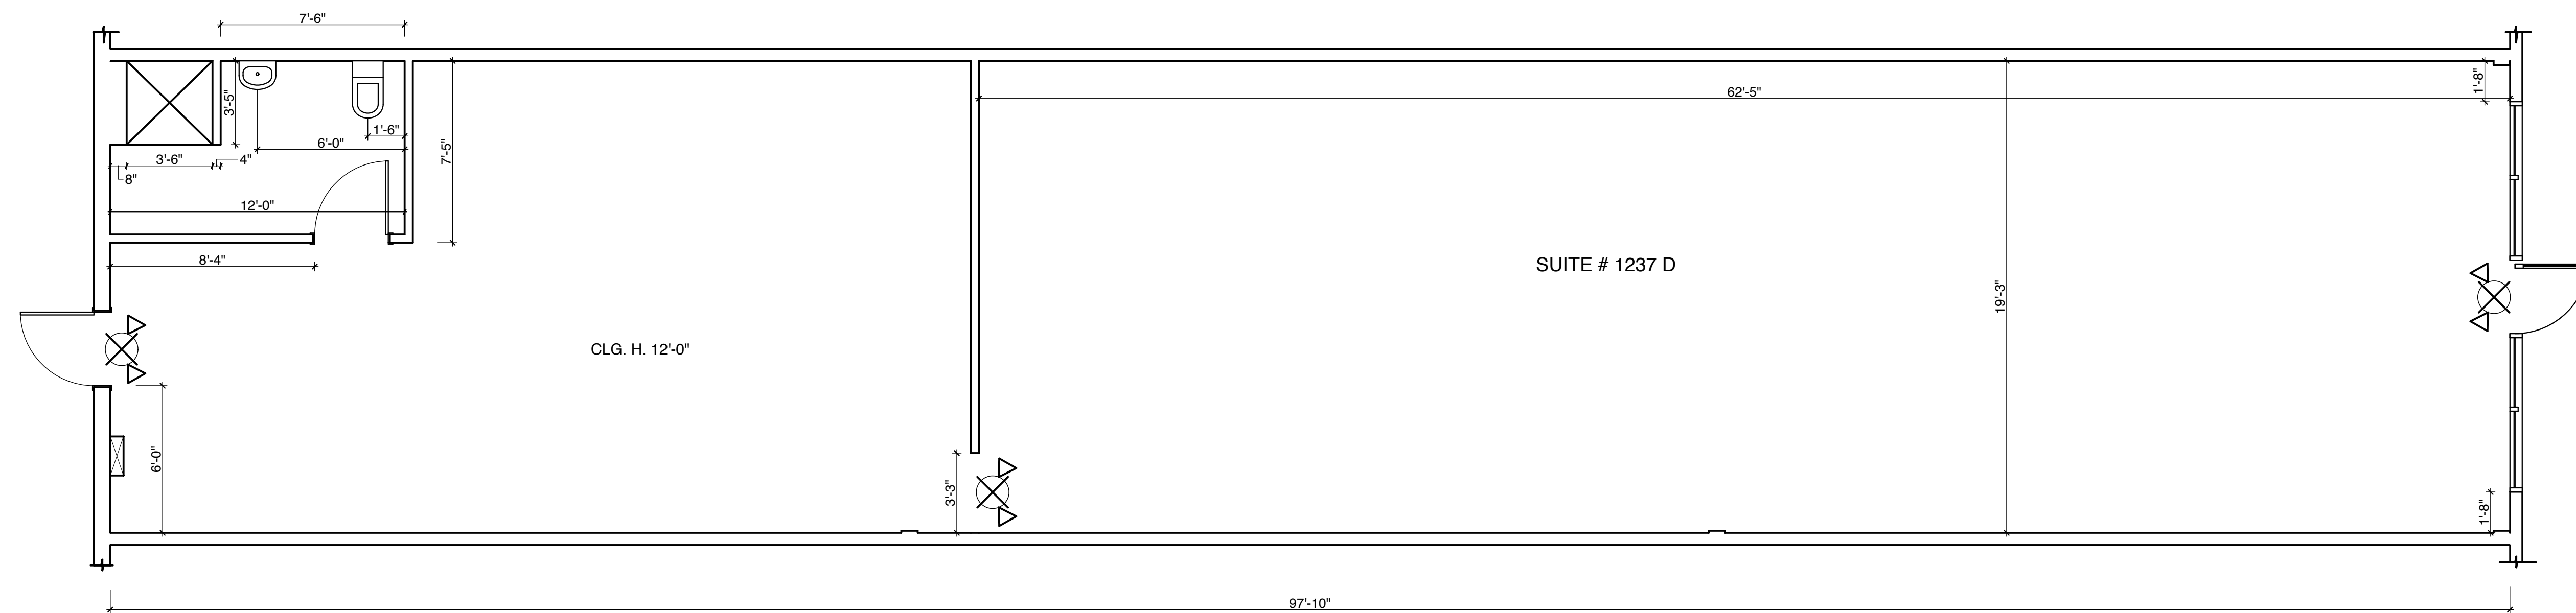

**1**  
**A-1** FLOOR PLAN  
SCALE: 1/4" = 1'-0"

**MELTON**  
ARCHITECTS  
Architecture • Land Planning • Space Planning  
208 N. LINCOLN ST., SUITE 200, KENNETT SQUARE, PENNSYLVANIA 19348 • 610-444-8538 • FAX 610-444-8537  
P.O. BOX 686, WILMINGTON, DELAWARE • 302-655-2088 • www.meltonarchitects.com

**CENTER POINT PLAZA 1**  
1201-1299 CHURCHMANS ROAD  
SUITE 1237 D  
NEWARK, DE 19713

Job No. 19-06-05  
Checked MA  
Drawn CC  
Date 6/10/19  
Revised

EXISTING FLOOR  
PLAN

Sheet of  
**A-1**

**PRELIMINARY**