

FURNITURE SPECIFICATIONS

NO.	QTY.	EQUIPMENT CATEGORY	MANUFACTURER	MODEL NUMBER	TRD. NO.	NET PRICE
1	1	TOP BOOTH	OVERSEAS CONCERNS	SIZE 95" PLAN	D101	MAN CHAIRBOARD WITH 2" SEAT
2	1	TOP BOOTH	OVERSEAS CONCERNS	SIZE 95" PLAN	D102	ADDITIONAL CHAIRBOARD
3	1	TOP BOOTH	OVERSEAS CONCERNS	SIZE 95" PLAN	D103	PRESTANDARD PLATE CHAIRBOARD
4	1	TOP BOOTH	OVERSEAS CONCERNS	SIZE 95" PLAN	D104	LANDSCAPE MIRROR - RIGHT
5	1	TOP BOOTH	OVERSEAS CONCERNS	SIZE 95" PLAN	D105	LANDSCAPE MIRROR - LEFT
6	1	TOP BOOTH	OVERSEAS CONCERNS	SIZE 95" PLAN	D106	PORTFOLIUM MIRROR
7	1	TOP BOOTH	OVERSEAS CONCERNS	SIZE 95" PLAN	D107	PORTFOLIUM MIRROR
8	1	TOP BOOTH	OVERSEAS CONCERNS	SIZE 95" PLAN	D108	FORM AND MATE
9	1	TOP BOOTH	OVERSEAS CONCERNS	SIZE 95" PLAN	D109	SCISSOR
10	1	TOP BOOTH	OVERSEAS CONCERNS	SIZE 95" PLAN	D110	SCISSOR
11	1	TOP BOOTH	OVERSEAS CONCERNS	SIZE 95" PLAN	D111	SCISSOR
12	1	TOP BOOTH	OVERSEAS CONCERNS	SIZE 95" PLAN	D112	SCISSOR
13	1	TOP BOOTH	OVERSEAS CONCERNS	SIZE 95" PLAN	D113	SCISSOR
14	1	TOP BOOTH	OVERSEAS CONCERNS	SIZE 95" PLAN	D114	SCISSOR
15	1	TOP BOOTH	OVERSEAS CONCERNS	SIZE 95" PLAN	D115	SCISSOR
16	1	TOP BOOTH	OVERSEAS CONCERNS	SIZE 95" PLAN	D116	SCISSOR
17	1	TOP BOOTH	OVERSEAS CONCERNS	SIZE 95" PLAN	D117	SCISSOR
18	1	TOP BOOTH	OVERSEAS CONCERNS	SIZE 95" PLAN	D118	SCISSOR
19	1	TOP BOOTH	OVERSEAS CONCERNS	SIZE 95" PLAN	D119	SCISSOR
20	1	TOP BOOTH	OVERSEAS CONCERNS	SIZE 95" PLAN	D120	SCISSOR
21	1	TOP BOOTH	OVERSEAS CONCERNS	SIZE 95" PLAN	D121	SCISSOR
22	1	TOP BOOTH	OVERSEAS CONCERNS	SIZE 95" PLAN	D122	SCISSOR
23	1	TOP BOOTH	OVERSEAS CONCERNS	SIZE 95" PLAN	D123	SCISSOR
24	1	TOP BOOTH	OVERSEAS CONCERNS	SIZE 95" PLAN	D124	SCISSOR
25	1	TOP BOOTH	OVERSEAS CONCERNS	SIZE 95" PLAN	D125	SCISSOR
26	1	TOP BOOTH	OVERSEAS CONCERNS	SIZE 95" PLAN	D126	SCISSOR
27	1	TOP BOOTH	OVERSEAS CONCERNS	SIZE 95" PLAN	D127	SCISSOR
28	1	TOP BOOTH	OVERSEAS CONCERNS	SIZE 95" PLAN	D128	SCISSOR
29	1	TOP BOOTH	OVERSEAS CONCERNS	SIZE 95" PLAN	D129	SCISSOR
30	1	TOP BOOTH	OVERSEAS CONCERNS	SIZE 95" PLAN	D130	SCISSOR
31	1	TOP BOOTH	OVERSEAS CONCERNS	SIZE 95" PLAN	D131	SCISSOR
32	1	TOP BOOTH	OVERSEAS CONCERNS	SIZE 95" PLAN	D132	SCISSOR
33	1	TOP BOOTH	OVERSEAS CONCERNS	SIZE 95" PLAN	D133	SCISSOR
34	1	TOP BOOTH	OVERSEAS CONCERNS	SIZE 95" PLAN	D134	SCISSOR
35	1	TOP BOOTH	OVERSEAS CONCERNS	SIZE 95" PLAN	D135	SCISSOR
36	1	TOP BOOTH	OVERSEAS CONCERNS	SIZE 95" PLAN	D136	SCISSOR
37	1	TOP BOOTH	OVERSEAS CONCERNS	SIZE 95" PLAN	D137	SCISSOR
38	1	TOP BOOTH	OVERSEAS CONCERNS	SIZE 95" PLAN	D138	SCISSOR
39	1	TOP BOOTH	OVERSEAS CONCERNS	SIZE 95" PLAN	D139	SCISSOR
40	1	TOP BOOTH	OVERSEAS CONCERNS	SIZE 95" PLAN	D140	SCISSOR
41	1	TOP BOOTH	OVERSEAS CONCERNS	SIZE 95" PLAN	D141	SCISSOR
42	1	TOP BOOTH	OVERSEAS CONCERNS	SIZE 95" PLAN	D142	SCISSOR
43	1	TOP BOOTH	OVERSEAS CONCERNS	SIZE 95" PLAN	D143	SCISSOR
44	1	TOP BOOTH	OVERSEAS CONCERNS	SIZE 95" PLAN	D144	SCISSOR
45	1	TOP BOOTH	OVERSEAS CONCERNS	SIZE 95" PLAN	D145	SCISSOR
46	1	TOP BOOTH	OVERSEAS CONCERNS	SIZE 95" PLAN	D146	SCISSOR
47	1	TOP BOOTH	OVERSEAS CONCERNS	SIZE 95" PLAN	D147	SCISSOR
48	1	TOP BOOTH	OVERSEAS CONCERNS	SIZE 95" PLAN	D148	SCISSOR
49	1	TOP BOOTH	OVERSEAS CONCERNS	SIZE 95" PLAN	D149	SCISSOR
50	1	TOP BOOTH	OVERSEAS CONCERNS	SIZE 95" PLAN	D150	SCISSOR

METRO DECOR PACKAGE-- See Metro Decor Catalog

TRD. NO.	NET PRICE
D101	MAN CHAIRBOARD WITH 2" SEAT
D102	ADDITIONAL CHAIRBOARD
D103	PRESTANDARD PLATE CHAIRBOARD
D104	LANDSCAPE MIRROR - RIGHT
D105	LANDSCAPE MIRROR - LEFT
D106	PORTFOLIUM MIRROR
D107	PORTFOLIUM MIRROR
D108	FORM AND MATE
D109	SCISSOR
D110	SCISSOR
D111	SCISSOR
D112	SCISSOR
D113	SCISSOR
D114	SCISSOR
D115	SCISSOR
D116	SCISSOR
D117	SCISSOR
D118	SCISSOR
D119	SCISSOR
D120	SCISSOR
D121	SCISSOR
D122	SCISSOR
D123	SCISSOR
D124	SCISSOR
D125	SCISSOR
D126	SCISSOR
D127	SCISSOR
D128	SCISSOR
D129	SCISSOR
D130	SCISSOR
D131	SCISSOR
D132	SCISSOR
D133	SCISSOR
D134	SCISSOR
D135	SCISSOR
D136	SCISSOR
D137	SCISSOR
D138	SCISSOR
D139	SCISSOR
D140	SCISSOR
D141	SCISSOR
D142	SCISSOR
D143	SCISSOR
D144	SCISSOR
D145	SCISSOR
D146	SCISSOR
D147	SCISSOR
D148	SCISSOR
D149	SCISSOR
D150	SCISSOR

METRO ORLANDO, FLORIDA


Storage LT.	Code LT.	Overall SF.	Kitchen SF.	Main Seals	Pastry Seals	Total # Tables
32	41	3800	1778	98	28	31

SEATING CALCULATIONS

DINING AREA	TABLE SEATING
2- TOP TABLES	2
4- TOP TABLES	4
6- TOP TABLES	6
8- TOP TABLES	8
10- TOP TABLES	10
12- TOP TABLES	12
14- TOP TABLES	14
16- TOP TABLES	16
18- TOP TABLES	18
20- TOP TABLES	20
22- TOP TABLES	22
24- TOP TABLES	24
26- TOP TABLES	26
28- TOP TABLES	28
30- TOP TABLES	30
32- TOP TABLES	32
34- TOP TABLES	34
36- TOP TABLES	36
38- TOP TABLES	38
40- TOP TABLES	40
42- TOP TABLES	42
44- TOP TABLES	44
46- TOP TABLES	46
48- TOP TABLES	48
50- TOP TABLES	50
52- TOP TABLES	52
54- TOP TABLES	54
56- TOP TABLES	56
58- TOP TABLES	58
60- TOP TABLES	60
62- TOP TABLES	62
64- TOP TABLES	64
66- TOP TABLES	66
68- TOP TABLES	68
70- TOP TABLES	70
72- TOP TABLES	72
74- TOP TABLES	74
76- TOP TABLES	76
78- TOP TABLES	78
80- TOP TABLES	80
82- TOP TABLES	82
84- TOP TABLES	84
86- TOP TABLES	86
88- TOP TABLES	88
90- TOP TABLES	90
92- TOP TABLES	92
94- TOP TABLES	94
96- TOP TABLES	96
98- TOP TABLES	98
100- TOP TABLES	100

FOOD SERVICE SHEET INDEX

FS-1	EQUIPMENT PLAN
FS-2	SPECIFICATION PLAN
FS-3	SPECIFICATION PLAN
FS-4	ELECTRICAL PLAN
FS-5	PLUMBING PLAN
FS-6	SPECIAL CONDITIONS
FS-7	ELEVATIONS
FS-8	ELEVATIONS
FS-9	ELEVATIONS
FS-10	ELEVATIONS
FS-11	ELEVATIONS
FS-12	ELEVATIONS
FS-13	ELEVATIONS
FS-14	ELEVATIONS
FS-15	ELEVATIONS
FS-16	ELEVATIONS
FS-17	ELEVATIONS
FS-18	ELEVATIONS
FS-19	ELEVATIONS
FS-20	ELEVATIONS
FS-21	ELEVATIONS
FS-22	ELEVATIONS
FS-23	ELEVATIONS
FS-24	ELEVATIONS
FS-25	ELEVATIONS
FS-26	ELEVATIONS
FS-27	ELEVATIONS
FS-28	ELEVATIONS
FS-29	ELEVATIONS
FS-30	ELEVATIONS
FS-31	ELEVATIONS
FS-32	ELEVATIONS
FS-33	ELEVATIONS
FS-34	ELEVATIONS
FS-35	ELEVATIONS
FS-36	ELEVATIONS
FS-37	ELEVATIONS
FS-38	ELEVATIONS
FS-39	ELEVATIONS
FS-40	ELEVATIONS
FS-41	ELEVATIONS
FS-42	ELEVATIONS
FS-43	ELEVATIONS
FS-44	ELEVATIONS
FS-45	ELEVATIONS
FS-46	ELEVATIONS
FS-47	ELEVATIONS
FS-48	ELEVATIONS
FS-49	ELEVATIONS
FS-50	ELEVATIONS

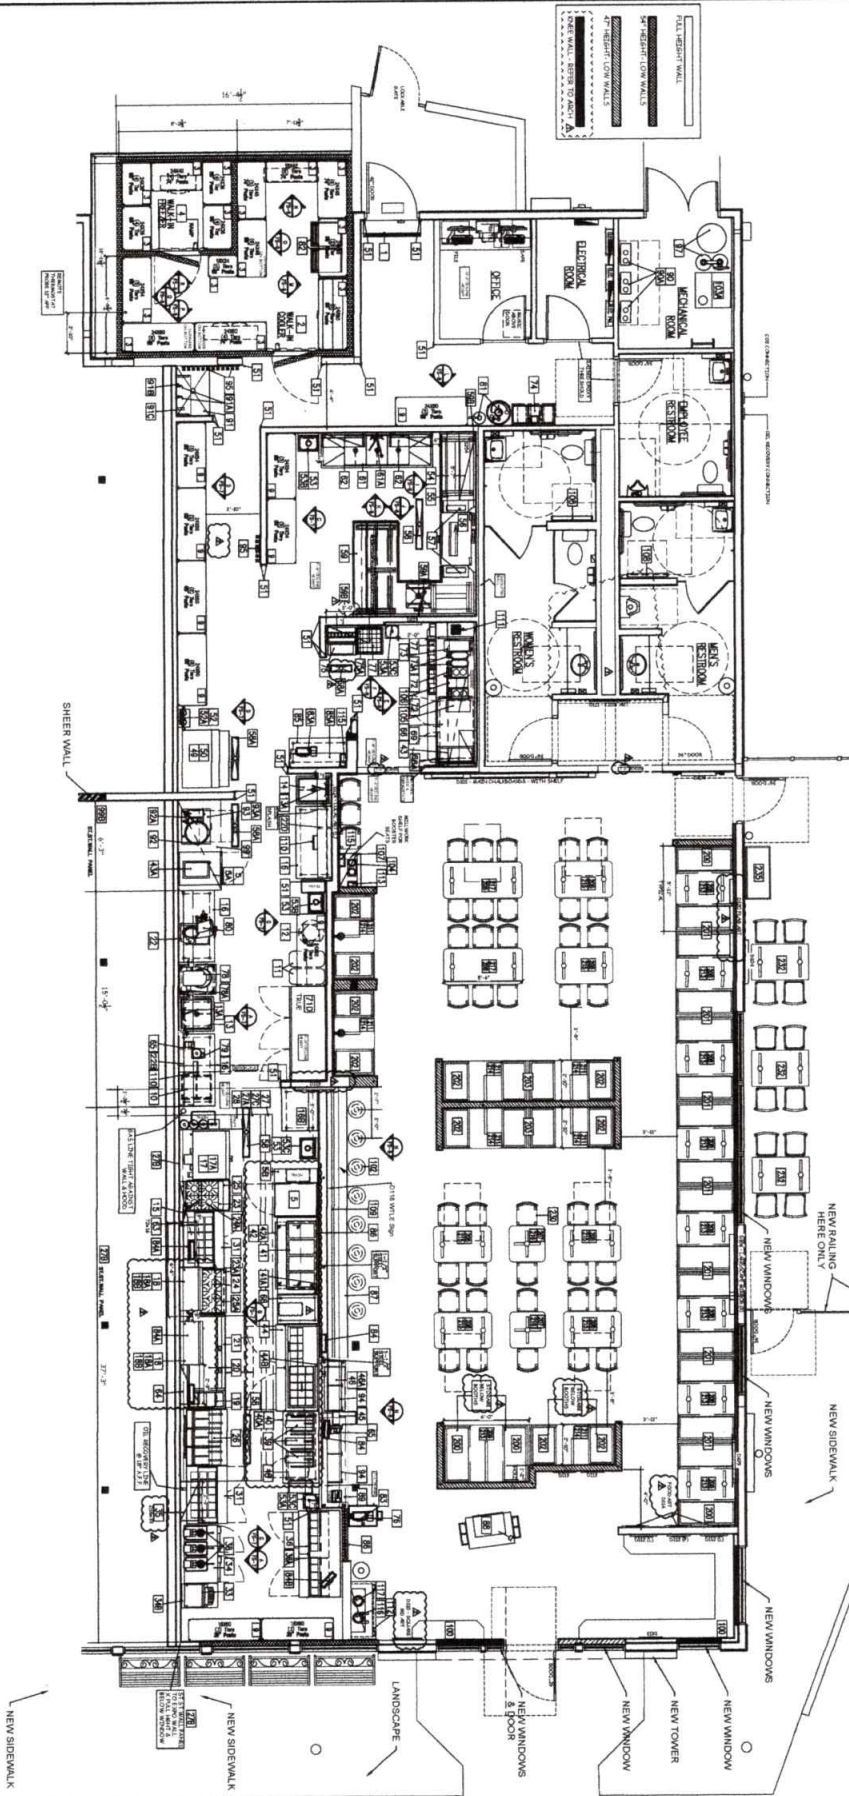

REVISIONS

NO.	DATE	DESCRIPTION
0.221	CLM-REVISED AS NOTED	
0.241	CLM-REVISED AS NOTED	

METRO DINER
ORLANDO, FLORIDA

FOODSERVICE EQUIPMENT PLAN



TriMark
Foodservice Equipment, Supplies and Design

STRATEGIC

1747 DANHAVEN DRIVE
MARIETTA, GA 30067
770-422-8116

SCALE: 1/4" = 1'-0"
DATE DRAWN: 8-12-17
PROJECT NO: METRO ORLANDO

SHEET NUMBER: FS-1

NOT TO SCALE: 1/4" = 1'-0"